


GENERAL NOTES:

1. ALL CIRCUITS SHALL CARRY A GREEN GROUND CONDUCTOR.
2. ALL EMERGENCY, EXIT LIGHTS, ETC. SHALL BE CIRCUITED WITH A SEPARATE UNSWITCHED HOT CONDUCTOR. CIRCUIT SHALL ORIGINATE AT PANELBOARD.

SHEET NOTES:

1. EXTEND AND CONNECT CIRCUITING FROM JUNCTION BOX TO LIGHTING FIXTURES/RECEPTACLES IN AREA WITH SAME CIRCUIT NUMBERS, ROUTE #0 CONDUCTORS (MINIMUM) THROUGHOUT, UNLESS NOTED OTHERWISE.
2. 3 SPEED FAN CONTROLLER - FURNISHED WITH FAN.
3. PROVIDE ALL REQUIRED SUPPORT(S) TO STRUCTURE FOR CEILING FAN. COORDINATE WITH STRUCTURAL ENGINEER AND STRUCTURAL CONTRACTOR.
4. MOUNT LIGHT FIXTURE AT 13'-0" AFS. TO CENTER OF LIGHT FIXTURE. COORDINATE ROUGH-IN LOCATION WITH ARCHITECT PRIOR TO START OF WORK.
5. MOUNT LIGHT FIXTURE 6" ABOVE DOOR HEADER TO BOTTOM OF LIGHT FIXTURE.
6. PENDANT MOUNT LIGHT FIXTURE AT 9'-0" AFF TO BOTTOM OF HOUSING. PROVIDE ALL REQUIRED SUPPORTS, ETC. TO ALLOW FOR PENDANTS TO BE INSTALLED AT LOCATIONS CONFIRMED BY THE ARCHITECT.
7. THIS ROOM HAS EXPOSED STRUCTURE (NO CEILING) ALL INSTALLATIONS SHALL BE INSTALLED TIGHT TO BOTTOM OF TRUSSES. COORDINATE WITH GENERAL CONTRACTOR FOR PAINTING OF INSTALLED MATERIALS.
8. CHAIN HANG LIGHT FIXTURE AT 10'-0" AFF. PROVIDE ALL REQUIRED SUPPORTS, ETC. TO ALLOW FOR CHAINS TO CLEAR DUCTWORK, ETC. CONFIRM MOUNTING HEIGHT WITH ARCHITECT.
9. PROVIDE MASTER/SLAVE BALLAST CONFIGURATION FOR a/b SWITCHING. MASTER (M) FIXTURE BALLAST SHALL CONTROL SWITCHES a LAMP IN EACH FIXTURE AND SLAVE (S) FIXTURE BALLAST SHALL CONTROL SWITCHES b IN EACH FIXTURE. INDEPENDANT (I) LIGHT FIXTURE SHALL CONTAIN 2 BALLASTS IN ORDER TO MAINTAIN a/b SWITCHING.
10. PROVIDE DUAL TECHNOLOGY MOTION SENSOR EQUAL TO LEVITON ODSB.
11. PROVIDE KEY SWITCH IN RESTROOMS.
12. COORDINATE ROUGH-IN LOCATION FOR PENDANT LIGHT WITH ARCHITECT.
13. MOUNT BOTTOM OF LIGHT FIXTURE AT 25'-0" AFF TO BOTTOM OF LIGHT FIXTURE. VERIFY HEIGHT WITH ARCHITECT AND OWNER.
14. MOUNT AT 1'-6" ABOVE STAIR LANDING OR STAIR RISER.

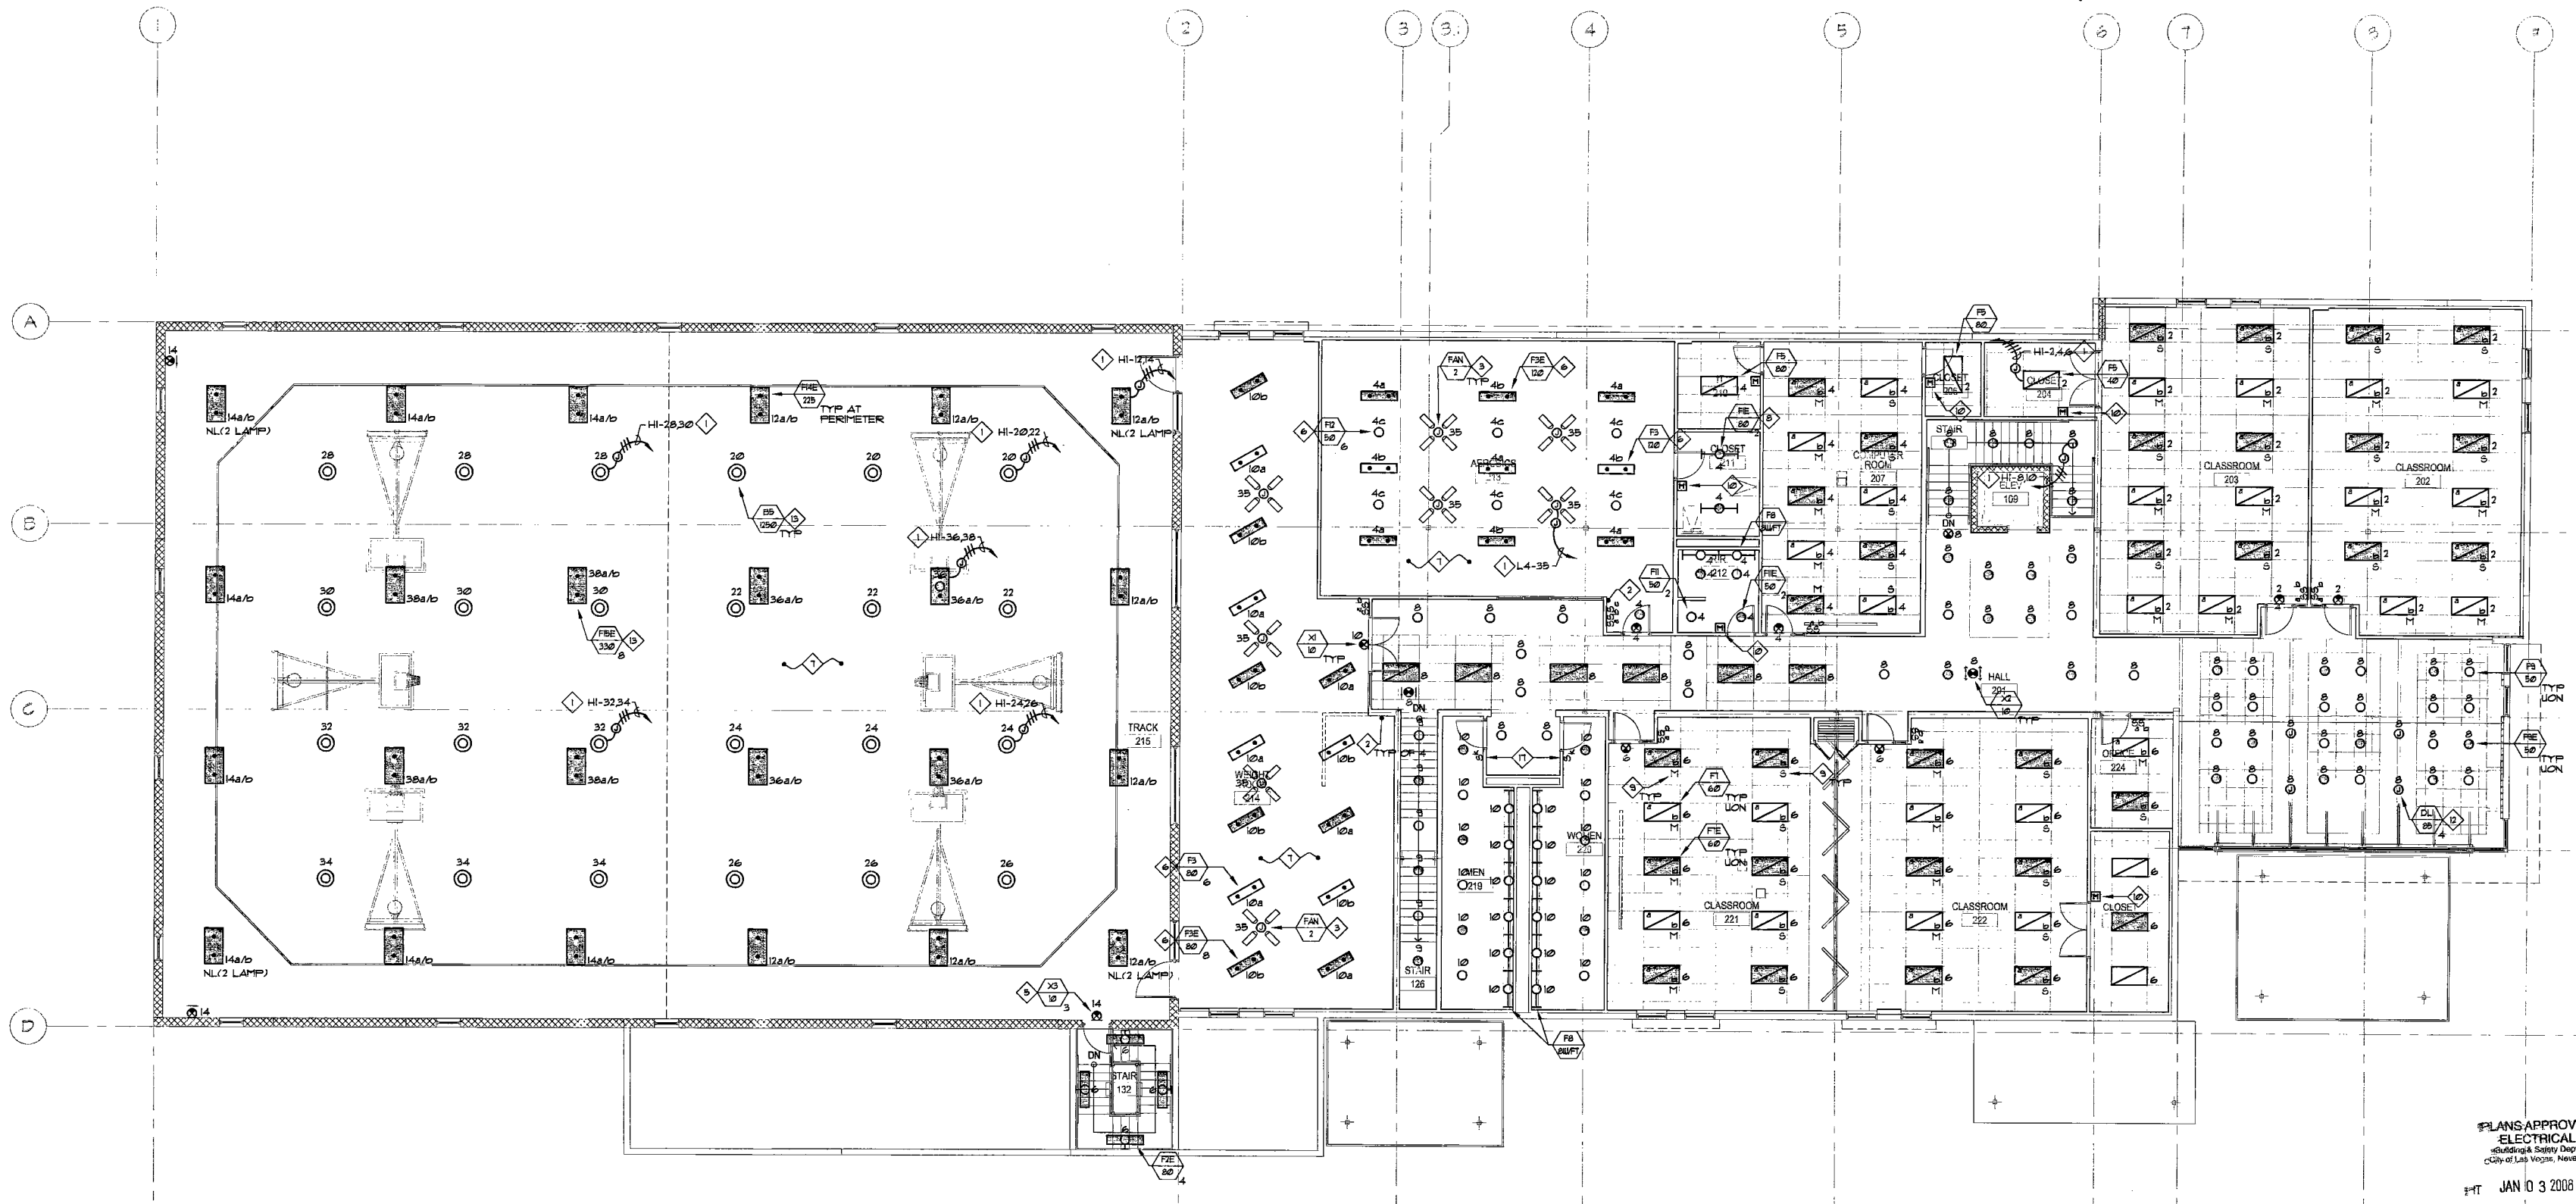

SECOND FLOOR LIGHTING PLAN
1/8" = 1'-0"



PLANS APPROVED
ELECTRICAL
City of Las Vegas, Nevada


JAN 03 2008

Stamp Not Include Structural, Architectural, Plumbing/Mechanical or Civil/Other
Supplemental Make No Change
Without Approval Plan is
not a Permit to Violate Any Ordinance

MSA # L06954



STUPAK COMMUNITY CENTER
250 WEST BOSTON AVENUE
LAS VEGAS, NEVADA 89102
SECOND FLOOR
LIGHTING PLAN

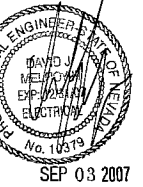

OWNER: CITY OF LAS VEGAS
DEPARTMENT OF PUBLIC WORKS
ARCHITECTURAL SERVICES

400 EAST STEWART AVENUE
LAS VEGAS, NEVADA 89103
PHONE: (702) 226-6535
FAX: (702) 384-4846
T: (702) 384-9108

DATE: 09/03/07
SCALE: AS NOTED
DRAWING NO: 06.15341.25
REVISED: 650.39-2

E512