


LEGEND

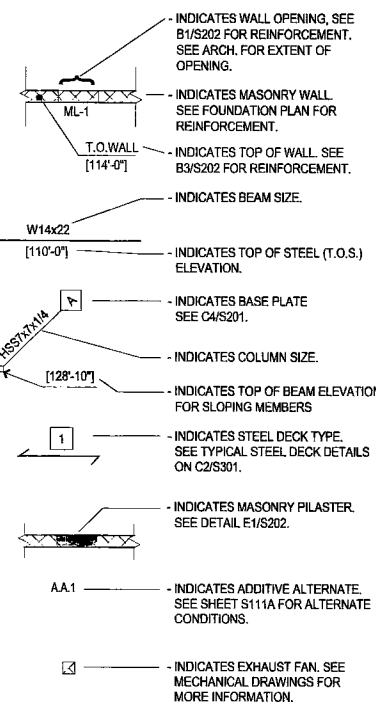


GENERAL NOTES

- A) SEE SHEET S301 AND S302 FOR TYPICAL SCHEDULES AND DETAILS.
- B) DATUM FOR ALL ELEVATIONS IS TOP OF GROUND FLOOR SLAB-ON-GRADE - REFERENCE ELEVATION 100'-0".
- C) JOIST BRIDGING IS SHOWN SCHEMATICALLY. CONTRACTOR SHALL PROVIDE AND INSTALL BRIDGING REQUIRED BY SJA AS WELL AS ADDITIONAL ERECTION BRIDGING IF REQUIRED FOR STABILITY.
- D) FOR CONDENSER PLATFORM - SEE DETAILS A5/S301 AND B5/S301.
- E) COORDINATE WITH ARCHITECTURAL DRAWINGS FOR ADDITIONAL INFORMATION.


KEY NOTES

- 1 HORIZONTAL BRIDGING: IN ACCORDANCE WITH THE LATEST EDITION OF SJA STANDARD SPECIFICATION EQUALLY SPACED ACROSS SPAN AS SHOWN.
- 2 1,000# BASKETBALL HOOP ASSEMBLY. JOIST MANUFACTURER TO INCLUDE WEIGHT IN JOIST DESIGN. CONTRACTOR SHALL SUBMIT DESIGN AND DETAILS OF SUPPORT AS A DEFERRED SUBMITTAL.
- 3 SKYLIGHT - SEE C3/S301 FOR OPENING SUPPORT.
- 4 ROOF HATCH OPENING. SEE C3/S301 FOR OPENING SUPPORT.
- 5 ROOF MOUNTED MECHANICAL UNIT. ALLOWABLE WEIGHTS AS NOTED WITH OPENINGS. SEE MECHANICAL PLAN FOR ADDITIONAL INFORMATION. SEE A3/S302 FOR ATTACHMENT.
- 6 HANGING PARTITION BELOW. SEE B6/S122 FOR SUPPORT FRAMING BELOW TRUSS.

- 7 L4x4x1/4 BETWEEN JOIST WELDED TO TOP CHORD SUPPORT CEILING FAN BELOW.
- 8 ROOF DRAIN INLET. SEE ARCH AND MEP DRAWINGS FOR ADDITIONAL INFORMATION.
- 9 GYM DIVIDER CURTAIN. CONTRACTOR SHALL SUBMIT DESIGN AND DETAILS OF SUPPORT AS DEFERRED SUBMITTAL. JOIST MANUFACTURER TO INCLUDE WEIGHT OF CURTAIN IN JOIST GIRDER DESIGN.
- 10 HSS4x4x3/16 BRACE AT EACH HSS10x5 BEAM. SEE DETAIL E5/S302.
- 11 SEE E2/S202 FOR DOUBLE ANGLE LINTEL AT MECHANICAL OPENING. COORDINATE OPENING LOCATION WITH MECHANICAL DRAWINGS.
- 12 RECESSED PROJECTION SCREEN (BELOW). REFER TO ARCHITECTURAL DRAWINGS FOR LOCATION. SEE A6/S303 FOR SUPPORT.
- 13 SUSPENDED PROJECTOR (BELOW). REFER TO ARCHITECTURAL DRAWINGS FOR LOCATION.
- 14 ROOF OPENING FOR MECHANICAL FAN. SEE MECHANICAL DRAWINGS FOR EXACT LOCATION. SEE DETAIL C3/S301 FOR OPENING SUPPORT.

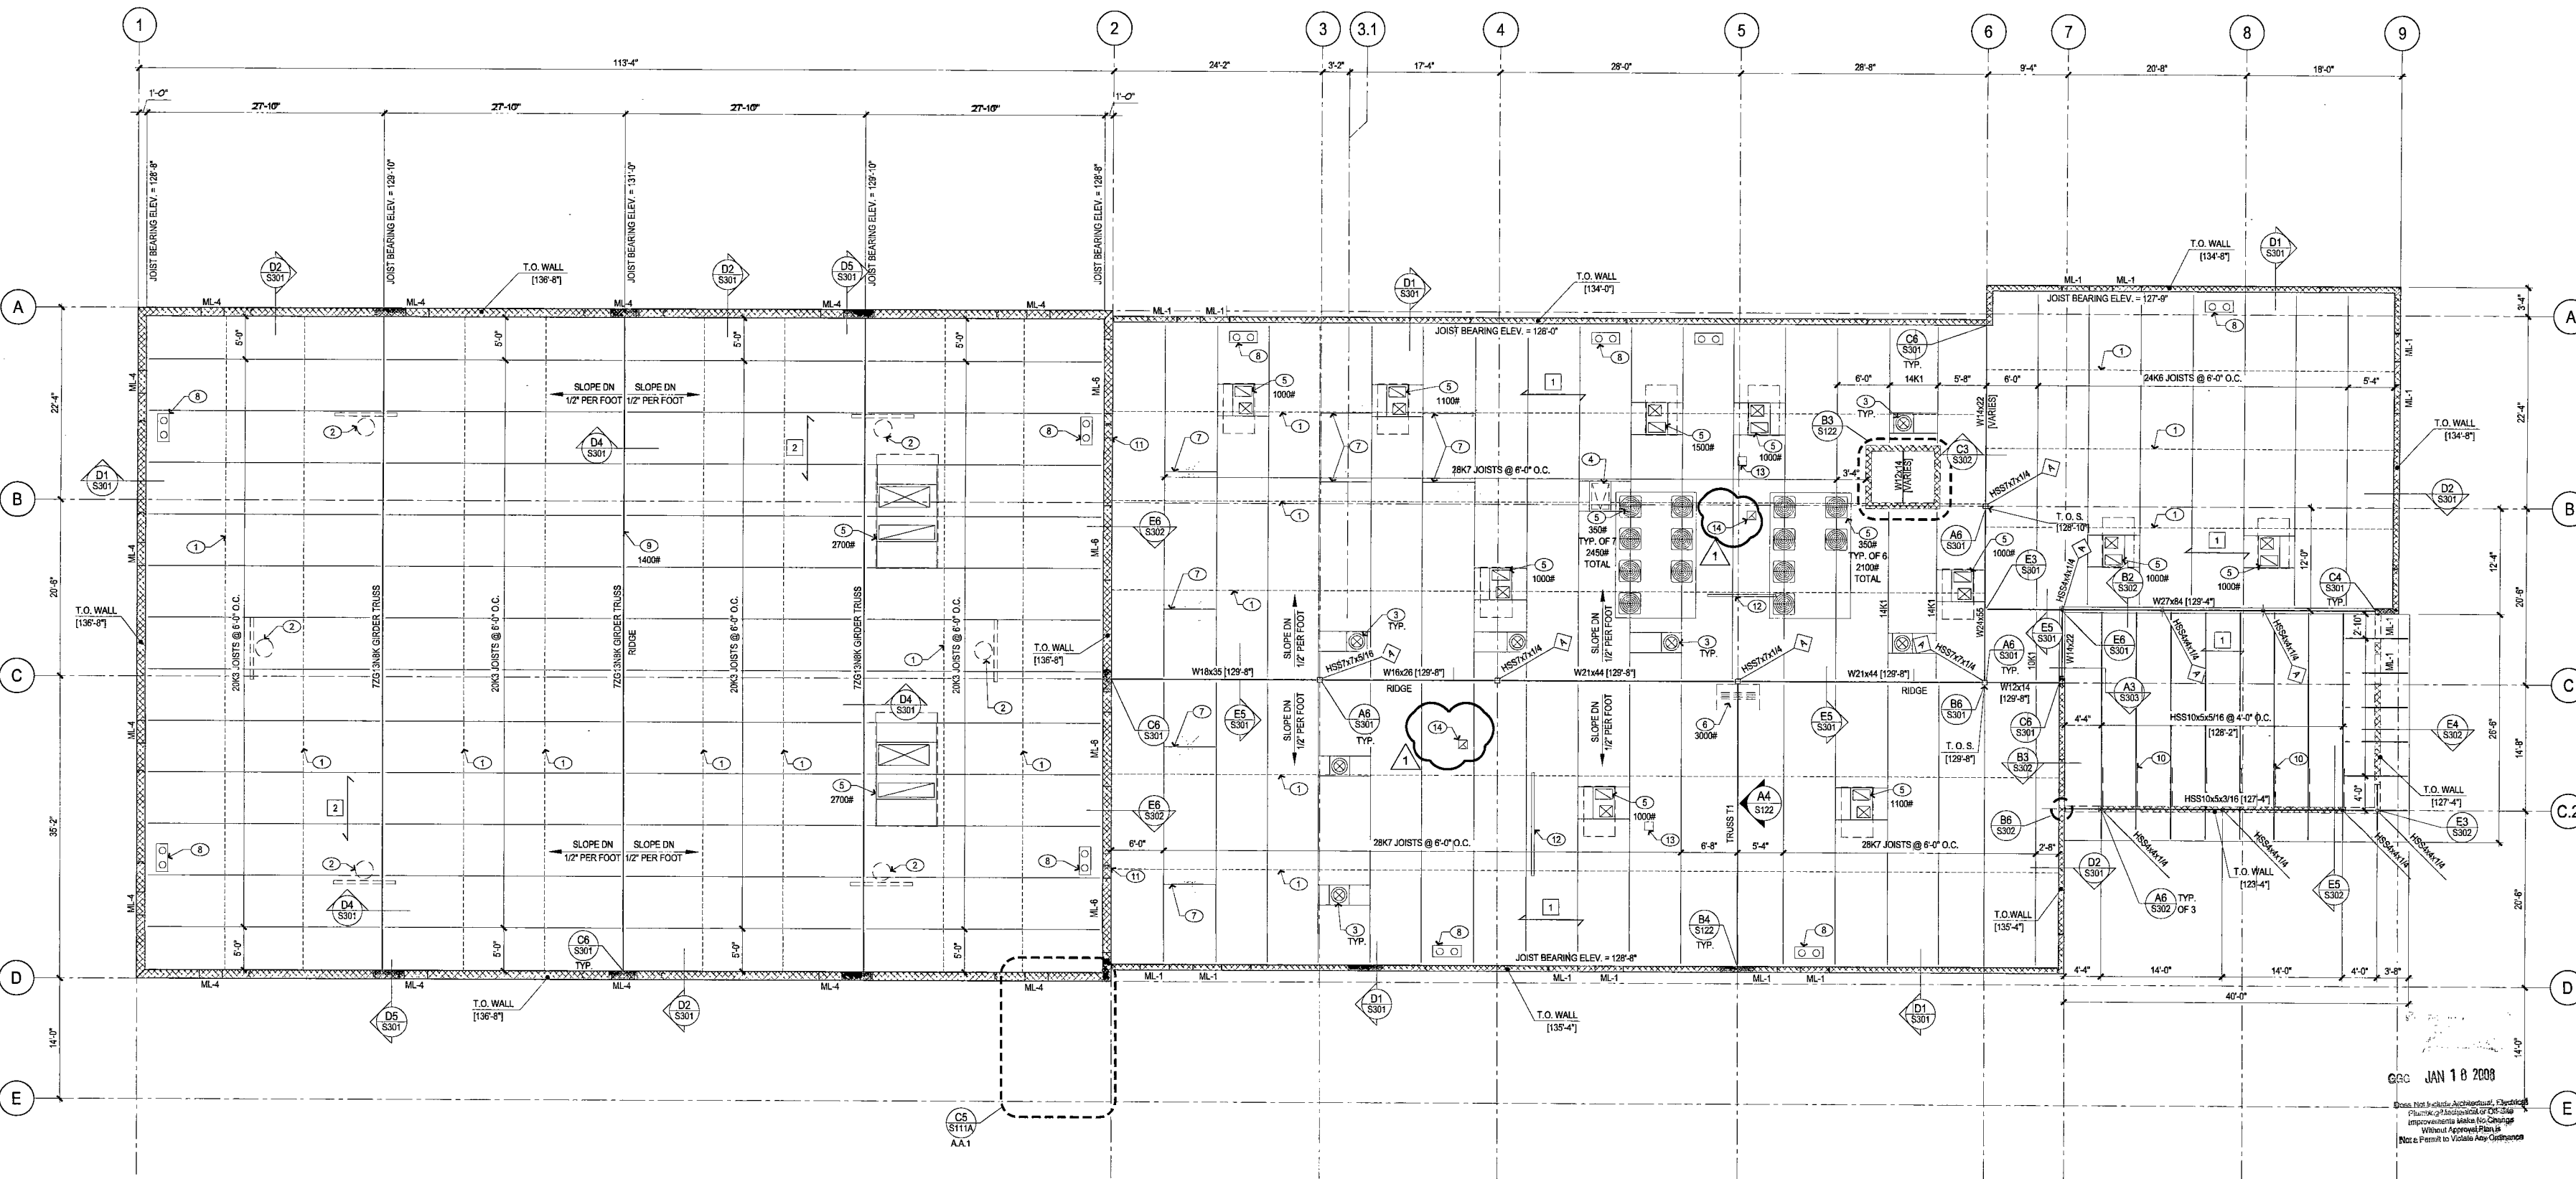

STUPAK COMMUNITY CENTER
251 WEST BOSTON AVENUE
LAS VEGAS, NEVADA 89102
ROOF FRAMING PLAN

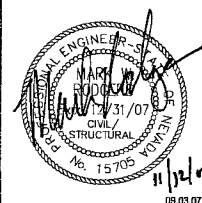

OWNER: CITY OF LAS VEGAS
DEPARTMENT OF PUBLIC WORKS
ARCHITECTURAL SERVICES

400 EAST STEWART AVENUE
LAS VEGAS, NEVADA 89103
PHONE: (702) 229-6838
FAX: (702) 384-8848
TDD: (702) 384-9108

DATE	11.02.07
SCALE	1/8"=1'-0"
NO	06.15341.25
REV	650.39-2

CITY OF LAS VEGAS
PERMITS
S121