


GENERAL NOTES:

1. CONTRACTOR SHALL BE RESPONSIBLE FOR THE COORDINATION OF ALL PLUMBING ROUGH-IN LOCATIONS, REFER TO ARCHITECTURAL DRAWINGS FOR FIXTURES AND EQUIPMENT LOCATIONS.
2. CONTRACTOR SHALL BE RESPONSIBLE FOR ALL CUTTING AND PATCHING AS REQUIRED TO ACCOMMODATE HIS WORK.
3. PLUMBING CONTRACTOR SHALL COORDINATE ROUTING OF PIPING WITH ALL OTHER TRADES PRIOR TO COMMENCING WORK.

SHEET NOTES:

- 1 3" ROOF DRAIN AND OVERFLOW DRAIN DOWN THROUGH ROOF.
- 2 4" ROOF DRAIN AND OVERFLOW DRAIN DOWN THROUGH ROOF.
- 3 3/4" CONDENSATE DRAIN DOWN THROUGH ROOF.
- 4 1" CONDENSATE DRAIN DOWN THROUGH ROOF.
- 5 3/4" COLD WATER DOWN.

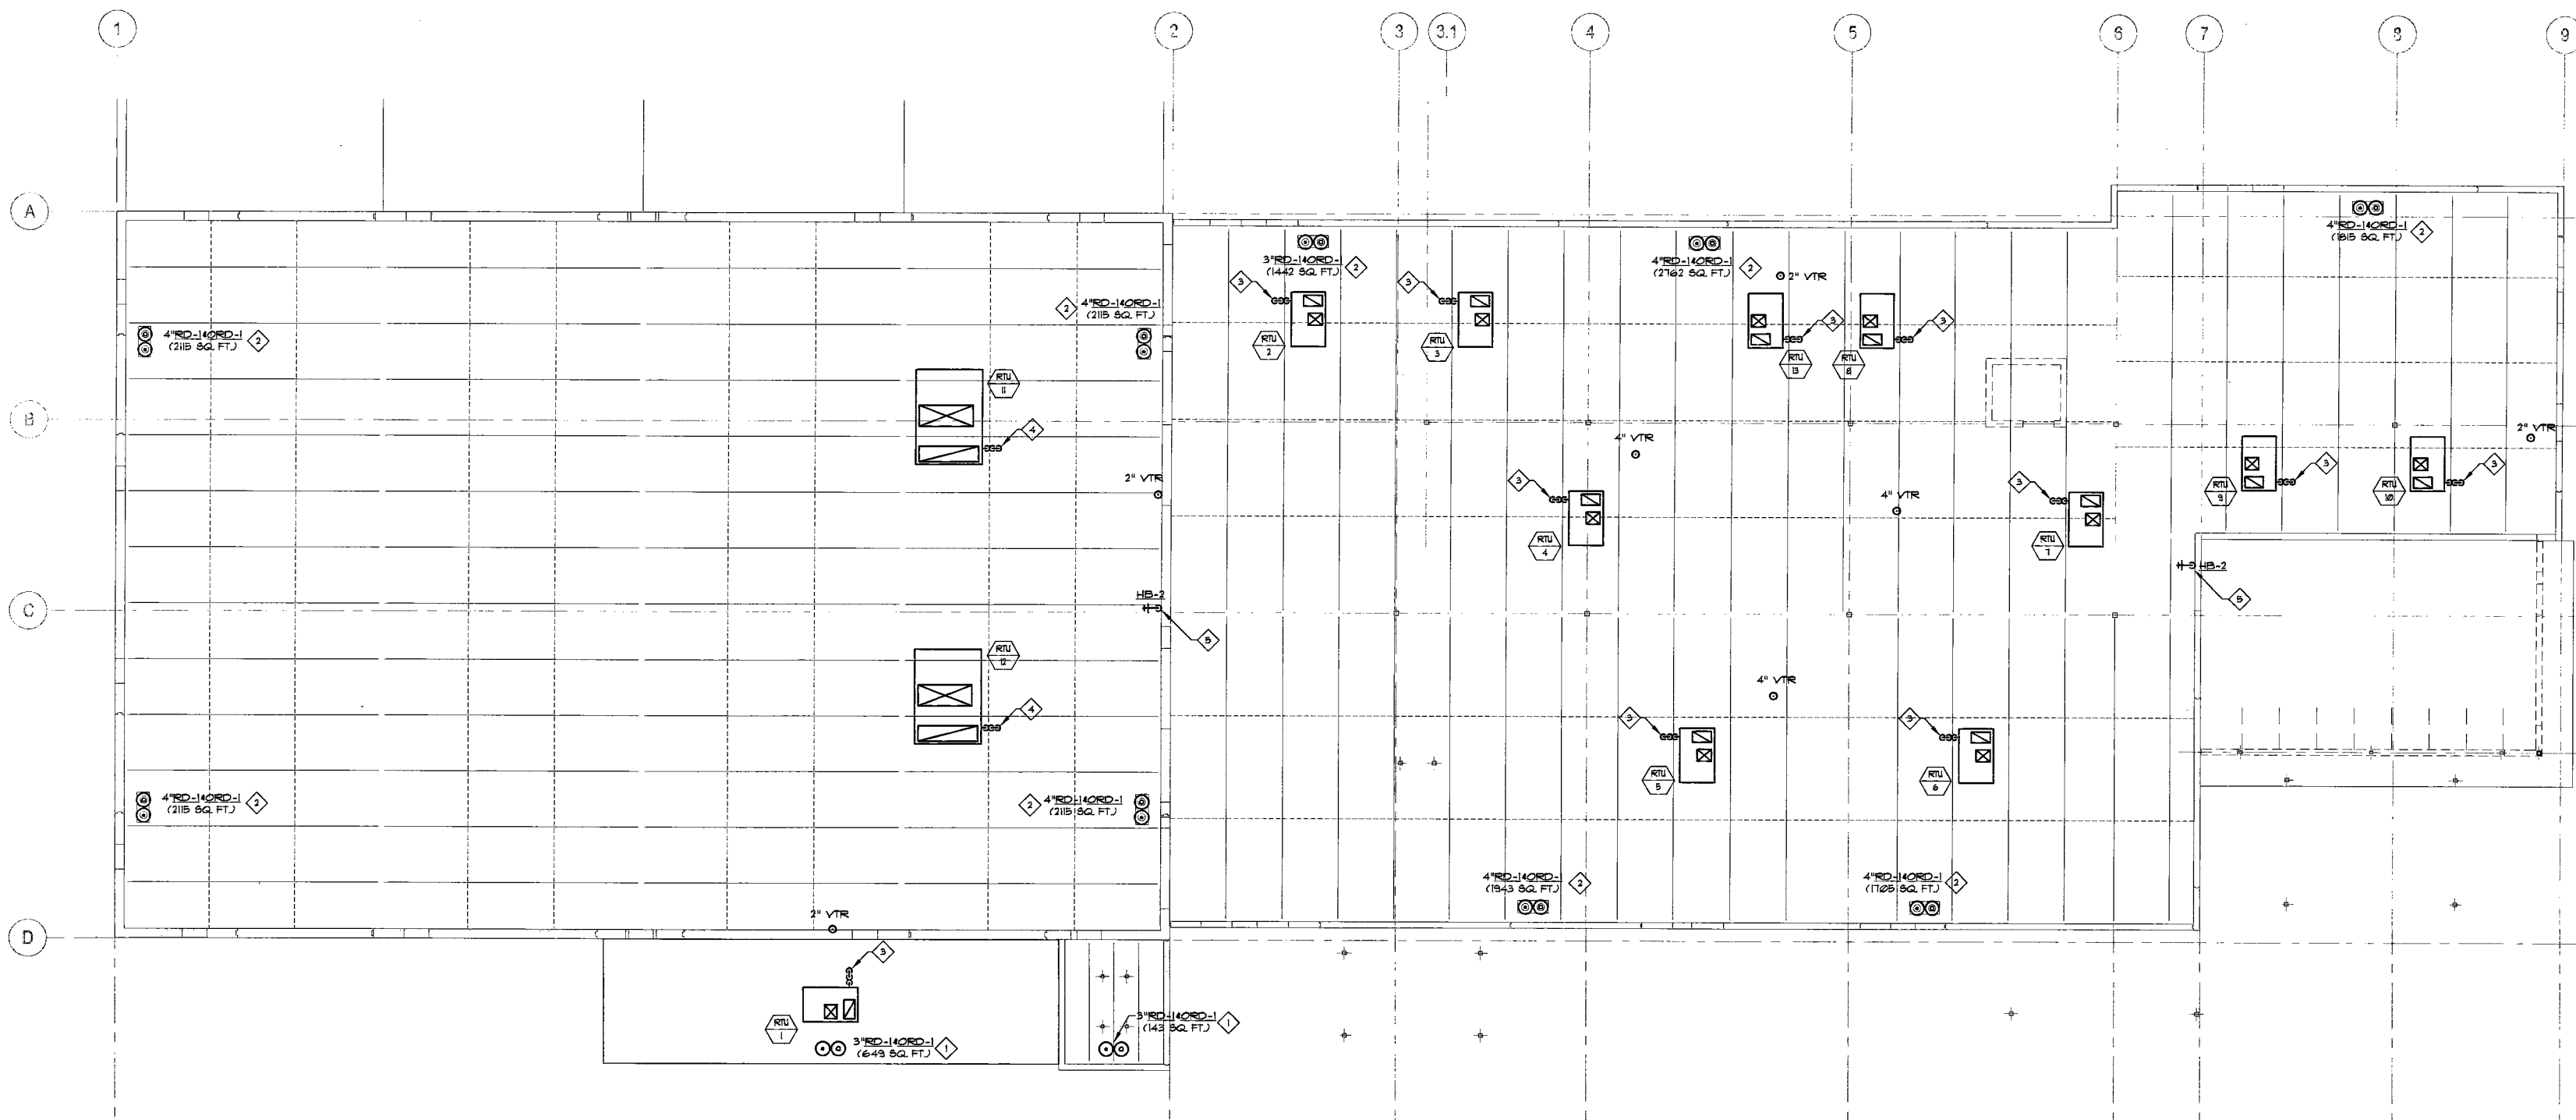

PLUMBING ROOF PLAN
1/8" = 1'-0"




PLANS APPROVED
PLUMBING/MECHANICAL
Building & Safety Dept.
City of Las Vegas, Nevada

M H JAN 23 2008
Does Not include Architectural, Electrical
Structural or Civil Site
Improvements Make No Change
Without Approval There is
Not a Permit to Violate Any Ordinance

MSA # L06354



STUPAK COMMUNITY CENTER
250 WEST BOSTON AVENUE
LAS VEGAS, NEVADA 89102
PLUMBING ROOF PLAN

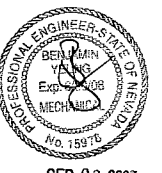

OWNER: CITY OF LAS VEGAS
DEPARTMENT OF PUBLIC WORKS
ARCHITECTURAL SERVICES

400 EAST STEWART AVENUE
LAS VEGAS, NEVADA 89101
PHONE: (702) 229-6535
FAX: (702) 384-6846
TDD: (702) 384-6108

DATE: 09/03/07
SCALE: AS NOTED
JOB NO: 06.15341.25
SUB NO: 650.39-2

P201