


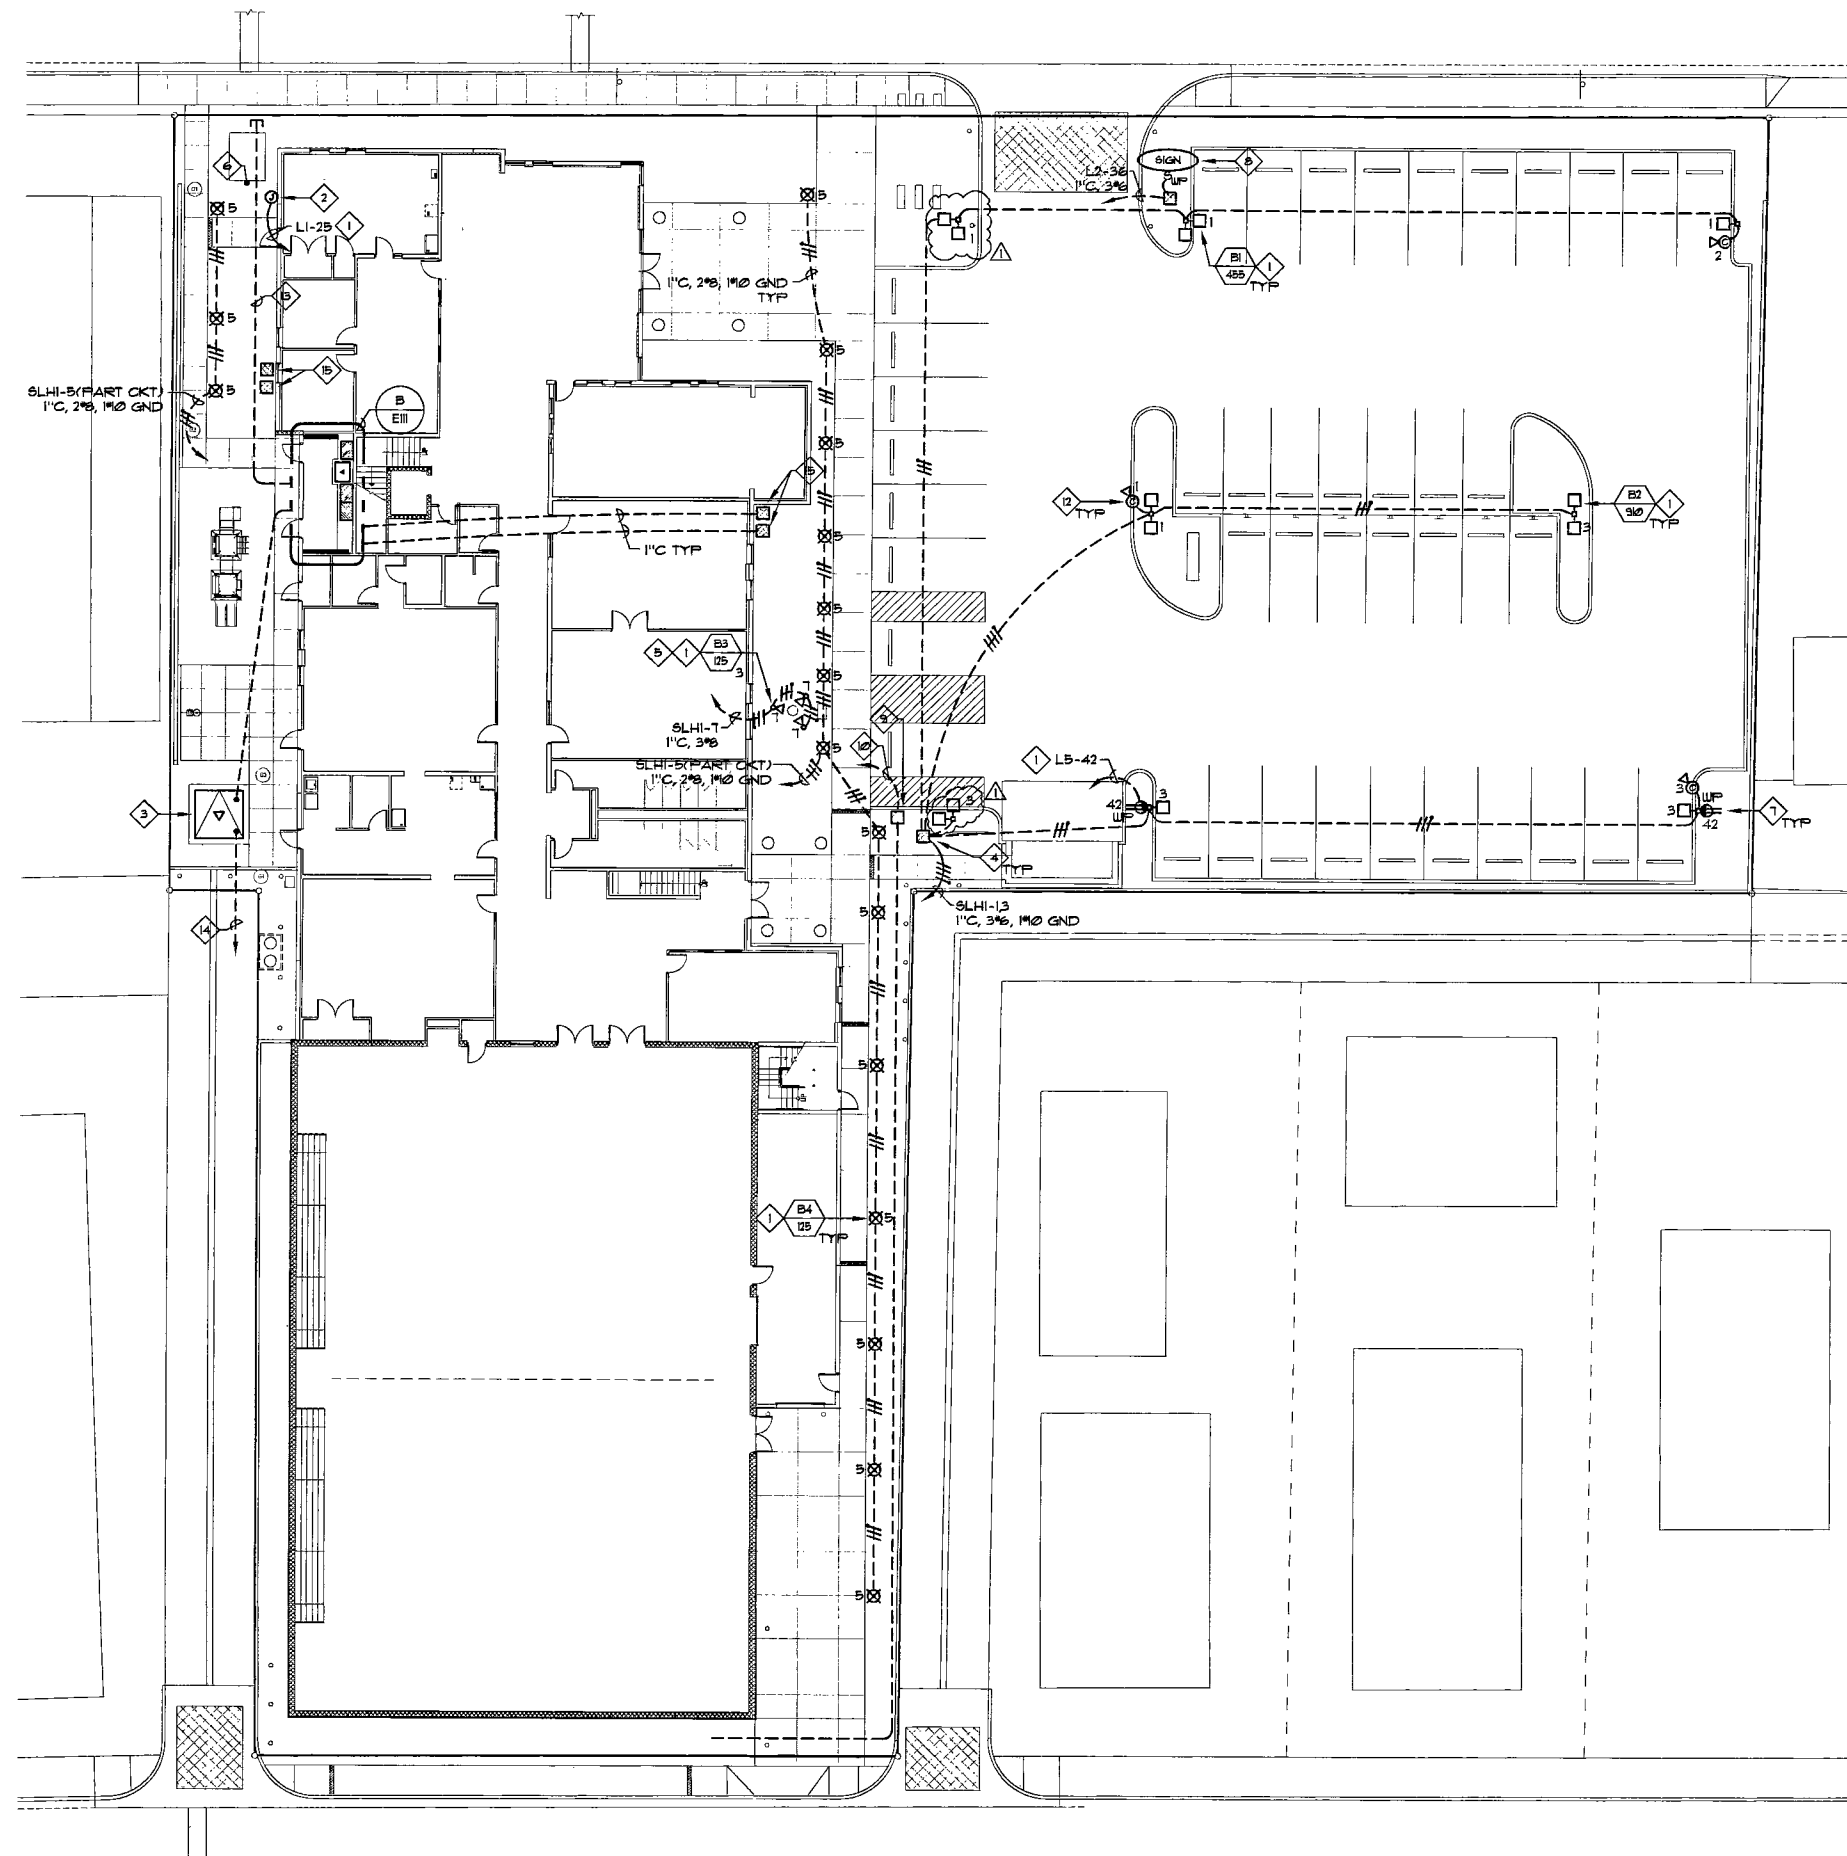

GENERAL NOTES:

- ALL CIRCUITS SHALL CARRY A GREEN GROUND CONDUCTOR.
- REFER TO SHEET E004 FOR LIGHT POLE AND BOLLARD BASE DETAIL AND INFORMATION. COORDINATE WITH CIVIL SITE SURVEYOR FOR ALL HORIZONTAL CONTROL STATIONS.

SHEET NOTES:

- COORDINATE ROUGH-IN LOCATION WITH ARCHITECT.
- CONNECT TO IRRIGATION CONTROLLER. COORDINATE ROUGH-IN LOCATION WITH ARCHITECT AND LANDSCAPE CONTRACTOR.
- APPROXIMATE LOCATION OF NEVADA POWER COMPANY TRANSFORMER. REFER TO NEVADA POWER COMPANY ENGINEERED DRAWINGS FOR ACTUAL LOCATION AND INCOMING CONDUIT ROUTING.
- PROVIDE 3 1/2 INGRADE FULLBOX AS SHOWN. COORDINATE ROUGH-IN LOCATION WITH LANDSCAPE CONTRACTOR.
- LOCATE FLAG POLE LIGHTS AT 120 DEGREES STATIONS AT A DISTANCE OF APPROXIMATELY 5' FROM POLE CENTER. LOCATE THE (2) TWO LIGHTS ALONG SIDEWALK BEHIND THE LIGHT BOLLARD AS SHOWN. AIM AT FLAG IN PRESENCE OF CITY CONSTRUCTION MANAGER FOR THE PROJECT.
- APPROXIMATE LOCATION OF POST INDICATOR VALVE (PIC) REFER TO CIVIL DRAWINGS.
- MOUNT OUTLET AT +48" AFF ON BACKSIDE OF LIGHT POLE. ALL CONDUIT SHALL BE INSTALLED WITHIN THE LIGHT POLE BASE.
- COORDINATE ROUGH-IN LOCATION WITH ARCHITECT.
- SURVEILLANCE FULLBOX - PROVIDE 3 1/2 FULLBOX WITH BROWN FIBERGLASS LID.
- PROVIDE (1) 2" CONDUIT TO 2ND FLOOR SURVEILLANCE EQUIPMENT.
- PROVIDE (1) 2" CONDUIT SPARE STUB AND CAP IN LANDSCAPE AREA. PROVIDE DIMENSIONED LOCATIONS ON.
- INSTALL CAMERA ON LIGHT POLE AS SHOWN IN DETAILS ON SHEET E004. CONFIRM CAMERA POLE LOCATION WITH OWNER PRIOR TO START OF CONDUIT WORK. CONTRACTOR SHALL WALK THE SITE WITH THE OWNER TO FIELD VERIFY LOCATIONS.
- EXTEND EMBARG AND COX COMMUNICATIONS CONDUIT TO SERVING UTILITY COMPANY POINTS OF CONNECTION. ALL WORK SHALL BE INSTALLED AND INSPECTED PER THE ENGINEERED UTILITY COMPANY DRAWINGS.
- EXTEND NEVADA POWER COMPANY CONDUITS TO NEVADA POWER POINT OF SERVICE CONNECTION. ALL WORK SHALL BE INSTALLED AND INSPECTED PER THE ENGINEERED UTILITY COMPANY DRAWINGS.
- PROVIDE 3 1/2 FULLBOX FOR FUTURE POWER AND TELEPHONE.

A SITE ELECTRICAL PLAN
E100 1/16" = 1'-0"



CITY OF LAS VEGAS
PLANS APPROVED
ELECTRICAL
Building & Safety Dept.
City of Las Vegas, Nevada

HT JAN 03 2008

Does Not Include Structural, Architectural,
Planning/Mechanical or Civil
Improvements Make No Change
Without Approval Plan is
Not a Permit to Violate Any Ordinance



STUPAK COMMUNITY CENTER
251 WEST BOSTON AVENUE
LAS VEGAS, NEVADA 89102
SITE ELECTRICAL PLAN



OWNER: CITY OF LAS VEGAS
DEPARTMENT OF PUBLIC WORKS
ARCHITECTURAL SERVICES

400 EAST STEWART AVENUE
LAS VEGAS, NEVADA 89101
PHONE: (702) 228-6535
FAX: (702) 384-9845
TDD: (702) 384-9108

DATE 11.02.07
SCALE AS NOTED
SHEET NO 06.15341.25
CITY OF LAS VEGAS 650.39-2

