


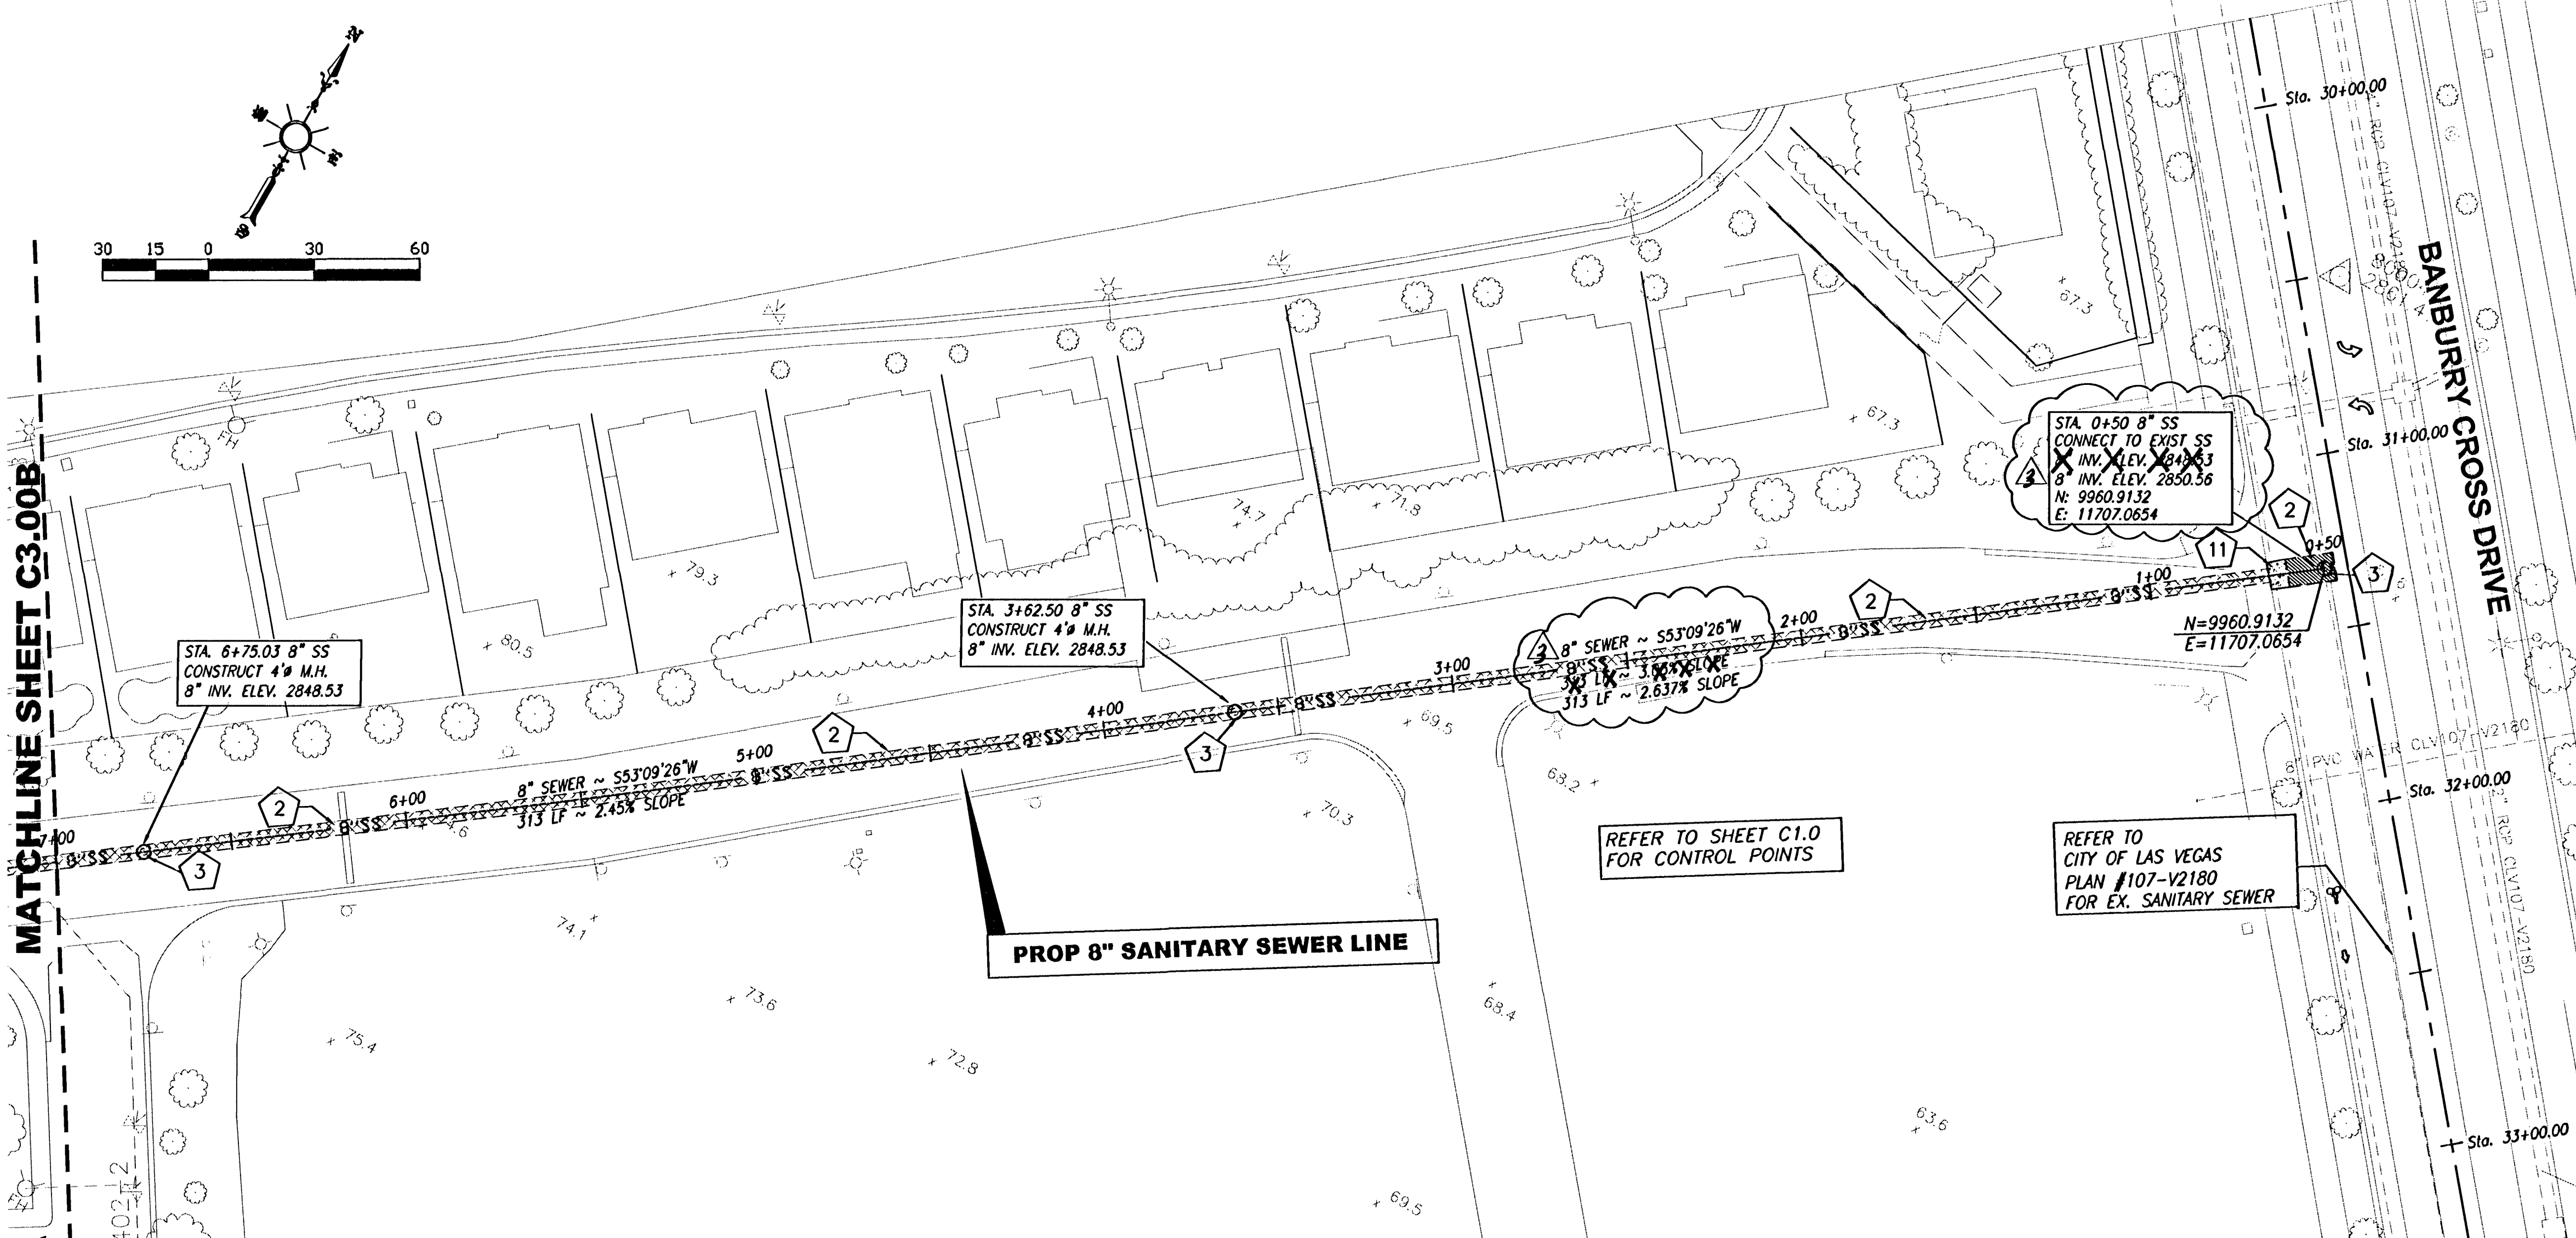

SEWER CONSTRUCTION NOTES

- (NOT ALL KEY NOTES ARE USED ON THIS DRAWING)
- 1 STUB AND CAP SEWER, FOR CONTINUATION REFER TO MEP PLANS.
 - 2 SAWCUT EX. PAVEMENT TRENCH AND BACKFILL PER DCSWCS #SD-16A. (SEE SHEET C3.21)
 - 3 CONSTRUCT 4" SS MH PER DCSWCS #SD-1 (SEE SHEET C3.21)
 - 4 INSTALL 6" ~ 45° BEND
 - 5 INSTALL 4" ~ 45° BEND
 - 6 INSTALL 8"x8" ~ 45° WYE
 - 7 INSTALL 8"x6" ~ 45° WYE
 - 8 INSTALL 8"x4" ~ 45° WYE
 - 9 REFER TO "DESIGN AND CONSTRUCTION STANDARDS FOR WASTEWATER COLLECTION SYSTEMS", DESIGN AND CONST. STD SECTION 2.2.21 A&B FOR PARALLEL AND CROSSING SECTIONS
 - 10 INSTALL CLEAN OUT PER DETAIL.
 - 11 SAW CUT, REMOVE AND REPLACE EXISTING VALLEY GUTTER.

NOTE:

ALL ABOVE GROUND UTILITY APPURTENANCES SHALL CONFORM TO THE REQUIREMENTS OF TITLE 19.12.040 AND THE SUMMERLIN DEVELOPMENT STANDARD.



SEWER CONTRIBUTION

ESTIMATED AVERAGE DAILY SEWAGE FLOW: 0.050 MGD
ESTIMATED PEAK DAILY SEWAGE FLOW: 0.169 MGD

**ALL ON-SITE STORM DRAINS AND
SANITARY SEWER ARE
PRIVATELY OWNED & MAINTAINED**

CAUTION TO CONTRACTOR

THE CONTRACTOR SHALL BE RESPONSIBLE TO INVESTIGATE AND VERIFY THE ACTUAL LOCATION AND DEPTH OF ALL EXISTING UNDERGROUND FACILITIES AT LEAST 48 HOURS IN ADVANCE OF THE PERFORMANCE OF ANY WORK.

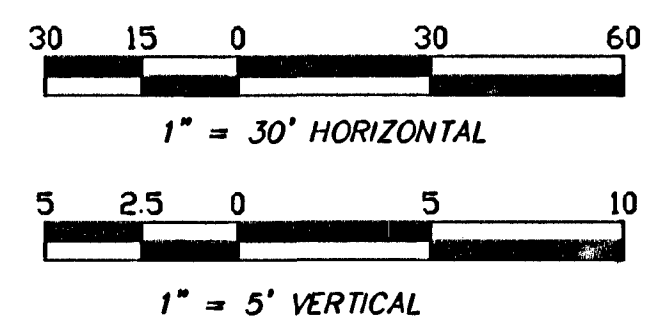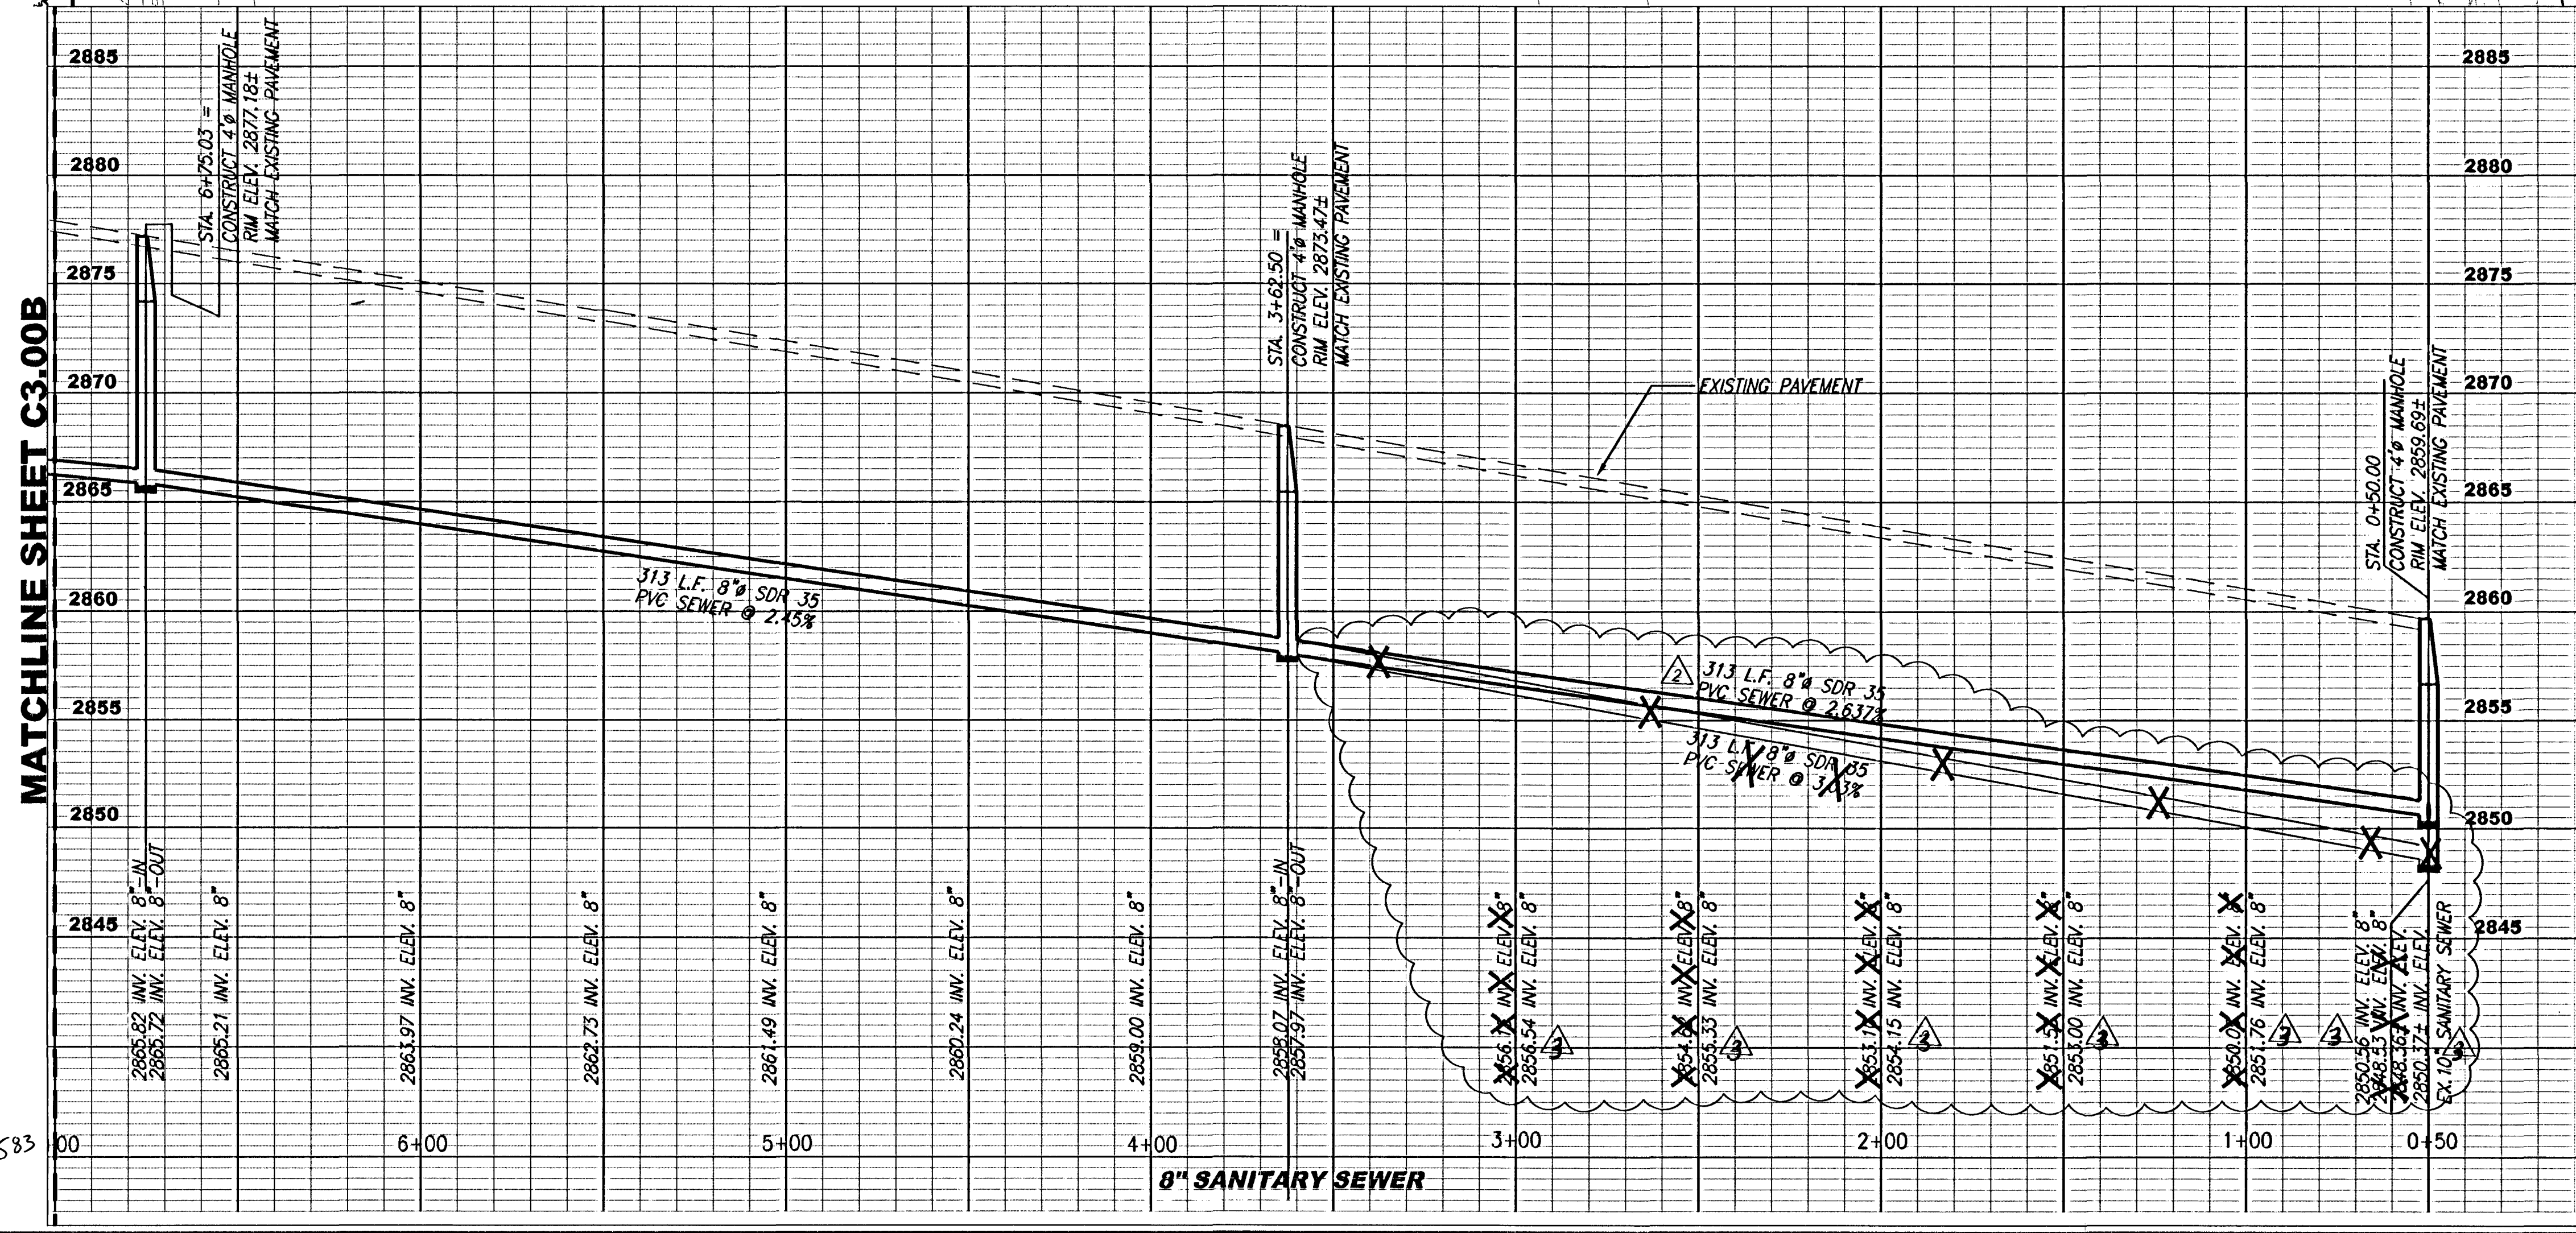


BASIS OF BEARINGS:

NORTH 40°08'34" WEST EAST BEING THE CENTERLINE OF BANBURY CROSS DRIVE AS SHOWN PLAT MAPS IN BOOK 64, PAGE 67 ON FILE AT THE CLARK COUNTY RECORDER'S OFFICE.

BENCHMARK:

CITY OF LAS VEGAS BENCHMARK #1LV0925NS, A RIVET & PLATE IN TOP OF CURB AT NORTHWEST CORNER OF CRESTDALE LANE AND HUALAPAI. ELEVATION = 891.3026 METERS, 2924.22 FEET (NAVD 88)

REV	DESCRIPTION:	DATE:	BY:
1	REVISED SAN. SEWER LINE		
2	CORRECTED INV. ELEV. ON SAN. SEWER AT STATION 0+50	8/4/8	KS

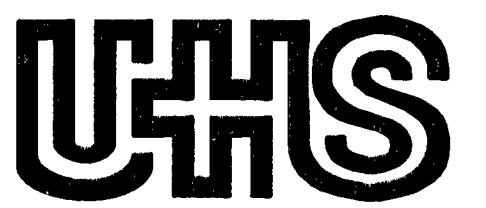

CLIENT
UHS OF DELAWARE, INC
387 SOUTH GULPH ROAD
KING OF PRUSSIA, PA 19408

ARCHITECT
HKS ARCHITECTS INC.
1919 MCKINNEY AVENUE
DALLAS, TX 75201-1753

STRUCTURAL ENGINEER
CHAVEZ-GRIEVES
CONSULTING ENGINEERS, INC.
4700 LINCOLN ROAD NE, SUITE 102
ALBUQUERQUE, NM 87109

MEP ENGINEER
CORD PARTNERS
3625 N. HALL ST., SUITE 1300 LB 139
DALLAS, TX 75219

DESIGN CONSULTANT
DESIGN STUDIO, INC.
161 LEVERINGTON AVE.
PHILADELPHIA, PA 19127

CIVIL ENGINEER
LOPEZGARCIA GROUP
1950 STEMMONS FRWY, SUITE 6000
DALLAS, TX 75207


FOOD SERVICE CONSULTANT
SDI, INC.
5200 DTC PARKWAY, SUITE 500
GREENWOOD VILLAGE, CO. 80111

LANDSCAPE ARCHITECT
JW ZUNINO AND ASSOCIATES
3191 S. JONES BLVD.
LAS VEGAS, NV 89148



**SUMMERLIN HOSPITAL
MEDICAL CENTER**

**Summerlin
Hospital
Bed
Addition
Las Vegas, NV**

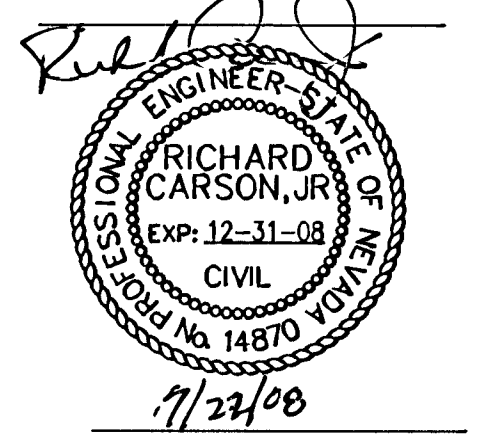

REVISION
PC 001 MAY 14, 2008
PC 006 JUNE 30, 2008

HKS PROJECT NUMBER
9942.003
DATE
October 23, 2007

ISSUE
ISSUED FOR PERMIT
SHEET TITLE
UTILITY PLAN

C3.00A
SHEET NO. 1 OF 20
107V4772-2
© 2008 HKS ARCHITECTS INC.