

HOT AND COLD WATER SUPPLY PIPING PLAN


SCALE: 3/16" = 1' - 0"

GENERAL NOTES

1. ALL CONDENSATE DRAIN PIPING SHALL BE SLOPED 1/8" PER FOOT.

SHEET NOTES

- 1 1/2" HOT AND COLD WATER PIPE DOWN IN WALL.
- 2 3/4" COLD WATER DOWN IN WALL.
- 3 1/2" COLD WATER DOWN IN WALL.
- 4 2" COLD WATER DOWN TO 2" HEADER.
- 5 LOCATE SHUT-OFF VALVE ABOVE CEILING IN AN ACCESSIBLE LOCATION. PROVIDE ACCESS PANEL. REFER TO ARCHITECTURAL DRAWINGS.
- 6 1/2" HOT WATER DOWN IN WALL.
- 7 ROUTE COLD WATER PIPE ABOVE CEILING.
- 8 ROUTE HOT WATER AND HOT WATER RETURN PIPE ABOVE CEILING.
- 9 ROUTE HOT WATER PIPE ABOVE CEILING.
- 10 ROUTE HOT WATER, COLD WATER, HOT WATER RETURN PIPE ABOVE CEILING.
- 11 1/2" COLD WATER DOWN TO TRAP PRIMER.
- 12 2-1/2" COLD WATER UP IN WALL AND ABOVE CEILING.
- 13 PROVIDE SHUT-OFF VALVE IN CONCRETE VALVE BOX WITH CAST-IRON SCORiated COVER.
- 14 2-1/2" COLD WATER PIPE BELOW GRADE. REFER TO CIVIL DRAWINGS FOR CONTINUATION.
- 15 2" COLD WATER TO POOL MAKE-UP WATER SYSTEM.
- 16 6" FIRE SPRINKLER PIPE BELOW GRADE. REFER TO CIVIL DRAWINGS FOR CONTINUATION.
- 17 6" FIRE SPRINKLER RISER. PROVIDE CONCRETE THRUST BLOCK AT BASE OF RISER.
- 18 1/2" COLD WATER DOWN IN WALL TO 3/8" SUPPLY STOP FOR VENDING MACHINE.
- 19 1/2" COLD WATER DOWN TO EVAPORATIVE COOLER SUPPLY. REFER TO DIAGRAM 1/15.02.
- 20 1/2" INDUSTRIAL COLD WATER PIPING TO EVAPORATIVE COOLER. REFER TO SHEET P2.03 FOR CONTINUATION.
- 21 1/2" HOT WATER DOWN TO EMERGENCY EYEWASH STATION.
- 22 3/4" COLD WATER PIPE DOWN THRU FLOOR. REFER TO PE1.01 FOR CONTINUATION.
- 23 1" COLD WATER DOWN IN WALL.
- 24 3/4" HOT WATER DOWN IN WALL.

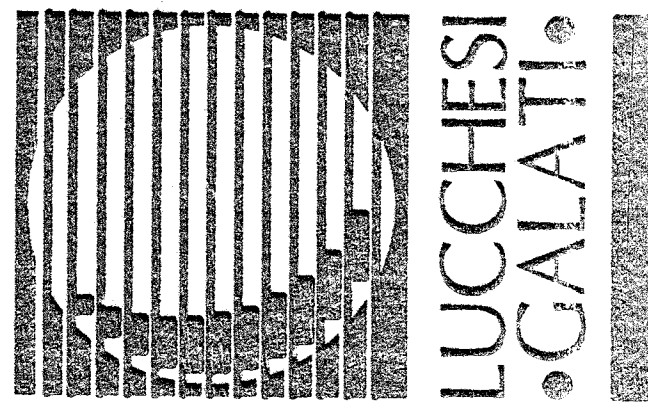

HARRIS
CONSULTING ENGINEERS
PROJECT NO. 990035
DESIGNED BY: L. ANCHETA
CHECKED BY: J. HARRIS
DRAWN BY: J. ROQUELO

**HOT AND COLD WATER
SUPPLY PIPING PLAN**
**SUMMERLIN ARBORS PARK
POOL AND POOL BUILDING**

Revisions:
Date: 10-22-93
Project No. 990035 ©
Scale: 3/16" = 1'-0"
Drawn By: KSK

PLANS APPROVED
PLUMBING/MECHANICAL
Issuing & Sealed True
City of Las Vegas, Nevada
BY: **NOV 03 1999**

Does Not Include: Connections, Electrical, Structural or Other
Improvements. Make No Changes
Without Approval. Form is
Not a Permit or Mechanical Ordinance.

Sheet Number: **P202**

500 PILOT ROAD, SUITE A, LAS VEGAS, NEVADA 89119 • PHONE (702) 263-7111 FAX (702) 263-8111