



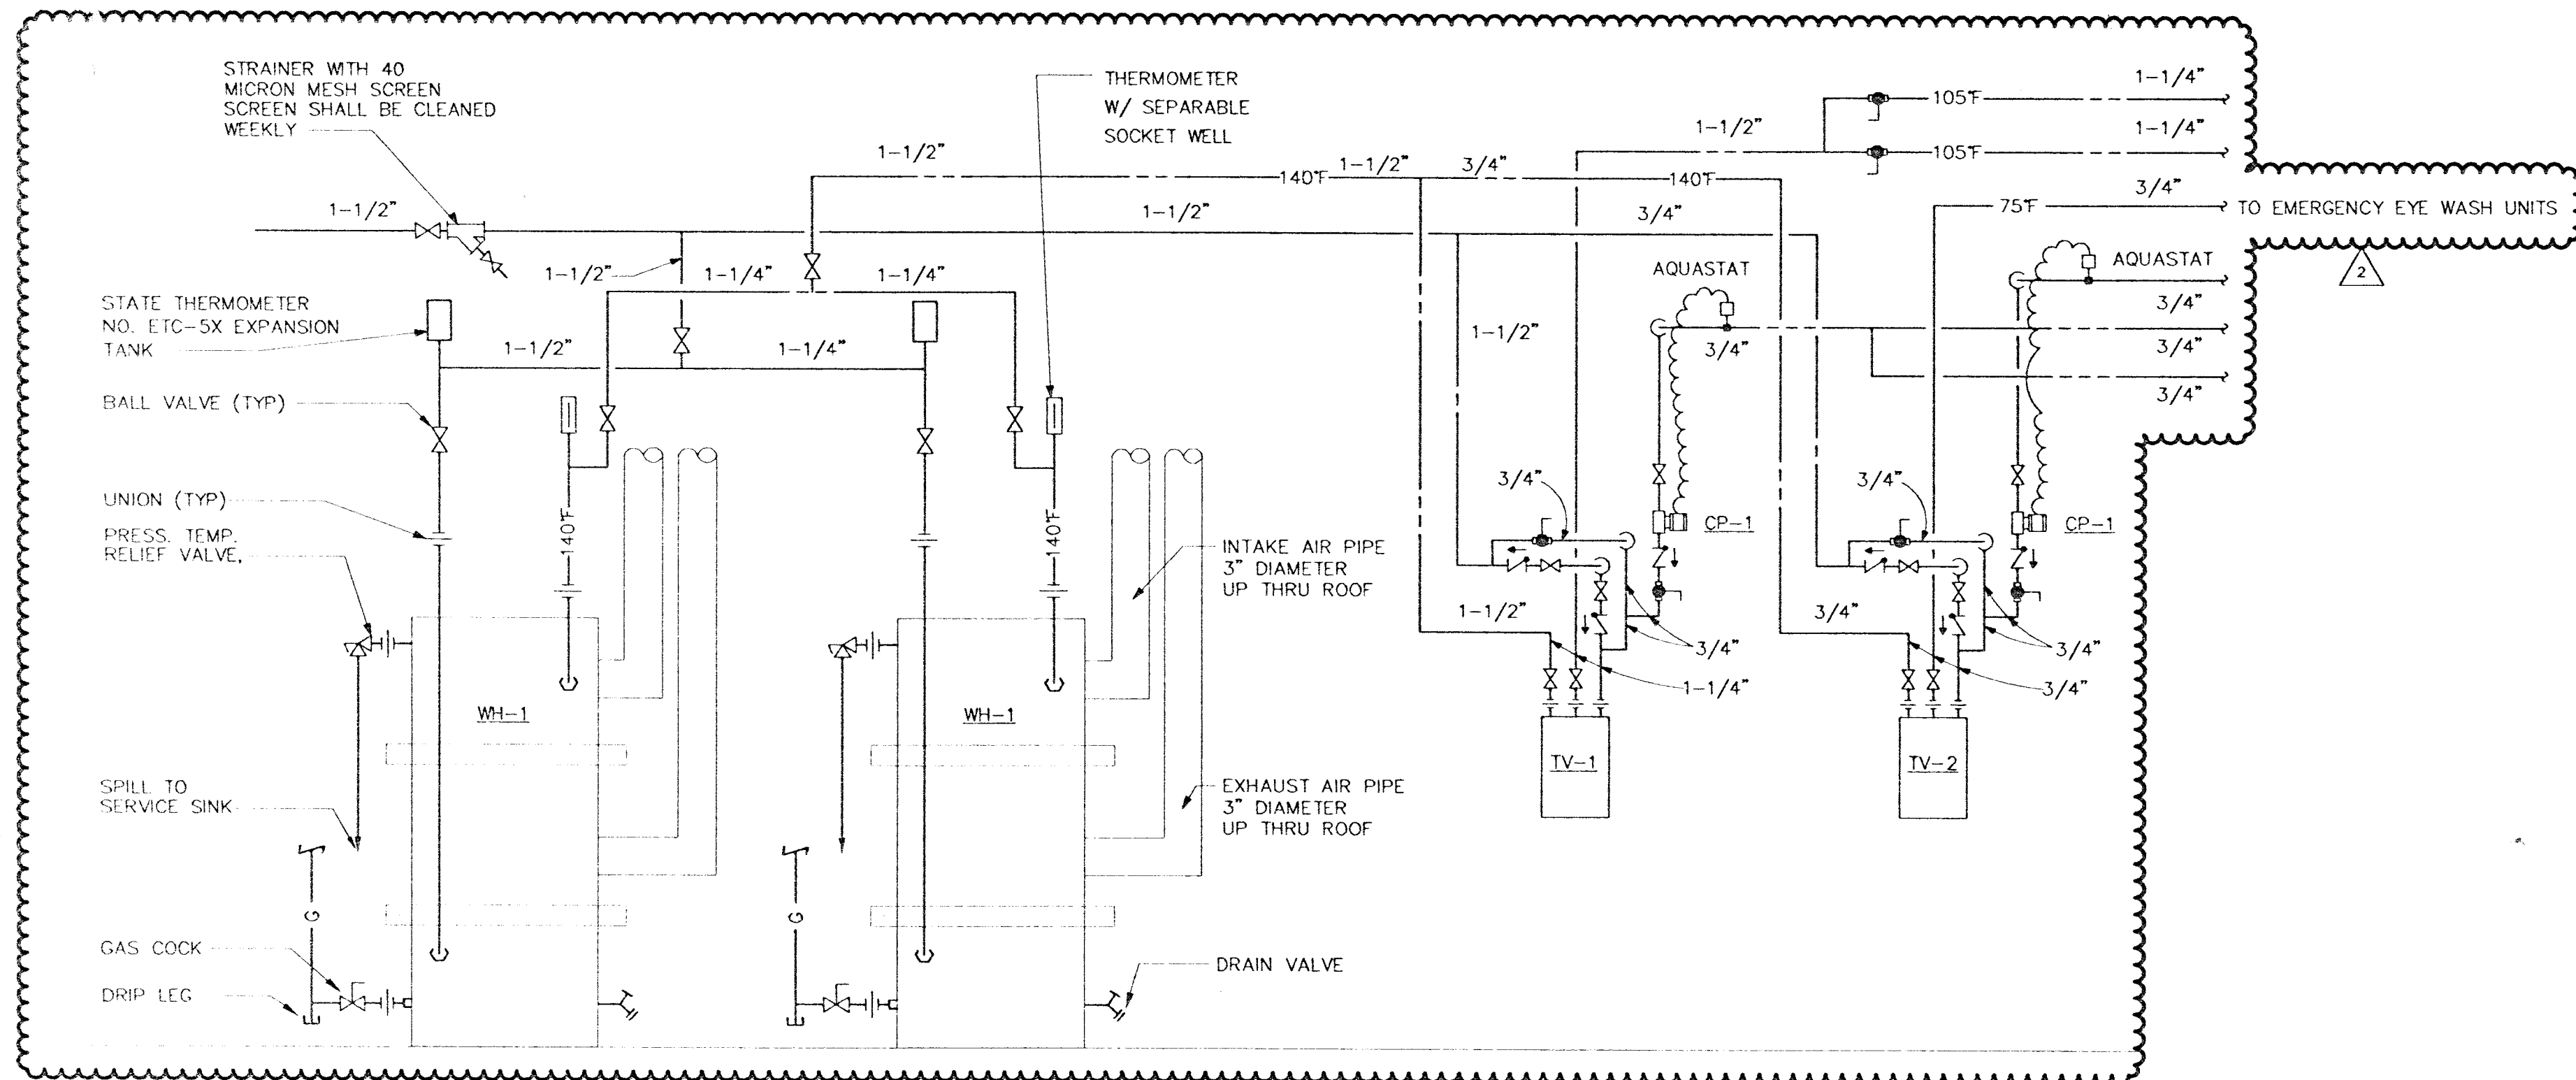


WATER HEATER PIPING DIAGRAM (WH-1)
NO SCALE

WH-1
PS.02

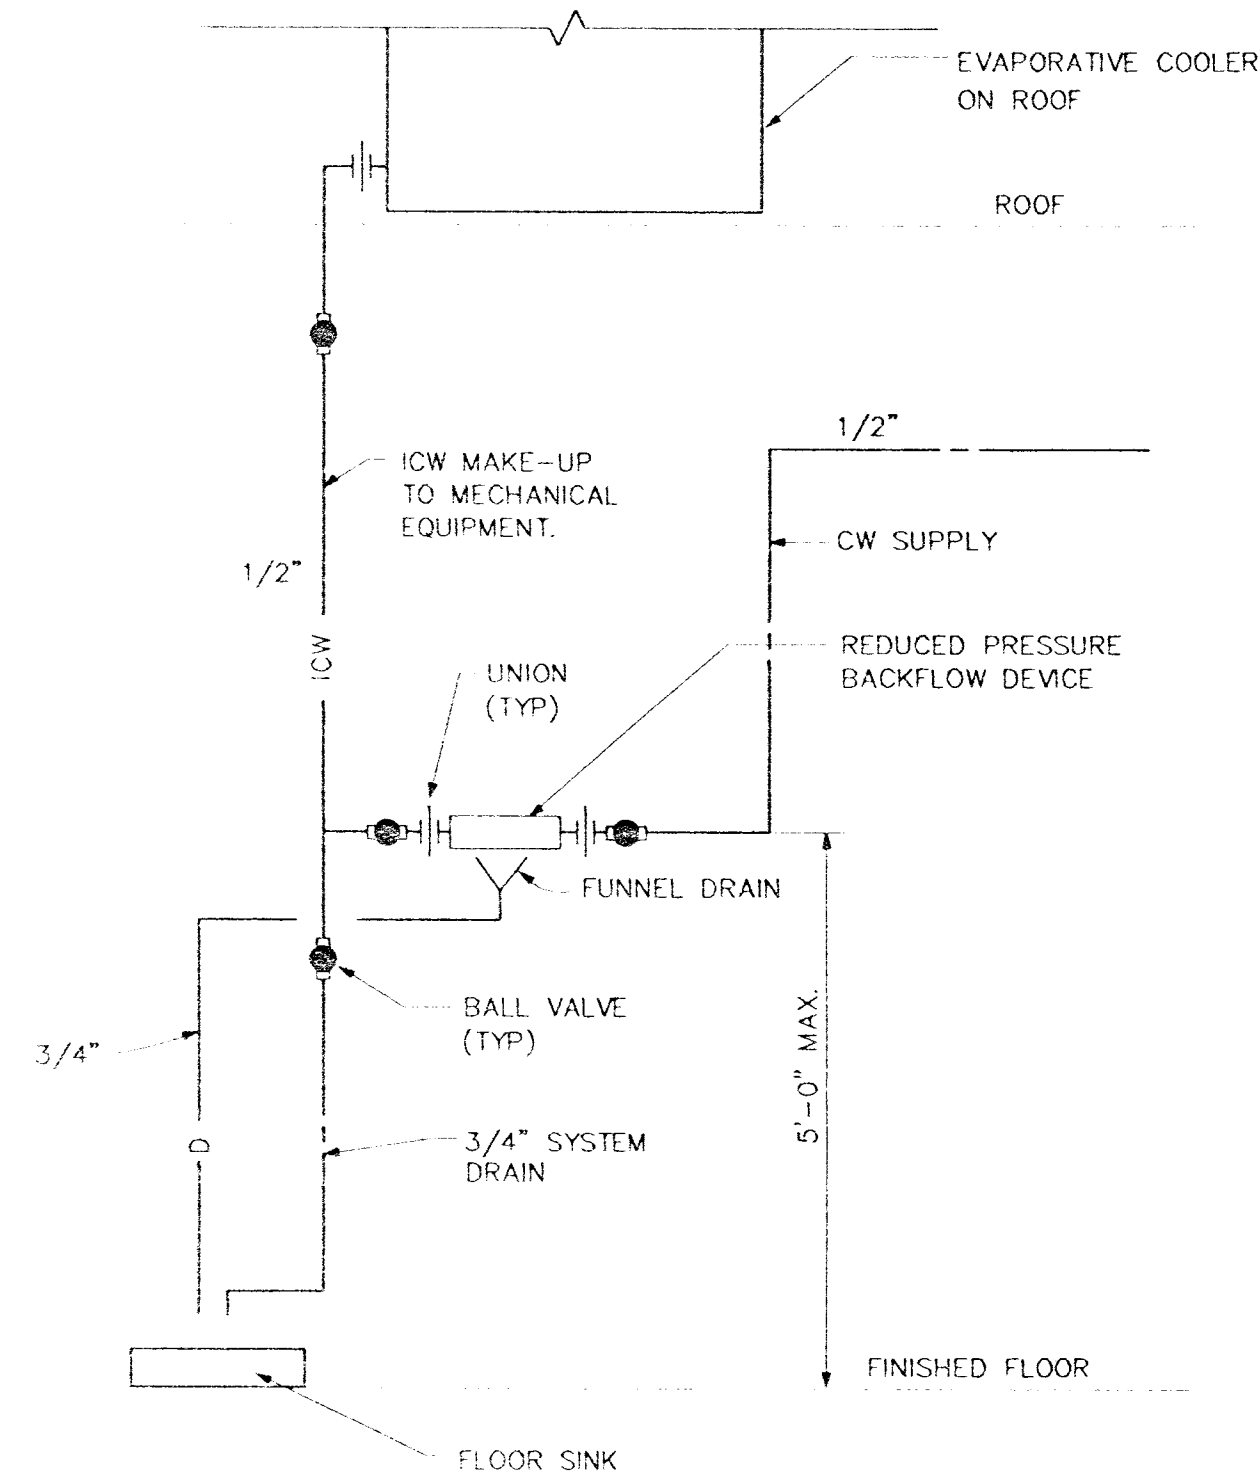

EVAPORATIVE COOLER WATER PIPING DIAGRAM
NO SCALE

1
PS.02

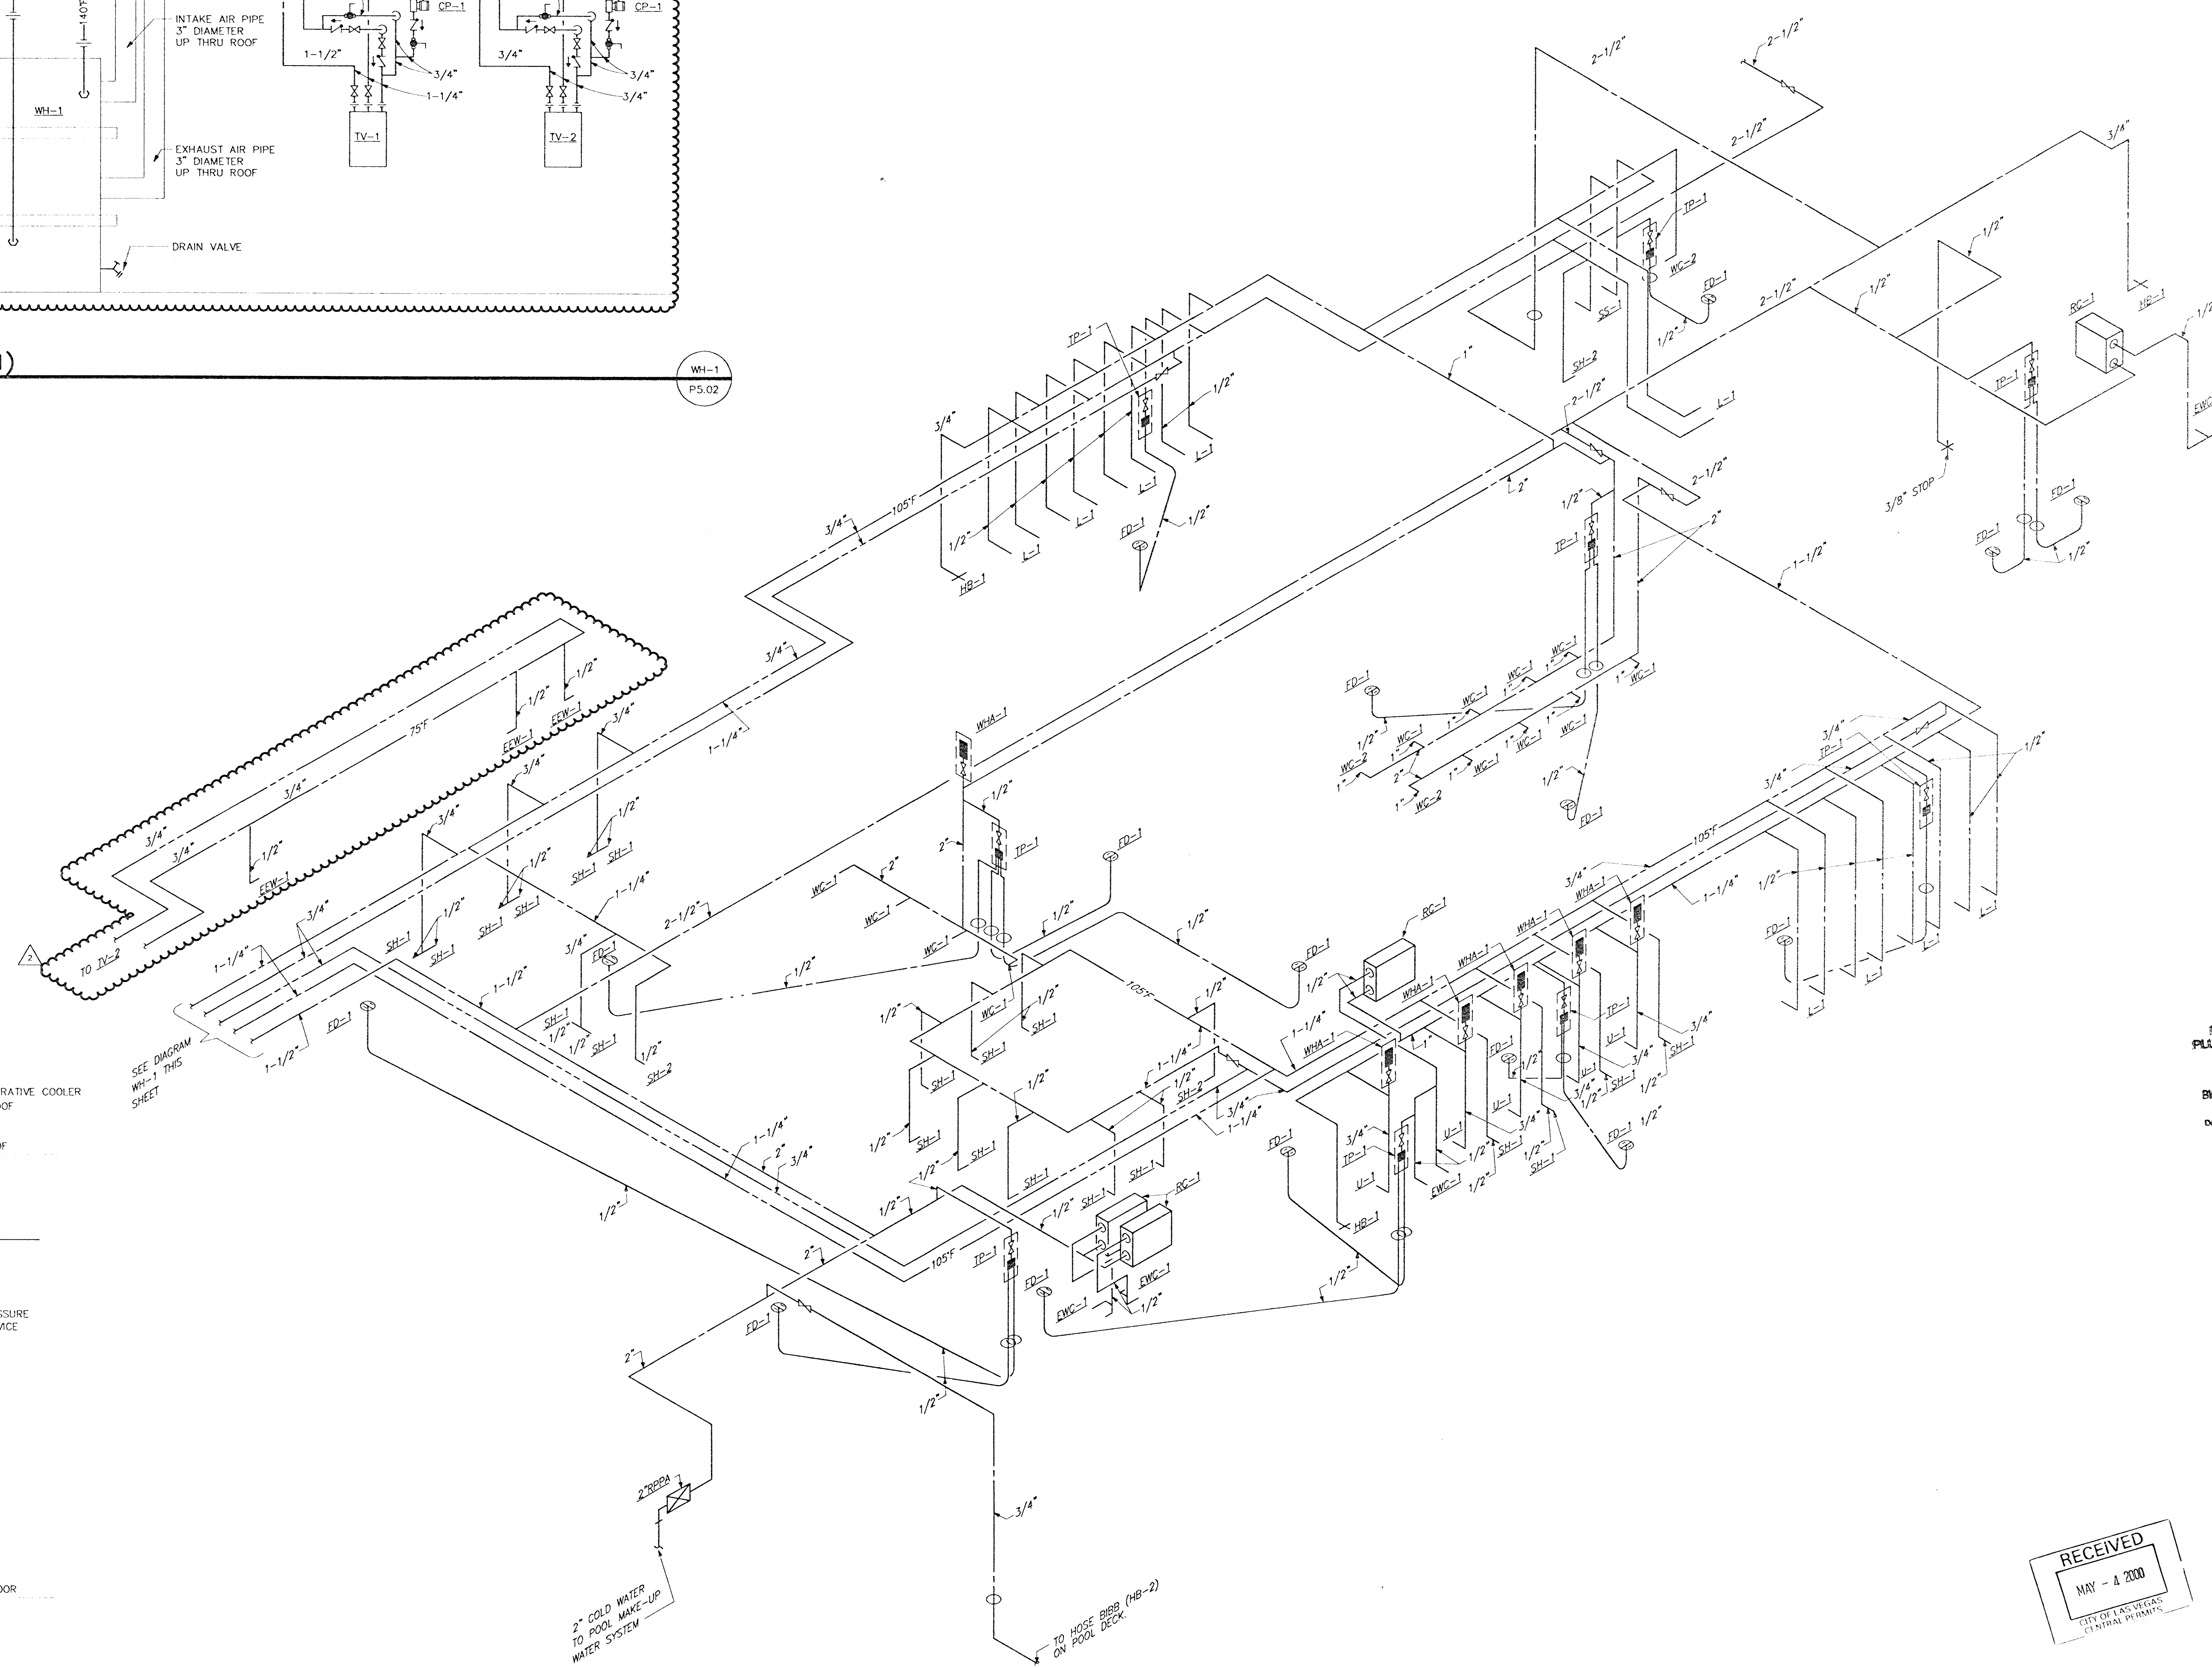

HOT AND COLD WATER SUPPLY RISER DIAGRAM
NO SCALE

WS-1
PS.02

LUCCHESI GALATI

STATE OF NEW YORK
JUL 1 2000
HARRIS

PROJECT NO. 00210-ED
DESIGNED BY L. HARRIS
CHECKED BY L. HARRIS
DRAWN BY L. HARRIS

PLUMBING RISER DIAGRAMS

SUMMERLIN ARBORS PARK

POOL AND POOL BUILDING

PLANS APPROVED
PLUMBING MECHANICAL
Building & Safety Dept.
City of Las Vegas, Nevada

BW AUG 01 2000

Does Not Include Architectural, Electrical
or Mechanical or Other
Improvements Made After
Without Approval Plan is
Not to be Used for Construction

RECEIVED
MAY - 4 2000
CITY OF LAS VEGAS
CENTRAL PLUMBING

Sheet Number: **P5.02**

P5.02