


GENERAL NOTES

1. REFER TO ARCHITECTURAL REFLECTED CEILING PLAN FOR EXACT LOCATION OF ALL LIGHTING FIXTURES.
2. ALL EMERGENCY LIGHTING FIXTURES SHALL BE CAPABLE OF BEING SWITCHED ON OR OFF UNLESS INDICATED TO BE A NIGHT LIGHT.

SHEET NOTES

- WIRING NOTES**
1. PROVIDE A 2 LAMP EMERGENCY BATTERY BALLAST UNIT IN FIXTURE. EXTEND A LOCAL UNSWITCHED LIGHTING CIRCUIT TO BATTERY UNIT. BALLAST SHALL COMPLY WITH LIGHTING FIXTURE SCHEDULE NOTE #5.
 2. PROVIDE TYPE 'W' LIGHTING FIXTURES IN COVE OF SKYLIGHT. PROVIDE IN LENGTHS AS REQUIRED FOR CONTINUOUS END-TO-END FIT.
 3. LOCATE TYPE 'N' LIGHTING FIXTURES ON TOP OF RING AND AIM AT HANGING SCULPTURE.
 4. ROUTE CIRCUITING TO PANEL THRU LIGHTING CONTACTOR 'a'.
 5. PROVIDE ROUTE #W302L TIME CLOCK IN NEMA 1 ENCLOSURE FOR CONTROL OF SKYLIGHTS. ROUTE CIRCUITING TO PANEL THRU TIME CLOCK.

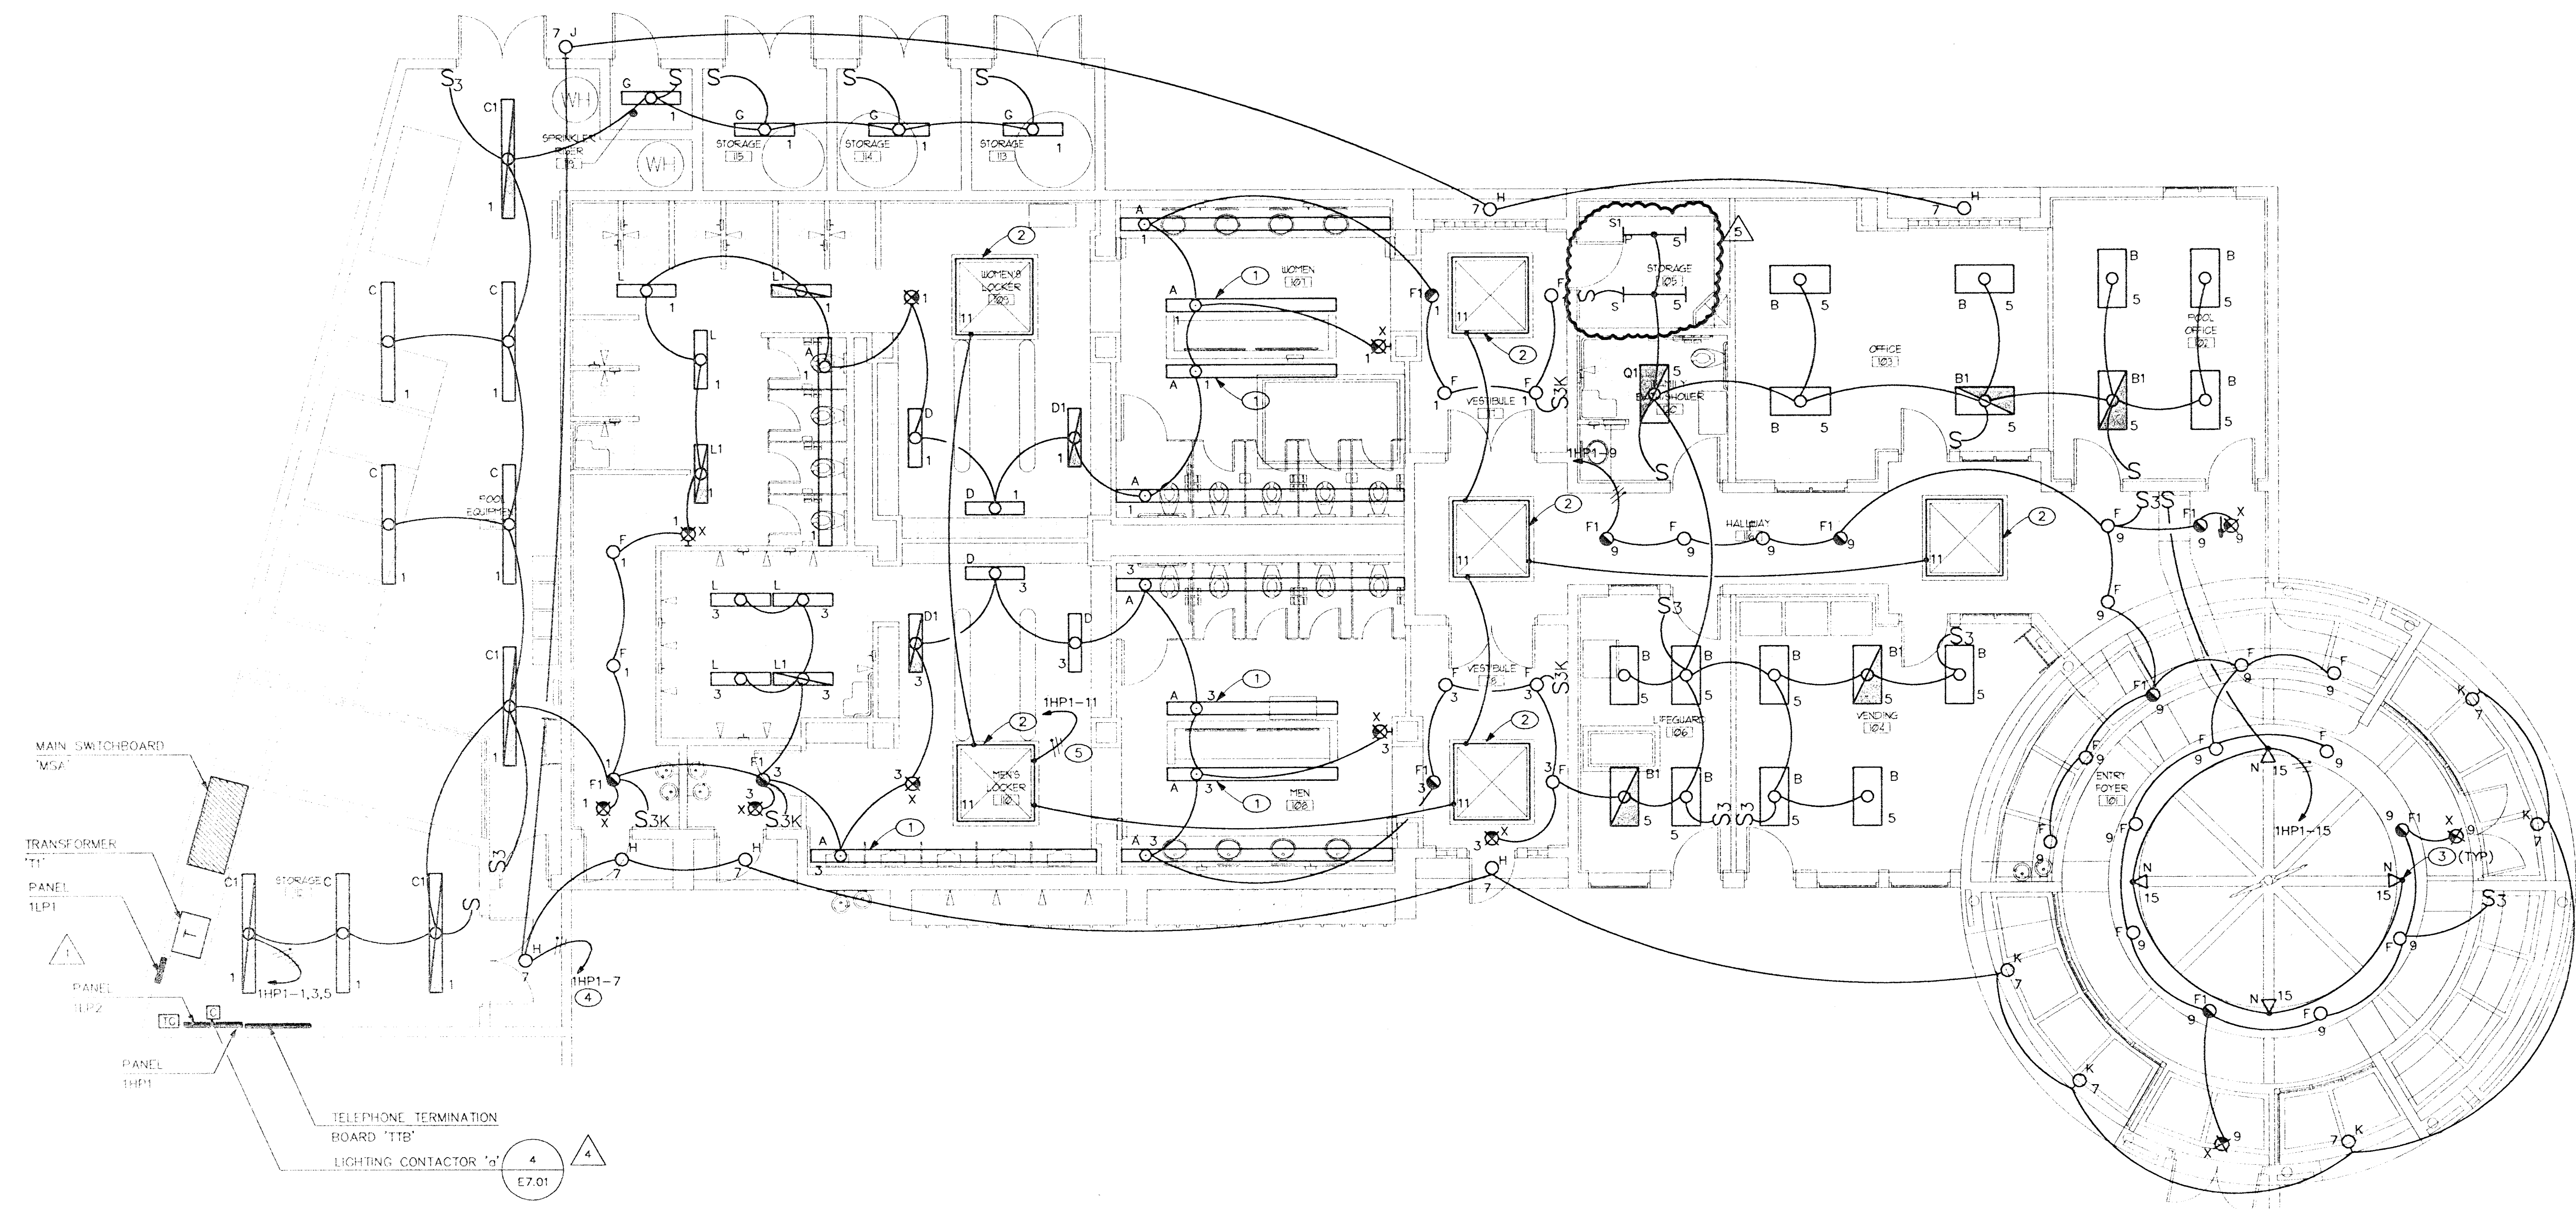

LIGHTING PLAN

SCALE: 3/16" = 1' - 0"

APPROVAL IS FOR CLOUDED
AREAS OR LATEST REVISIONS
ONLY. SEE ORIGINALS FOR
OTHER REQUIREMENTS.

PLANS APPROVED
ELECTRICAL
Building & Safety Dept.
City of Las Vegas, Nevada

DRM: OCT 09 2001

Does Not Include Structural, Architectural,
Plumbing/Mechanical or Off-Site
Improvements. Make No Change
Without Approval. Plan is
Not a Permit to Violate Any Ordinance

LIGHTING PLAN

SUMMERLIN ARBORS PARK
POOL AND POOL BUILDING

	11-3-99	PLAN CHECK COMMENTS
1	02-08-01	ADDENDUM #2
4		

Revisions: 10/01/01 MISCELLANEOUS REVISIONS

Date: 10-22-99

Project No. 98035-00

Scale: 3/16" = 1' - 0"

Sheet Number:

20

No 387023
RECEIVED
 OCT 08 2001
 CITY OF LAS VEGAS
 GENERAL PERMITS

E201