



HPFC Mon Dec 06 16:42:13 1999 e201.dwg XEROX 8830 HP-GL/2 - Version 1.5

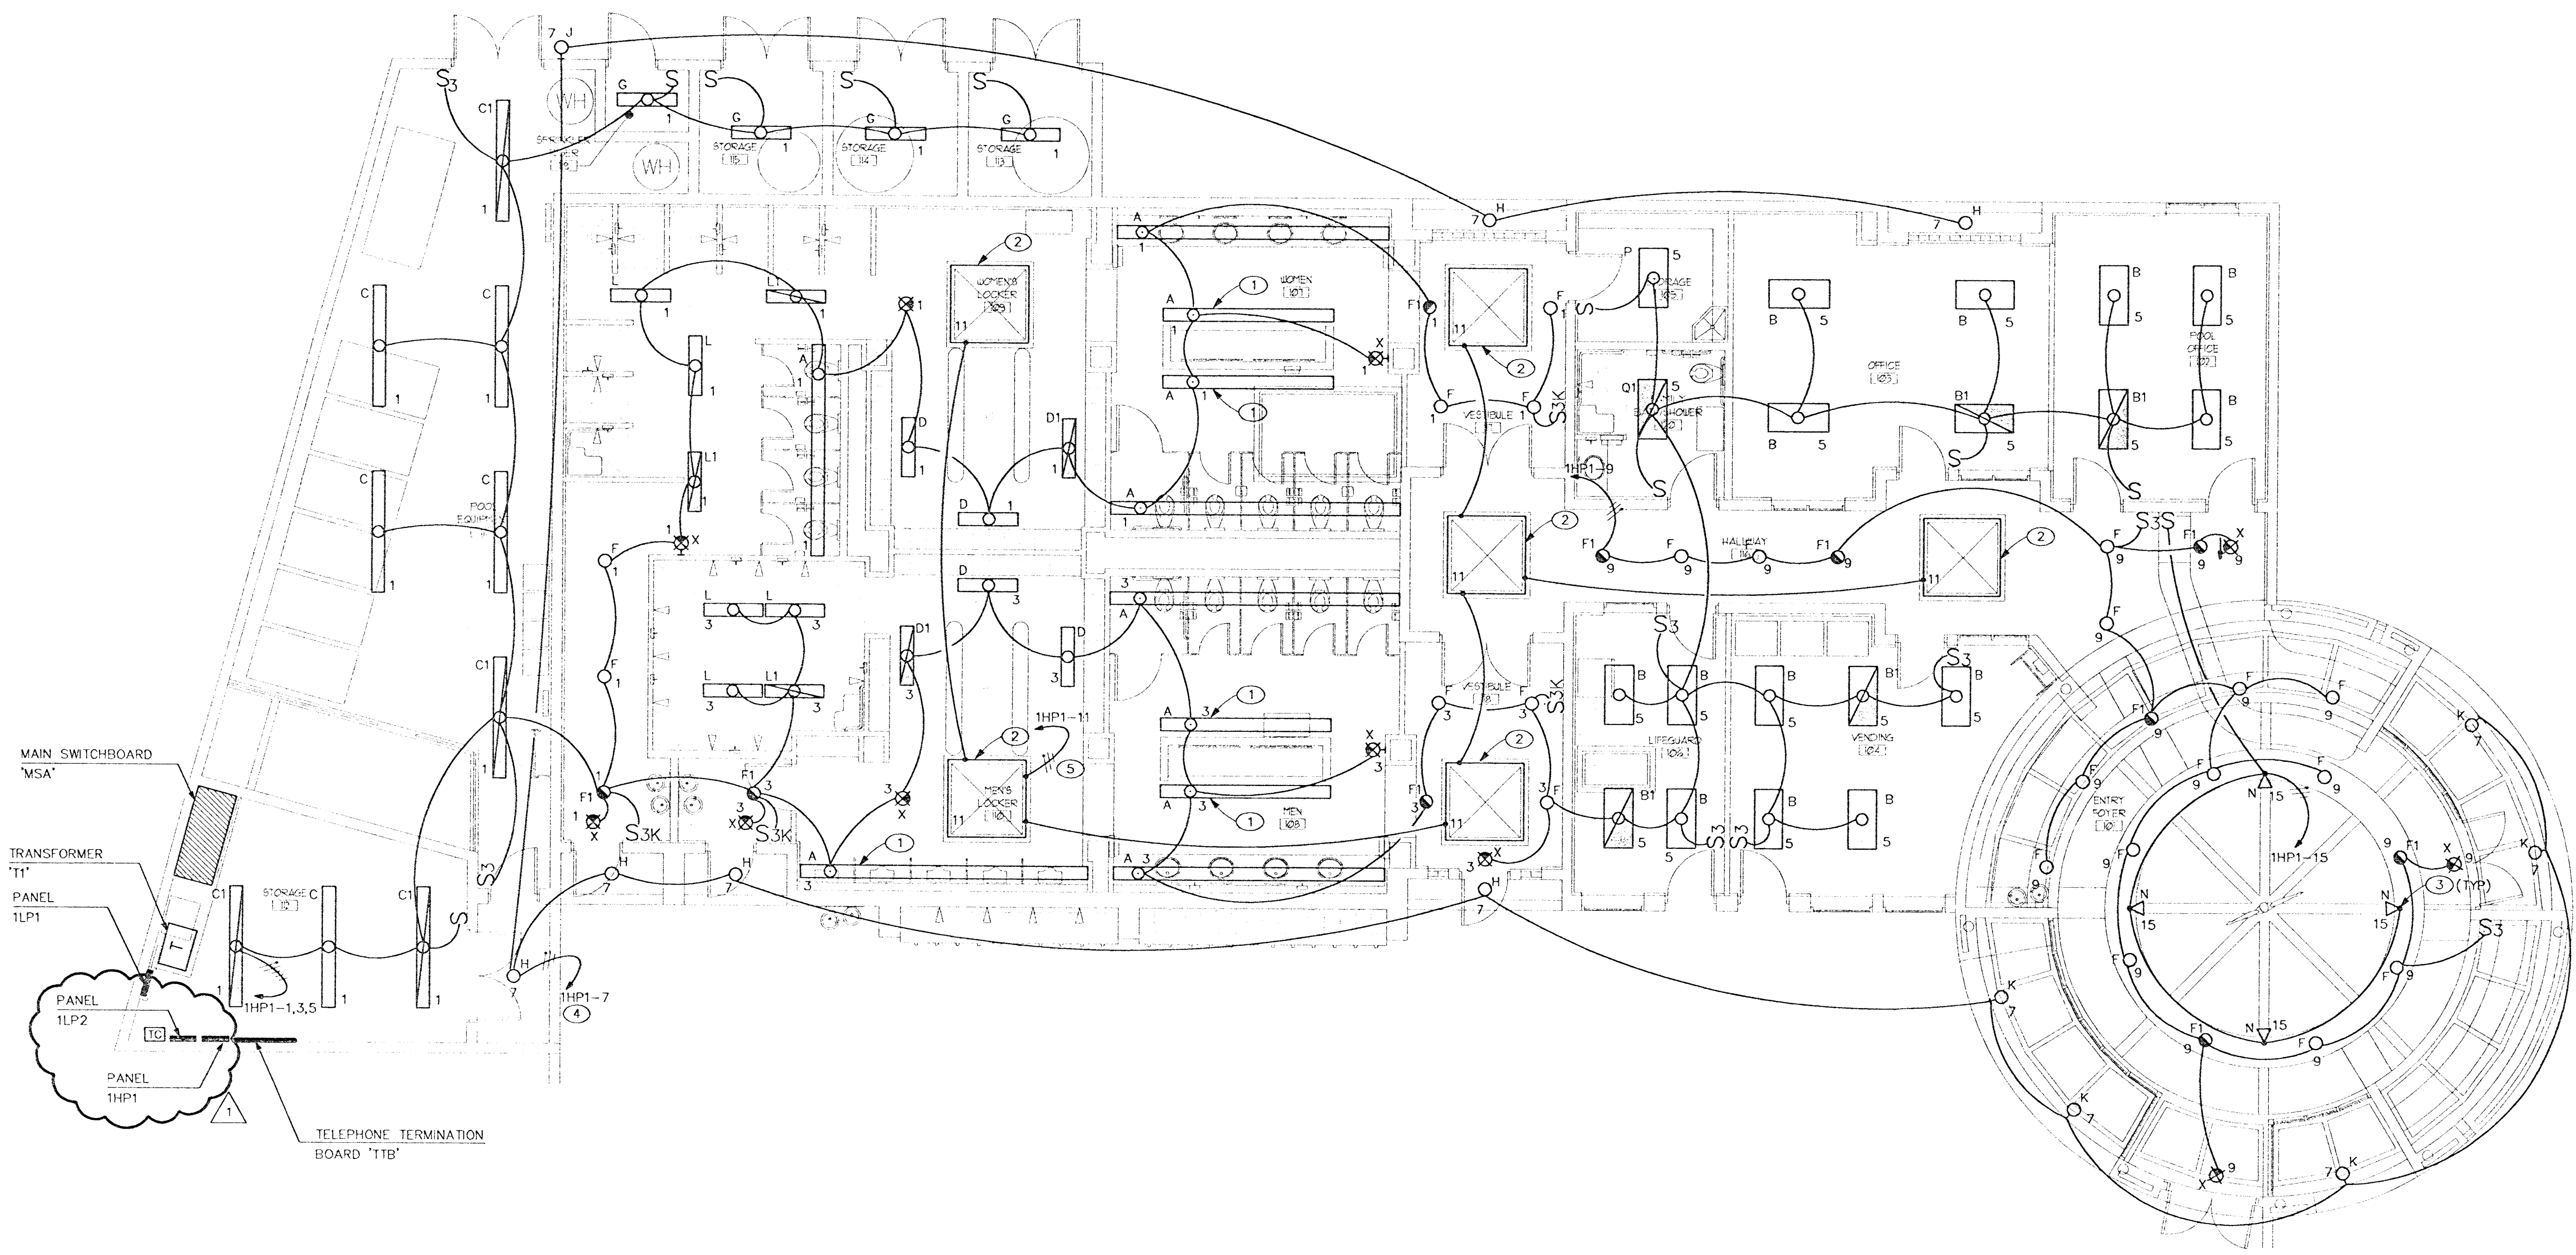

LIGHTING PLAN
SCALE: 3/16" = 1' - 0"

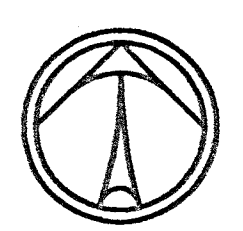

GENERAL NOTES

1. REFER TO ARCHITECTURAL REFLECTED CEILING PLAN FOR EXACT LOCATION OF ALL LIGHTING FIXTURES.
2. ALL EMERGENCY LIGHTING FIXTURES SHALL BE CAPABLE OF BEING SWITCHED ON OR OFF UNLESS INDICATED TO BE A NIGHT LIGHT.

SHEET NOTES

1. PROVIDE A 2 LAMP EMERGENCY BATTERY BALLAST UNIT IN FIXTURE. EXTEND A LOCAL UNSWITCHED LIGHTING CIRCUIT TO BATTERY UNIT. BALLAST SHALL COMPLY WITH LIGHTING FIXTURE SCHEDULE NOTE #5.
2. PROVIDE TYPE 'M' LIGHTING FIXTURES IN COVE OF SKYLIGHT. PROVIDE IN LENGTHS AS REQUIRED FOR CONTINUOUS END-TO-END FIT.
3. LOCATE TYPE 'N' LIGHTING FIXTURES ON TOP OF RING AND AIM AT HANGING SCULPTURE.
4. PROVIDE TORK #W302L TIME CLOCK IN NEMA 1 ENCLOSURE FOR CONTROL OF EXTERIOR LIGHTS. ROUTE CIRCUITING TO PANEL THRU TIME CLOCK.
5. PROVIDE TORK #W302L TIME CLOCK IN NEMA 1 ENCLOSURE FOR CONTROL OF SKYLIGHTS. ROUTE CIRCUITING TO PANEL THRU TIME CLOCK.

PLANS APPROVED
ELECTRICAL
Building & Safety Dept.
City of Las Vegas, Nevada
Date: 12-22-99
Project No. 99035-00
Scale: 3/16" = 1'-0"
Drawn By: DEF.

HARRIS
PROJECT NO. 99035-00
DESIGNED BY: D. HARRIS
CHECKED BY: D. HARRIS
DRAWN BY: D. HARRIS

LIGHTING PLAN

SUMMERLIN ARBORS PARK
POOL AND POOL BUILDING

RECEIVED
DEC - 7 1999
CITY OF LAS VEGAS
CENTRAL PERMITS

Revisions:
11-3-99
PLAN CHECK
COMMENTS

Sheet Number: **E201**

500 PILOT ROAD, SUITE A, LAS VEGAS, NEVADA 89119 • PHONE (702) 283-7111 FAX (702) 283-8111