


- NOTES:
1. EACH SYSTEM PROVIDING HEATING AND COOLING AIR SHALL BE EQUIPPED WITH ONE IONIZATION TYPE SHUTOFF SMOKE DETECTOR, UNLESS INDICATED OTHERWISE ON THE FLOOR PLANS OR EQUIPMENT SCHEDULE.
 2. THE SMOKE DETECTOR SHALL BE LOCATED IN THE MAIN SUPPLY AIR DUCT AHEAD OF ANY BRANCH TAKEOFFS.
 3. ACTIVATION OF A SMOKE DETECTOR SHALL CAUSE THE AIR-MOVING EQUIPMENT IT IS CONNECTED TO AUTOMATICALLY SHUT DOWN. THE GLOBAL SHUTDOWN OF ALL AIR MOVING EQUIPMENT IS NOT REQUIRED.
 4. DIVISION 16 CONTRACTOR SHALL PROVIDE DUCT SMOKE DETECTORS AND SUPPLY THEM TO THE DIVISION 15 CONTRACTOR FOR INSTALLATION IN DUCTWORK. ALL WIRING SHALL BE DONE IN ACCORDANCE WITH THE NEC AND DIVISION 16 SECTION OF THE SPECIFICATION. FIRE ALARM MONITORING WIRING, POWER WIRING TO SMOKE DETECTOR, AND INTERLOCK WIRING BETWEEN SMOKE DETECTOR AND AC UNIT SHALL BE THE RESPONSIBILITY OF THE DIVISION 16 CONTRACTOR.
 5. DIVISION 16 CONTRACTOR SHALL PROVIDE AND INSTALL AN INDICATOR LIGHT IN A VISIBLE AND ACCESSIBLE LOCATION, LABELED TO INDICATE FUNCTION AND UNIT SERVED, PER NFPA 72 AND SECTION 5-10.6.8 (IF NO FIRE ALARM SYSTEM IS INSTALLED).
 6. DIVISION 16 CONTRACTOR SHALL PROVIDE AND INSTALL AN AUDIBLE SIGNAL IN AN OCCUPIED AREA WHEN SMOKE DETECTOR IS ACTIVATED, PER NFPA 90A SECTION 4-4.4.3 (IF NO FIRE ALARM SYSTEM IS INSTALLED).

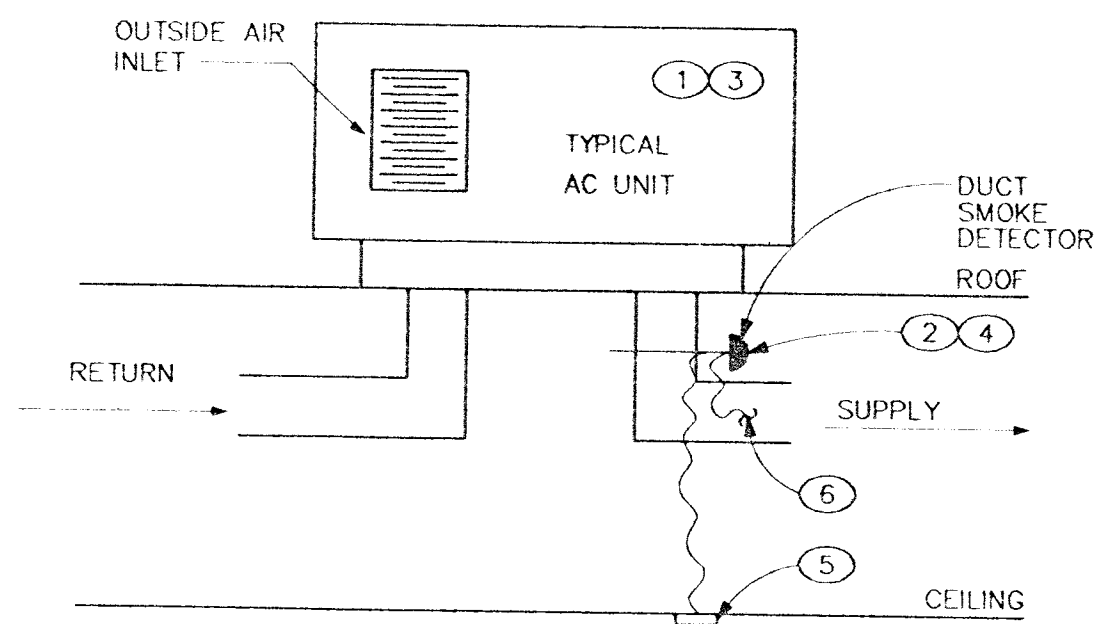

DETAIL # 1 - SMOKE DETECTOR DIAGRAM

NOT TO SCALE

DETAIL # 2 - ROOFTOP HVAC EQUIPMENT DIAGRAM (TYP.)

NOT TO SCALE

DETAIL # 3 - OUTLET ORIENTATION

NOT TO SCALE

DETAIL # 4 - NOT USED

NOT TO SCALE

DETAIL # 5 - NOT USED

NOT TO SCALE

DETAIL # 6 - NOT USED

NOT TO SCALE

DETAIL # 7 - NOT USED

NOT TO SCALE

DETAIL # 8 - NOT USED

NOT TO SCALE

DETAIL # 9 - NOT USED


NOT TO SCALE

DETAIL # 10 - NOT USED

NOT TO SCALE


DETAIL # 11 - NOT USED

DETAIL # 12 - NOT USED

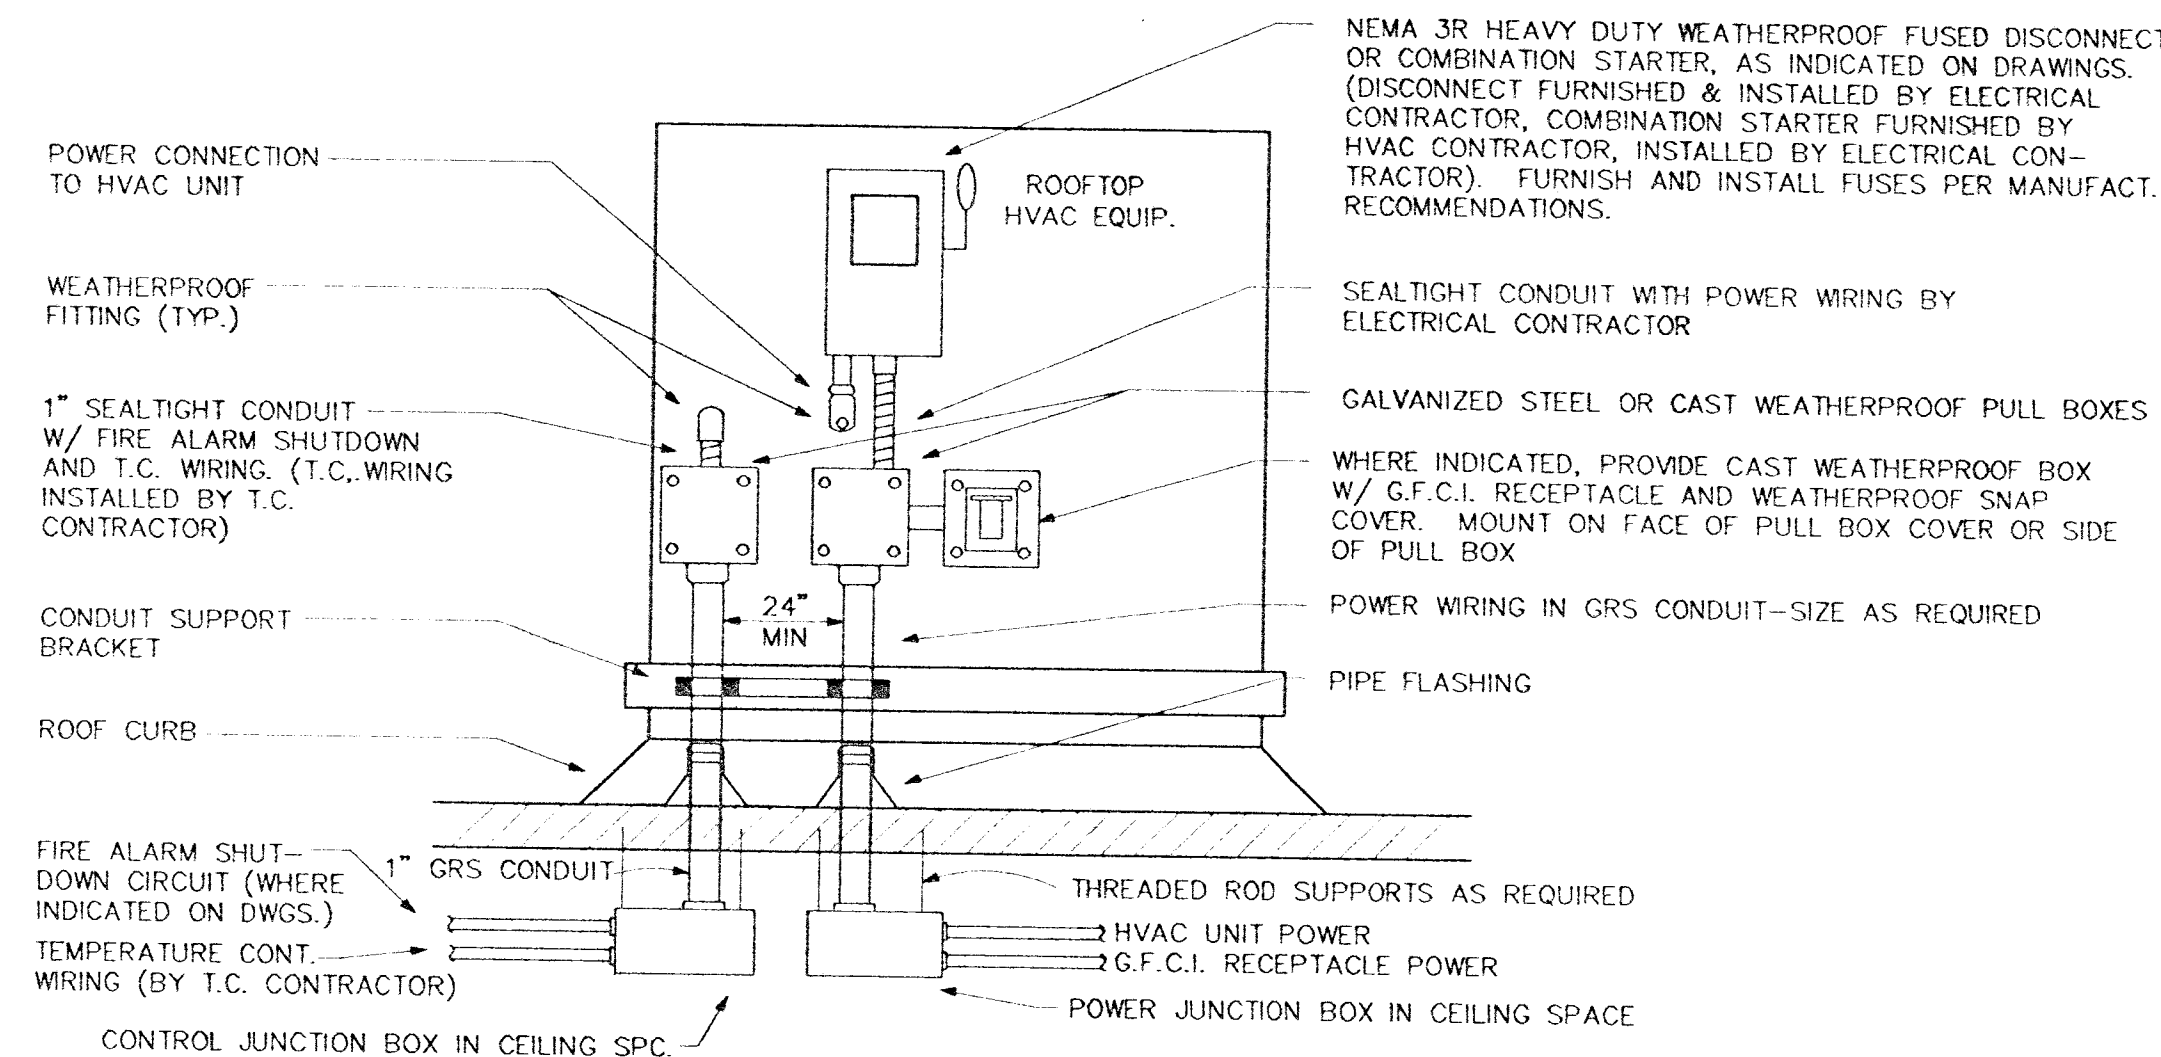

NOTES:

1. WIRING TO THE ROOFTOP HVAC EQUIPMENT SHALL EXTEND THROUGH THE ROOF IN CONDUITS LOCATED OUTSIDE OF THE EQUIPMENT ROOF CURB AS SHOWN, UNLESS OTHERWISE SPECIFICALLY ALLOWED BY THE UNIT MANUFACTURER.
2. WIRING RUN INSIDE THE HVAC EQUIPMENT SHALL BE ACCOMPLISHED IN A MANNER ACCEPTABLE WITH THE UNIT MANUFACTURER AND SHALL MEET ALL REQUIREMENTS OF THE NATIONAL ELECTRIC CODE.

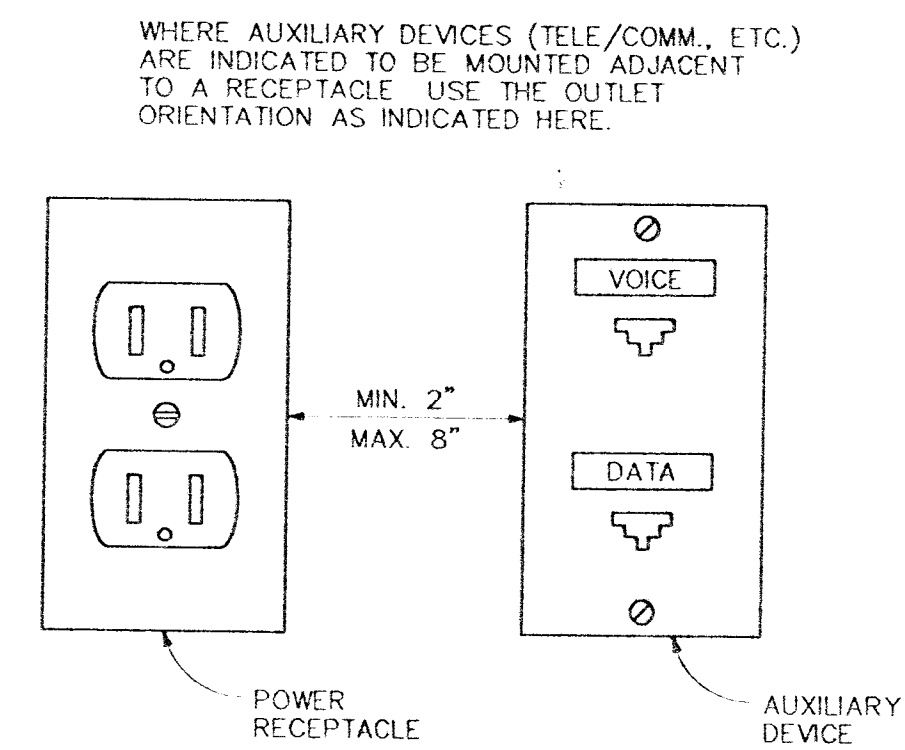

ELECTRICAL
DETAILS

SUMMERLIN ARBORS PARK
POOL AND POOL BUILDING

PLANS APPROVED
ELECTRICAL
DEC 15 1999
DRN
DEC 15 1999
PLANS APPROVED
ELECTRICAL
DEC 15 1999
DRN
DEC 15 1999

Revisions:
Date: 10-22-99
Project No. 9903500
Scale: NO SCALE
Drawn By: KKK

Sheet Number: E7.01