


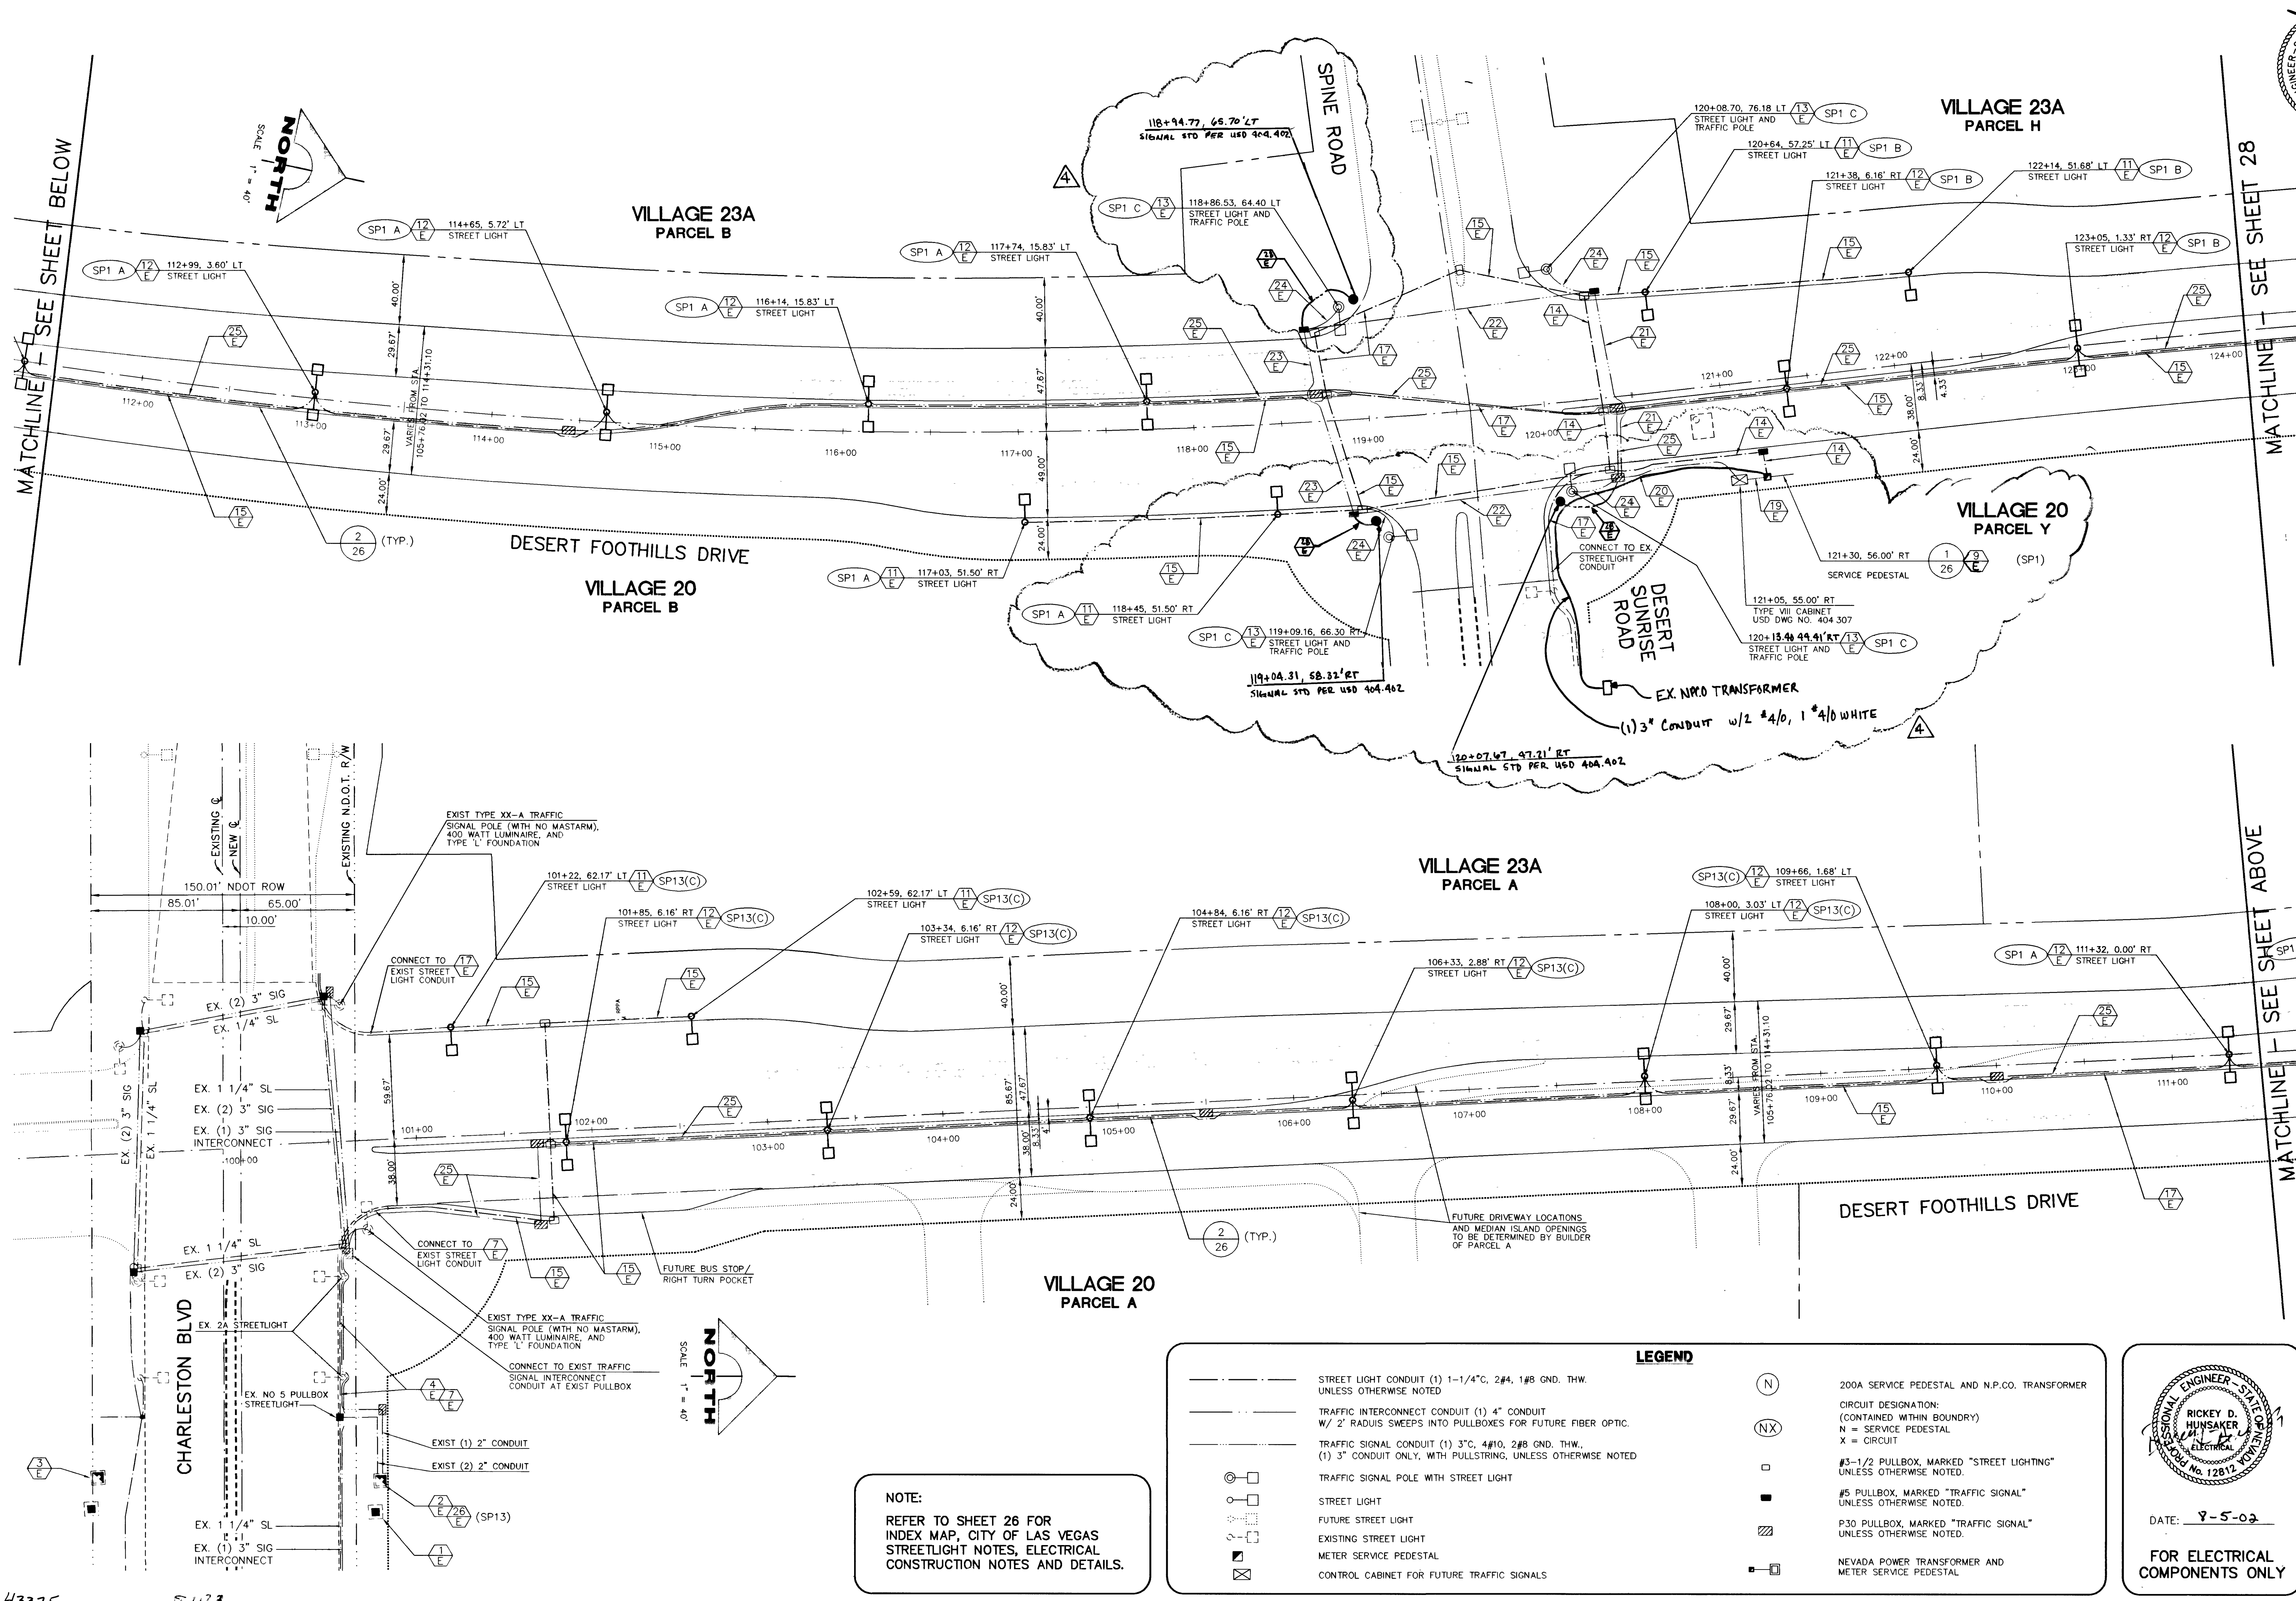

NOTE:
REFER TO SHEET 26 FOR
INDEX MAP, CITY OF LAS VEGAS
STREETLIGHT NOTES, ELECTRICAL
CONSTRUCTION NOTES AND DETAILS.

LEGEND

—	STREET LIGHT CONDUIT (1) 1-1/4", 2#4, 1#8 GND. THW. UNLESS OTHERWISE NOTED
---	TRAFFIC INTERCONNECT CONDUIT (1) 4" CONDUIT W/ 2" RADIUS SWEEPS INTO PULLBOXES FOR FUTURE FIBER OPTIC.
---	TRAFFIC SIGNAL CONDUIT (1) 3", 4#10, 2#8 GND. THW. (1) 3" CONDUIT ONLY, WITH PULLSTRING, UNLESS OTHERWISE NOTED
○	TRAFFIC SIGNAL POLE WITH STREET LIGHT
○	STREET LIGHT
○	FUTURE STREET LIGHT
○	EXISTING STREET LIGHT
■	METER SERVICE PEDESTAL
⊠	CONTROL CABINET FOR FUTURE TRAFFIC SIGNALS

N	200A SERVICE PEDESTAL AND N.P.CO. TRANSFORMER
NX	CIRCUIT DESIGNATION: (CONTAINED WITHIN BOUNDARY) N = SERVICE PEDESTAL X = CIRCUIT
□	#3-1/2 PULLBOX, MARKED "STREET LIGHTING" UNLESS OTHERWISE NOTED.
■	#5 PULLBOX, MARKED "TRAFFIC SIGNAL" UNLESS OTHERWISE NOTED.
⊠	P30 PULLBOX, MARKED "TRAFFIC SIGNAL" UNLESS OTHERWISE NOTED.
⊠	NEVADA POWER TRANSFORMER AND METER SERVICE PEDESTAL

FOR ELECTRICAL COMPONENTS ONLY

DATE: 8-5-02

PROFESSIONAL ENGINEER - SAFETY

RICKEY D. HUNSAKER

12819 WYOMING

DATE: 8-5-02

10/15/03

DATE: 10/15/03

DATE: 10/15/03

DESIGN: SWW
DRAWN: SWW
CHECK: RDH
ISSUE DATE: 10/15/03
ISSUE EDITOR: SWW
PLOT DATE: 08-05-02
PLOT TIME: 14:55:01

G.C. WALLACE, INC.
Engineers/Planners/Surveyors
1555 SOUTH RANDOLPH BLVD./LAS VEGAS, NEVADA 89146
OFFICE: (702) 804-2000, FAX: (702) 804-2295
OFFICE: (702) 804-2160, FAX: (702) 804-2295

SUMMERLIN

VILLAGE 23A DESERT FOOTHILLS DRIVE IMPROVEMENTS

MASTER CONDUIT AND ELECTRICAL PLAN II

SHEET 27

07-V-3605

JOB NO. 62052230