


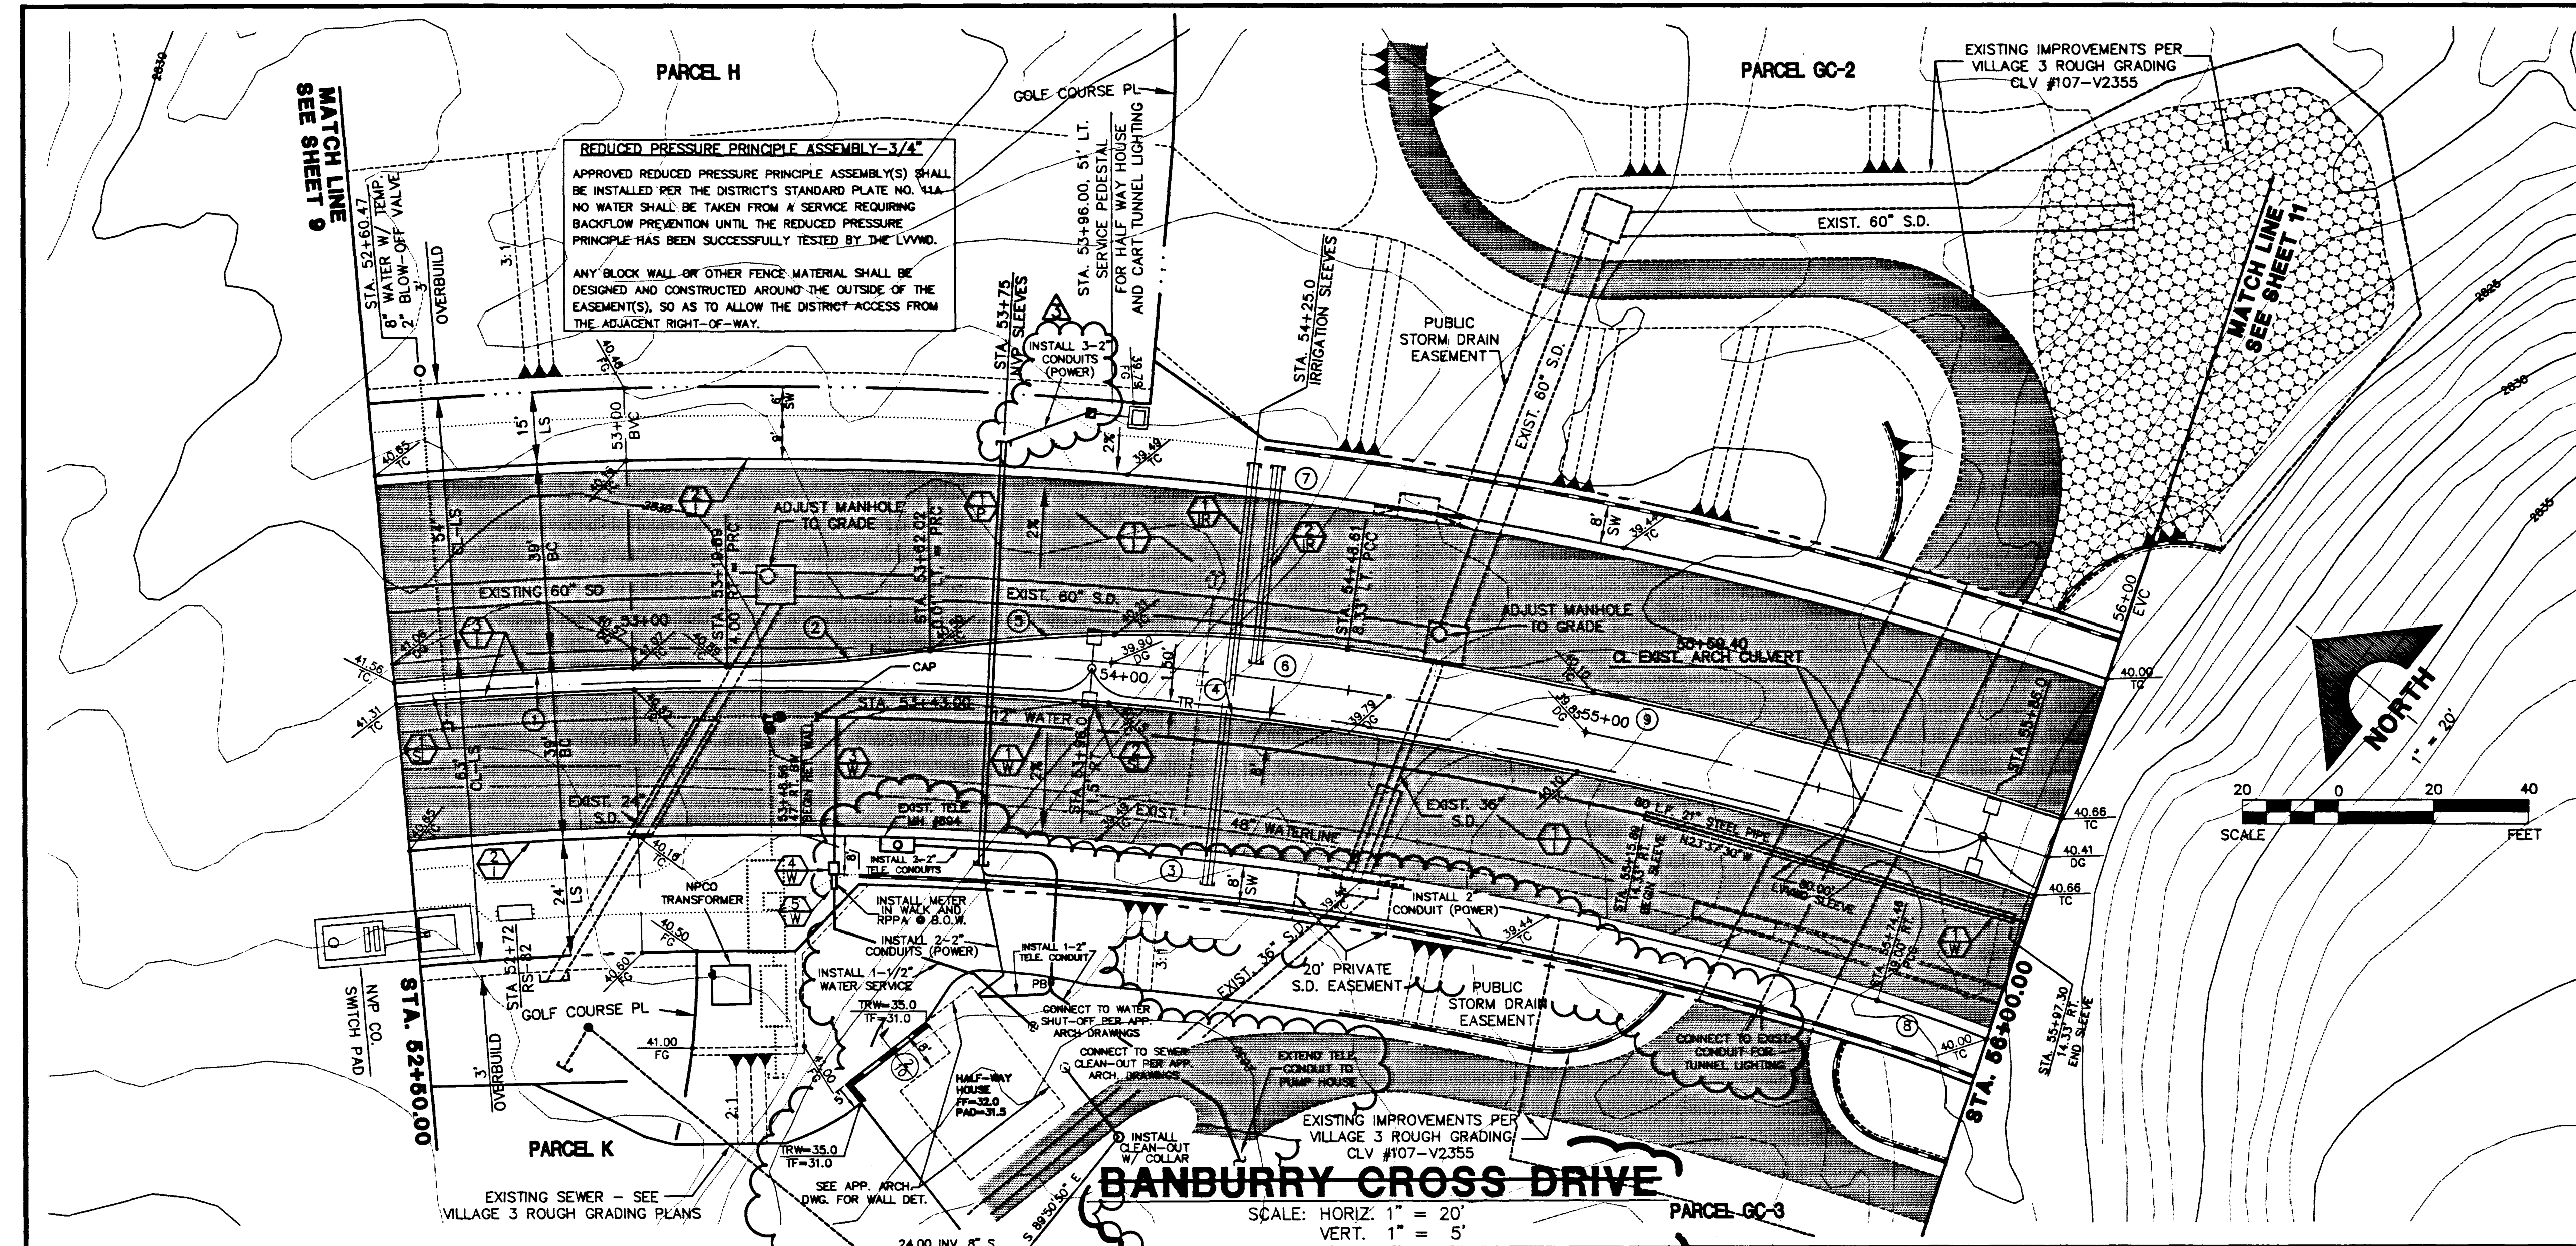

CURVE DATA (1 INDICATES CURVE NUMBER)

CURVE	DELTA	RADIUS	LENGTH	TANGENT
1	04°42'41"	846.00'	89.57'	34.80'
2	08°04'10"	300.00'	42.25'	21.18'
3	21°52'07"	811.00'	309.54'	156.68'
4	23°35'33"	346.57'	175.78'	127.78'
5	18°44'44"	300.00'	87.58'	44.15'
6	23°35'33"	850.00'	350.00'	177.52'
7	23°35'33"	889.00'	366.06'	185.66'
8	04°39'19"	24.37'	12.19'	12.19'
9	10°12'18"	858.33'	152.88'	76.64'

NOTE: CURVE DATA REPRESENTS PARTIAL CURVE, THIS SHEET ONLY.

CONSTRUCTION NOTES

- IMPROVEMENTS**
- 1. INSTALL A.C. PAVEMENT PER STREET SECTIONS, SHEET NO. 25
 - 2. INSTALL "L" TYPE CURB AND GUTTER (S-47)
 - 3. INSTALL "A" TYPE ISLAND CURB (S-50)
- SEWER**
- 1. INSTALL 8" SEWER PIPE (U-20)
 - 2. INSTALL SEWER MANHOLE (S-01-A)
- WATER**
- 1. INSTALL 12" WATER PIPE (U-20)
 - 2. INSTALL 45° BEND AND THRUST BLOCK
 - 3. INSTALL 1" SERVICE PER LVWD STD. PLATE NO. 1B
 - 4. INSTALL 5/8" METER PER LVWD STD. PLATE NO. 1B
 - 5. INSTALL 3/4" R.P.P.A. PER LVWD STD. PLATE NO. 11A
- STREET LIGHTING**
- 1. STREET LIGHT OR COMMON TRENCH, SEE ELECTRICAL PLANS
 - 2. STREET LIGHT, SEE ELECTRICAL PLANS (E-2)
- IRRIGATION**
- 1. BANK "A", 1-6" & 2-4" SDR35 PVC
 - 2. BANK "B", 2-4" SDR35 PVC
- POWER**
- 1. INSTALL (2) 4" CL200 SLEEVES FOR "POWER FEED TO GOLF COURSE HALFWAY HOUSE"

REVISIONS

NO.	DATE	DESCRIPTION	BY	CHKD.
1	10/30/95	EXTEND SERVICE TO P.O.A. BLDG. 5	BERT A. WALLACE	
2	12/20/95	ADD 1" WATER SERVICE, 5/8" WATER METER & 3/4" R.P.P.A. ADD NEVADA POWER SLEEVES	BERT A. WALLACE	
3	12/20/95	REVISE PIPE CASING DETAIL, METER, CONFIRM AND ADD 8" WATER	BERT A. WALLACE	

RECOMMENDED BY: BERT A. WALLACE, INC. ENGINEER

DATE: 7/16/96

PROJECT: BANBURY CROSS DRIVE

LOCATION: 1555 SOUTH RANCHO BLVD. LAS VEGAS, NEVADA 89102

