
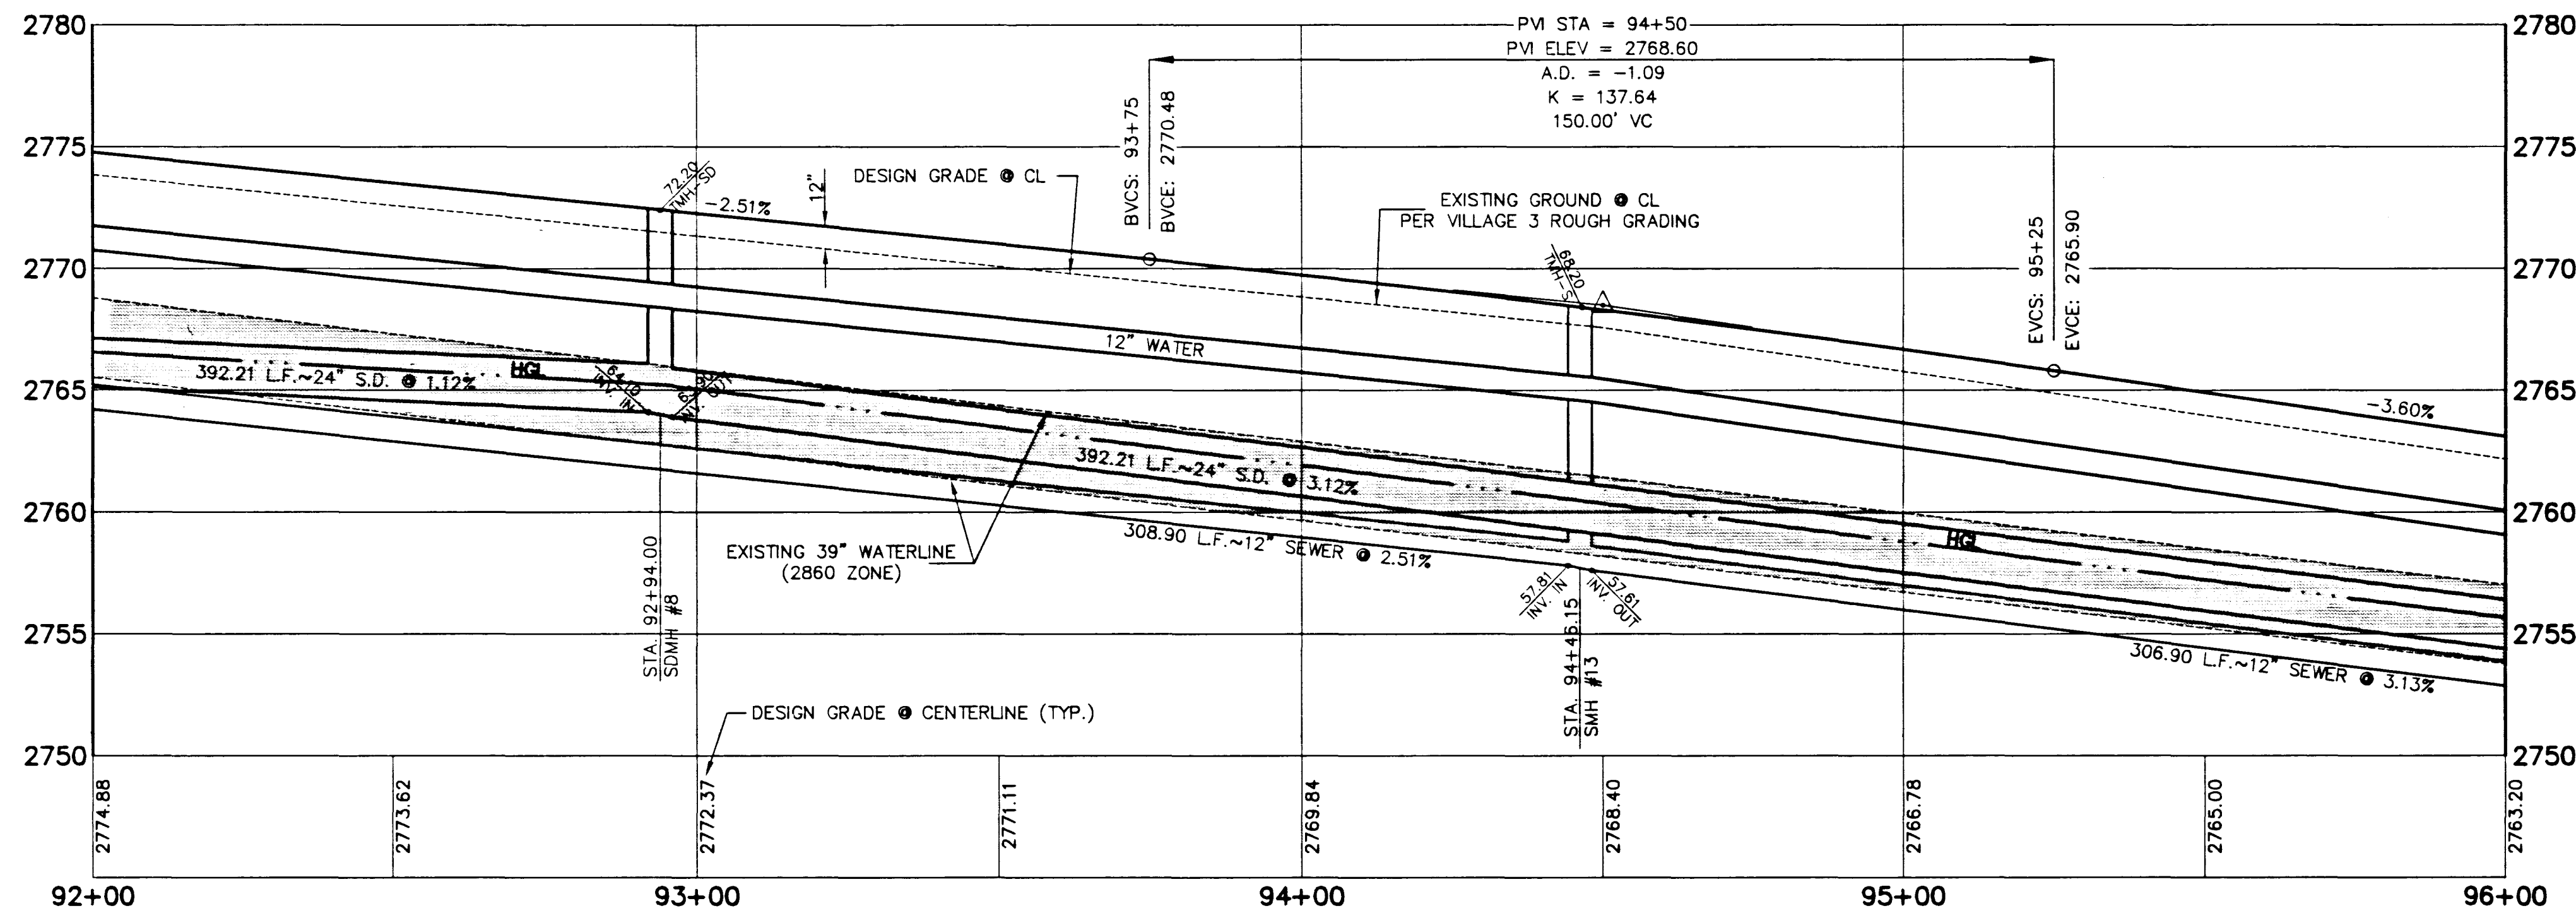


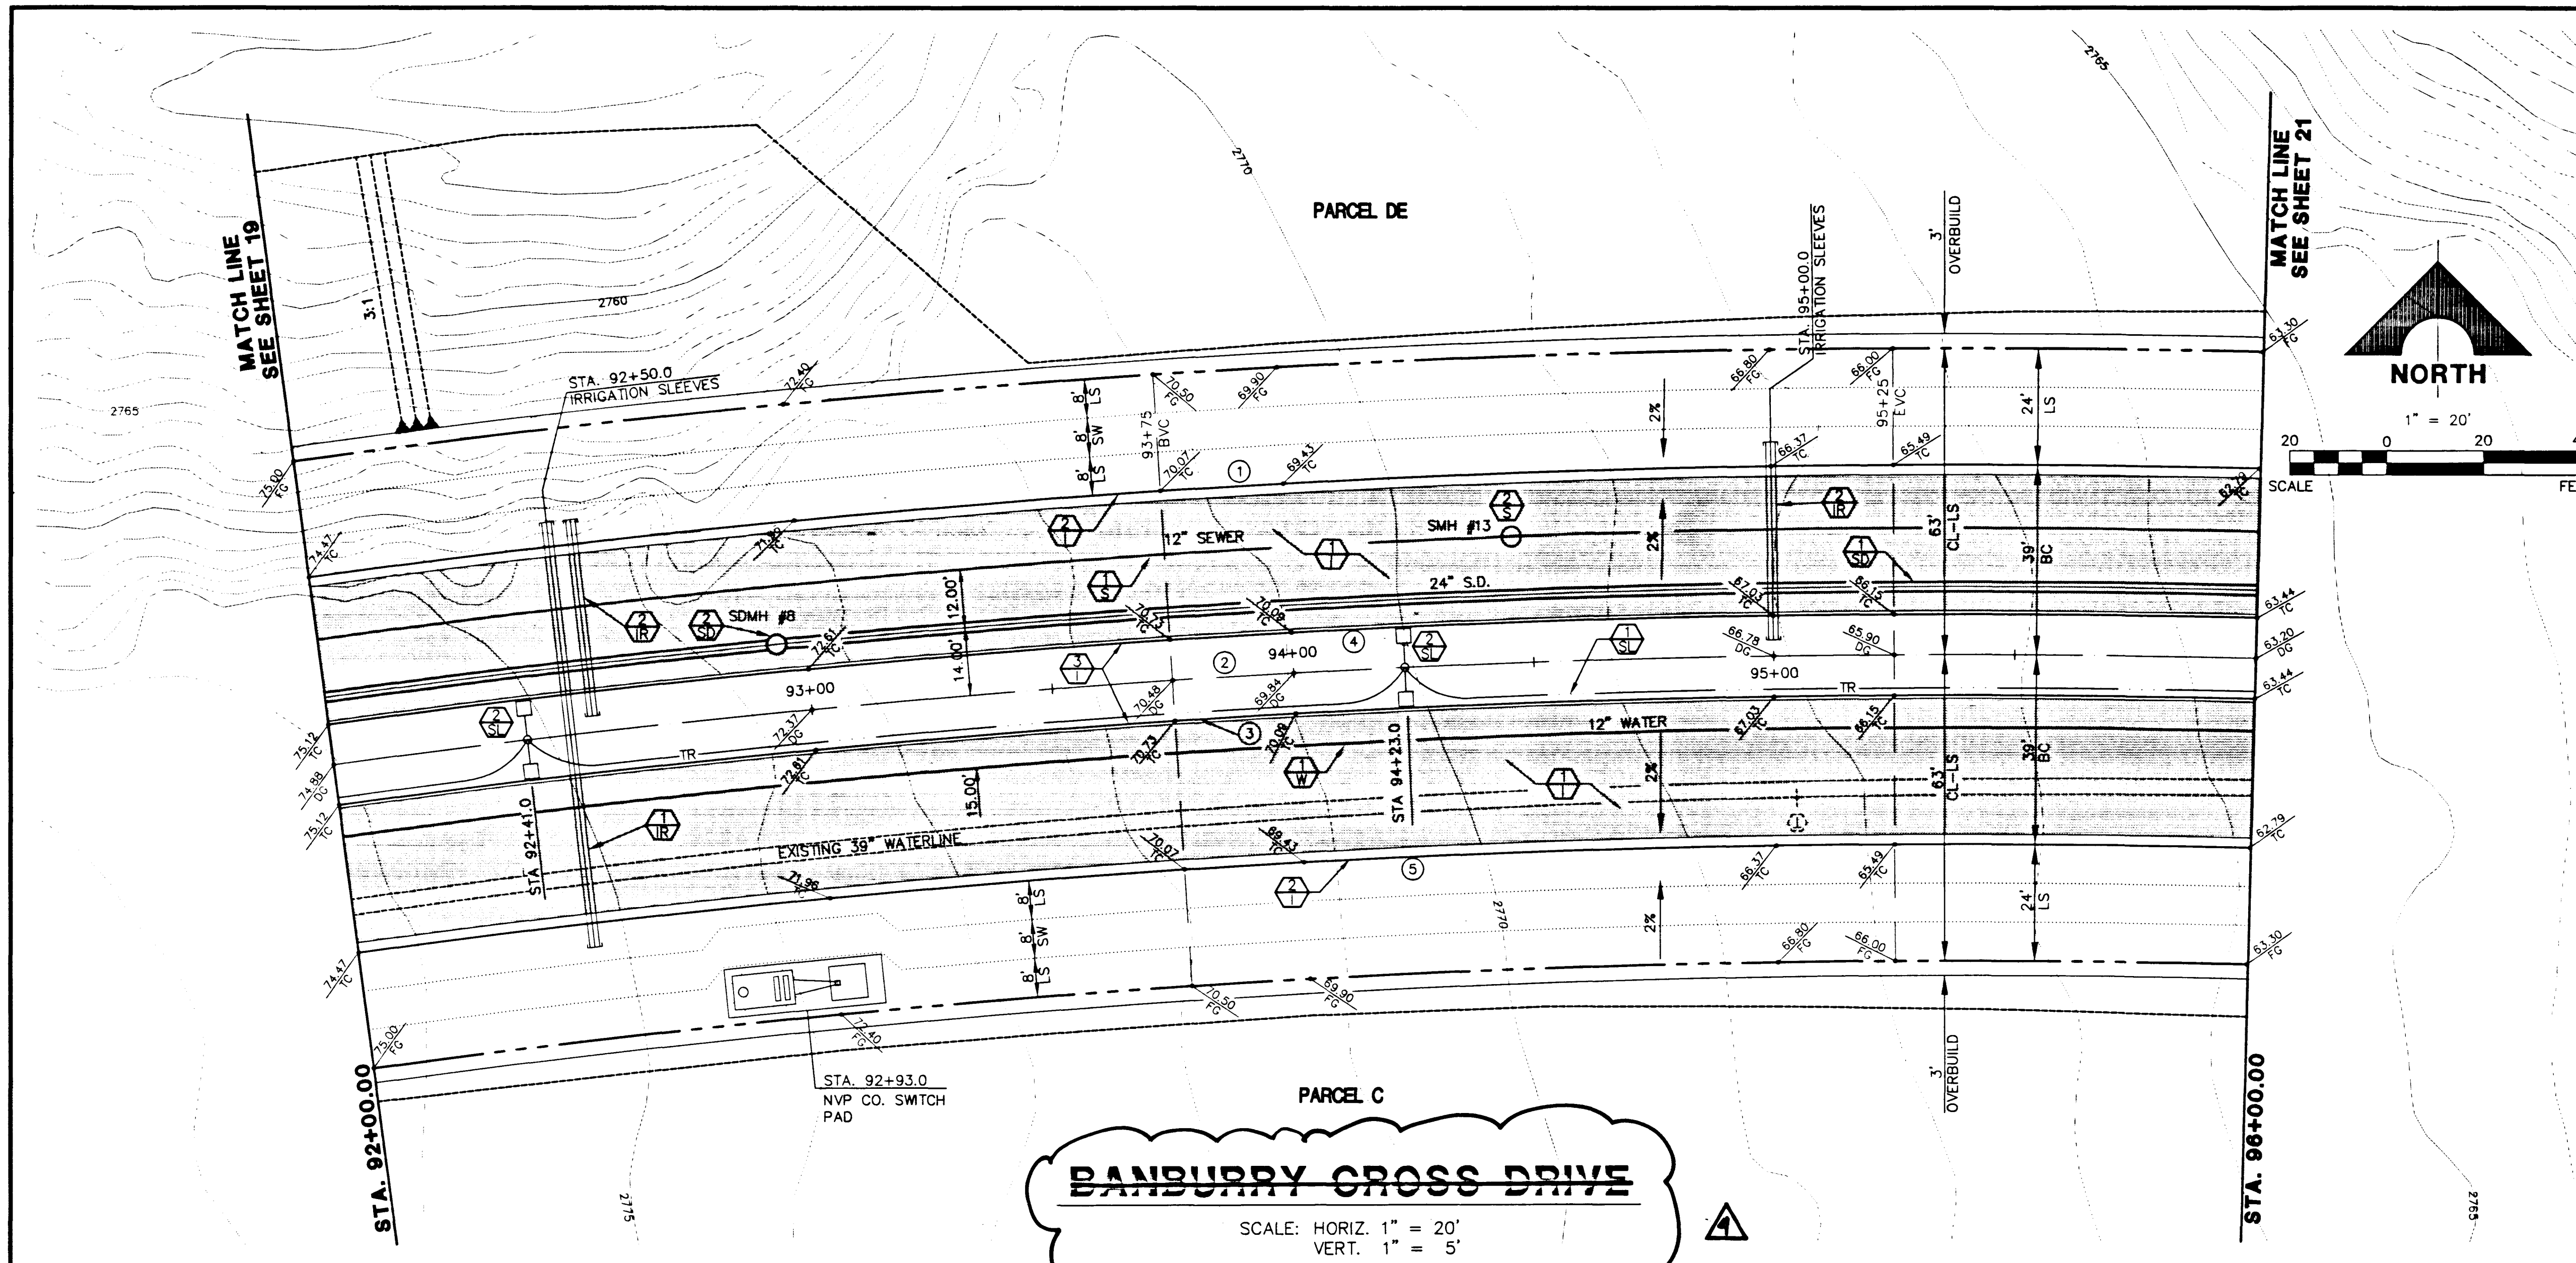


CURVE DATA ① INDICATES CURVE NUMBER

CURVE	DELTA	RADIUS	LENGTH	TANGENT
1	99°10'20"	2539.00'	406.46'	203.66'
2	99°10'20"	2500.00'	400.21'	200.54'
3	99°10'20"	2491.67'	398.84'	199.87'
4	99°10'20"	2508.33'	401.55'	201.20'
5	99°10'20"	2461.00'	393.97'	197.41'

NOTE: CURVE DATA REPRESENTS PARTIAL CURVE, THIS SHEET ONLY.

CONSTRUCTION NOTES

- IMPROVEMENTS**
- INSTALL A.C. PAVEMENT PER STREET SECTIONS, SHEET NO. 25
 - INSTALL "L" TYPE CURB AND GUTTER (S-47)
 - INSTALL "A" TYPE ISLAND CURB (S-50)
- SEWER**
- INSTALL 12" SEWER PIPE (U-20)
 - INSTALL SEWER MANHOLE (SD1-8 GLV)
- WATER**
- INSTALL 12" WATER PIPE (U-20)
- STORM DRAIN**
- INSTALL 24" STORM DRAIN PIPE (1350-D) (U-20)
 - INSTALL TYPE II STORM DRAIN MANHOLE (D1-2)
- STREET LIGHTING**
- STREET LIGHT OR COMMON TRENCH, SEE ELECTRICAL PLANS
 - STREET LIGHT, SEE ELECTRICAL PLANS (E-2)
- IRRIGATION**
- BANK "A", 1-6" & 2-4" SDR35 PVC
 - BANK "B", 2-4" SDR35 PVC

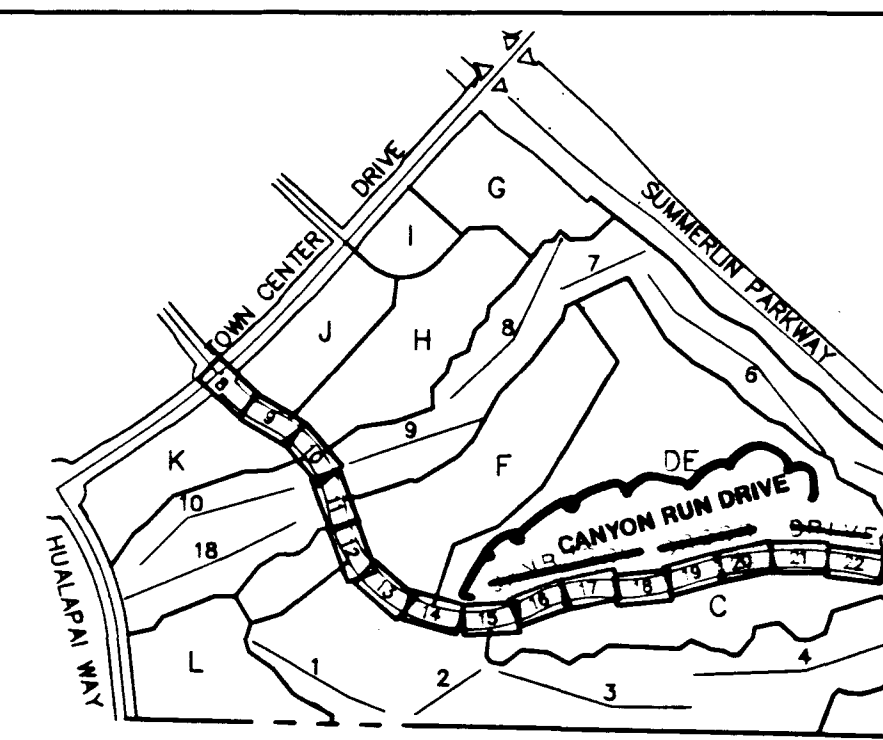

APPROVAL:

12/11/95
LAS VEGAS VALLEY WATER DISTRICT

11/01/95

SUMMERLIN

VILLAGE 3
BANBURY CROSS DRIVE
PLAN AND PROFILE
STA. 92+00.00 TO STA. 96+00.00

SHEET

20

SHT 20 OF 25

107-V2426

