

MATCH LINE
SEE SHEET 17

STA. 96+00.00

MATCH LINE
SEE SHEET 19

STA. 100+00.00

BANDURRY CROSS DRIVE
SCALE: HORIZ. 1" = 20'
VERT. 1" = 5'

CANYON RUN DRIVE

CURVE DATA

CURVE	DELTA	RADIUS	LENGTH	TANGENT
1	03°00'59"	2491.67	131.18	65.60
2	101°19'13"	300.00	54.04	27.09
3	09°09'45"	2461.00	393.55	197.20
4	09°09'45"	2500.00	399.79	200.32
5	09°09'45"	2508.33	401.12	200.99
6	09°09'45"	2539.00	406.03	203.45
7	13°06'57"	300.00	68.67	34.49
8	03°21'03"	2504.00	146.44	73.24

NOTE: CURVE DATA REPRESENTS PARTIAL CURVE, THIS SHEET ONLY.

CONSTRUCTION NOTES

IMPROVEMENTS

- INSTALL A.C. PAVEMENT PER STREET SECTIONS, SHEET NO. 25
- INSTALL "L" TYPE CURB AND GUTTER (S-47)
- INSTALL "A" TYPE ISLAND CURB (S-50)

SEWER

- INSTALL 12" SEWER PIPE (U-20)
- INSTALL SEWER MANHOLE (S-51)

WATER

- INSTALL 12" WATER PIPE (U-20)
- INSTALL 8" WATER PIPE (U-20)
- INSTALL 8" GATE VALVE (U-34)
- INSTALL FIRE HYDRANT ASSEMBLY (U-33)
- INSTALL TEMPORARY 2" BLOW-OFF VALVE (U-32)
- INSTALL 12" X 8" ELBOW
- INSTALL 8" X 8" X 6" TEE

STORM DRAIN


- INSTALL 24" STORM DRAIN PIPE (1350-D) (U-20)
- INSTALL TYPE II STORM DRAIN MANHOLE (DT-2)

STREET LIGHTING

- STREET LIGHT OR COMMON TRENCH, SEE ELECTRICAL PLANS
- STREET LIGHT, SEE ELECTRICAL PLANS (E-2)

IRRIGATION

- BANK "A", 1-6" & 2-4" SDR35 PVC
- BANK "B", 2-4" SDR35 PVC

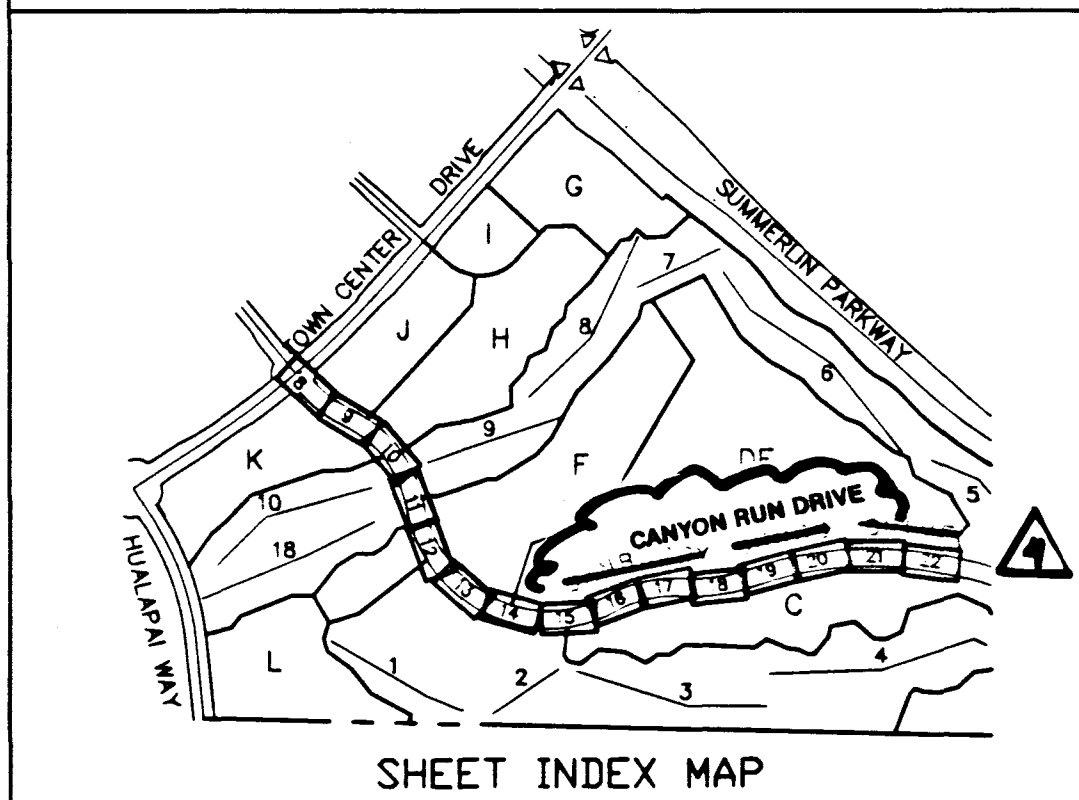

APPROVAL:
10/20/95
12/2/95
LAS VEGAS VALLEY WATER DISTRICT

8/19/95 STREET NAME CHANGE
12/2/95 REVISE PROFILE OVER EX. WATER MAIN
G.C. WALLACE, INC.
Engineering/Architecture 1555 SOUTH RAINBOW BLVD./LAS VEGAS, NEVADA 89102

SUMMERLIN
VILLAGE 3
BANDURRI CROSS DRIVE
PLAN AND PROFILE
STA. 96+00.00 TO STA. 100+00.00

SHEET
21
SHT 21 OF 25

JOB NO. 62003.205

8/19/95 8:00PM-31 DVG 12/2/95

9799

107-V7421

