
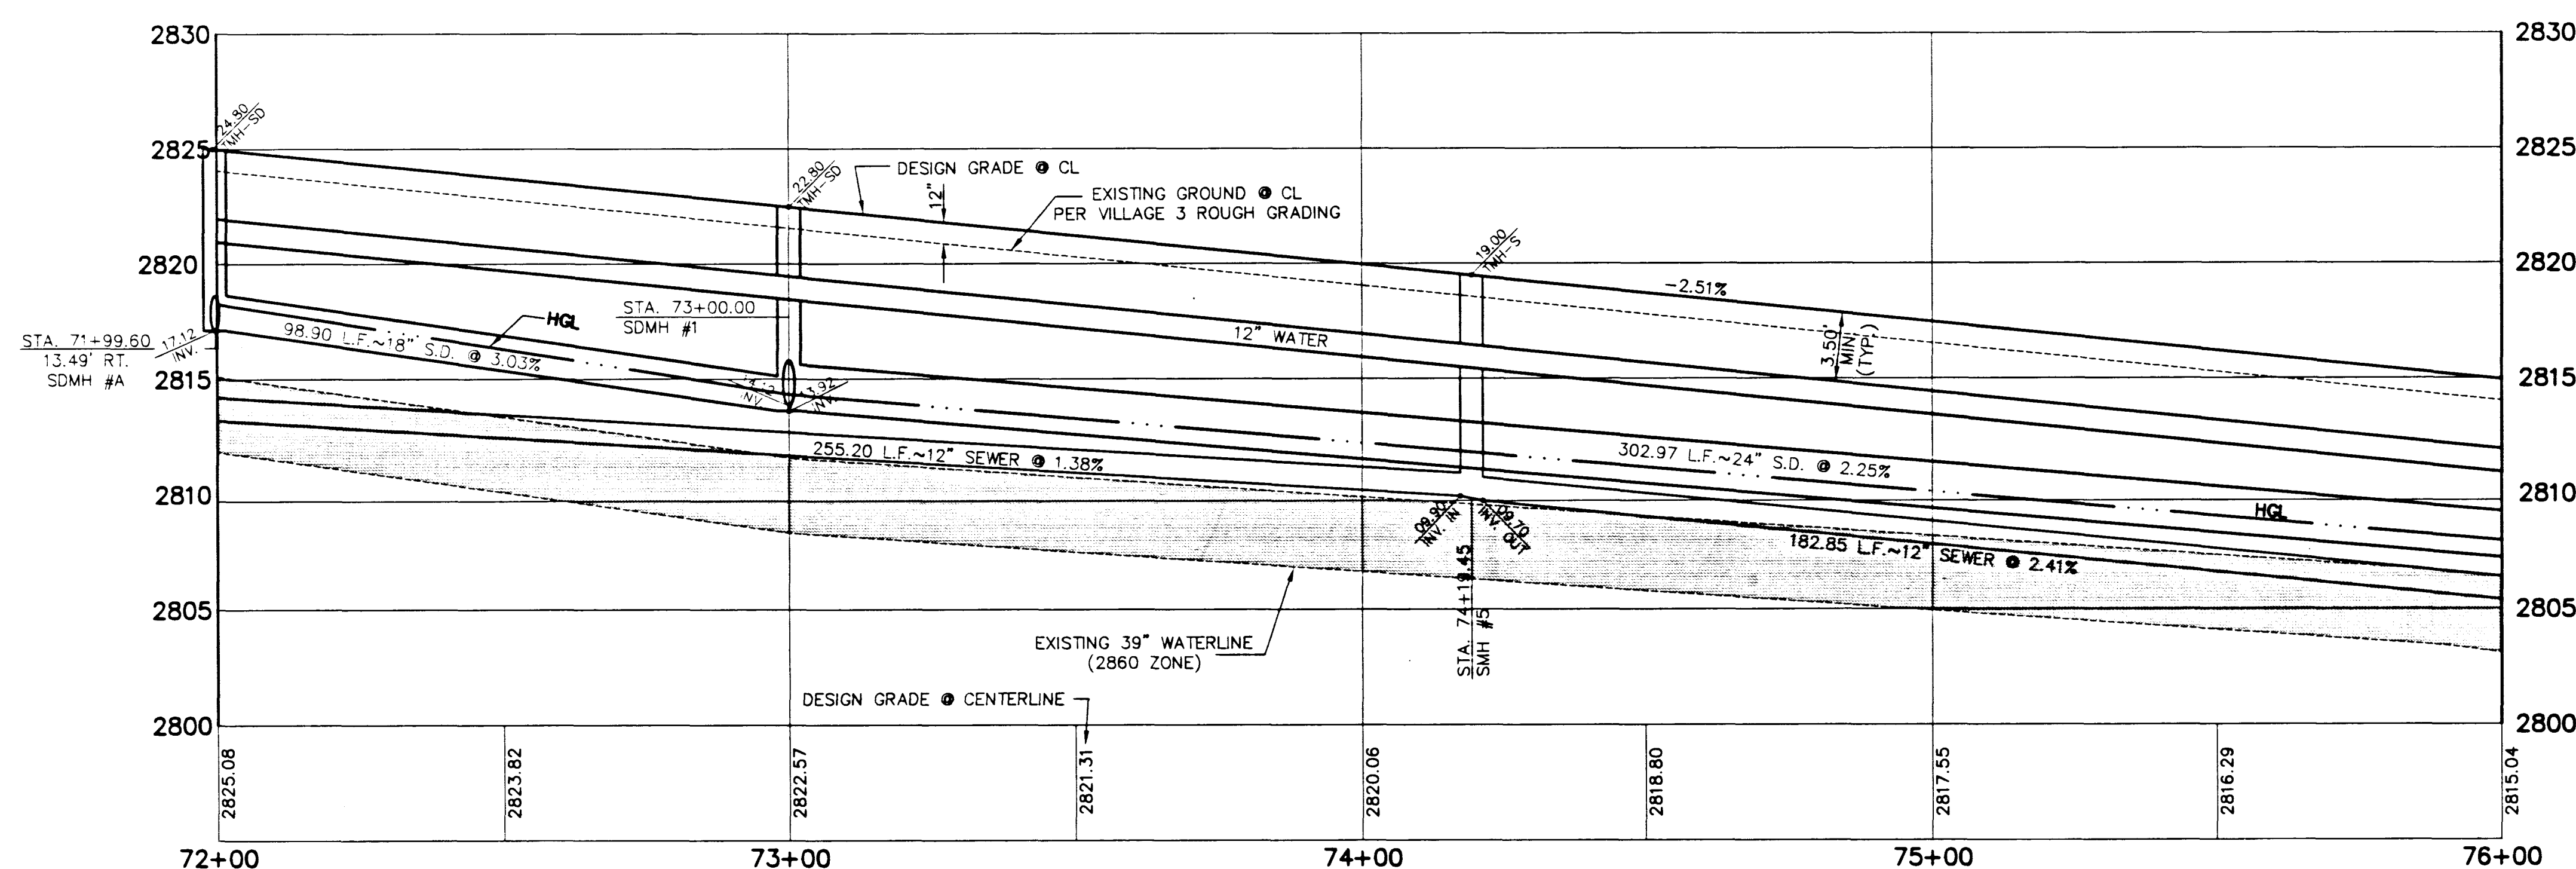


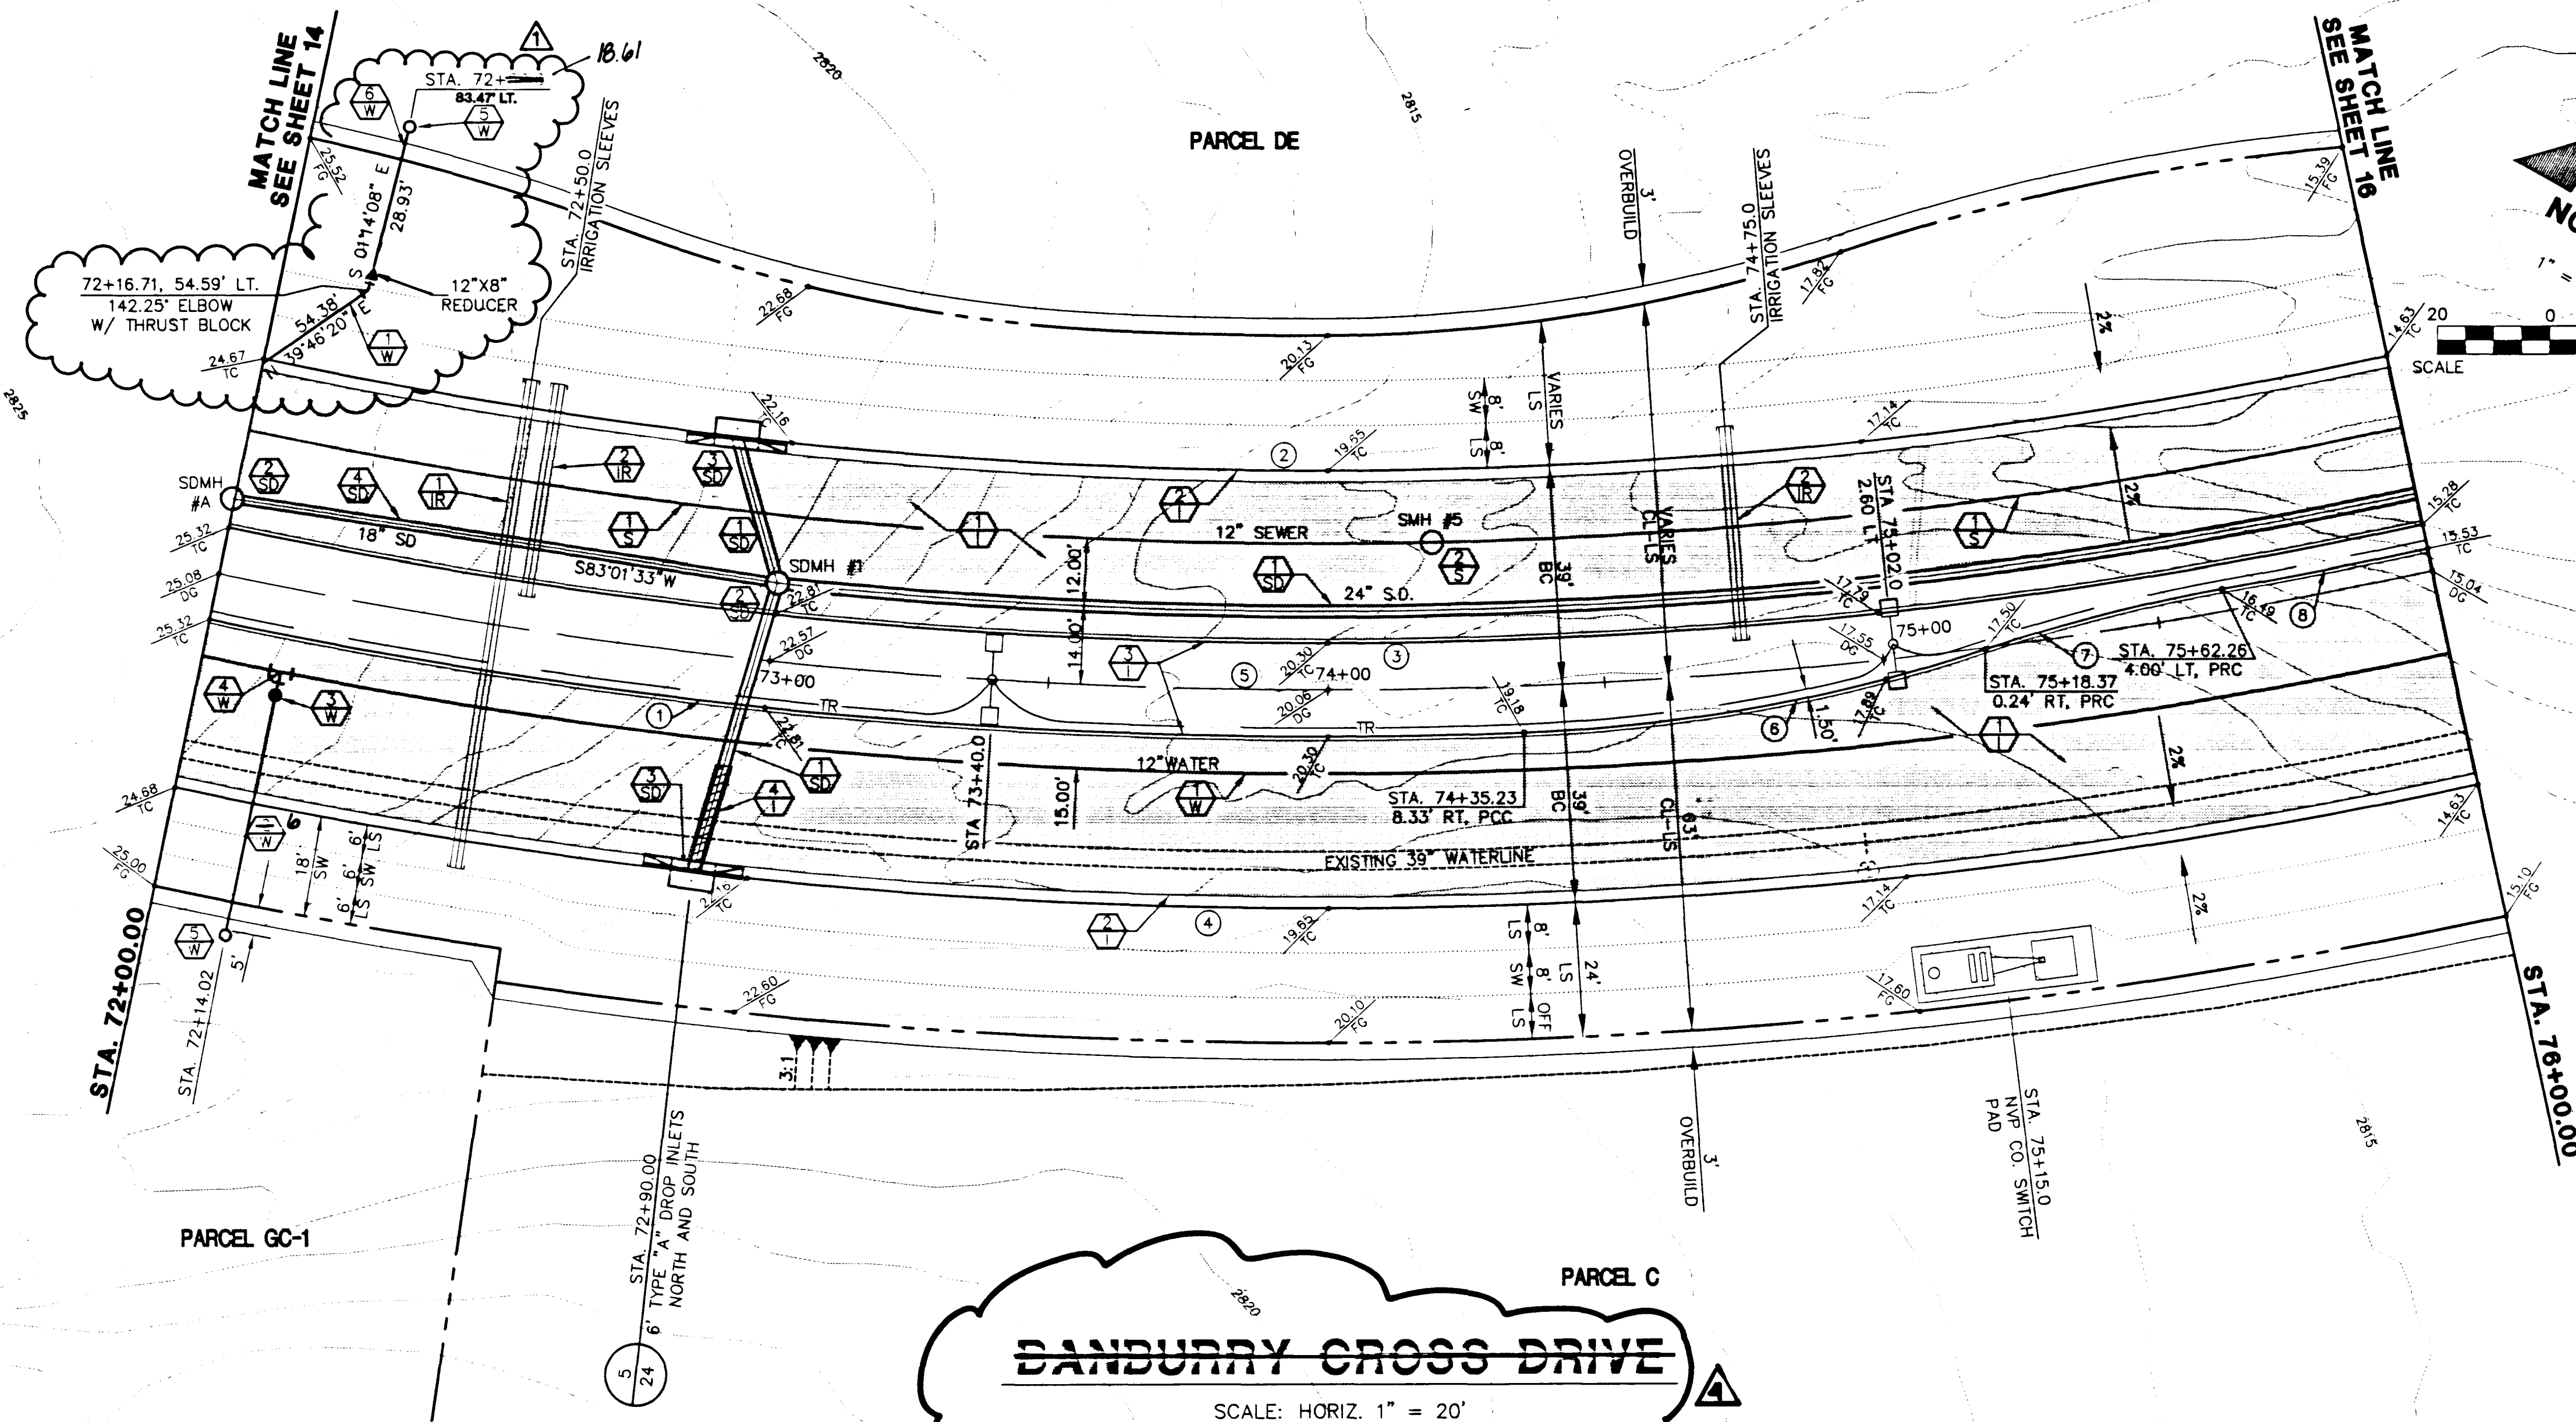

CURVE DATA ① INDICATES CURVE NUMBER

CURVE	DELTA	RADIUS	LENGTH	TANGENT
1	141°10'	958.33'	237.28'	119.24'
2	24°07'22"	911.00'	383.55'	194.66'
3	24°07'22"	941.67'	396.46'	201.21'
4	24°07'22"	416.39'	211.33'	107.55'
5	24°07'22"	950.00'	399.37'	202.99'
6	16°04'20"	300.00'	84.15'	42.56'
7	08°24'40"	500.00'	44.04'	22.30'
8	02°16'36"	946.00'	37.59'	18.80'

NOTE: CURVE DATA REPRESENTS PARTIAL CURVE, THIS SHEET ONLY.

CONSTRUCTION NOTES

IMPROVEMENTS

- ① INSTALL A.C. PAVEMENT PER STREET SECTIONS, SHEET NO. 25
- ② INSTALL "L" TYPE CURB AND GUTTER (S-47) S
- ③ INSTALL "A" TYPE ISLAND CURB (S-50) S
- ④ INSTALL CONCRETE ENCASEMENT (C-24) S

SEWER

- ⑤ INSTALL 12" SEWER PIPE (U-20) S
- ⑥ INSTALL SEWER MANHOLE (S-01) S
- ⑦ INSTALL 8" SEWER PIPE (U-20) S

WATER

- ⑧ INSTALL 12" WATER PIPE (U-20) S
- ⑨ INSTALL 8" WATER PIPE (U-20) S
- ⑩ INSTALL 8" GATE VALVE (U-34) S
- ⑪ INSTALL 12" X 12" X 4" TEE (U-32) S
- ⑫ INSTALL TEMPORARY 2" BLOW-OFF VALVE (U-32) S
- ⑬ INSTALL 8" WATER PIPE (U-20) S

STORM DRAIN


- ⑭ INSTALL 24" STORM DRAIN PIPE (1350-D) (U-20) S
- ⑮ INSTALL TYPE II STORM DRAIN MANHOLE (D1.2) S
- ⑯ INSTALL TYPE "A" DROP INLET (D-12) S
- ⑰ INSTALL 18" STORM DRAIN PIPE (1350-D) (U-20) S

STREET LIGHTING

- ⑱ STREET LIGHT OR COMMON TRENCH, SEE ELECTRICAL PLANS
- ⑲ STREET LIGHT, SEE ELECTRICAL PLANS (E-2) S

IRRIGATION

- ⑳ BANK "A", 1-6" & 2-4" SDR35 PVC
- ㉑ BANK "B", 2-4" SDR35 PVC

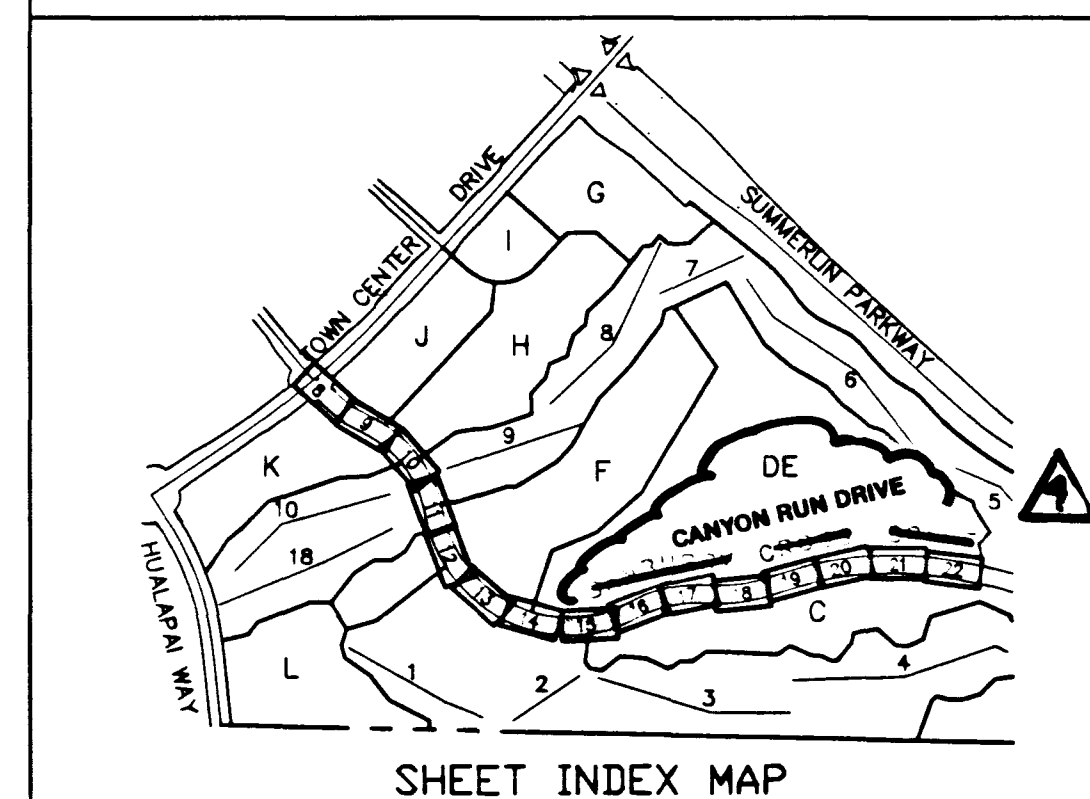

APPROVAL:
1ST 11/11/95 10-30-95
12/3/95
LAS VEGAS VALLEY WATER DISTRICT

STREET NAME CHANGE
REUSE WATER LOCATION
DATE
DESCRIPTION

RECLAMATION DISTRICT
CLIMATE CONTROL
CIVIL
G.C. WALLACE, INC.
Engineering/Architecture
1555 SOUTH RAINBOW BLVD./LAS VEGAS, NEVADA 89106

SUMMERLIN
VILLAGE 3
CANYON RUN DRIVE
STA. 72+00.00 TO 76+00.00

SHEET
15
SHT 15 OF 26

