

MATCH LINE
SEE SHEET 16

STA. 80+00.00

STA. 80+04.95
TYPE "A" DROP INLETS
NORTH AND SOUTH

STA. 80+50.0
IRRIGATION SLEEVES

OVERBUILD

OVERBUILD

3' OVERBUILD

3' OVERBUILD


3' OVERBUILD

3' OVERBUILD

CANYON RUN DRIVE BANBURY CROSS DRIVE

SCALE: HORIZ. 1" = 20'
VERT. 1" = 5'

MATCH LINE
SEE SHEET 18

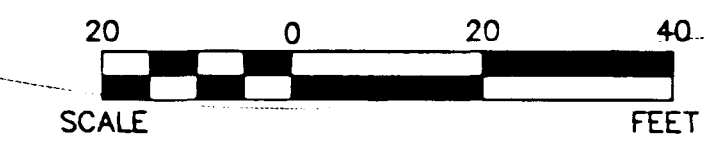

CURVE DATA				
① INDICATES CURVE NUMBER				
CURVE	DELTA	RADIUS	LENGTH	TANGENT
1	10°07'22"	997.67	176.26'	88.36'
2	10°07'22"	1006.00	177.74'	89.10'
3	10°07'22"	1014.33	179.21'	89.84'
4	10°07'22"	1045.00	184.63'	92.55'
5	10°07'22"	967.00	170.85'	85.65'
6	00°23'32"	1253.00	8.58'	4.29'
7	07°20'59"	300.00	38.49'	19.27'
8	11°55'51"	300.00	52.47'	31.35'
9	10°29'19"	1214.00	222.24'	111.43'
10	10°29'19"	1175.00	215.10'	107.85'
11	10°29'19"	1222.33	223.76'	112.19'
12	10°29'19"	1205.67	220.71'	110.66'
13	05°50'55"	1261.00	121.38'	60.74'

NOTE: CURVE DATA REPRESENTS PARTIAL CURVE, THIS SHEET ONLY.

CONSTRUCTION NOTES

IMPROVEMENTS

- ① INSTALL A.C. PAVEMENT PER STREET SECTIONS, SHEET NO. 25
- ② INSTALL "L" TYPE CURB AND GUTTER (S-47 S)
- ③ INSTALL "A" TYPE ISLAND CURB (S-50 S)

SEWER

- ① INSTALL 12" SEWER PIPE (U-20 S)
- ② INSTALL SEWER MANHOLE (SD1-B CLV)

WATER

- ① INSTALL 12" WATER PIPE (U-20 S)

STORM DRAIN



- ① INSTALL 24" STORM DRAIN PIPE (1350-D) (U-20 S)
- ② INSTALL TYPE II STORM DRAIN MANHOLE (DI.2 S)
- ③ INSTALL TYPE "A" DROP INLET (D-12 S)
- ④ INSTALL CONCRETE ENCASEMENT (C-24)

STREET LIGHTING

- ① STREET LIGHT OR COMMON TRENCH, SEE ELECTRICAL PLANS
- ② STREET LIGHT, SEE ELECTRICAL PLANS (E-2 S)

IRRIGATION

- ① BANK "A", 1-6" & 2-4" SDR35 PVC
- ② BANK "B", 2-4" SDR35 PVC

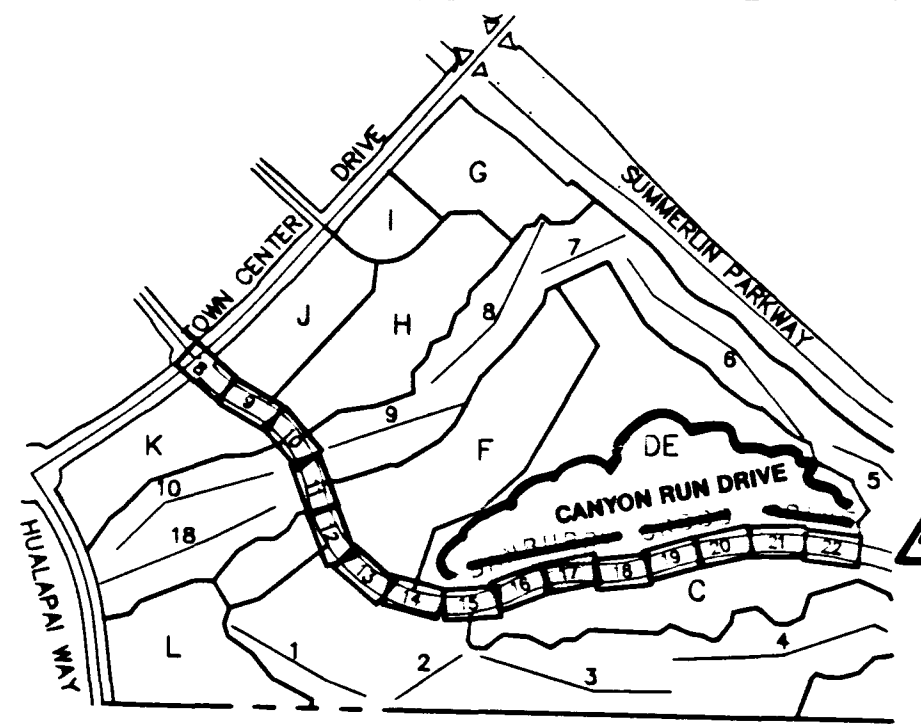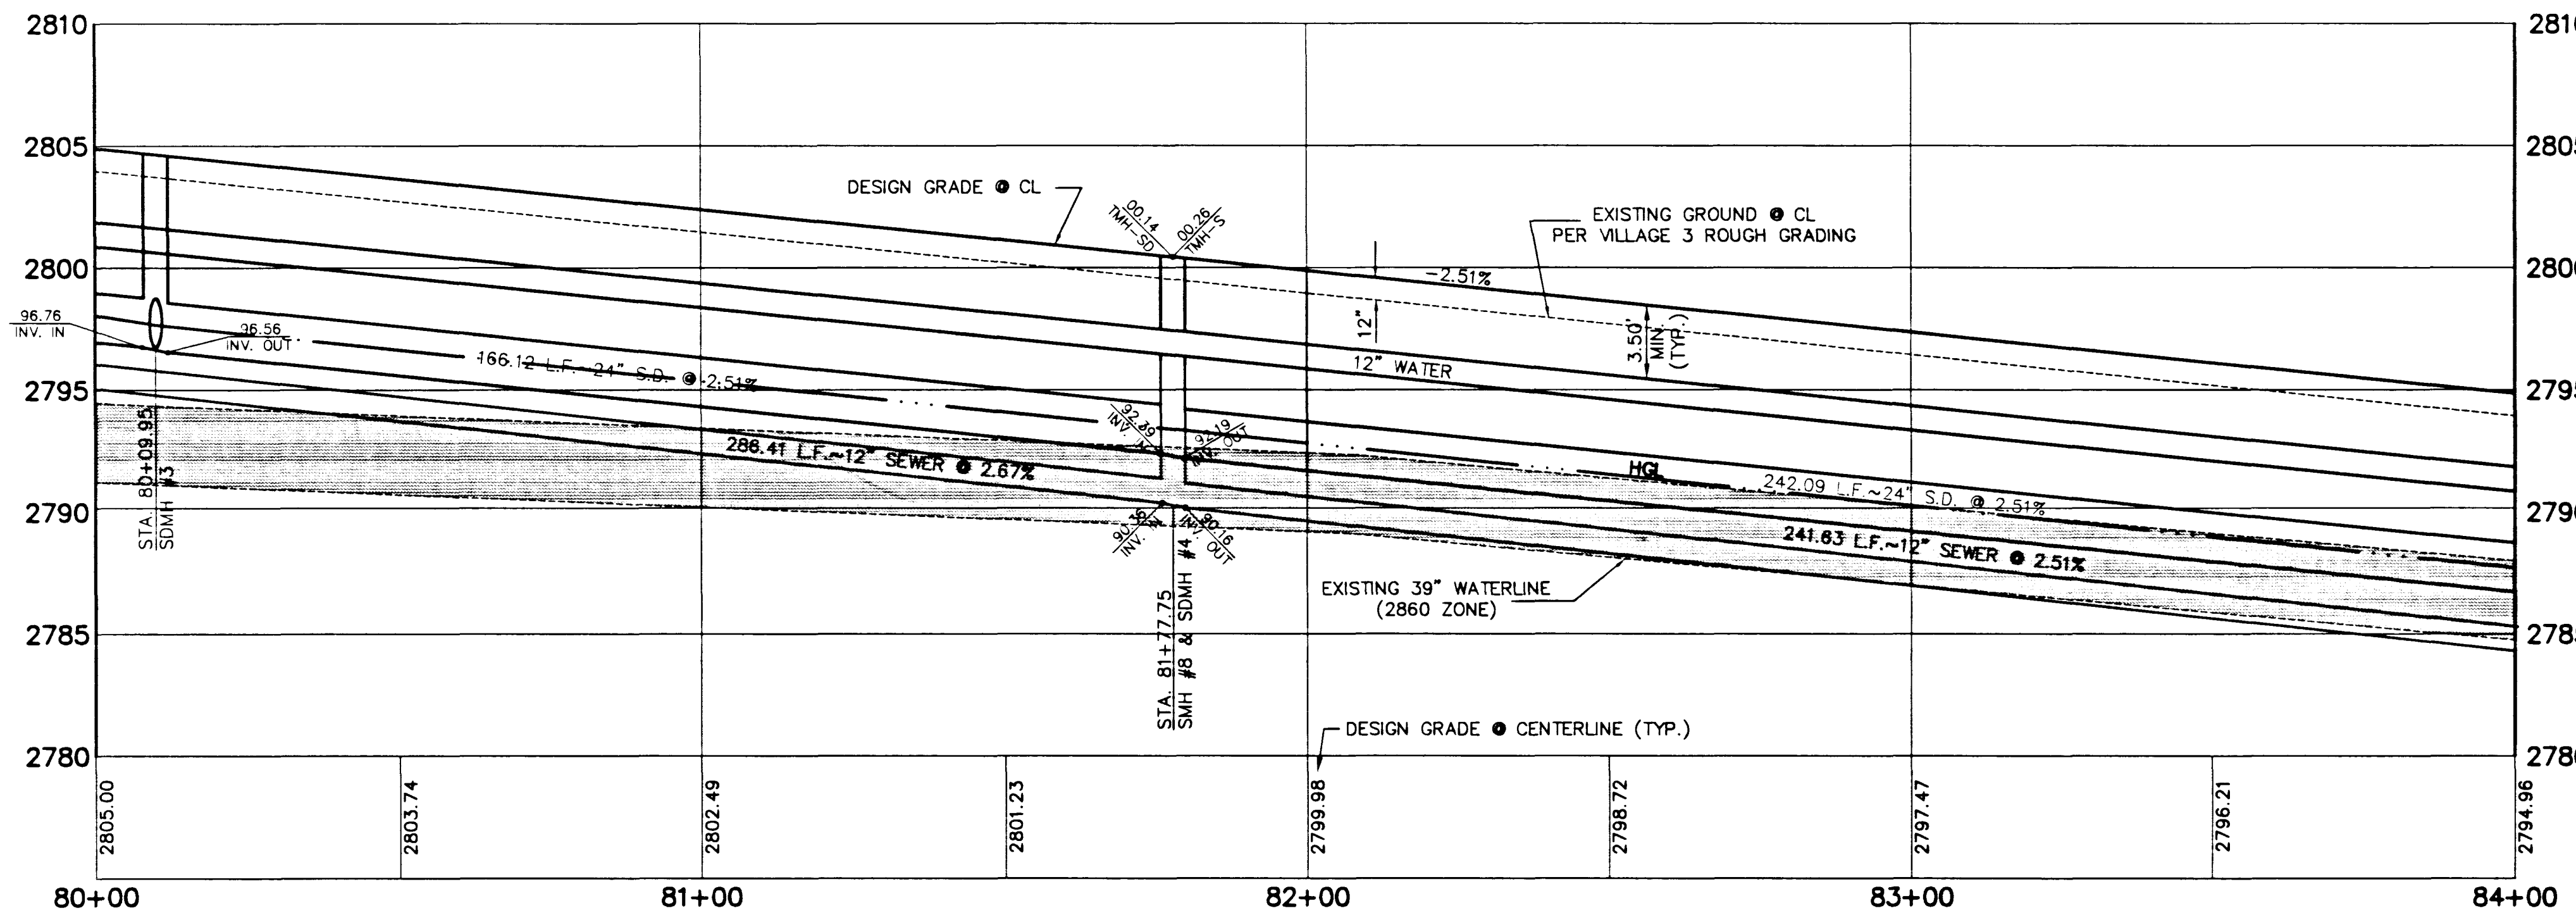

APPROVAL:

1st April 10-20-95
LAS VEGAS VALLEY WATER DISTRICT

SHEET

17

SHT 17 OF 26

JOB NO. 82003.205

9795

107-V2426

