
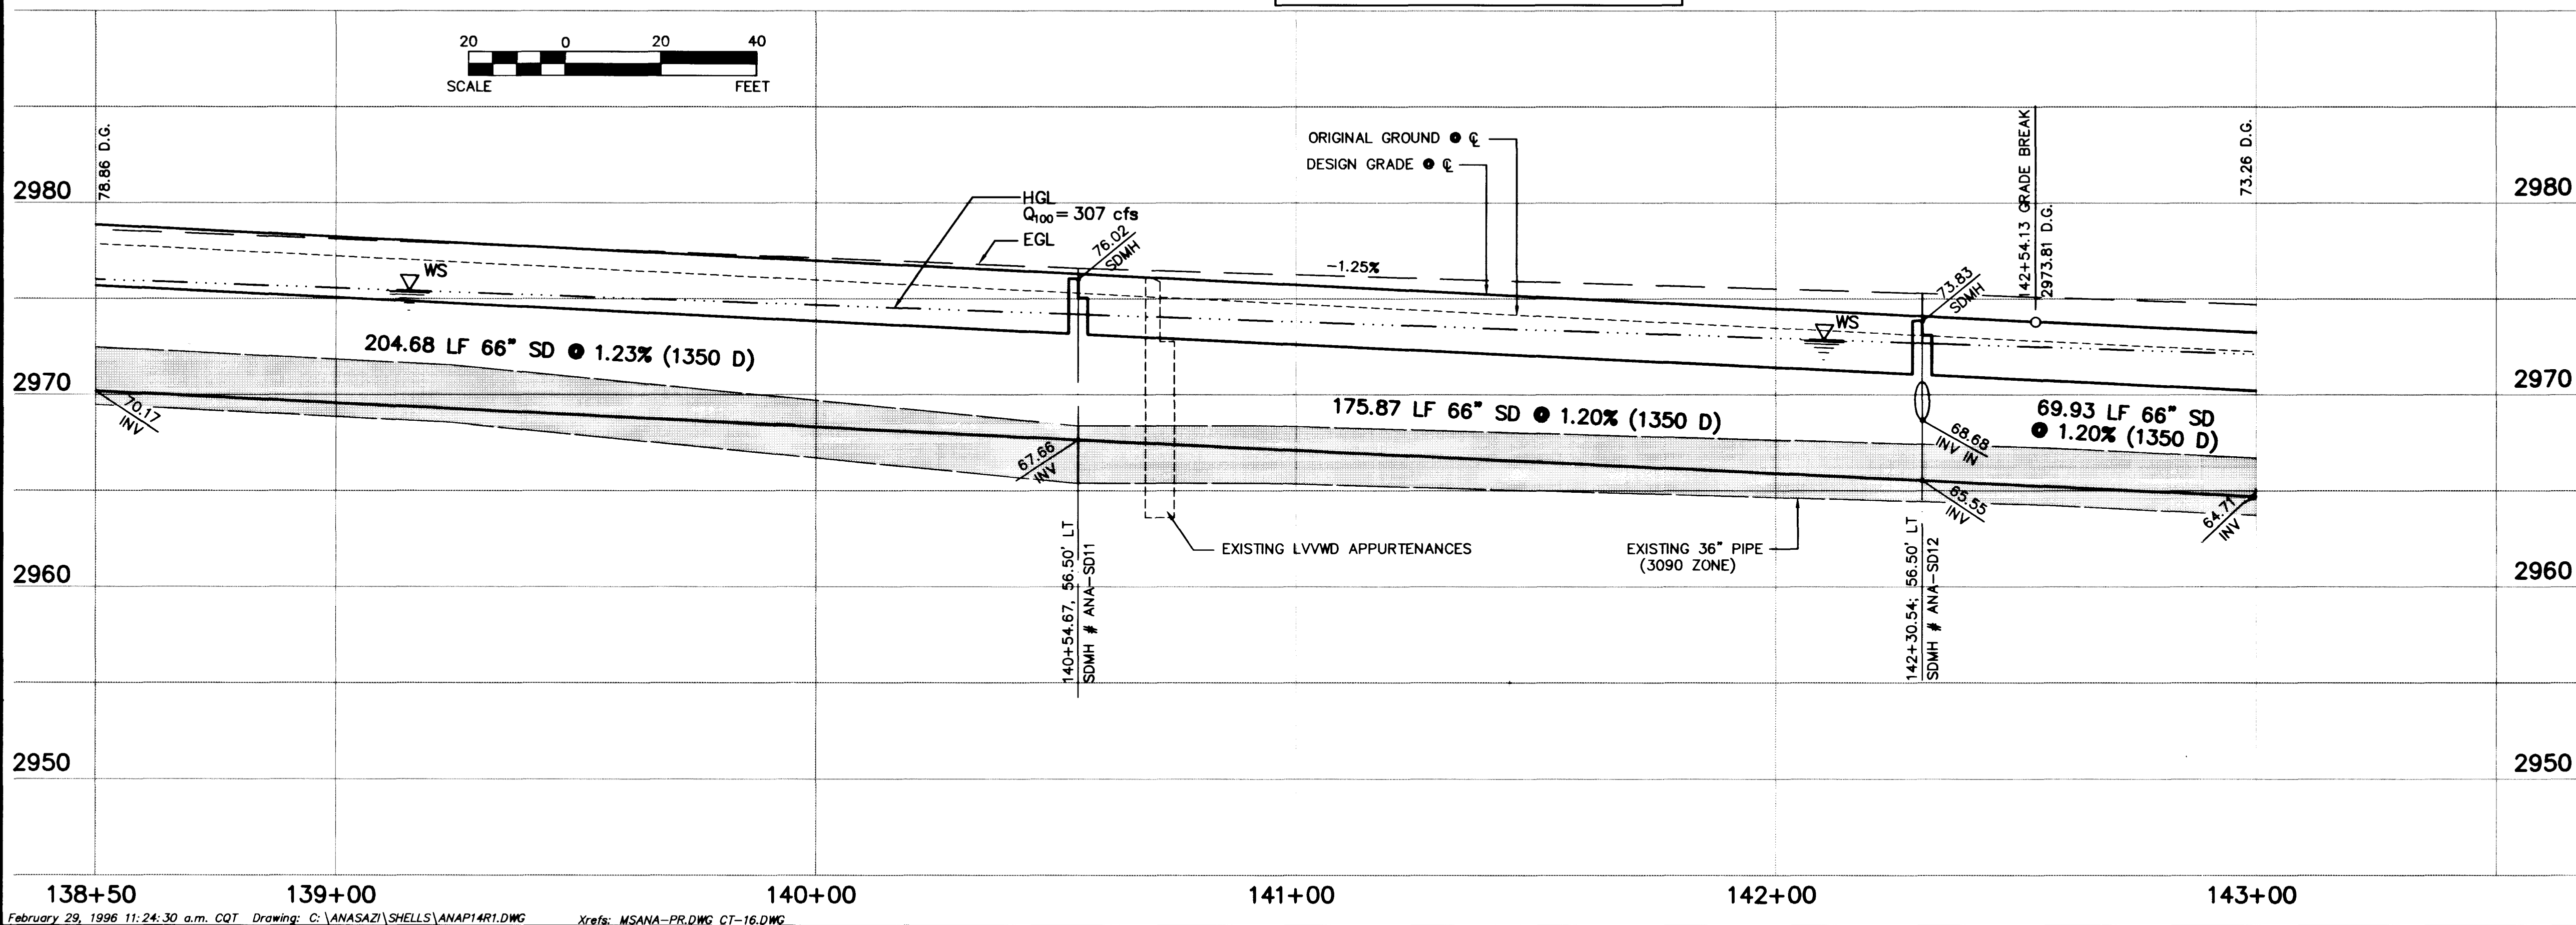


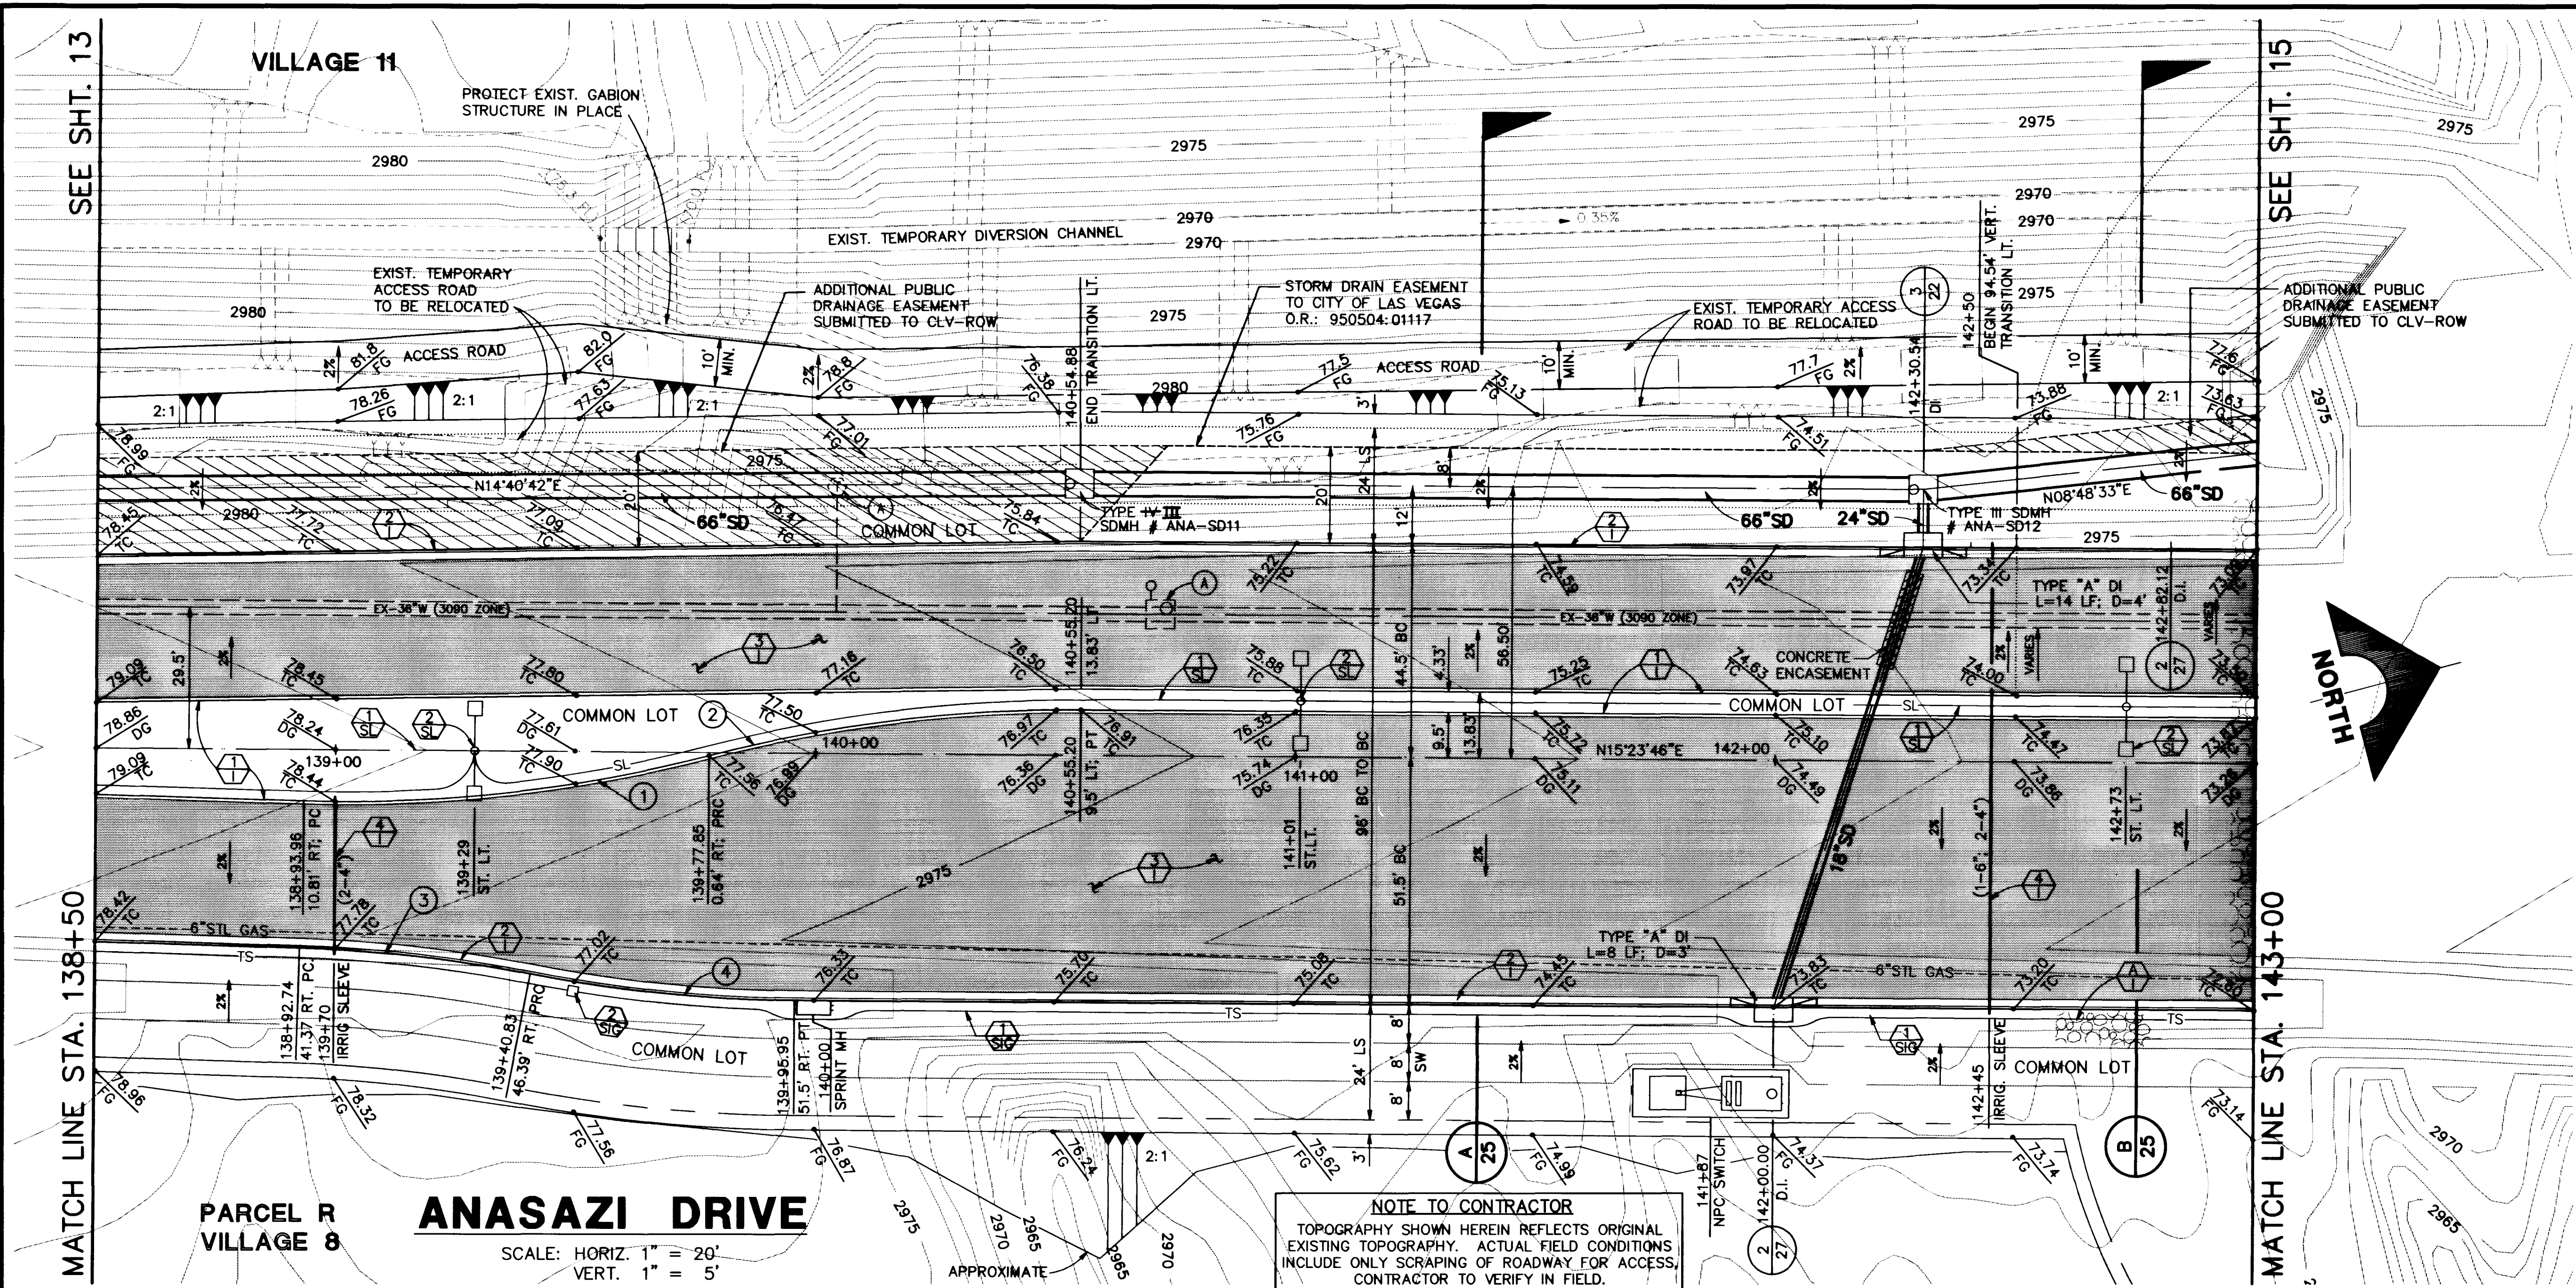


CURVE DATA

CURVE	DELTA	RADIUS	LENGTH	TANGENT
1	167°10'	300.00'	85.27'	42.93'
2	14°56'32"	300.00'	78.24'	39.34'
3	09°14'38"	300.00'	48.40'	24.25'
4	10°35'16"	300.00'	55.44'	27.80'

- CONSTRUCTION NOTES
- IMPROVEMENTS
- 1. INSTALL "A" TYPE ISLAND CURB (S-50 S)
 - 2. INSTALL TYPE "L" CURB & GUTTER (S-47 S)
 - 3. INSTALL AC PAVEMENT PER STREET SECTIONS SHEET NO. 25
 - 4. INSTALL IRRIGATION SLEEVES; NUMBER AND SIZE PER PLAN (U-18 S)
 - 5. REMOVE EXISTING RIP RAP, STOCK PILE AS DIRECTED BY OWNER
- WATER
- 1. ADJUST TO GRADE
- STREET LIGHTING
- 1. STREET LIGHT OR COMMON TRENCH, SEE ELECTRICAL PLANS
 - 2. INSTALL STREET LIGHT, SEE ELECTRICAL PLANS (E-2 S)
- TRAFFIC
- 1. INSTALL 2" INTERCONNECT
 - 2. INSTALL NO. 5 PULLBOX (E-32 S)

NOTE: COMMON LOT AREAS TO BE PRIVATELY MAINTAINED BY THE SUMMERLIN H.O.A.

CONTRACTOR TO VERIFY LOCATION OF EXISTING APPURTENANCES

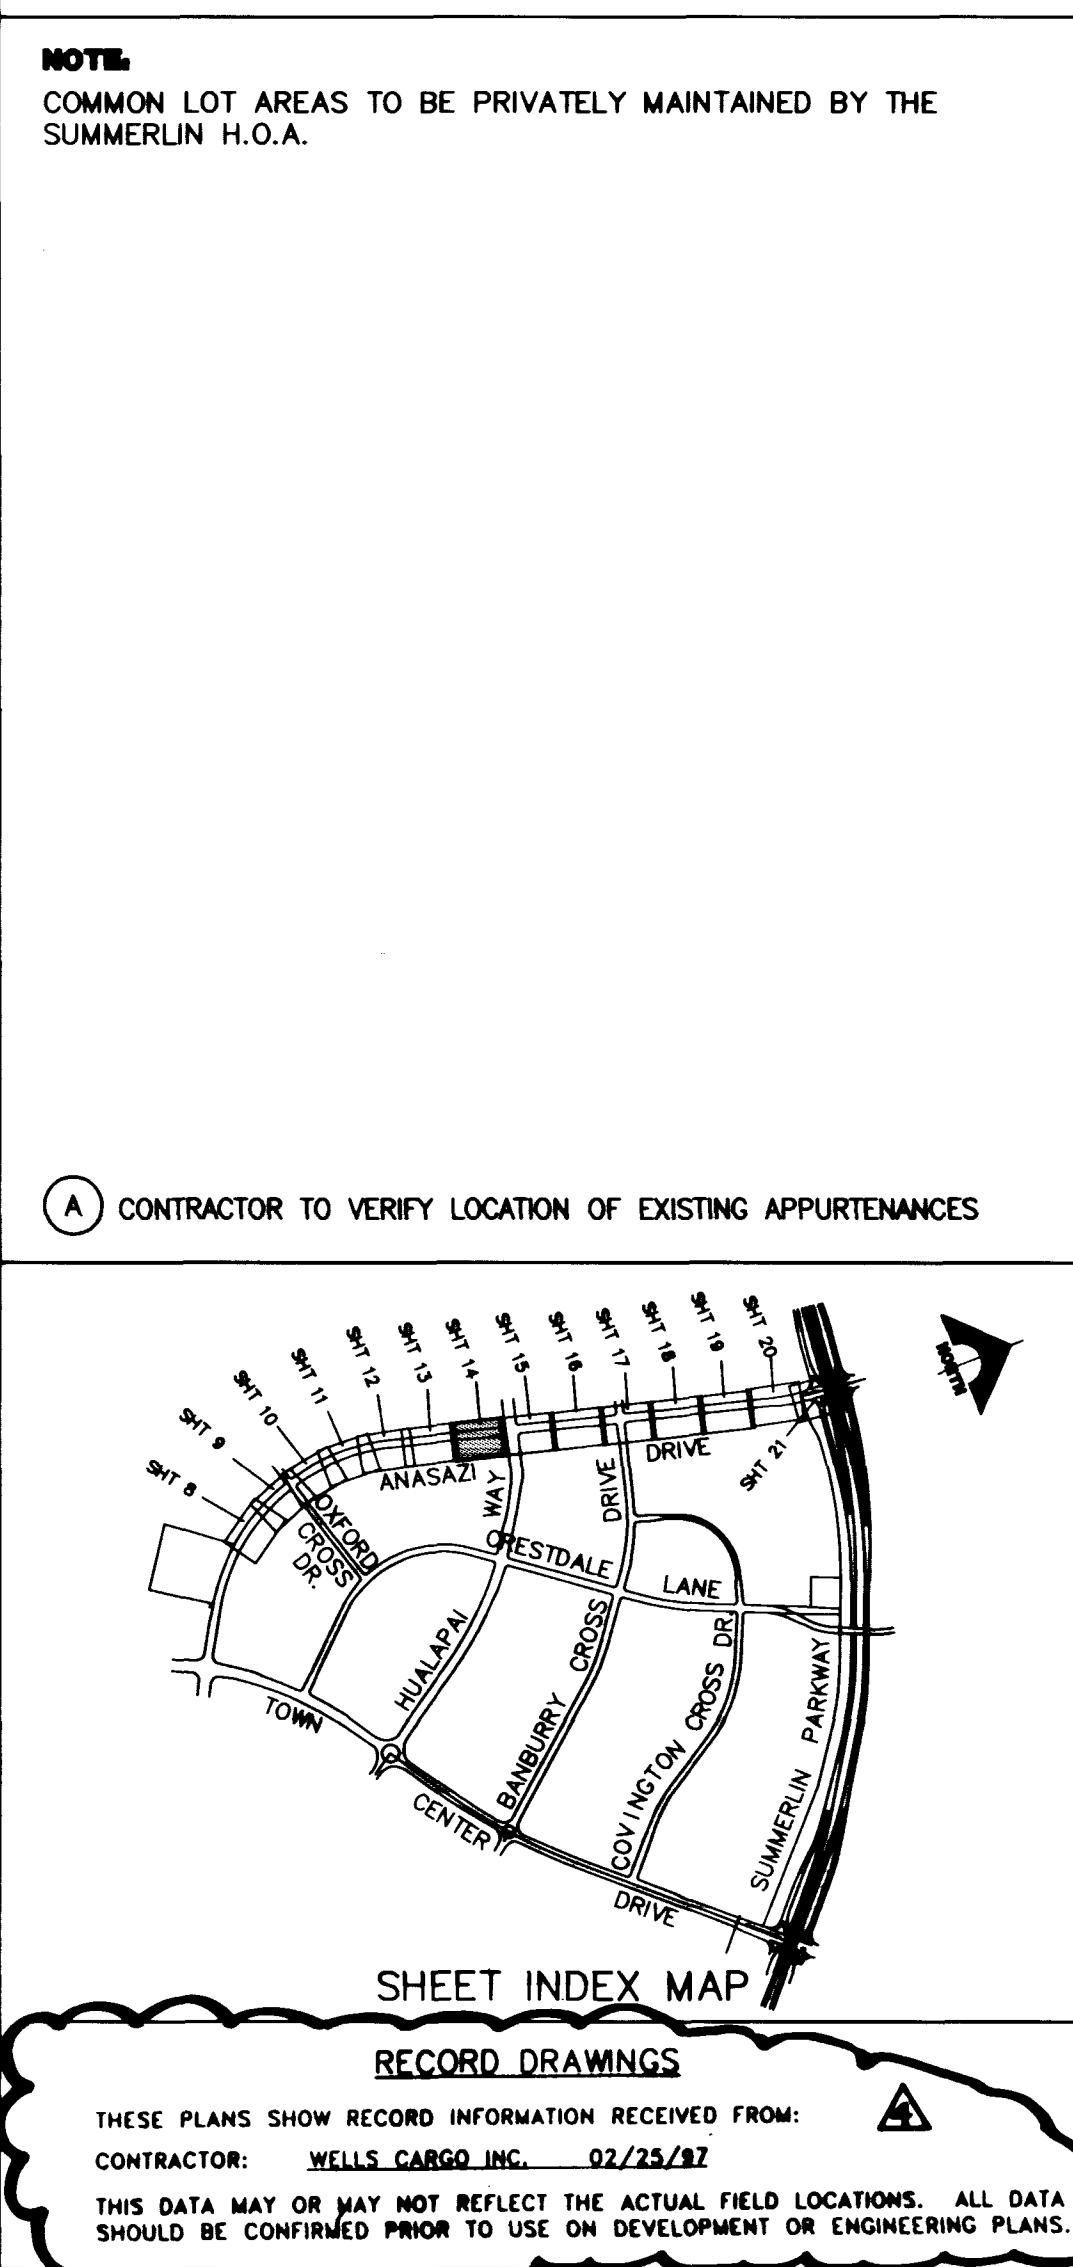

ENGINEER: BERT A. WALLACE, INC. No. 10259

RECOMMENDED BY: BERT A. WALLACE, INC. No. 10259

ANASAZI DRIVE IMPROVEMENTS

ANASAZI DRIVE

PLAN & PROFILE

STA. 138+50 TO STA. 143+50

SHEET 14

