
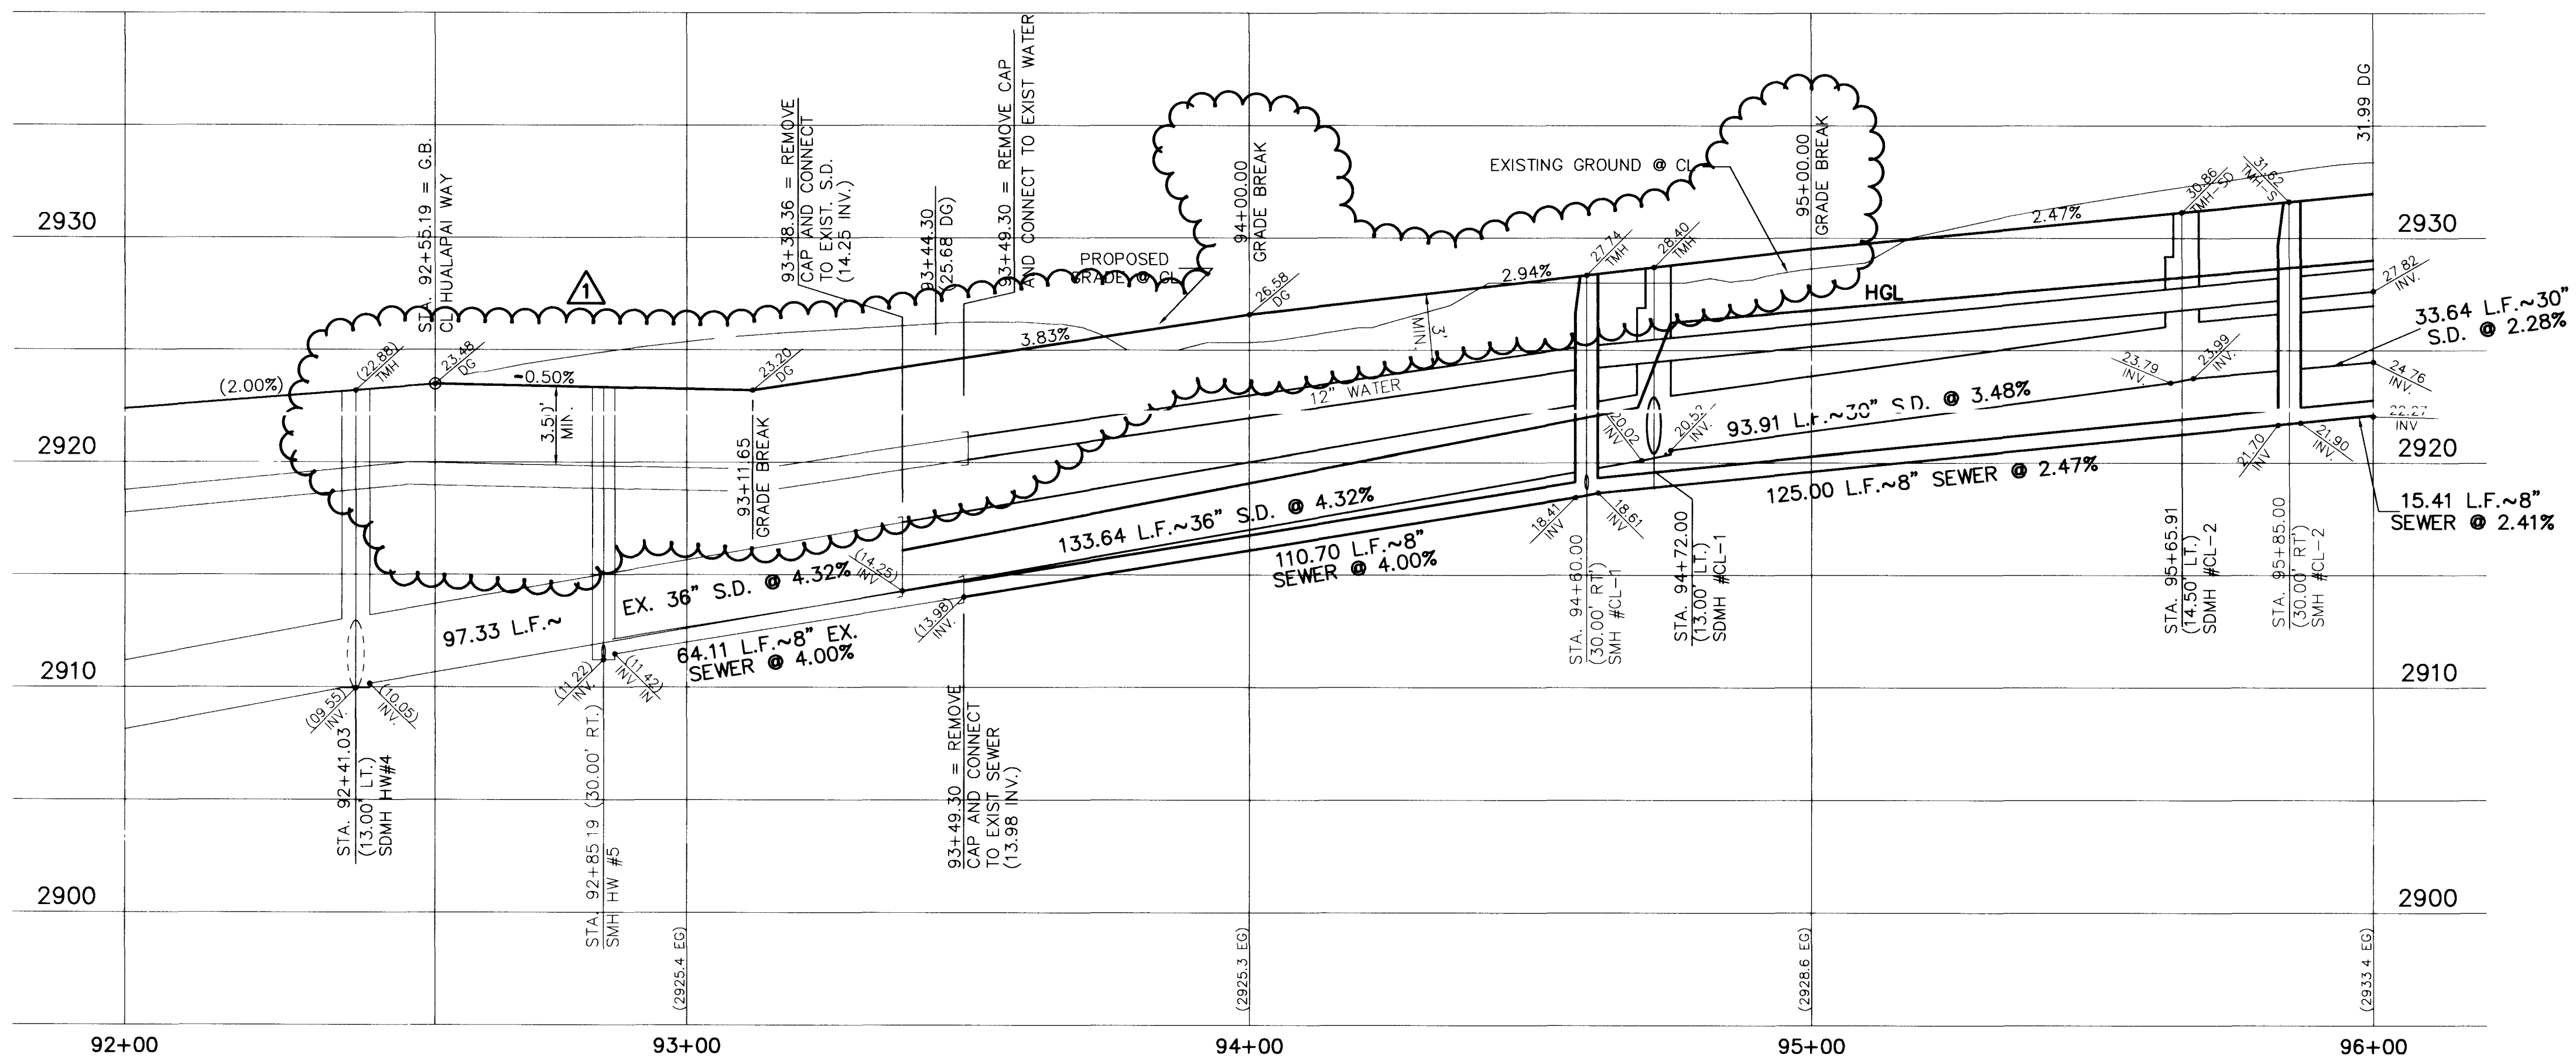


JOB NO. 62008.203

S.T.S. CD-10WG 11/18/94

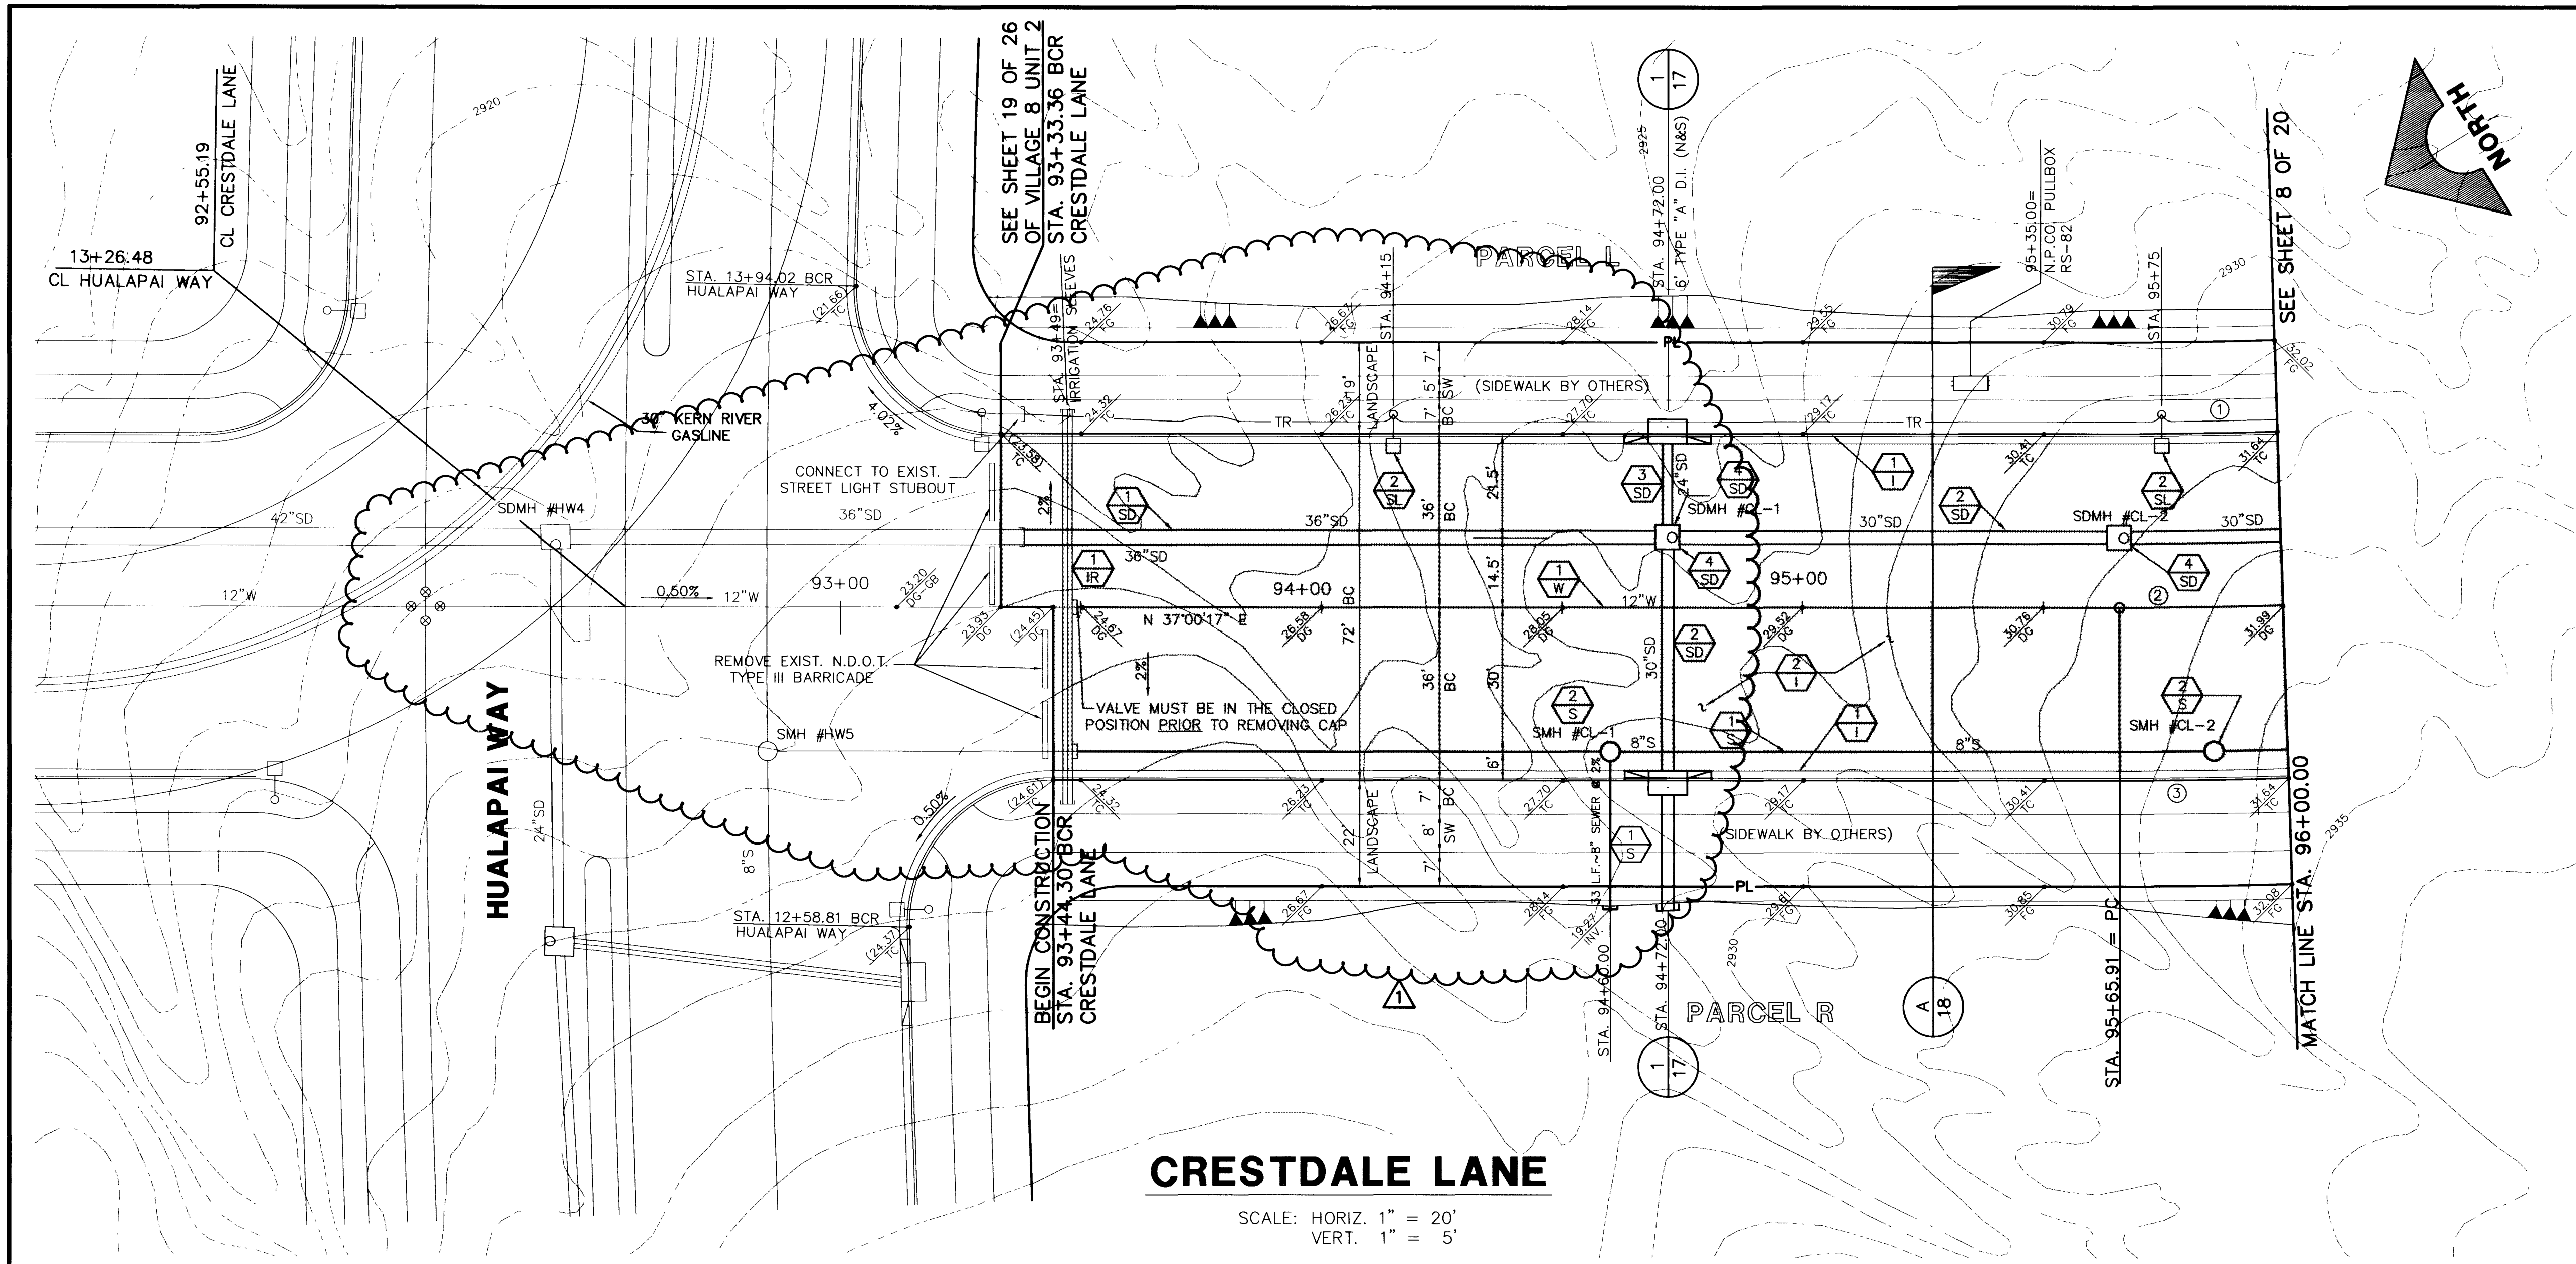

CURVE DATA				
① INDICATES CURVE NUMBER				
NO.	DELTA	RADIUS	LENGTH	TANGENT
1	01°46'33"	1064.00'	32.98'	16.49'
2	01°46'33"	1100.00'	34.09'	17.05'
3	01°46'33"	1136.00'	35.21'	17.61'

NOTE: CURVE DATA REPRESENTS PARTIAL CURVE, THIS SHEET ONLY.

CONSTRUCTION NOTES

- IMPROVEMENTS**
- ① INSTALL "L" TYPE CURB & GUTTER (S-47 S)
 - ② INSTALL AC PAVEMENT PER STREET SECTIONS SHEET NO. 18

- SEWER**
- ① INSTALL 8" SEWER PIPE (U-20 S)
 - ② INSTALL SEWER MANHOLE (SD1-8 CLV)

- WATER**
- ① INSTALL 12" WATER PIPE (U-20 S)

- STORM DRAIN**
- ① INSTALL 36" STORM DRAIN PIPE (1350-D) (U-20 S)
 - ② INSTALL 30" STORM DRAIN PIPE (1350-D) (U-20 S)
 - ③ INSTALL 24" STORM DRAIN PIPE (1350-D) (U-20 S)
 - ④ INSTALL TYPE II STORM DRAIN MANHOLE (0.2,3,4 S)

- STREET LIGHTING**
- ① STREET LIGHT OR COMMON TRENCH, SEE ELECTRICAL PLANS
 - ② INSTALL STREET LIGHT, SEE ELECTRICAL PLANS (E-2 S)

- IRRIGATION**
- ① BANK "C", 1-6" AND 3-4" SDR35 PVC

RECORD DRAWINGS

G.C. WALLACE, INC.

THESE PLANS SHOW RECORD INFORMATION RECEIVED FROM:


CONTRACTOR: WELLS CARGO, INC.

DATE: 9/13/92

THIS DATA MAY OR MAY NOT REFLECT THE ACTUAL FIELD LOCATIONS. ALL DATA SHOULD BE CONFIRMED PRIOR TO USE ON DEVELOPMENT OR ENGINEERING PLANS.

PROJECT MANAGER REVIEW

BY: [Signature] DATE: 10/1/92

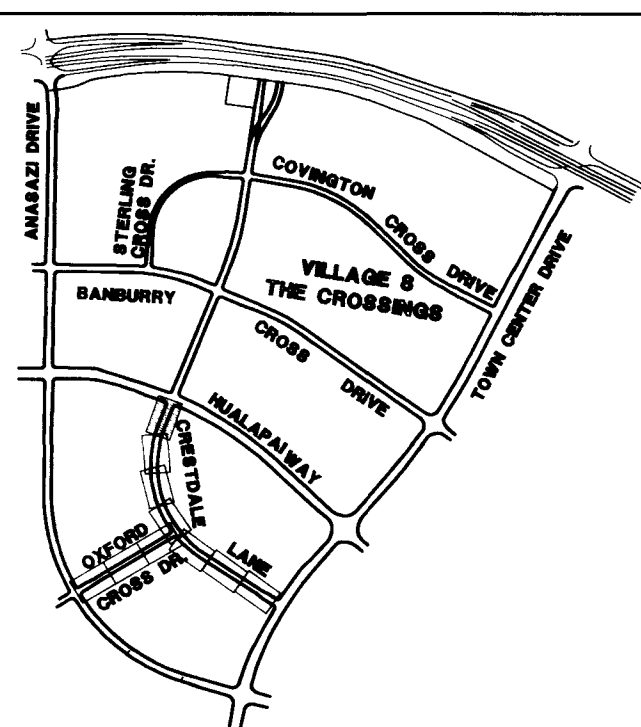

SHEET INDEX MAP

APPROVAL:

[Signature]

LAS VEGAS VALLEY WATER DISTRICT

1.13.85

SUMMERLIN VILLAGE 8 UNIT 3 IMPROVEMENTS

CRESTDALE LANE PLAN & PROFILE


STA. 92+55.19 TO STA. 96+00

SHEET

7

SHT 7 OF 20

21-5-56 107-V2289

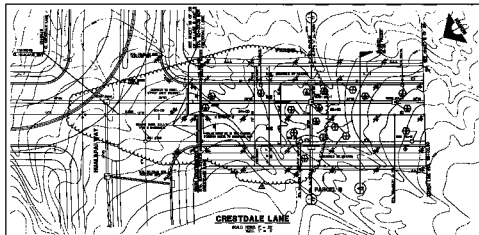[illegible]