

CRESTDALE LANE

SCALE: HORIZ. 1" = 20'
VERT. 1" = 5'

*NOTE: APPROVAL OF THESE PLANS FOR THE STUBOUT INSTALLATION WILL NOT BE CONSTRUED AS A COMMITMENT FOR WATER SERVICE TO THIS PROPERTY.
CURVED SEWER NOTE: LINE & GRADE STAKES TO BE PROVIDED AT 25' MAX. INTERVALS.

CURVE DATA ① INDICATES CURVE NUMBER

NO.	DELTA	RADIUS	LENGTH	TANGENT
1	20°05'06"	1064.00'	386.91'	195.62'
2	20°05'06"	1100.00'	400.00'	202.23'
3	20°05'06"	1136.00'	413.09'	208.85'

NOTE: CURVE DATA REPRESENTS PARTIAL CURVE, THIS SHEET ONLY.

CONSTRUCTION NOTES

- IMPROVEMENTS**
- ① INSTALL "L" TYPE CURB & GUTTER (S-47)
 - ② INSTALL AC PAVEMENT PER STREET SECTIONS SHEET NO. 18



- SEWER**
- ① INSTALL 8" SEWER PIPE (U-20)
 - ② INSTALL SEWER MANHOLE (SD1-8)

- WATER**
- ① INSTALL 12" WATER PIPE (U-20)
 - ② INSTALL 8" WATER PIPE (U-20)
 - ③ INSTALL 8" WATER GATE VALVE (U-34)
 - ④ INSTALL TEMP. 2" BLOWOFF ASSEMBLY
 - ⑤ INSTALL CONC. ENCASEMENT (11)
 - ⑥ INSTALL 12" X 12" X 8" TEE (U-20)
 - ⑦ INSTALL 12" WATER GATE VALVE (U-34)

- STORM DRAIN**
- ① INSTALL 30" STORM DRAIN PIPE (1350-D) (U-20)
 - ② INSTALL 24" STORM DRAIN PIPE (1350-D) (U-20)
 - ③ INSTALL TYPE II STORM DRAIN MANHOLE (U-2,3,4) (U-20)

- STREET LIGHTING**
- ① STREET LIGHT OR COMMON TRENCH, SEE ELECTRICAL PLANS
 - ② INSTALL STREET LIGHT, SEE ELECTRICAL PLANS (E-2)

- IRRIGATION**
- ① BANK "A", 1-6" AND 2-4" SDR35 PVC

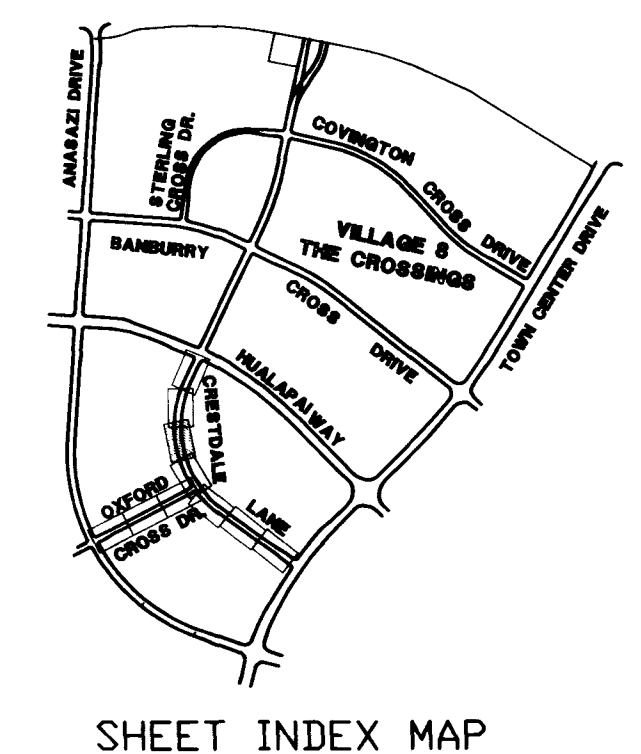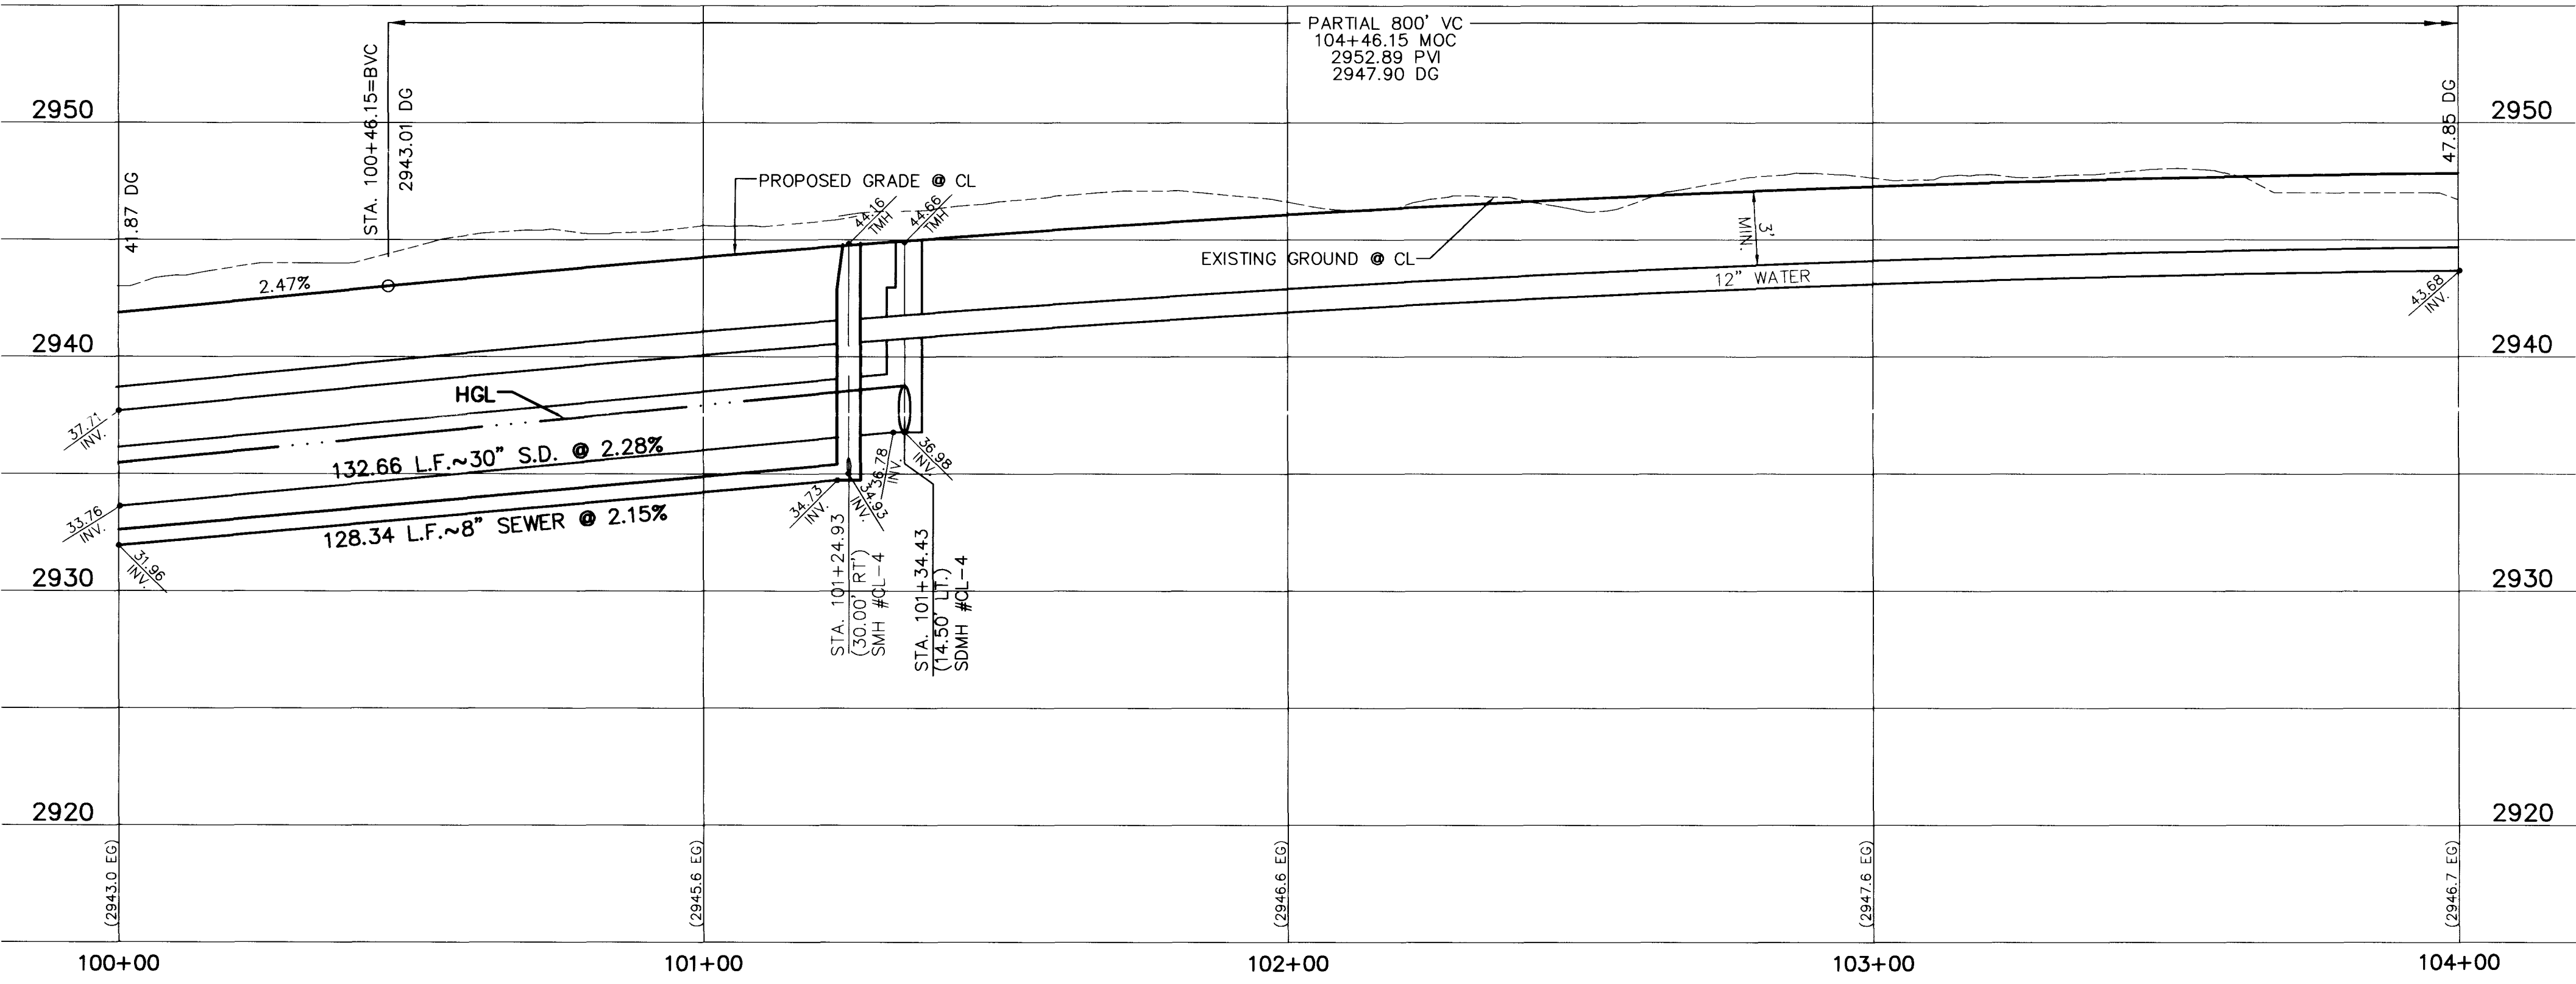

APPROVAL: _____
LAS VEGAS VALLEY WATER DISTRICT

SHEET
9
SHT 9 OF 20

JOB NO. 62008.203

SUMMERLIN VILLAGE 8 UNIT 3 IMPROVEMENTS
CRESTDALE LANE
PLAN & PROFILE
STA. 100+00 TO STA. 104+00
THESE PLANS ISSUED FOR GRADING ONLY

G. C. WALLACE, INC.
Engineering/Architecture

RECEIVED
BERRY & ASSOCIATES
10259 R.P.E. NO. 10259
DATE

APPROVAL

31. 9 - 106 107-V 2289

