


DATE	
BY	
DESIGNED	
PLANNED	
ALIGNED	
CHECKED	
BY	
DATE	
NO.	

DATE	
BY	
DESIGNED	
PLANNED	
CHECKED	
BY	
DATE	
NO.	

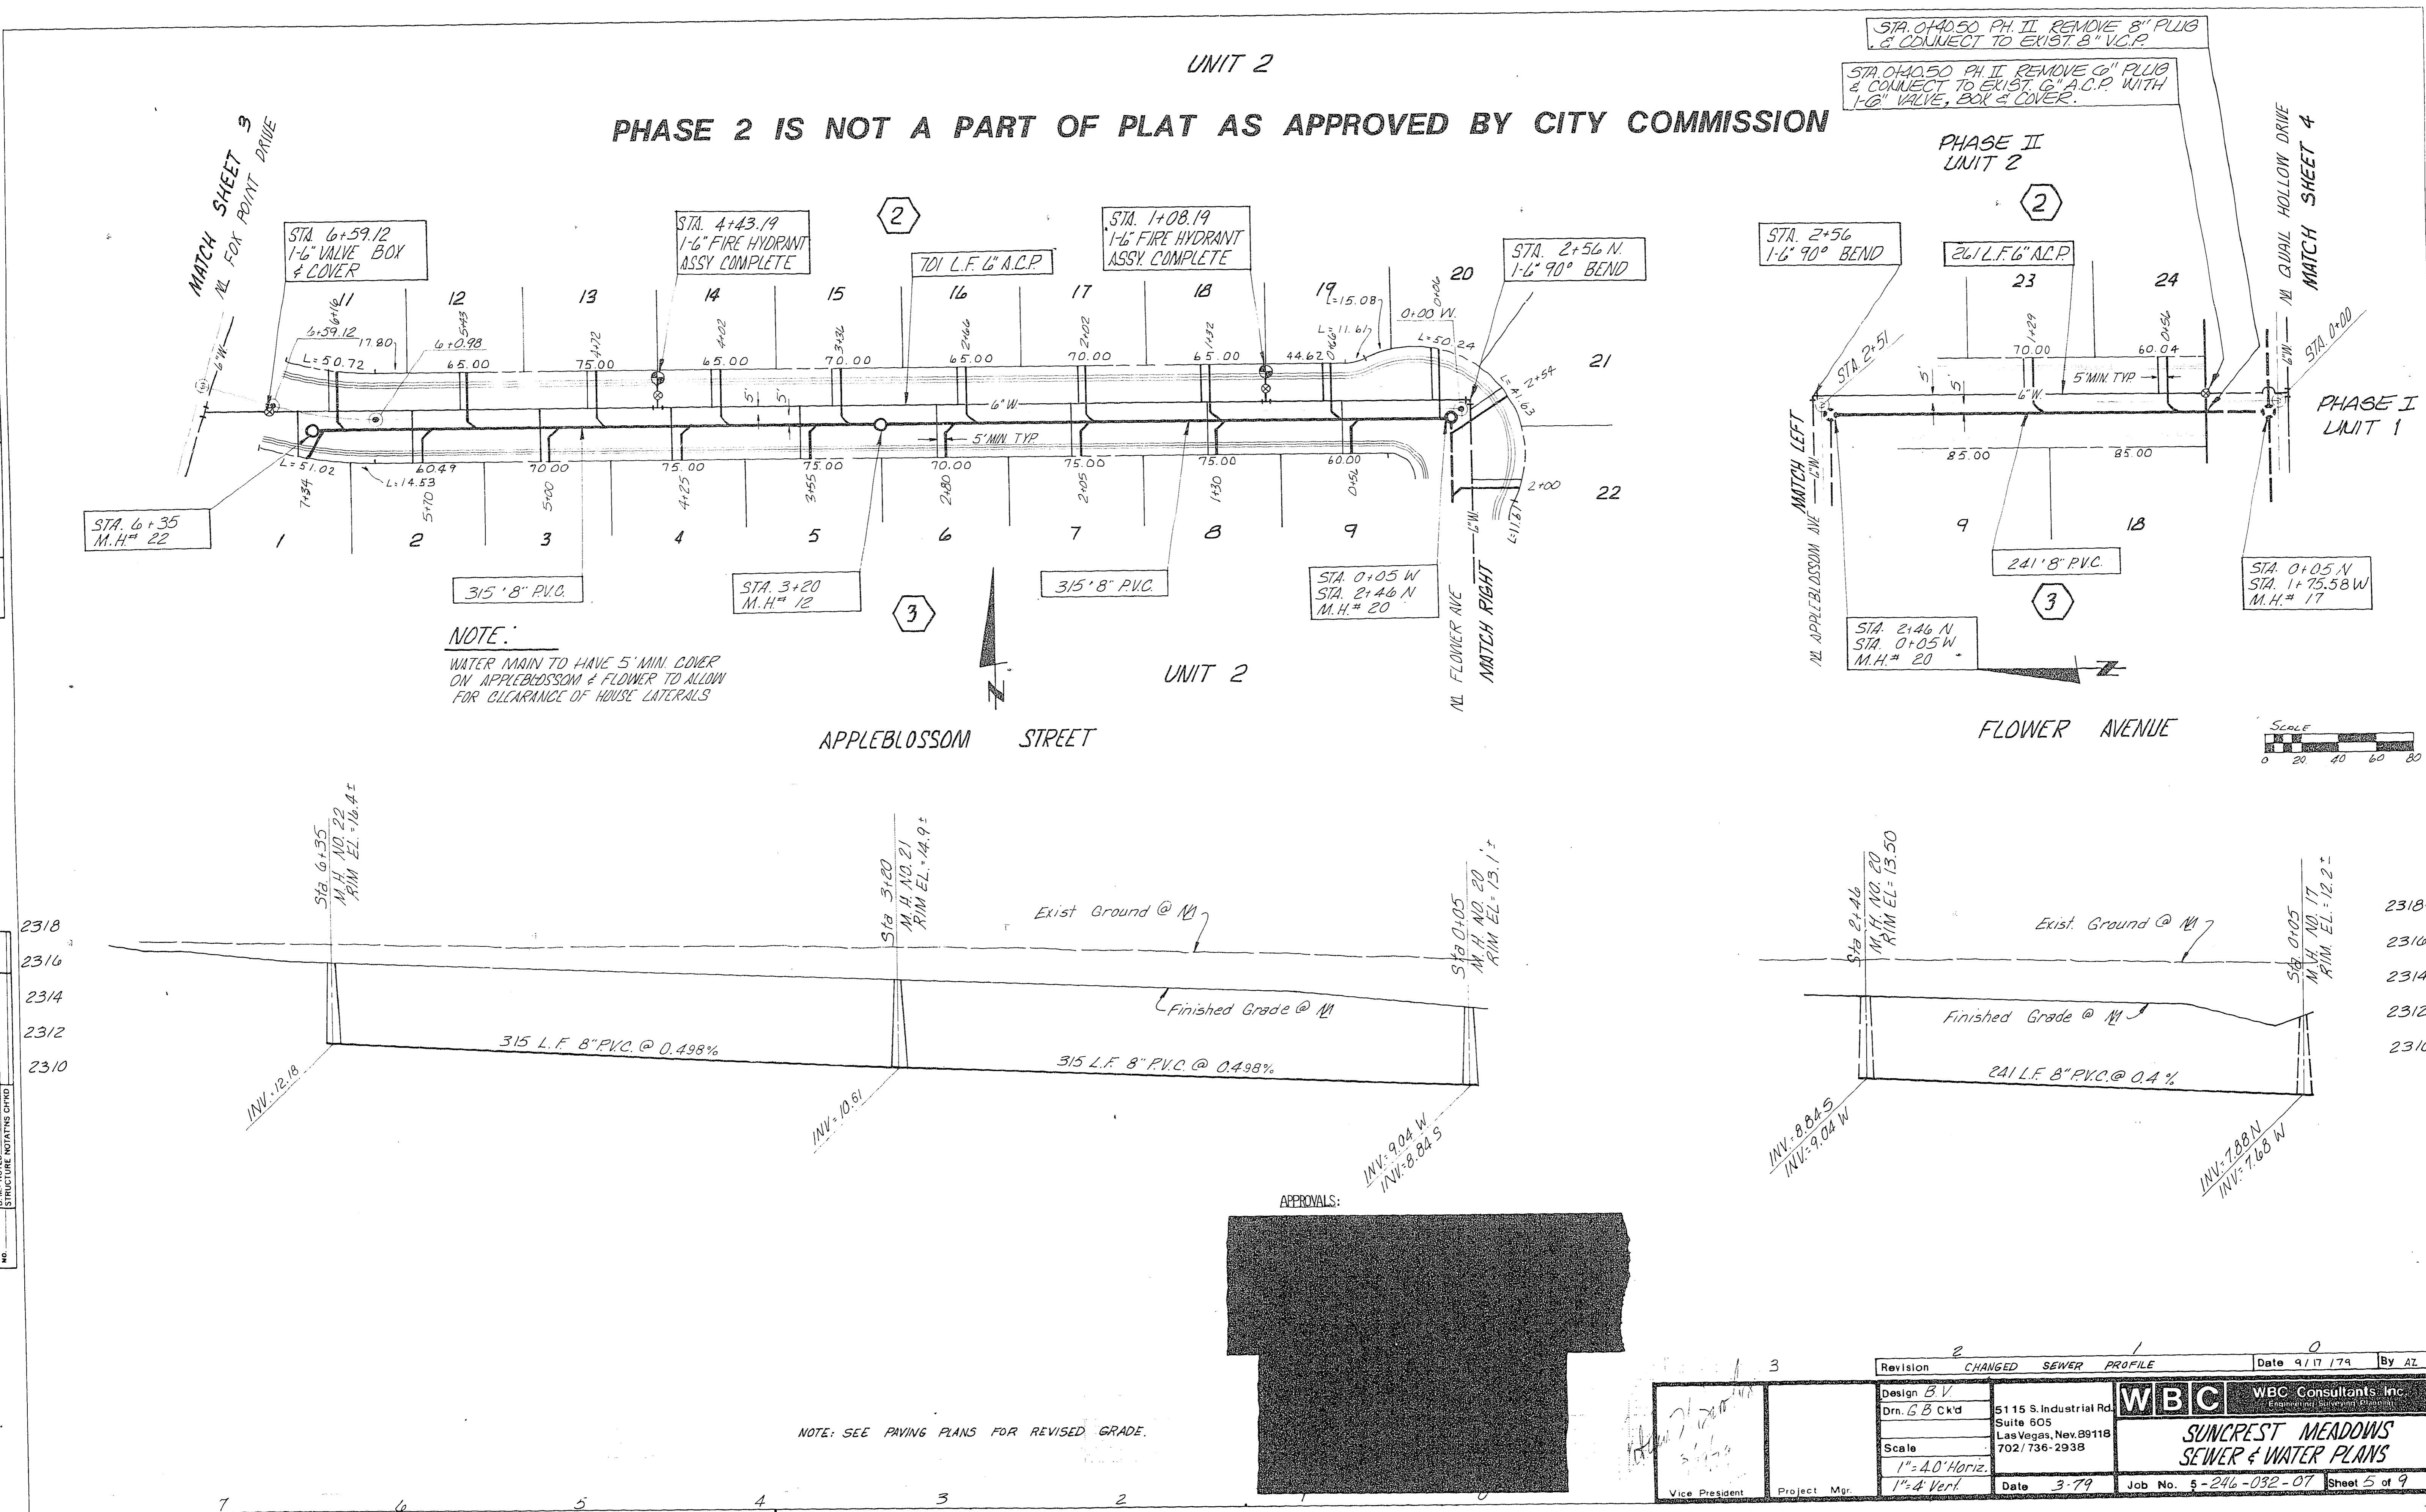

NOTE:
WATER MAIN TO HAVE 5' MIN. COVER ON APPLEBLOSSOM & FLOWER TO ALLOW FOR CLEARANCE OF HOUSE LATERALS


APPROVALS:

NOTE: SEE PAVING PLANS FOR REVISED GRADE.

Revision	CHANGED	SEWER PROFILE	Date	9/17/79	By	AZ
Design	BV					
Drn.	G.B. Ck'd					
Scale	1" = 4.0' Horiz.					
	1" = 4' Vert.					
Vice President						
Project Mgr.						
WBC		WBC Consultants Inc.				
5115 S. Industrial Rd.		Suite 605				
Las Vegas, Nev. 89118		702/736-2938				
SUNCREST MEADOWS		SEWER & WATER PLANS				
Date	3-79	Job No.	5-246-032-07	Sheet	5 of 9	

UNIT 2


PHASE 2 IS NOT A PART OF FLAT AS APPROVED BY CITY COMMISSION

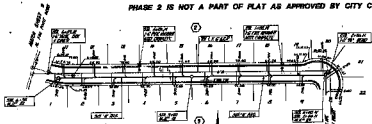


NOTE:
 THIS UNIT IS ONE (1) OF MANY
 UNITS APPROVED UNDER THE
 PROVISIONS OF THE ACT.

UNIT 2

APPROXIMATE STREET

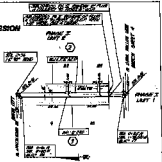

FLOOR MARK

 

SEE ALL NOTES AND ALL OTHER SHEETS.



DATE	BY	CHECKED	DATE

PROJECT NUMBER: 1000000000
 SHEET: 1000000000