


32340

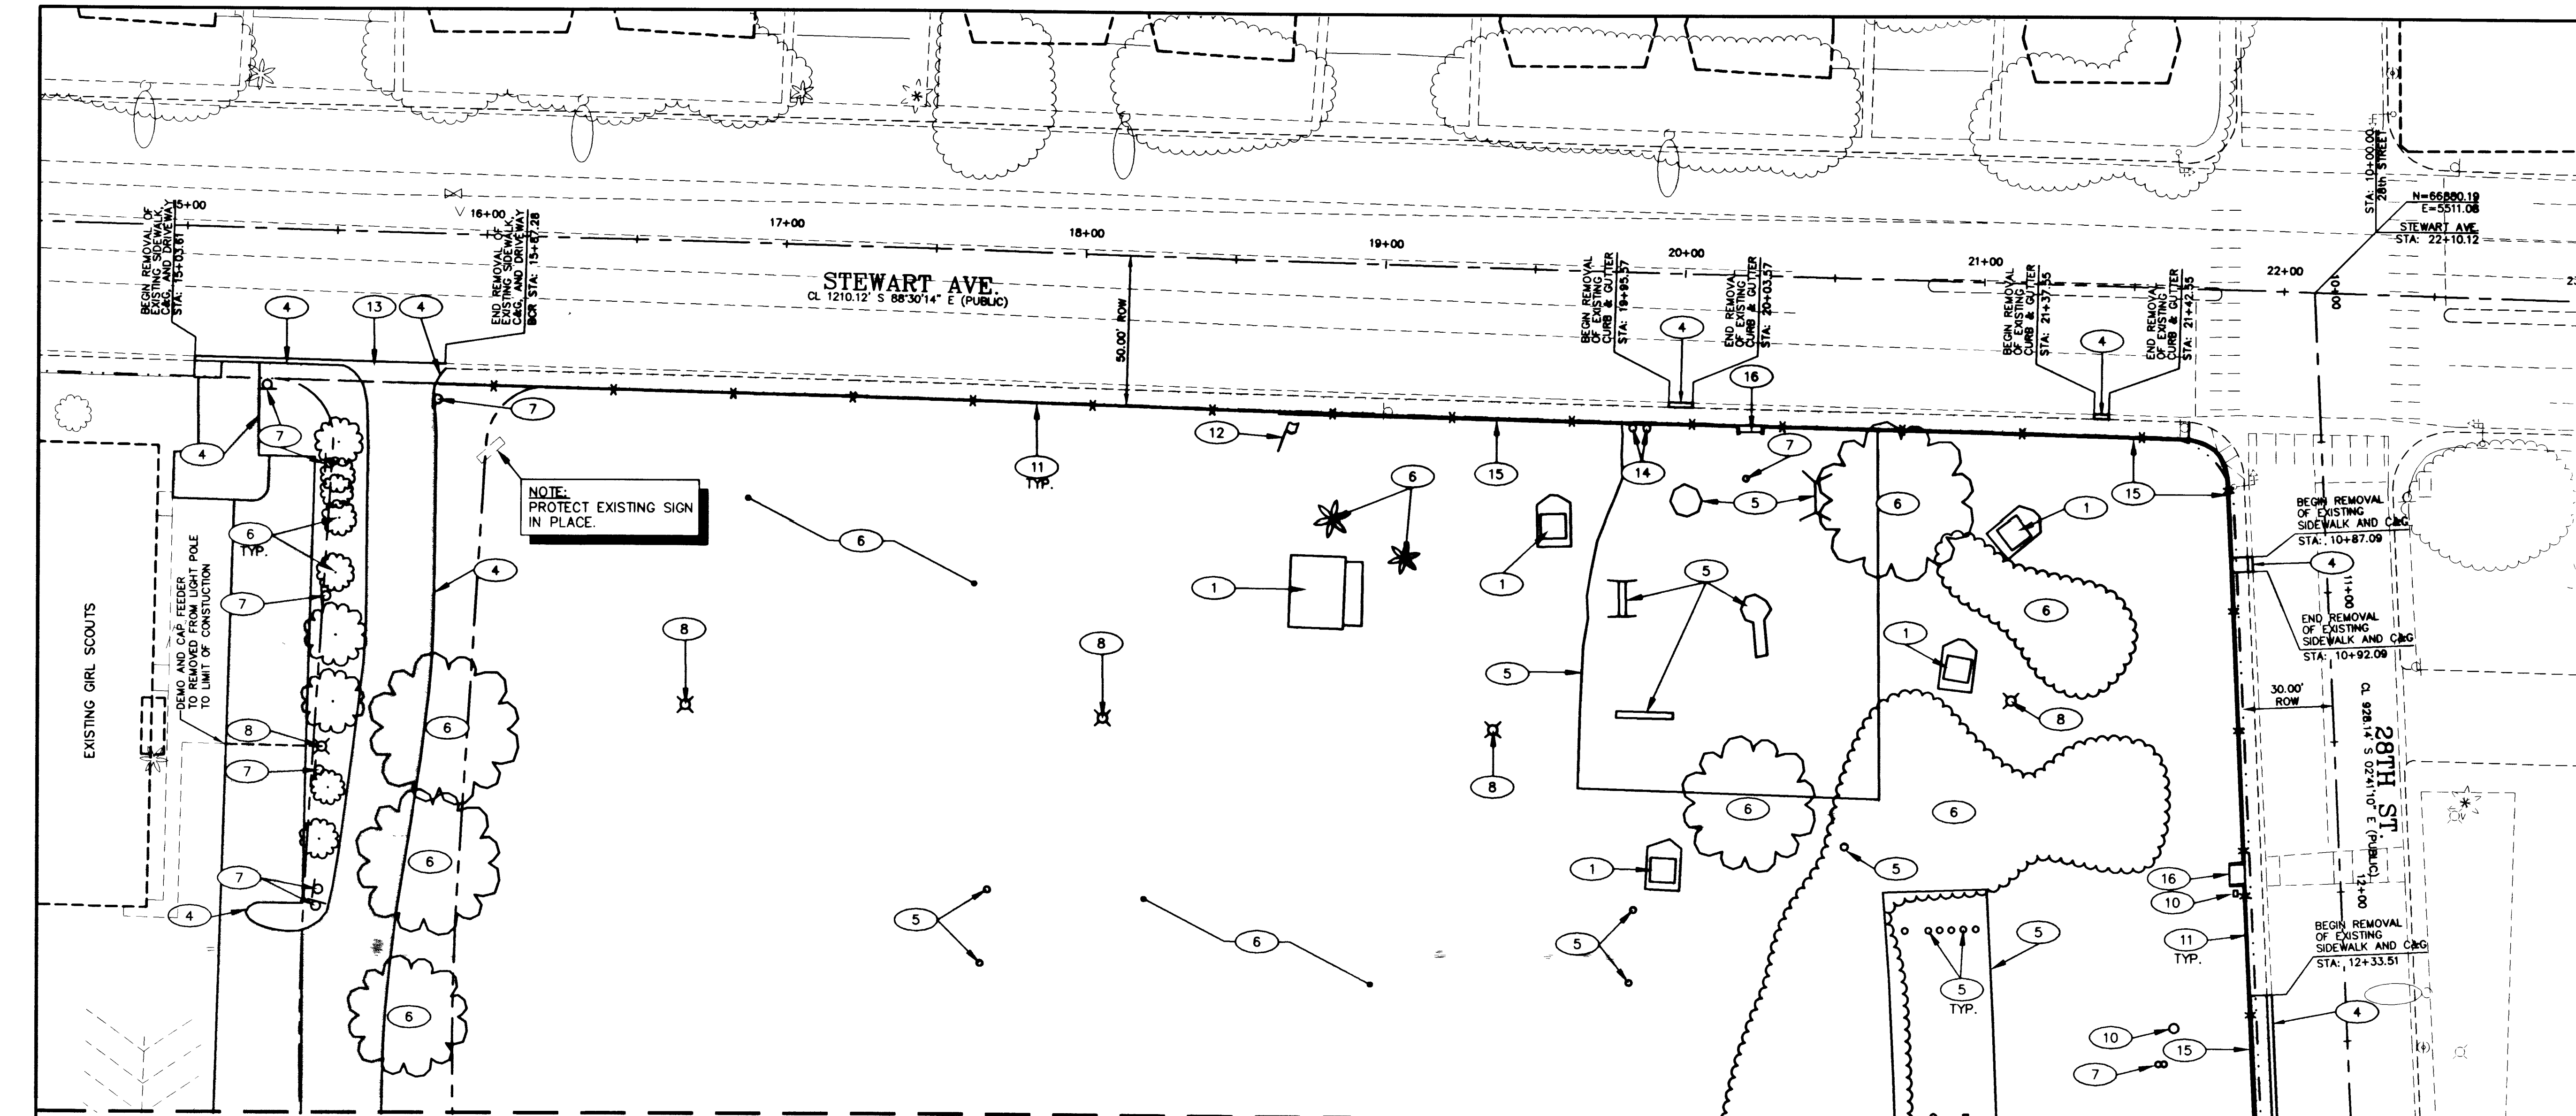

MATCHLINE - SEE SHT. C2.01


DEMOLITION NOTES:

- REMOVE EXISTING ASPHALT CONCRETE PAVEMENT.
- REMOVE EXISTING CONCRETE SIDEWALK.
- 1 REMOVE EXISTING BUILDING AND/OR PARK STRUCTURE.
- 2 REMOVE EXISTING BALL FIELD.
- 3 REMOVE EXISTING PAVEMENT MARKING, PARKING SIGNS, BUMPERS, ETC.
- 4 REMOVE EXISTING CURB, CURB AND GUTTER (WHERE APPLICABLE).
- 5 REMOVE EXISTING PLAYGROUND AREA AND/OR PARK EQUIPMENT.
- 6 REMOVE EXISTING LANDSCAPE.
- 7 REMOVE AND/OR RELOCATE EXISTING SIGN.
- 8 REMOVE AND RETURN STREET/PARK LIGHT POLE/S TO CITY OF LAS VEGAS YARDS AT 3104 E. BONANZA ROAD. CALL 24 HOURS BEFORE RETURNING AT 229-6331.
- 9 REMOVE EXISTING BALL FIELD LIGHT AND RELOCATE PER ELECTRICAL PLANS.
- 10 EXISTING ELECTRICAL UTILITIES, SEE ELECTRICAL PLANS FOR WORK TO BE PERFORMED.
- 11 REMOVE EXISTING FENCE.
- 12 REMOVE EXISTING FLAG POLE.
- 13 REMOVE EXISTING DEPRESSED DRIVEWAY.
- 14 REMOVE EXISTING BOLLARD.
- 15 REMOVE EXISTING WALL.
- 16 REMOVE EXISTING STEPS.
- 17 ABANDON IN PLACE EXISTING SANITARY SEWER LINE OR MANHOLE, AND CAP AS SHOWN ON SHEET C5.02.
- 18 REMOVE AND RELOCATE EXISTING SCOREBOARD PER ELECTRICAL PLANS.
- 19 EXISTING OVERHEAD POWER POLE WITH GUY WIRES (WHERE APPLICABLE) TO BE REMOVED AND POWER RELOCATED UNDERGROUND BY OTHERS.

IMPORTANT NOTE TO CONTRACTOR:
IT SHALL BE THE RESPONSIBILITY OF THE CONTRACTOR TO IDENTIFY ALL UNDERGROUND UTILITIES (KNOWN & UNKNOWN) PRIOR TO COMMENCEMENT OF DEMOLITION WORK.

DEMOLITION NOTE:
ALL EQUIPMENT NOT USED MUST BE RETURNED TO CLV.

NOTE:
REMOVE AND RELOCATE THE FOLLOWING ITEMS PER LANDSCAPE PLANS:
THREE (3) EXISTING DRINKING FOUNTAINS
FIVE (5) EXISTING BLEACHERS
TWO (2) EXISTING FOUL POLES

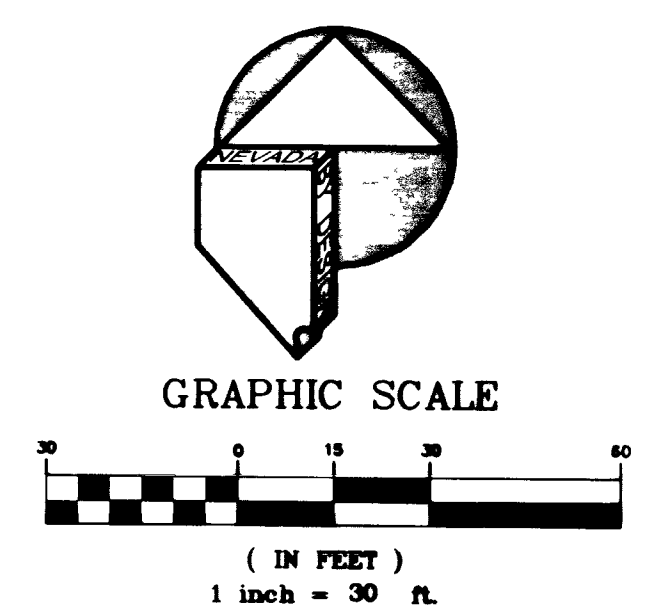

BENCHMARK
CLV BM 2LV0136W4: RIVET & PLATE IN TOP OF CURB, S.E. RETURN, STEWART AVENUE AND EASTERN AVENUE, ELEVATION: 1846.08' (NAVD88)

BASIS OF BEARING
S 44°48'20" E, BEING THE GRID BEARING BETWEEN CLARK COUNTY GIS CONTROL POINTS 816 AND 827, AS SHOWN ON A RECORD OF SURVEY IN FILE 88, PAGE 53 OF SURVEYS, OFFICIAL RECORDS, CLARK COUNTY, NEVADA.

SAFETY ALERT
Call Before You Overhead
1-702-593-6111

Avoid cutting underground utility lines. It's costly.
Call before you Dig
1-800-227-2600

REVISIONS			
REV	DESCRIPTION	DATE	BY

JMA ARCHITECTURE STUDIOS 2000

KEY MAP

DO NOT SCALE DRAWINGS

PROVIDING THE BEST DESIGN SERVICES TODAY

NEVADA BY DESIGN
3515 East Harmon Avenue
Las Vegas, Nevada 89121
702/338-1535 - fax
702/338-1536 - cell

CLARK COUNTY SCHOOL DISTRICT
CONSTRUCTION MANAGEMENT
4828 PEARL ST.

SUNRISE ACRES ELEMENTARY SCHOOL

DEMOLITION PLAN - SHEET 1

SHEET NO. **C2.00**
SHEET 3 of 26
DRAWING NUMBER 715-134