


MATCHLINE - SEE SHT. C2.01

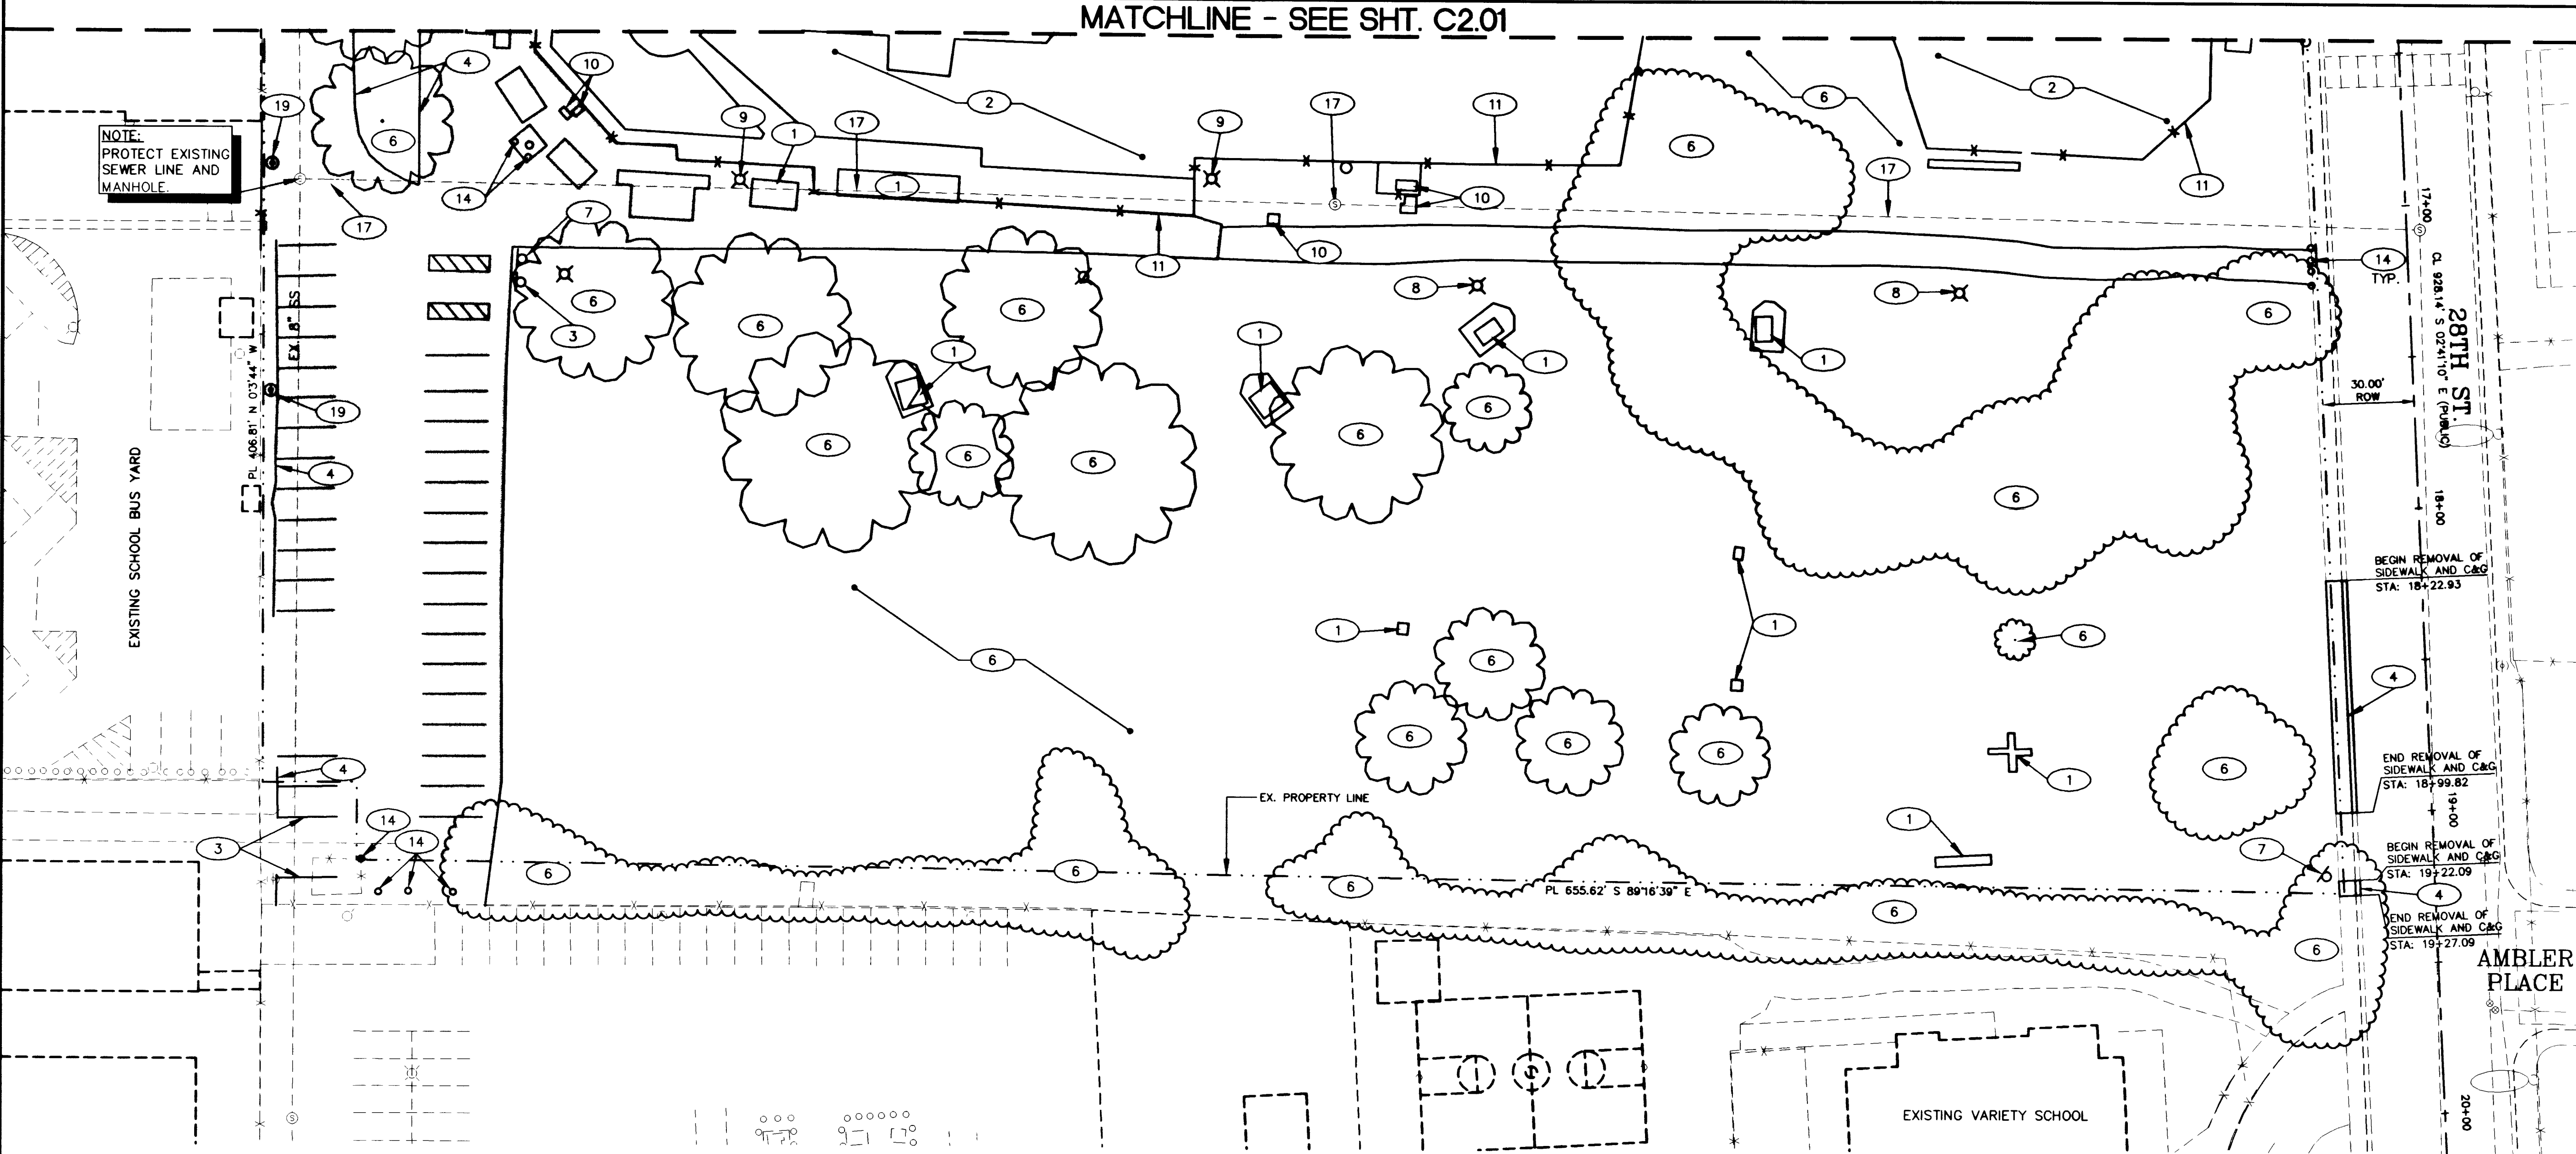

NOTE:
PROTECT EXISTING
SEWER LINE AND
MANHOLE.

EXISTING SCHOOL BUS YARD

28TH ST.
CL. 928.14' S 02°41'0" E (PUB. CO.)
17+00
18+00
19+00
20+00
30.00' ROW

BEGIN REMOVAL OF
SIDEWALK AND C&G
STA: 18+22.93


END REMOVAL OF
SIDEWALK AND C&G
STA: 18+99.82

BEGIN REMOVAL OF
SIDEWALK AND C&G
STA: 19+22.09

END REMOVAL OF
SIDEWALK AND C&G
STA: 19+27.09

AMBLER PLACE

EXISTING VARIETY SCHOOL

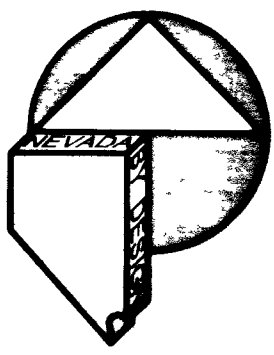

GRAPHIC SCALE
(IN FEET)
1 inch = 30 ft.

DEMOLITION NOTES:

- REMOVE EXISTING ASPHALT CONCRETE PAVEMENT.
- REMOVE EXISTING CONCRETE SIDEWALK.
- 1 REMOVE EXISTING BUILDING AND/OR PARK STRUCTURE.
- 2 REMOVE EXISTING BALL FIELD.
- 3 REMOVE EXISTING PAVEMENT MARKING, PARKING SIGNS, BUMPERS, ETC.
- 4 REMOVE EXISTING CURB, CURB AND GUTTER (WHERE APPLICABLE).
- 5 REMOVE EXISTING PLAYGROUND AREA AND/OR PARK EQUIPMENT.
- 6 REMOVE EXISTING LANDSCAPE.
- 7 REMOVE AND/OR RELOCATE EXISTING SIGN.
- 8 REMOVE AND RETURN STREET/PARK LIGHT POLE/S TO CITY OF LAS VEGAS YARDS AT 3104 E. BONANZA ROAD. CALL 24 HOURS BEFORE RETURNING AT 229-6331.
- 9 REMOVE EXISTING BALL FIELD LIGHT AND RELOCATE PER ELECTRICAL PLANS.
- 10 EXISTING ELECTRICAL UTILITIES, SEE ELECTRICAL PLANS FOR WORK TO BE PERFORMED.
- 11 REMOVE EXISTING FENCE.
- 12 REMOVE EXISTING FLAG POLE.
- 13 REMOVE EXISTING DEPRESSED DRIVEWAY.
- 14 REMOVE EXISTING BOLLARD.
- 15 REMOVE EXISTING WALL.
- 16 REMOVE EXISTING STEPS.
- 17 ABANDON IN PLACE EXISTING SANITARY SEWER LINE OR MANHOLE, AND CAP AS SHOWN ON SHEET C5.02.
- 18 REMOVE AND RELOCATE EXISTING SCOREBOARD PER ELECTRICAL PLANS.
- 19 EXISTING OVERHEAD POWER POLE WITH GUY WIRES (WHERE APPLICABLE) TO BE REMOVED AND POWER RELOCATED UNDERGROUND BY OTHERS.

IMPORTANT NOTE TO CONTRACTOR:
IT SHALL BE THE RESPONSIBILITY OF THE CONTRACTOR TO IDENTIFY ALL UNDERGROUND UTILITIES (KNOWN & UNKNOWN) PRIOR TO COMMENCEMENT OF DEMOLITION WORK.

DEMOLITION NOTE:
ALL EQUIPMENT NOT USED MUST BE RETURNED TO CLV.


NOTE:
REMOVE AND RELOCATE THE FOLLOWING ITEMS PER LANDSCAPE PLANS.
THREE (3) EXISTING DRINKING FOUNTAINS
FIVE (5) EXISTING BLEACHERS
TWO (2) EXISTING FOUL POLES

BENCHMARK
CLV BM 2LV013694: RIVET & PLATE IN TOP OF CURB, S.E. RETURN, STEWART AVENUE AND EASTERN AVENUE, ELEVATION: 1846.08' (NAV088)

BASIS OF BEARING
S 44°48'20" E, BEING THE GRID BEARING BETWEEN CLARK COUNTY GIS CONTROL POINTS 816 AND 827, AS SHOWN ON A RECORD OF SURVEY IN FILE 88, PAGE 53 OF SURVEYS, OFFICIAL RECORDS, CLARK COUNTY, NEVADA.

SAFETY ALERT
Call Before You Dig
1-702-593-6111
Call before you Dig
1-800-227-2600

REVISIONS			
REV	DESCRIPTION	DATE	BY

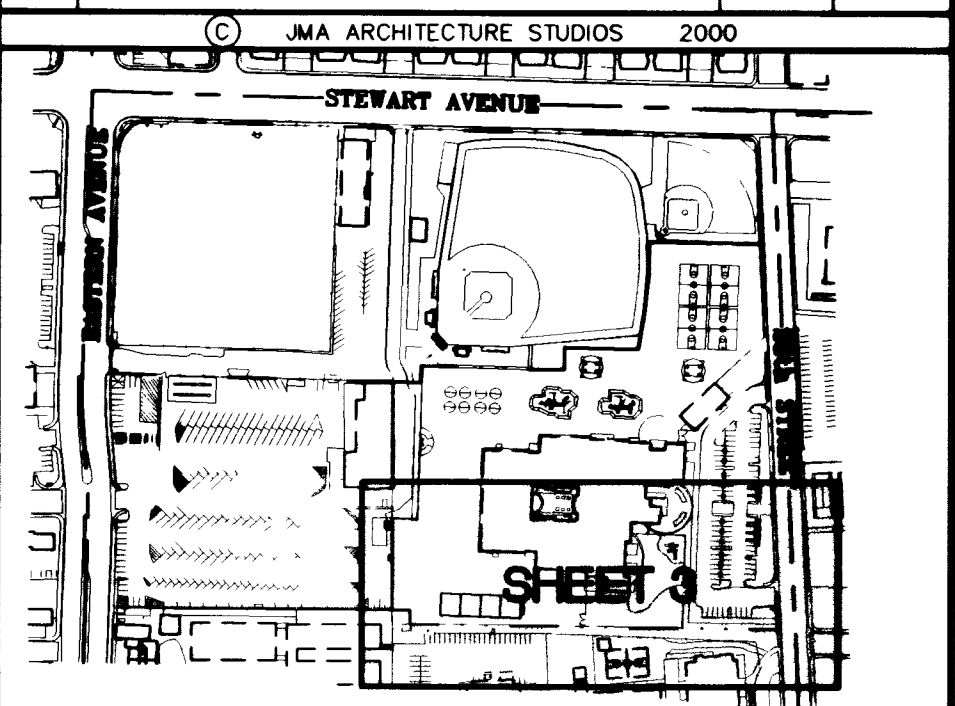

DO NOT SCALE DRAWINGS

CLV PROJECT NO. 1702771-1001	CLV REVIEW	APPROVED BY	DATE
FILE NO. 1702771-1001	DESIGN	DATE	DATE
CLV PROJECT NO. 1702771-1001	DESIGN	DATE	DATE
CLV PROJECT NO. 1702771-1001	DESIGN	DATE	DATE

NEVADA
BY
DESIGN

3515 East Harmon Avenue
Las Vegas, Nevada 89121
702/338-1335 - Tel
702/338-1330 - Fax

NEVADA
PROVIDING
TODAY'S
DESIGN

JMA ARCHITECTURE STUDIOS

10100 CONVENT CROSS ROUTE LAS VEGAS, NEVADA 89144 (702)771-1001

CLARK COUNTY SCHOOL DISTRICT
CONSTRUCTION MANAGEMENT
4828 PEARL ST.

SUNRISE ACRES ELEMENTARY SCHOOL

DEMOLITION PLAN - SHEET 3

SHEET NO.
C2.02
SHEET 5 of 26
DRAWING NUMBER
715-134