
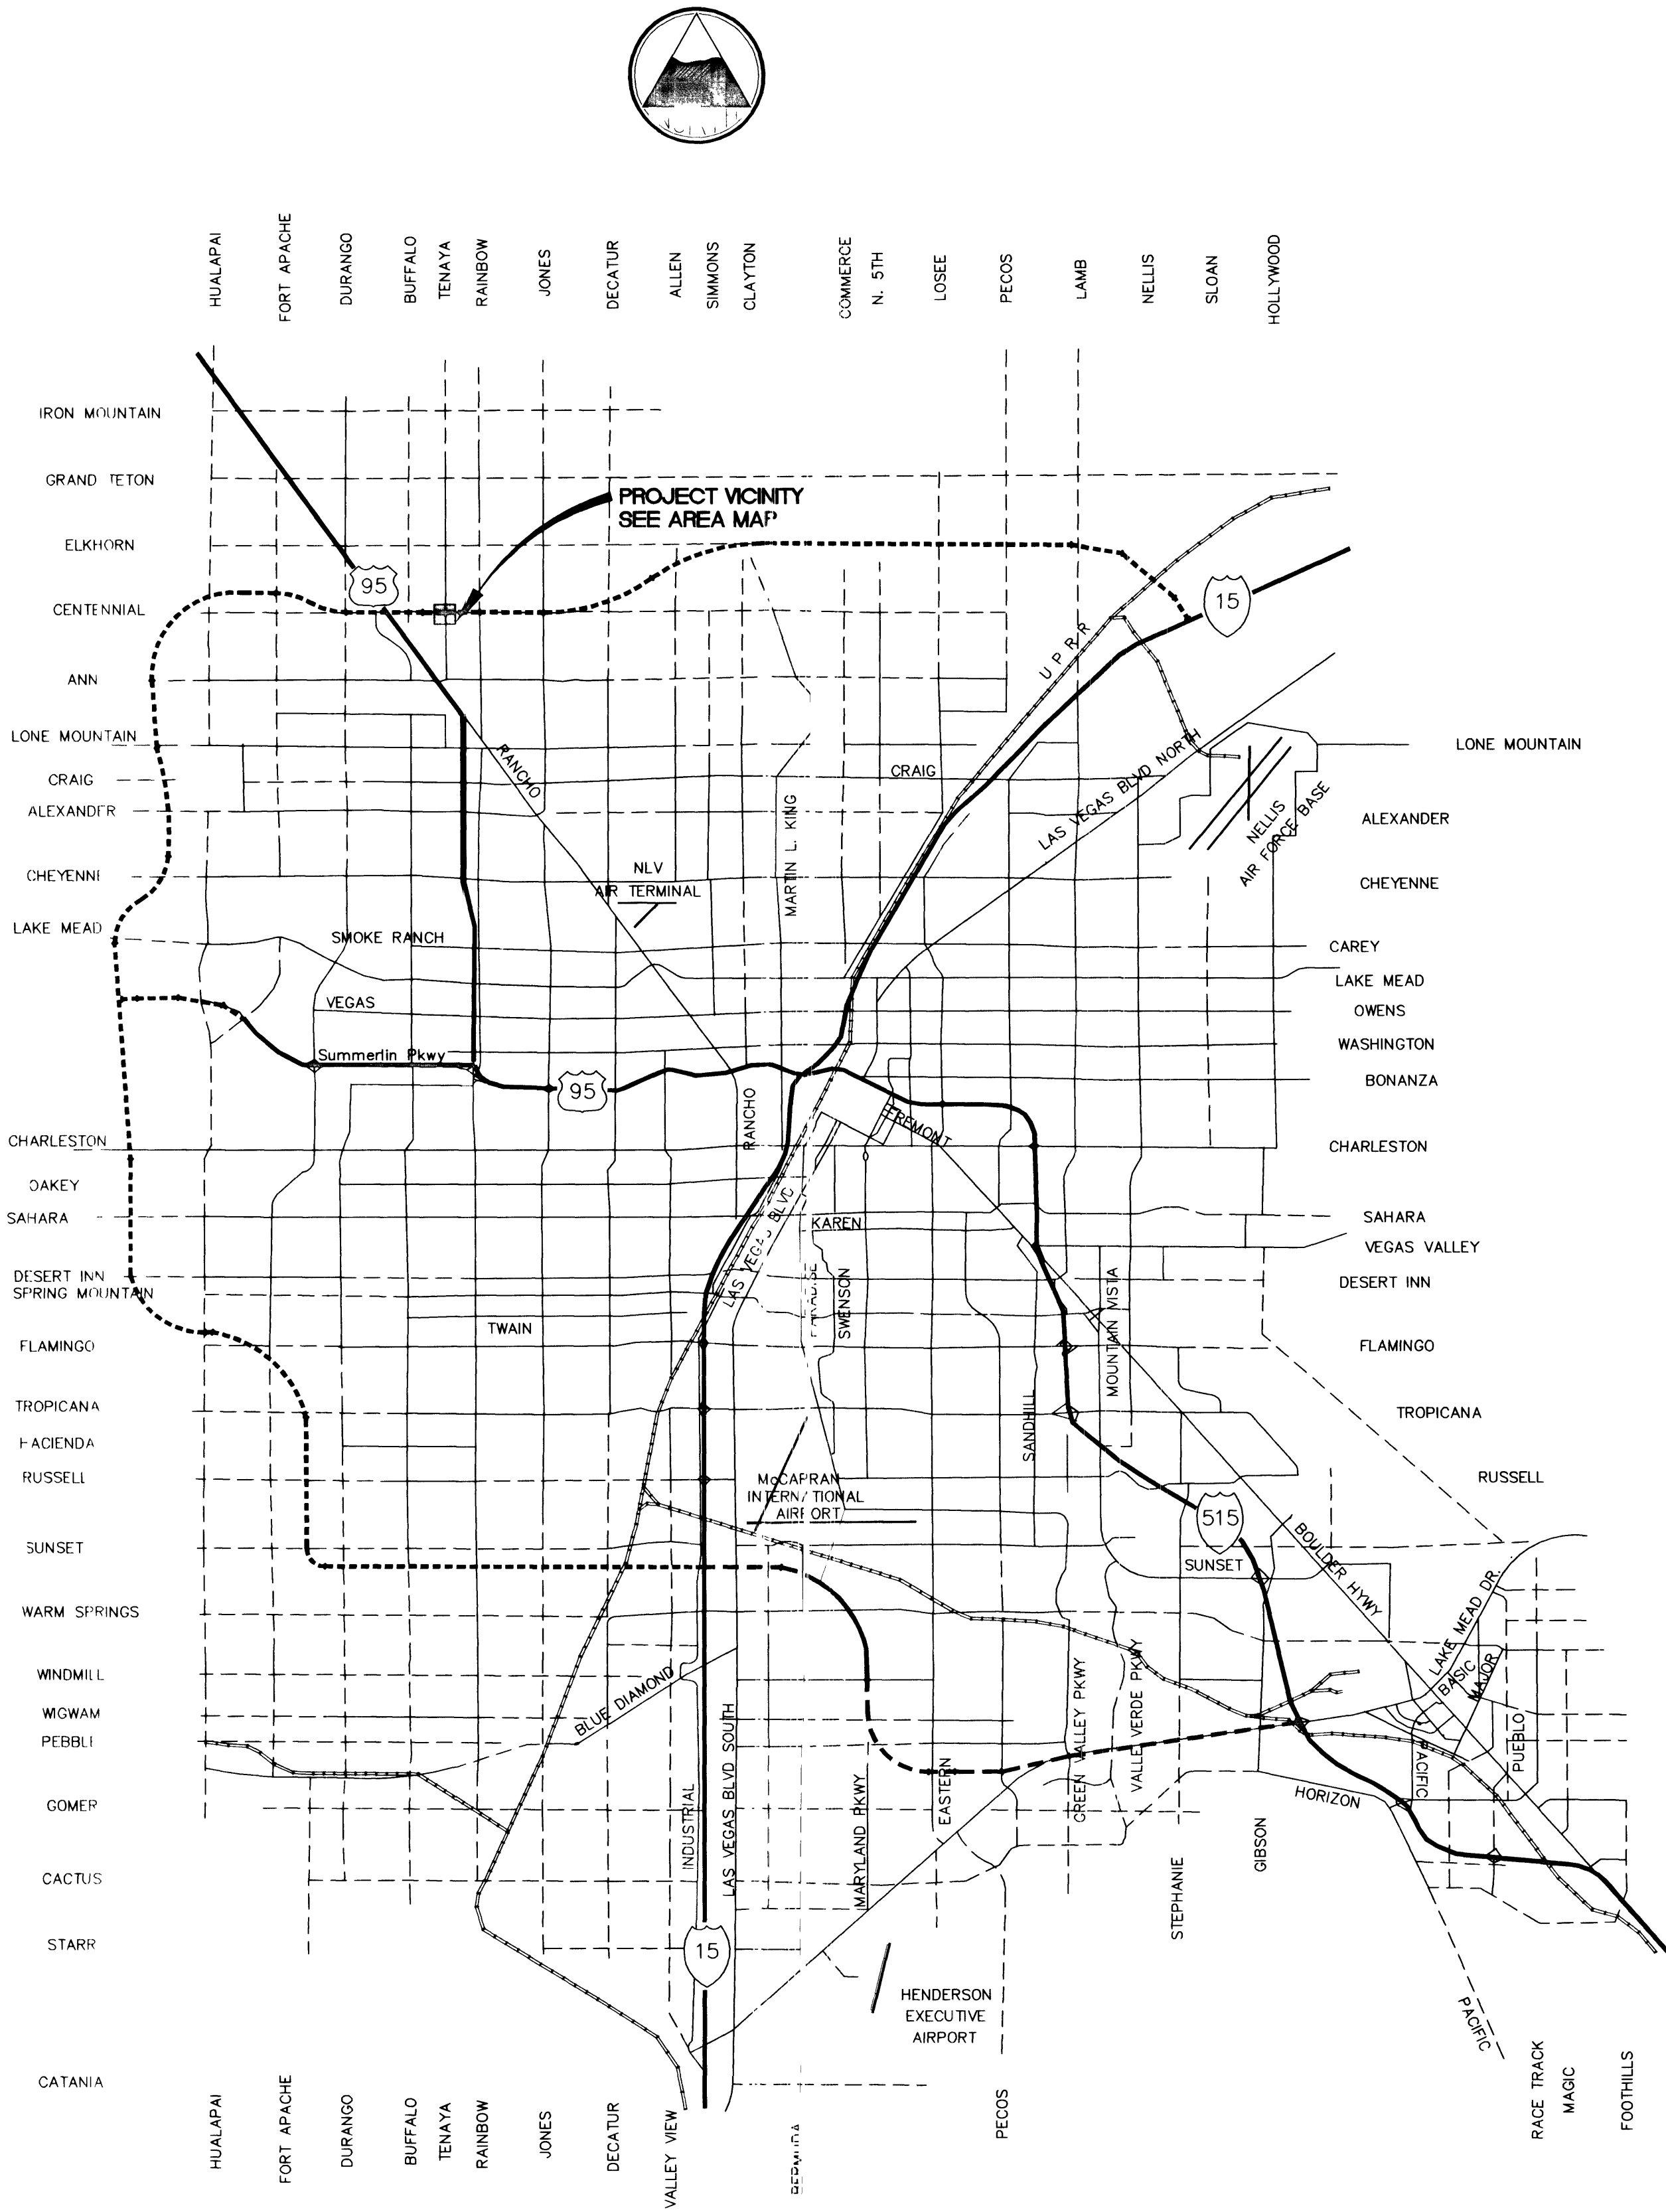


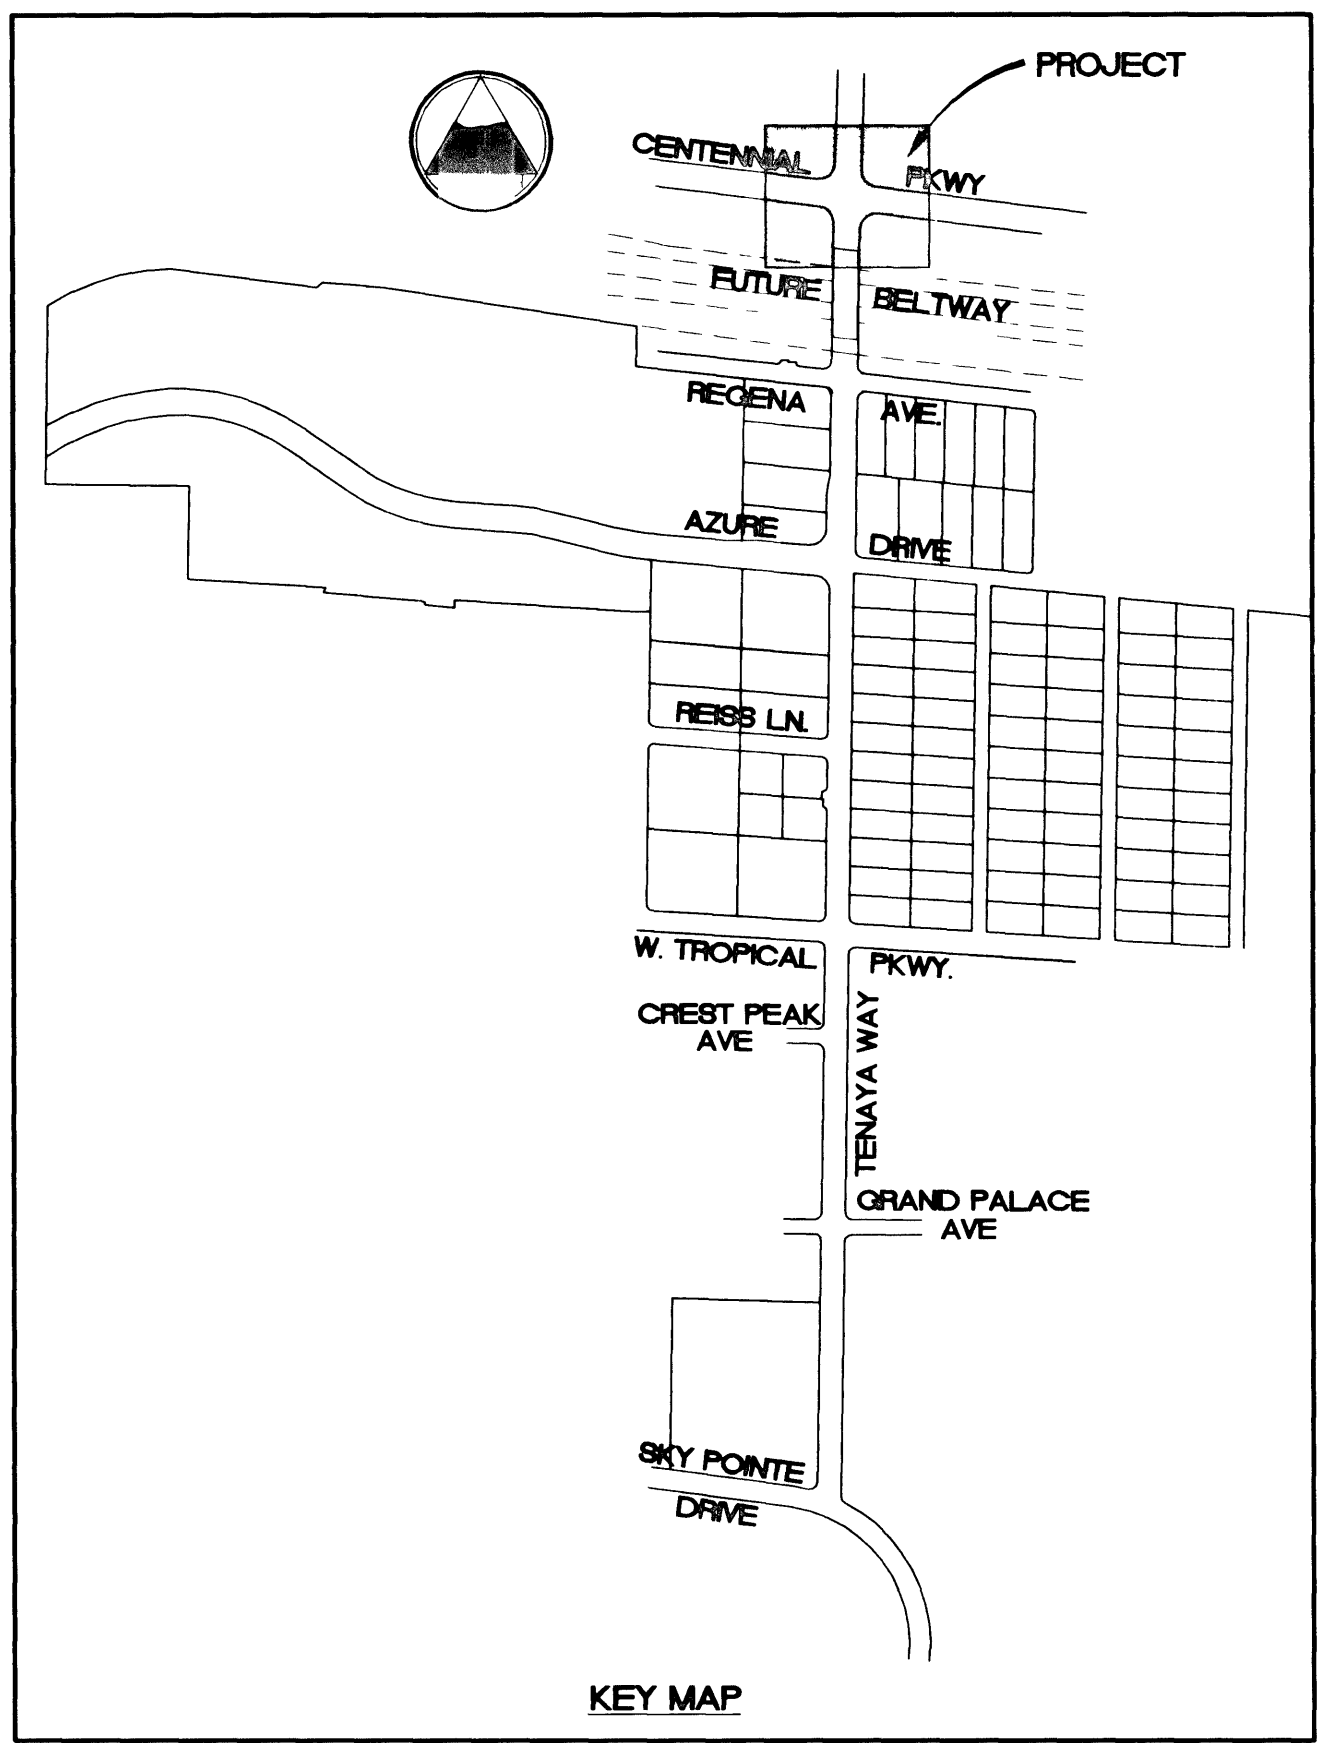

BID GROUP II QUANTITY ESTIMATE									
	A	B	C	E	F	G	H	I	J
	ITEM #	DESCRIPTION	UNIT	SHEET G6	SHEET T5	SHEET STL4	SHEET SD9	SHEET SD10	TOTAL
1	202.04	Remove Asphalt	SY	3,220	-	-	-	-	3,220
2	402.04	5-inch Plantmix Bituminous Surface	SY	6,063	-	-	-	-	6,063
3	403.01	3/4-inch Plantmix Bituminous Open Grade	SY	6,063	-	-	-	-	6,063
4	502.01	6'x4' Reinforced Concrete Box Culvert	LF	-	-	-	285	-	285
5	502.03	6'x4' RCB 45 Degree Bend	EA	-	-	-	1	-	1
6	605.04	24-inch HDPE	LF	-	-	-	-	345	345
7	605.05	18-inch HDPE	LF	-	-	-	-	169	169
8	609.08	Beehive Drop Inlet	EA	-	-	-	-	2	2
9	613.01	Type "L" Curb and Gutter	LF	203	-	-	-	-	203
10	613.05	Concrete Sidewalk	SF	529	-	-	-	-	529
11	613.06	Concrete Sidewalk Ramps	SF	636	-	-	-	-	636
12	623.01	Traffic Signal System at Tenaya & Centennial	LS	-	1	-	-	-	1
13	623.07	#5 Pullboxes	EA	-	-	8	-	-	8
14	623.08	#7 Pullboxes @ 500' Spacing	EA	-	-	2	-	-	2
15	623.09	3" Interconnect Conduit, Sch 40 PVC w/ 25-pair #22 AWG Interconnect Wire	LF	-	-	120	-	-	120
16	623.10	2" St. Lt. Conduit, Sch 40 PVC w/ 2#4, 1#8 THW	LF	-	-	85	-	-	85
17	627.02	Remove and Salvage Existing Sign	EA	4	-	-	-	-	4
18	627.04	Relocate Traffic Sign	EA	2	-	-	-	-	2
19	628.01	Type I Film (Arrow)	EA	-	-	14	-	-	14
20	628.03	Type I Film For Crosswalks and Stop Bars	SF	-	-	1,720	-	-	1,720
21	628.04	Painted Striping (4" Wide)	LF	-	-	2,877	-	-	2,877
22	629.09	Irrigation Wire and Pipe Sleeves (2" / 4")	LF	91	-	-	-	-	91
23	630.07	Eccentric 60" Manhole	EA	-	-	-	1	-	1
24	633.01	Non-Reflective Pavement Markers	EA	-	-	300	-	-	300
25	633.02	Reflective Pavement Markers	EA	-	-	100	-	-	100

SHEET INDEX

SHEET #	SHEET	DESCRIPTION
57	C8	VICINITY MAP AND SHEET INDEX
58	C9	GENERAL NOTES
59	C10	TENAYA WAY HORIZONTAL CONTROL PLAN SKY POINTE TO WEST TROPICAL PARKWAY
60	G6	INTERSECTION GRADING PLAN - TENAYA WAY AND CENTENNIAL PARKWAY
61	T5	TRAFFIC SIGNAL PLAN - TENAYA WAY AND CENTENNIAL PARKWAY
62	STL4	TENAYA WAY STREET LIGHTING AND STRIPING PLAN - STA 43+00 TO 46+00
63	SD9	TENAYA WAY STORM DRAIN PLAN - STA 43+00 TO 48+00
64	SD10	CENTENNIAL PARKWAY STORM DRAIN PLAN - STA 5+00 TO 11+00
65	SDD3	CONSTRUCTION DETAILS

DEPARTMENT OF PUBLIC WORKS
ENGINEERING DESIGN SECTION
CITY ENGINEER: CHARLES KAJKOWSKI, JR., P.E.
PROJECT MANAGER: THERESA M. HANRAHAN, P.E.
1081 CUMARON ROAD, SUITE A-3
LAS VEGAS, NV, 89101
(702) 228-8183
FAX (702) 228-8194

PRIMAS AND ASSOCIATES
CONSULTING ENGINEERS
1081 CUMARON ROAD, SUITE A-3
LAS VEGAS, NV, 89101
(702) 228-8183
FAX (702) 228-8194

SHEET
TENAYA WAY / AZURE DRIVE
VICINITY MAP AND SHEET INDEX

TITLE
TENAYA WAY / AZURE DRIVE
ROADWAY IMPROVEMENTS

DRAWN BY: PACE
DESIGNED BY: LSK
CHECKED BY: [Signature]
PROJECT NO: 907.01001
SCALE: 1"=40'

3/8/01
3/8/01
8/5/01
HORIZ
VERT

SEAL
REGISTERED PROFESSIONAL ENGINEER
CHARLES KAJKOWSKI, JR.
No. 6638
EXPIRATION DATE 08/01/05

SHEET
C8
57 OF 70 SHEETS
DRAWING NO.
107-V3145

REV. DATE BY REVISION

107-V3145