


LAS VEGAS VALLEY WATER DISTRICT STANDARD NOTES

- LVVWD PROJECT # 113678
- 1) NO WORK SHALL BEGIN UNTIL THE WATER PLANS HAVE BEEN APPROVED FOR CONSTRUCTION BY THE LVVWD. FOLLOWING WATER PLAN APPROVAL, NOTICE SHALL BE GIVEN TO THE LVVWD COMMUNICATION SUPPORT CENTER (258-7171) TWO (2) WORKING DAYS PRIOR TO THE START OF CONSTRUCTION. FOR FUTURE INSPECTIONS, NOTICE MUST BE GIVEN BY 2:00 PM THE BUSINESS DAY PRIOR TO THE REQUESTED LVVWD INSPECTION. WHEN REQUESTING INSPECTIONS, PLEASE REFER TO THE PROJECT # IDENTIFIED ABOVE.
- 2) ALL WORK SHALL CONFORM TO THE LVVWD'S STANDARD PLATES, DRAWINGS, AND SPECIFICATIONS AND TO THE 2003 EDITION OF THE UNIFORM DESIGN AND CONSTRUCTION STANDARDS FOR POTABLE WATER SYSTEMS (UDACS).
- 3) ALL WORK, EXCEPT AS MODIFIED BY THESE PLANS OR BY NOTE 2 ABOVE, SHALL BE DONE IN ACCORDANCE WITH THE MOST RECENT DRAFT OR EDITION OF THE UNIFORM STANDARD SPECIFICATIONS FOR PUBLIC WORKS CONSTRUCTION OFFSITE IMPROVEMENT, CLARK COUNTY AREA.
- 4) A SINGLE PIPE MATERIAL SHALL BE USED THROUGHOUT THE PROJECT UNLESS OTHERWISE APPROVED BY THE LVVWD.
- 5) ALL SERVICE LATERALS TWO (2) INCHES IN DIAMETER AND SMALLER SHALL BE TYPE K COPPER TUBING WITH LVVWD APPROVED SERVICE SADDLES.
- 6) ALL WATER METER BOXES SHALL BE LOCATED OUTSIDE OF DRIVEWAY AREAS.
- 7) ALL VALVES SHALL BE LOCATED OUTSIDE OF DRIVEWAYS, VALLEY AND CURB GUTTERS.
- 8) ALL WATER AND STORM DRAIN OR SANITARY SEWER CROSSINGS SHALL CONFORM TO SECTION 2.19 OF THE 2003 EDITION OF THE UDACS.
- 9) ALL WATER FACILITIES SHALL BE FILLED, DISINFECTED, PRESSURE TESTED, FLUSHED, FILLED AND AN ACCEPTABLE WATER SAMPLE OBTAINED, PRIOR TO CONNECTION TO THE LVVWD'S DISTRIBUTION SYSTEM.
- 10) THE CONTRACTOR MUST OBTAIN ALL METERS TWO (2) INCHES AND SMALLER FROM LVVWD CENTRAL STORES. TELEPHONE 258-3152 OR 258-3802, TWO (2) WORKING DAYS PRIOR TO METER PICKUP.
- 11) ANY INTERRUPTION OF SERVICE MUST PERFORMED IN ACCORDANCE WITH UDACS SECTION 3.13.01, & APPROVED BY THE LVVWD INSPECTION DIVISION PRIOR TO SHUTDOWN. PROPER WRITTEN NOTIFICATION MUST BE GIVEN TO ALL AFFECTED CUSTOMERS.
- 12) ALL WATER FACILITY CONSTRUCTION MATERIALS USED MUST BE AS LISTED ON THE LVVWD PRE-APPROVED MATERIALS AND MANUFACTURER'S LISTING FOR NEW FACILITIES, LATEST REVISION, OR SPECIFICALLY APPROVED ON THESE PLANS.
- 13) TELEPHONE "CALL BEFORE YOU DIG" AT 1-800-227-2600.

APPROVED FOR CONSTRUCTION

LVVWD (PROJECT #113678) DATE 11-15-07

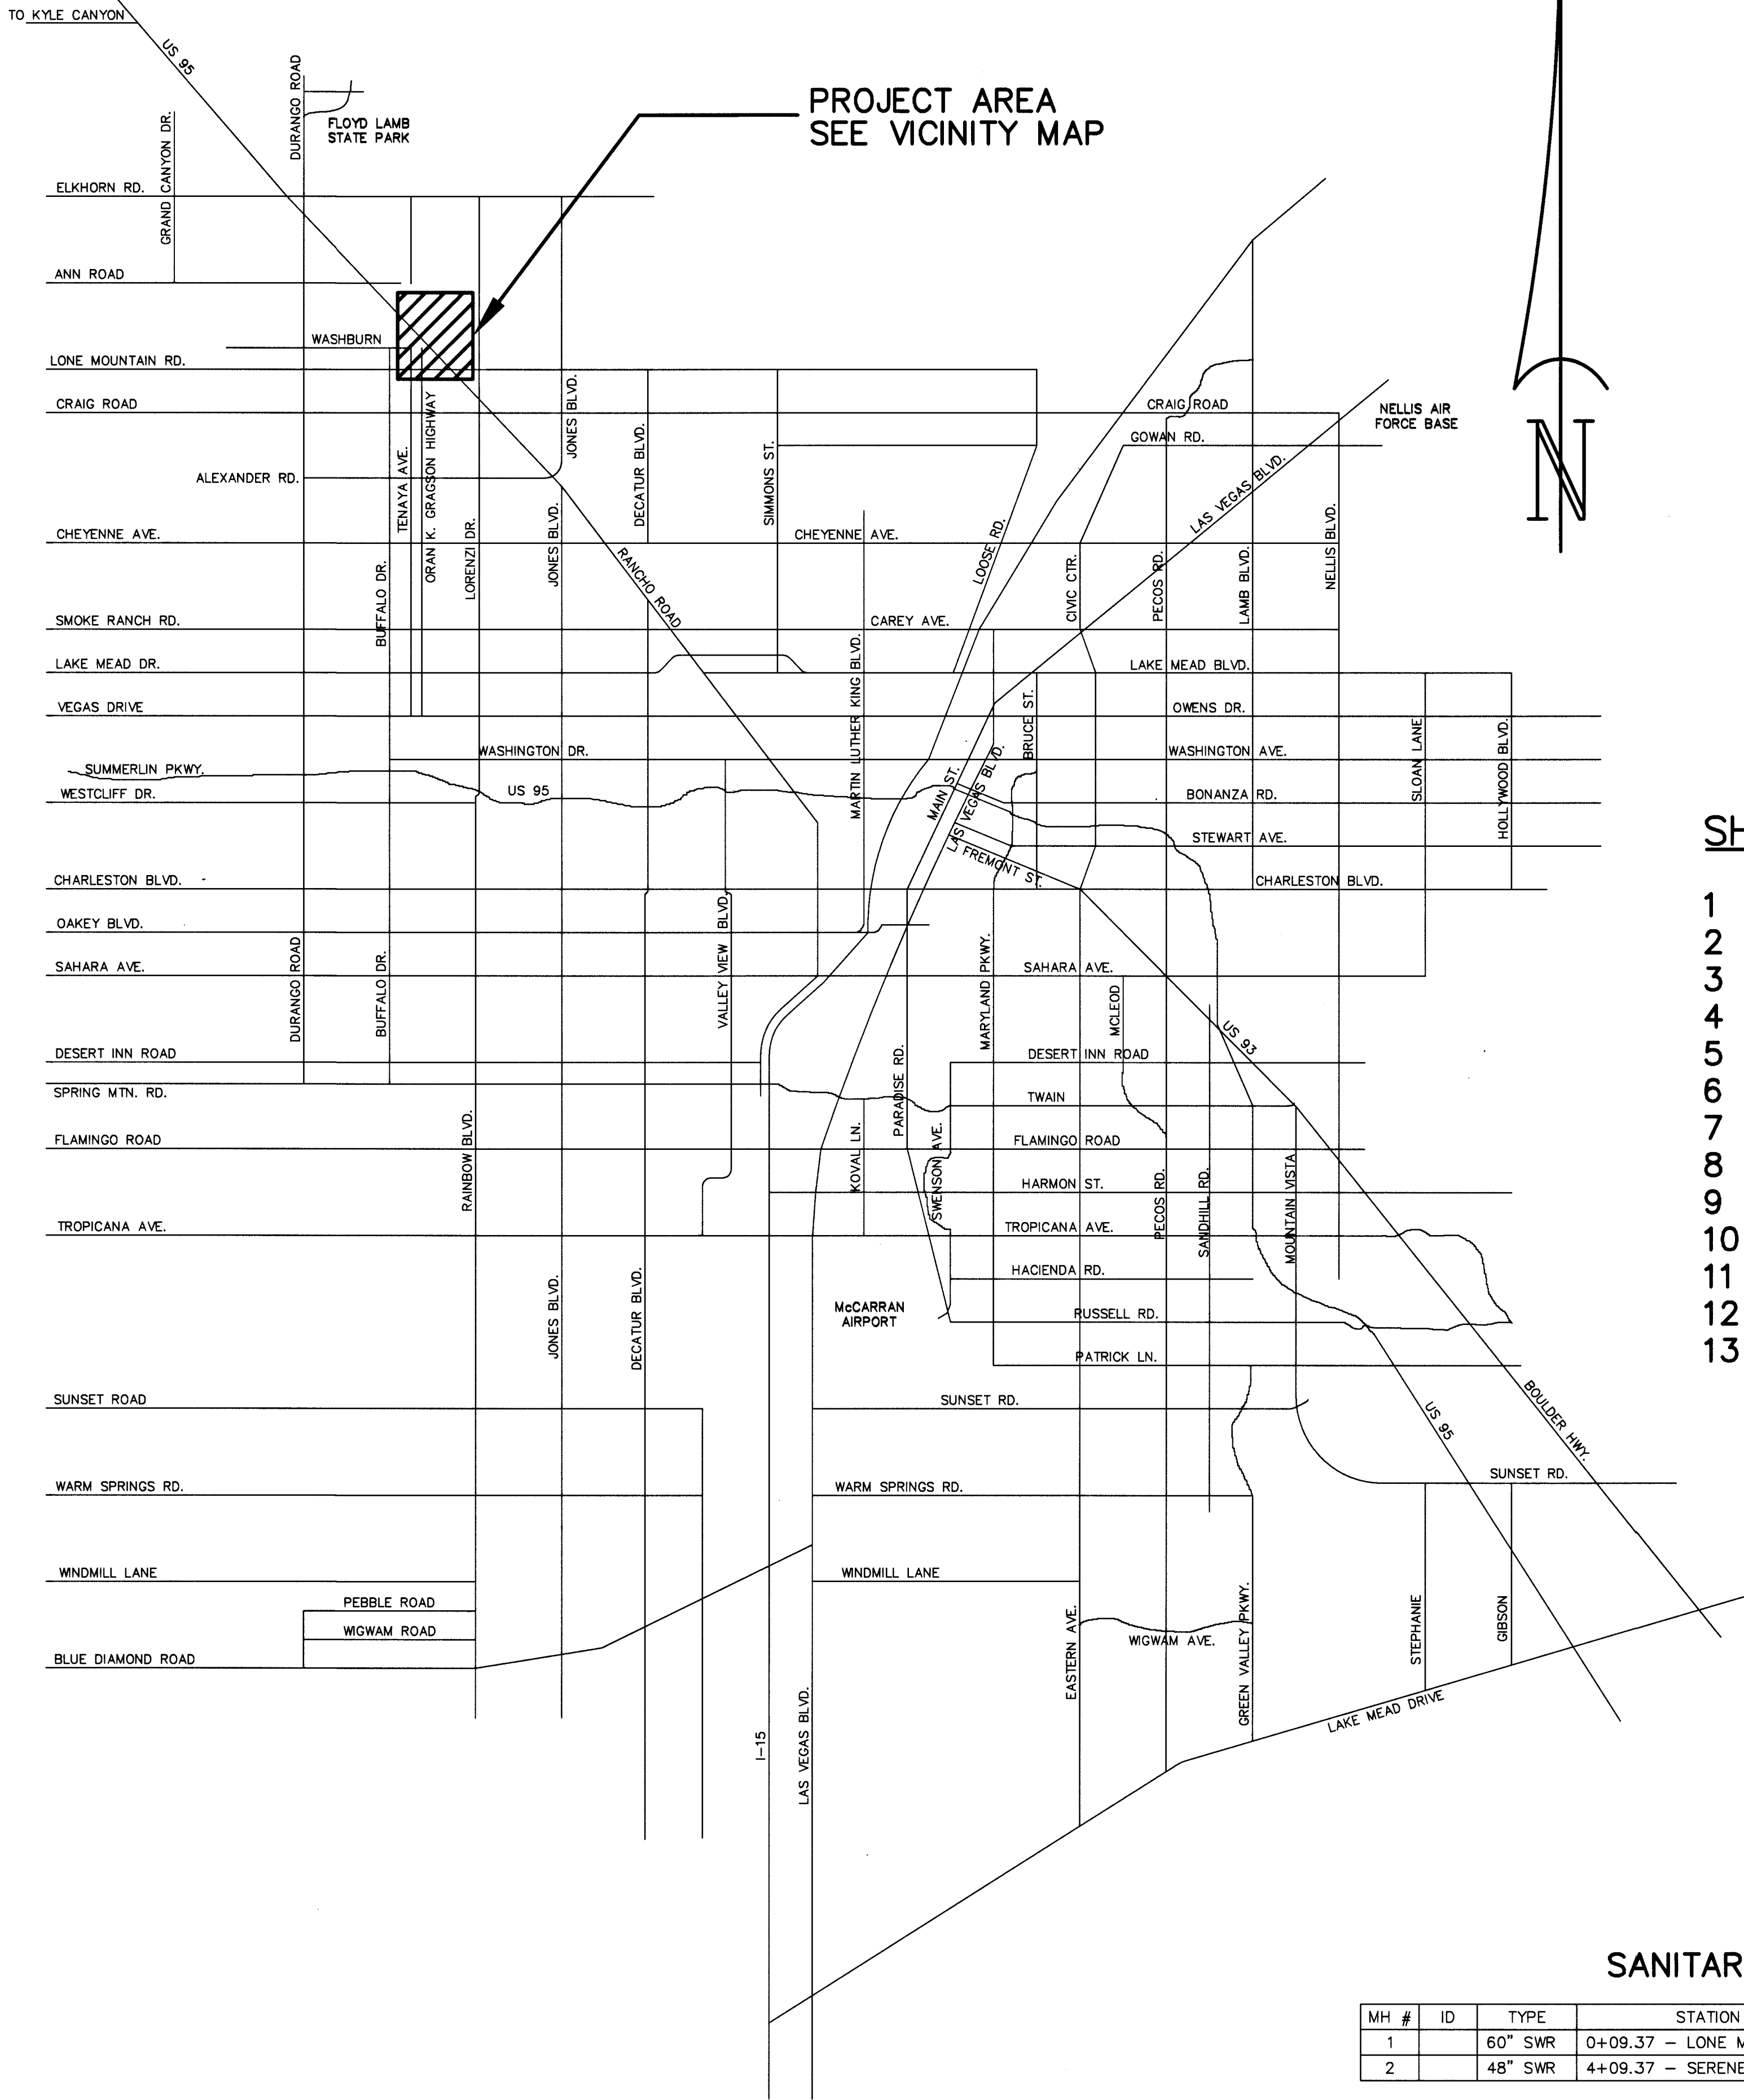


SHEET INDEX

- 1 COVER SHEET
- 2 VICINITY MAP
- 3 GENERAL NOTES
- 4 DEMOLITION PLAN
- 5 GRADING PLAN (NW)
- 6 GRADING PLAN (NE)
- 7 GRADING PLAN (SE)
- 8 UTILITY PLAN
- 9 STREET LIGHT & TRAFFIC PLAN
- 10 SEWER PLAN & PROFILE – Serene Dr.
- 11 STREET PLAN & PROFILE – Lone Mtn Rd.
- 12 SECTIONS
- 13 DETAILS

SANITARY SEWER MANHOLE SCHEDULE

MH #	ID	TYPE	STATION	OFFSET	RIM EL.	INV 8" IN	INV THRU	COMMENTS
1		60" SWR	0+09.37 - LONE MOUNTAIN	6.40' LT	2314.7 ±	2304.63	2302.8 ±	
2		48" SWR	4+09.37 - SERENE DRIVE	15.00' LT	2314.4 ±		2306.63	

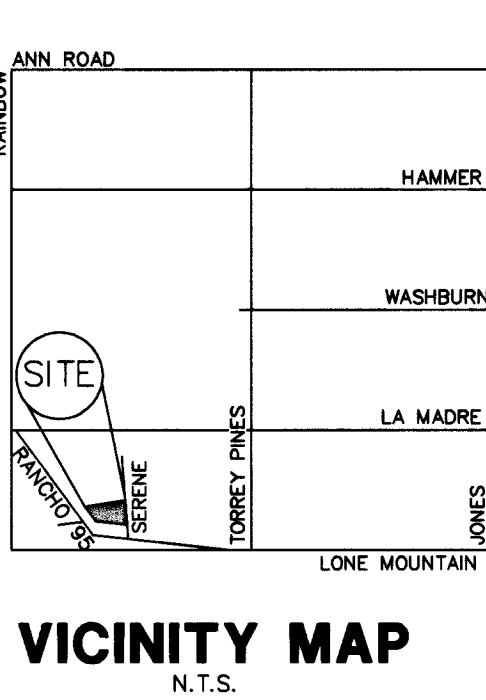

DATE	
APP BY	
SHT #	
DESCRIPTION	
REV #	

DUNNAM CIVIL ENGINEERS
3471 WEST OQUENDO ROAD SUITE 202
LAS VEGAS, NV 89118
(702) 798-1088 (702) 798-3688 FAX

THE ANNEX
VICINITY MAP

109684
106014

18912

FILE NAME:
KALB55F2.dwg
SCALE:
1" = 1'
SHEET
2
OF THIRTEEN
CLV DRAWING #
107V4960