


MATCHLINE SEE SHEET 60

VILLAGE 23A
PARCEL I



PASEO MIST DRIVE
SPOKE-A-ROAD

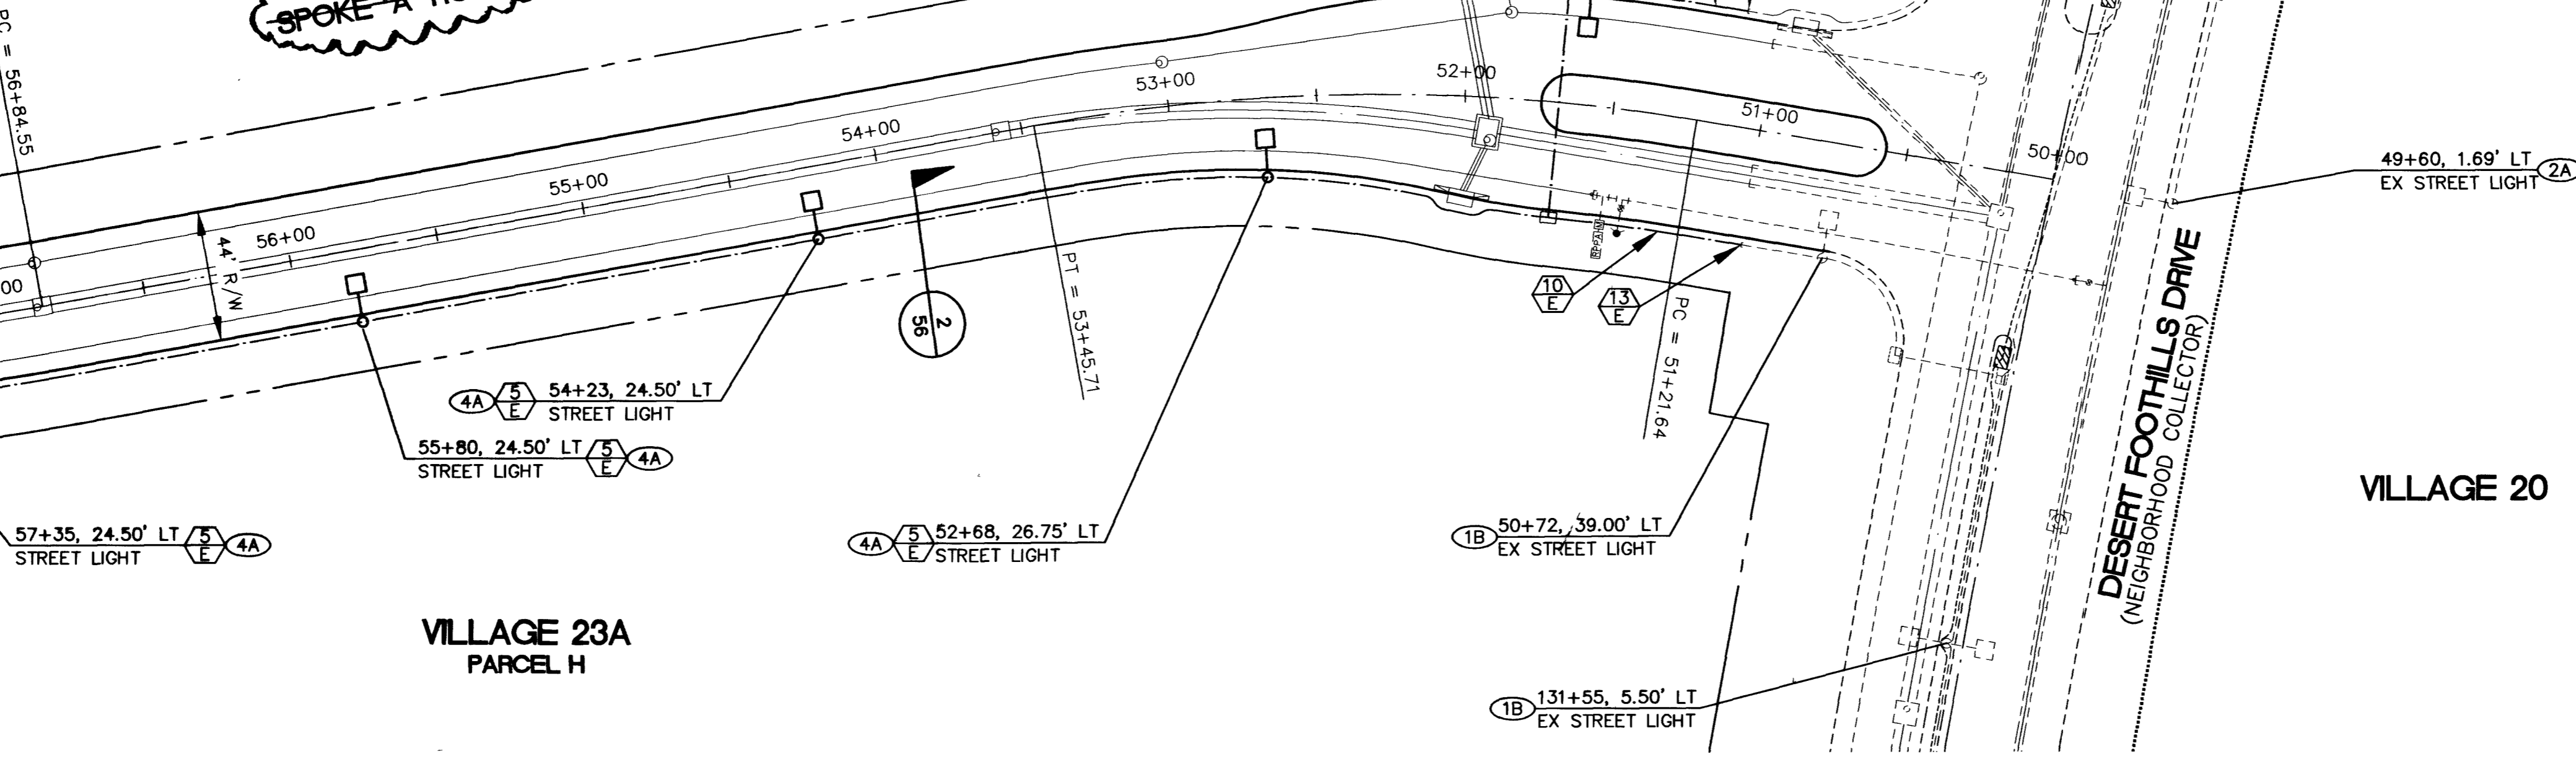

VILLAGE 23A
PARCEL H



VILLAGE 20

DESERT FOOTHILLS DRIVE
(NEIGHBORHOOD COLLECTOR)

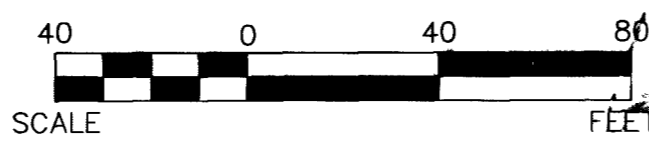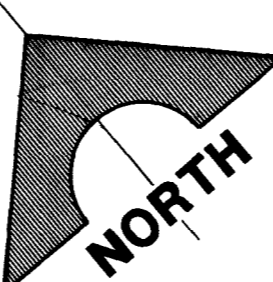


MATCHLINE SEE SHEET 57

CUL DE SAC 'A'
PASEO FLOWER COURT

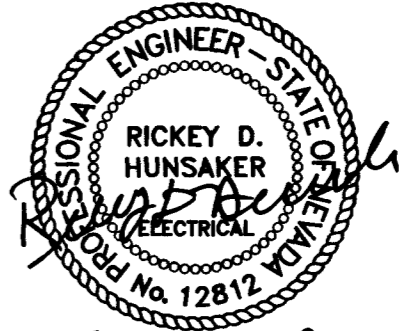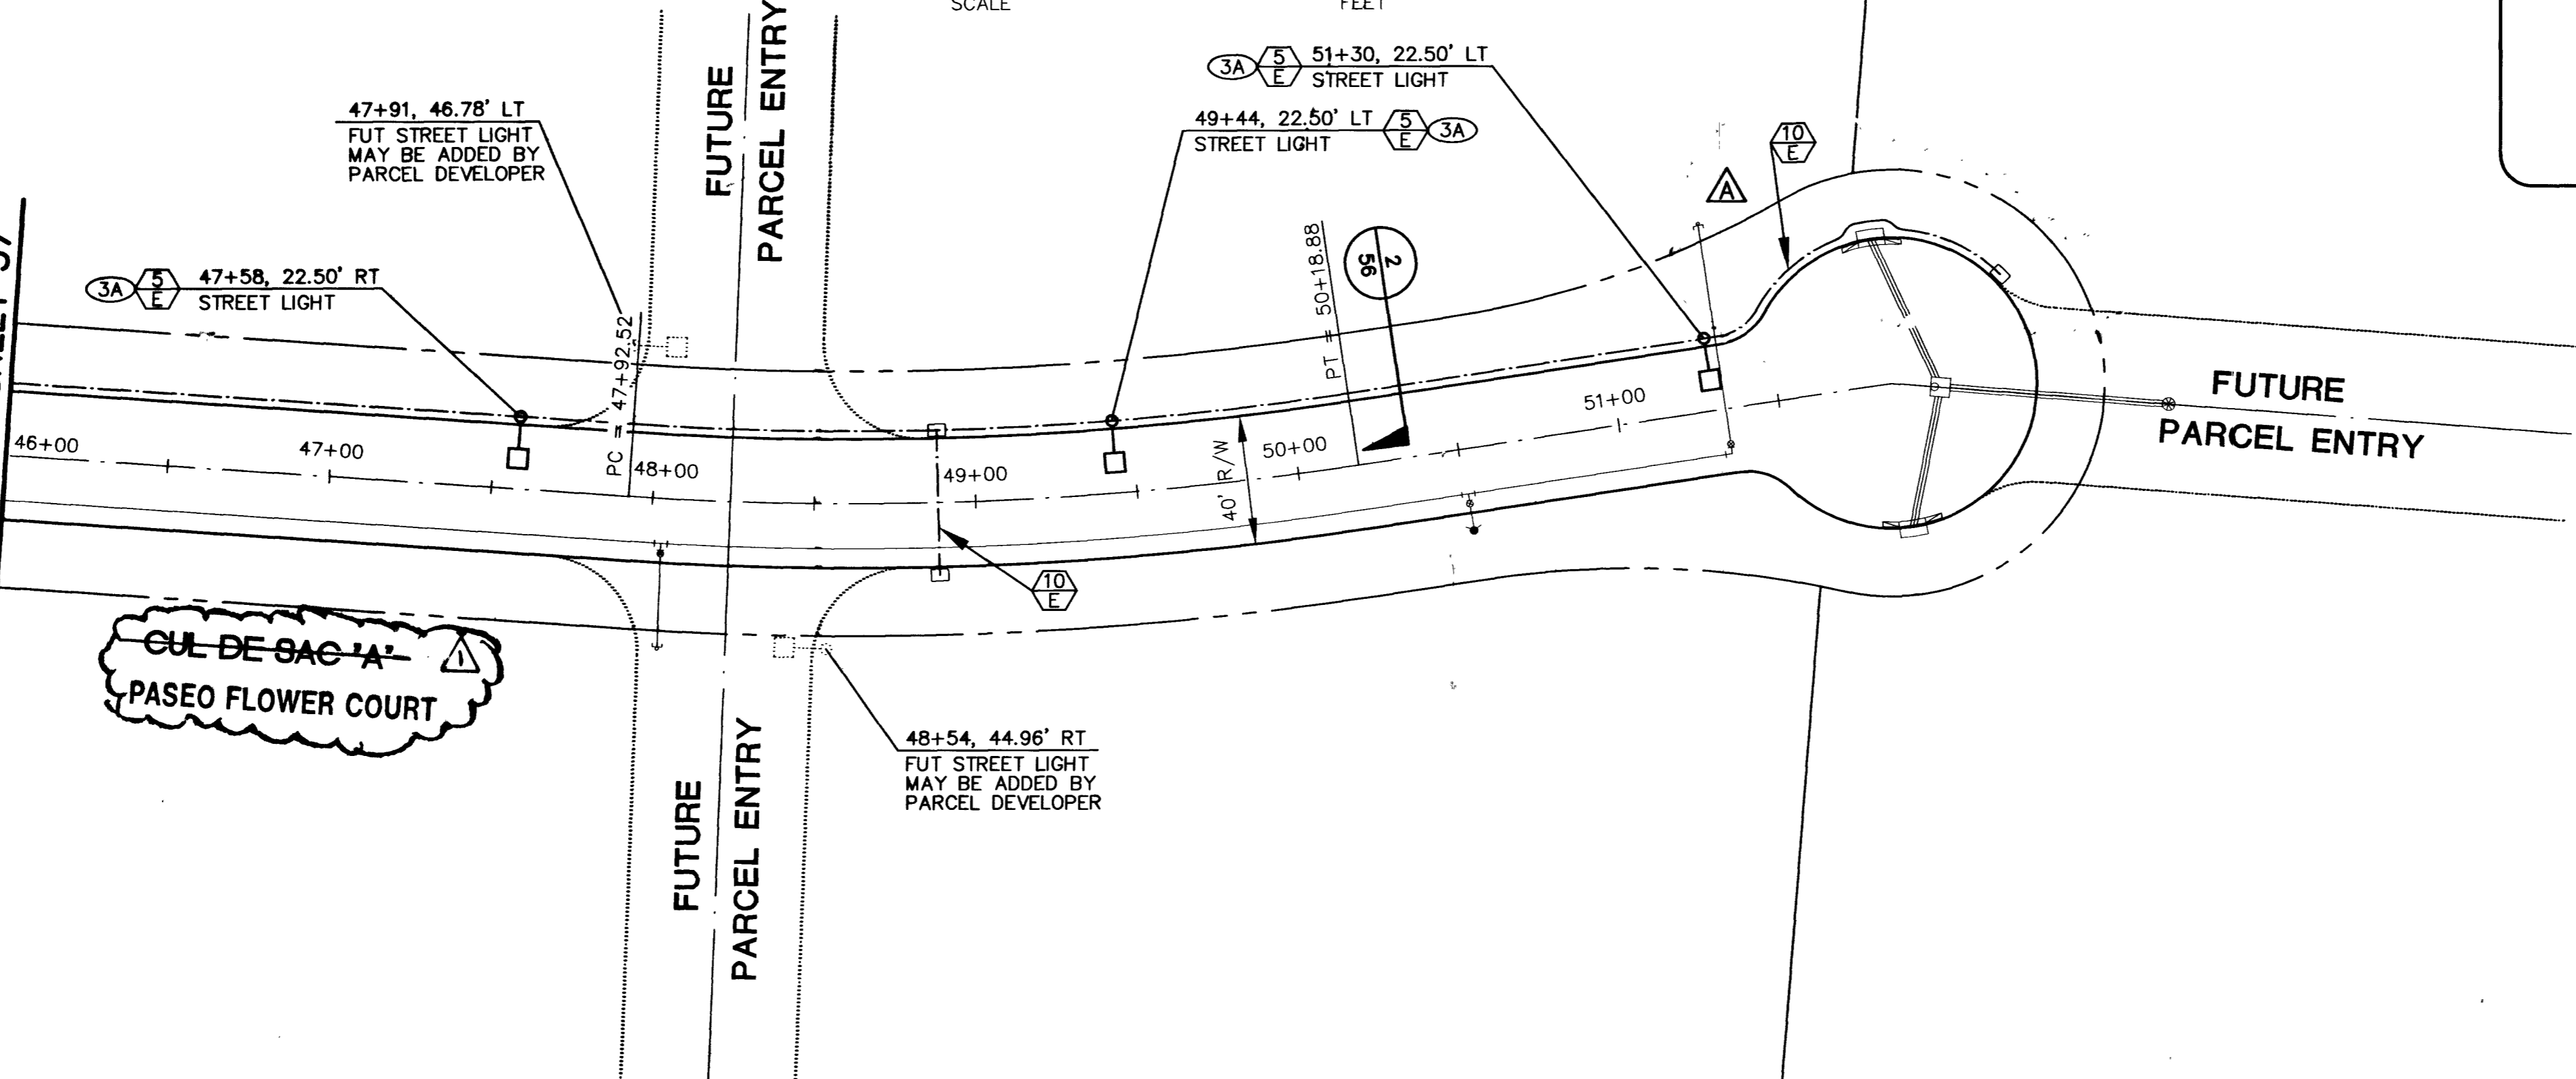

Exp. 6-30-03
DATE: 9-10-02

FOR ELECTRICAL
COMPONENTS ONLY

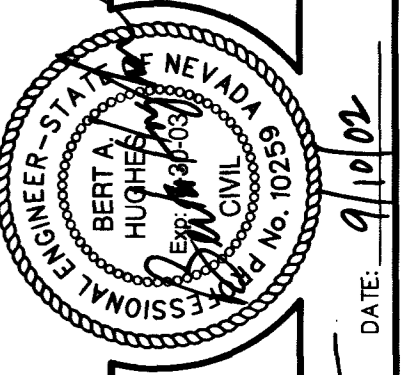

DESIGN:	JLJ
DRAWN:	JLJ
CHECK:	
ISSUE DATE:	
ISSUE EDITOR:	
PLOT DATE:	08-25-02
PLOT TIME:	12:42:02

G. C. WALLACE, INC.
Engineers/Planners/Surveyors
1555 SOUTH RAINBOW BLVD., LAS VEGAS, NEVADA 89146
OFFICE: (702) 804-2000, FAX: (702) 804-2299
SUMMERLIN OFFICE: 10000 CHARLESTON BLVD., STE. 130
OFFICE: (702) 804-2160, FAX: (702) 804-2295

SUMMERLIN
VILLAGE 23A UNIT 1 IMPROVEMENTS
STREET LIGHT, MASTER CONDUIT,
AND ELECTRICAL PLAN VI

Paul Martin
44788 50879