
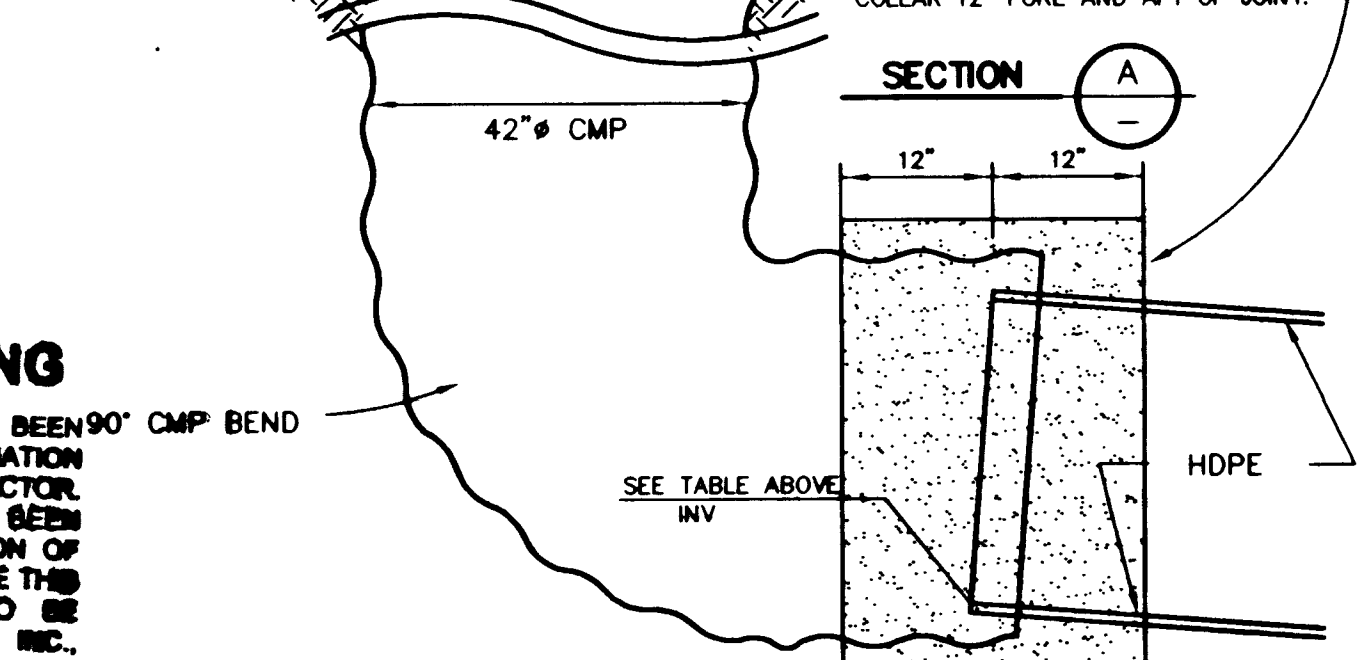
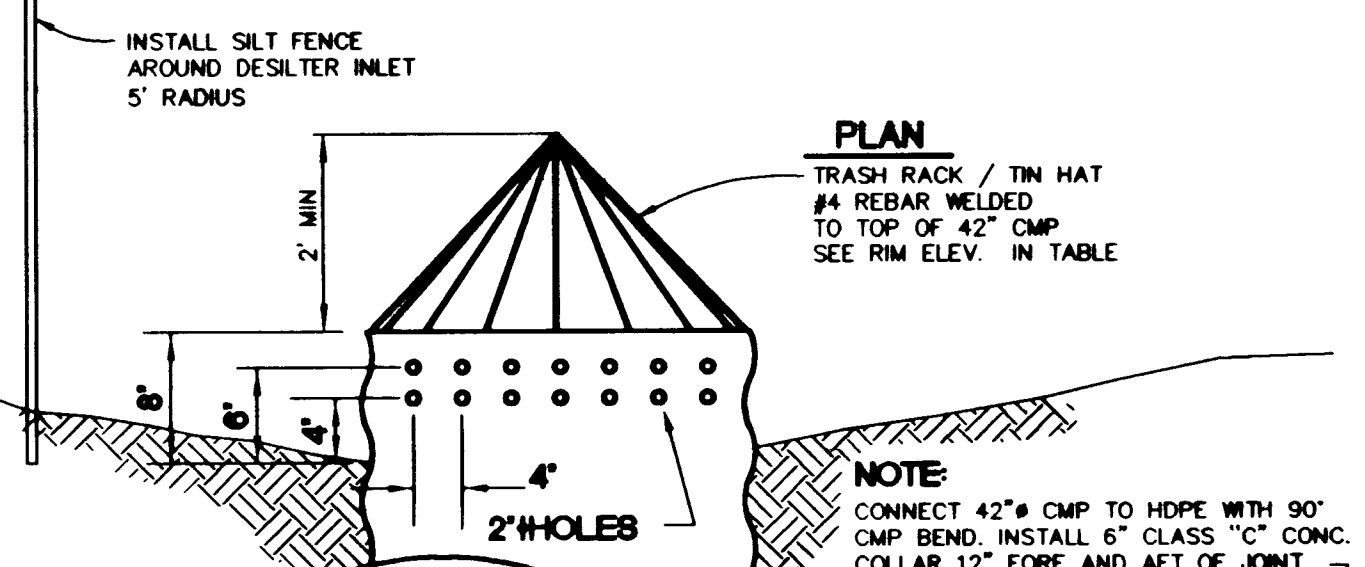


UTILITY NOTES

- 1 REMOVE EXIST STORM DRAIN PIPE AND INSTALL NEW STORM DRAIN PER PLAN.
- 2 CONTRACTOR TO VERIFY EXISTING STORM DRAIN AND/OR SEWER INVERTS & PIPE SLOPES PRIOR TO CONSTRUCTION. ANY WORK DONE PRIOR TO THIS VERIFICATION SHALL BE THE CONTRACTORS RESPONSIBILITY & COST.
- 3 EXISTING STORM DRAIN PIPE TO BE REMOVED.
- 4 INSTALL TYPE II MANHOLE, PER USDOCA DWG. NO. 405.
- 5 INSTALL TIN-HAT. SEE DETAIL 1 THIS SHEET.
- 6 INSTALL TYPE B DROP INLET PER USDOCA DWG. NO. 412. SEE PLAN FOR "D" DIMENSION.
- 7 INSTALL 60" DIAMETER TYPE I MANHOLE, PER USDOCA DWG. NO. 403.
- 8 CONNECT TO EXISTING STORM DRAIN PIPE.
- 9 CONSTRUCT 48" DIA. TYPE I SEWER MANHOLE PER CCSD STANDARDS.
- 10 EXISTING SEWER TO BE ABANDONED IN PLACE.
- 11 INSTALL 8" SEWER PLUG.
- 12 INSTALL 30" STORM DRAIN PLUG.
- 13 SAWCUT EXISTING STORM DRAIN PIPE AND MATCH.
- 14 INSTALL 6" SEWER PLUG.

GENERAL NOTE: ALL UTILITY LINES SHALL BE BACKFILLED AND COMPACTED PER SUMMERLIN IMPROVEMENT STANDARD DRAWINGS U-19 & U-20

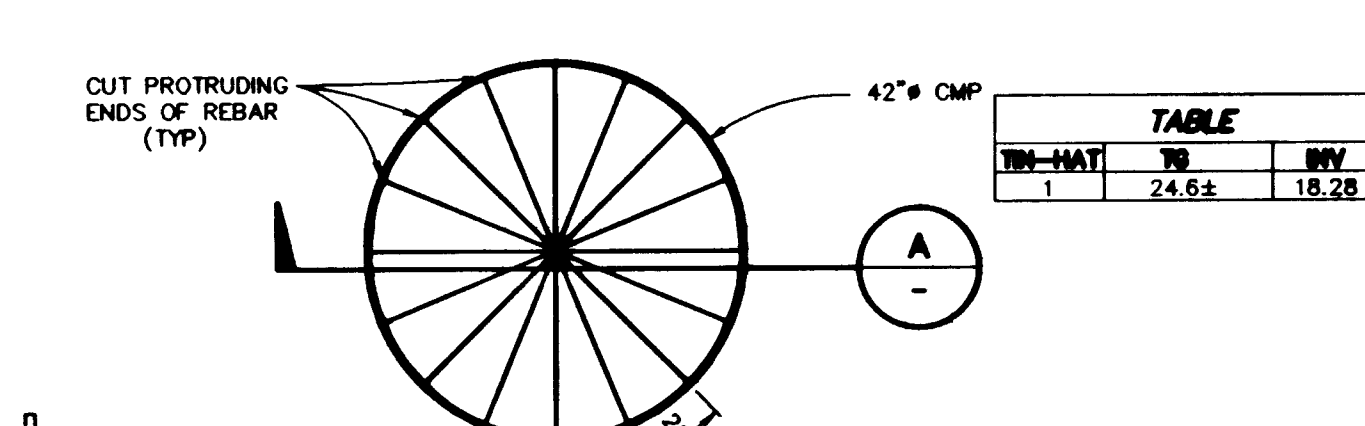

1 TEMPORARY INLET STRUCTURE
SCALE: N.T.S.

RECORD DRAWING

THIS RECORD DRAWING HAS BEEN PREPARED BASED UPON INFORMATION AS PROVIDED BY THE CONTRACTOR. NO FIELD VERIFICATION HAS BEEN MADE AND NO REPRESENTATION OF ITS ACCURACY IS IMPLIED. WHILE THIS INFORMATION IS BELIEVED TO BE RELIABLE, G. C. WALLACE, INC., CANNOT ASSURE ITS ACCURACY, AND THIS IS NOT RESPONSIBLE FOR THE ACCURACY OF THIS RECORD DRAWING OR FOR ANY ERRORS OR OMISSIONS WHICH MAY HAVE BEEN INCORPORATED INTO ITR AS A RESULT. THOSE RELYING ON THIS RECORD DOCUMENT ARE ADVISED TO OBTAIN INDEPENDENT VERIFICATION OF ITS ACCURACY BEFORE APPLYING IT FOR ANY PURPOSE.

STORM DRAIN QUANTITIES (PUBLIC)

- | | |
|------------------------------|---------|
| 1. 60" DIAMETER MANHOLE..... | 2 EA. |
| 2. TYPE II MANHOLE..... | 5 EA. |
| 3. 36" H.D.P.E. PIPE..... | 528 LF. |
| 4. 30" H.D.P.E. PIPE..... | 421 LF. |
| 5. 24" H.D.P.E. PIPE..... | 785 LF. |
| 6. 18" H.D.P.E. PIPE..... | 36 LF. |
| 7. 30" H.D.P.E. PLUG..... | 2 EA. |
| 8. 36" TIN HAT..... | 1 EA. |
| 10. TYPE "B" DROP INLET..... | 2 EA. |

SEWER QUANTITIES (PUBLIC)


- | | |
|------------------------------|---------|
| 1. 48" DIAMETER MANHOLE..... | 4 EA. |
| 2. SEWER WYE..... | 2 EA. |
| 4. 8" PVC SEWER MAIN..... | 412 LF. |
| 5. 6" PVC SEWER LINE..... | 44 LF. |



PAINT CURBS RED
INSTALL "FIRE LANE NO PARKING" SIGN
TYPICAL AS REQUIRED

- #### LEGEND
- EX. FIRE HYDRANT W/6" GATE VALVE
 - PROPOSED FIRE HYDRANT W/6" GATE VALVE
 - EX. WATER LINE
 - EX. SEWER LINE
 - EX. GAS LINE
 - EX. STORM DRAIN GATE VALVE
 - SEWER MANHOLE
 - SEWER CLEAN OUT
 - WATER LINE
 - SEWER LINE
 - GAS LINE
 - FIRE LANE

MATCH LINE SEE SHEET C-5

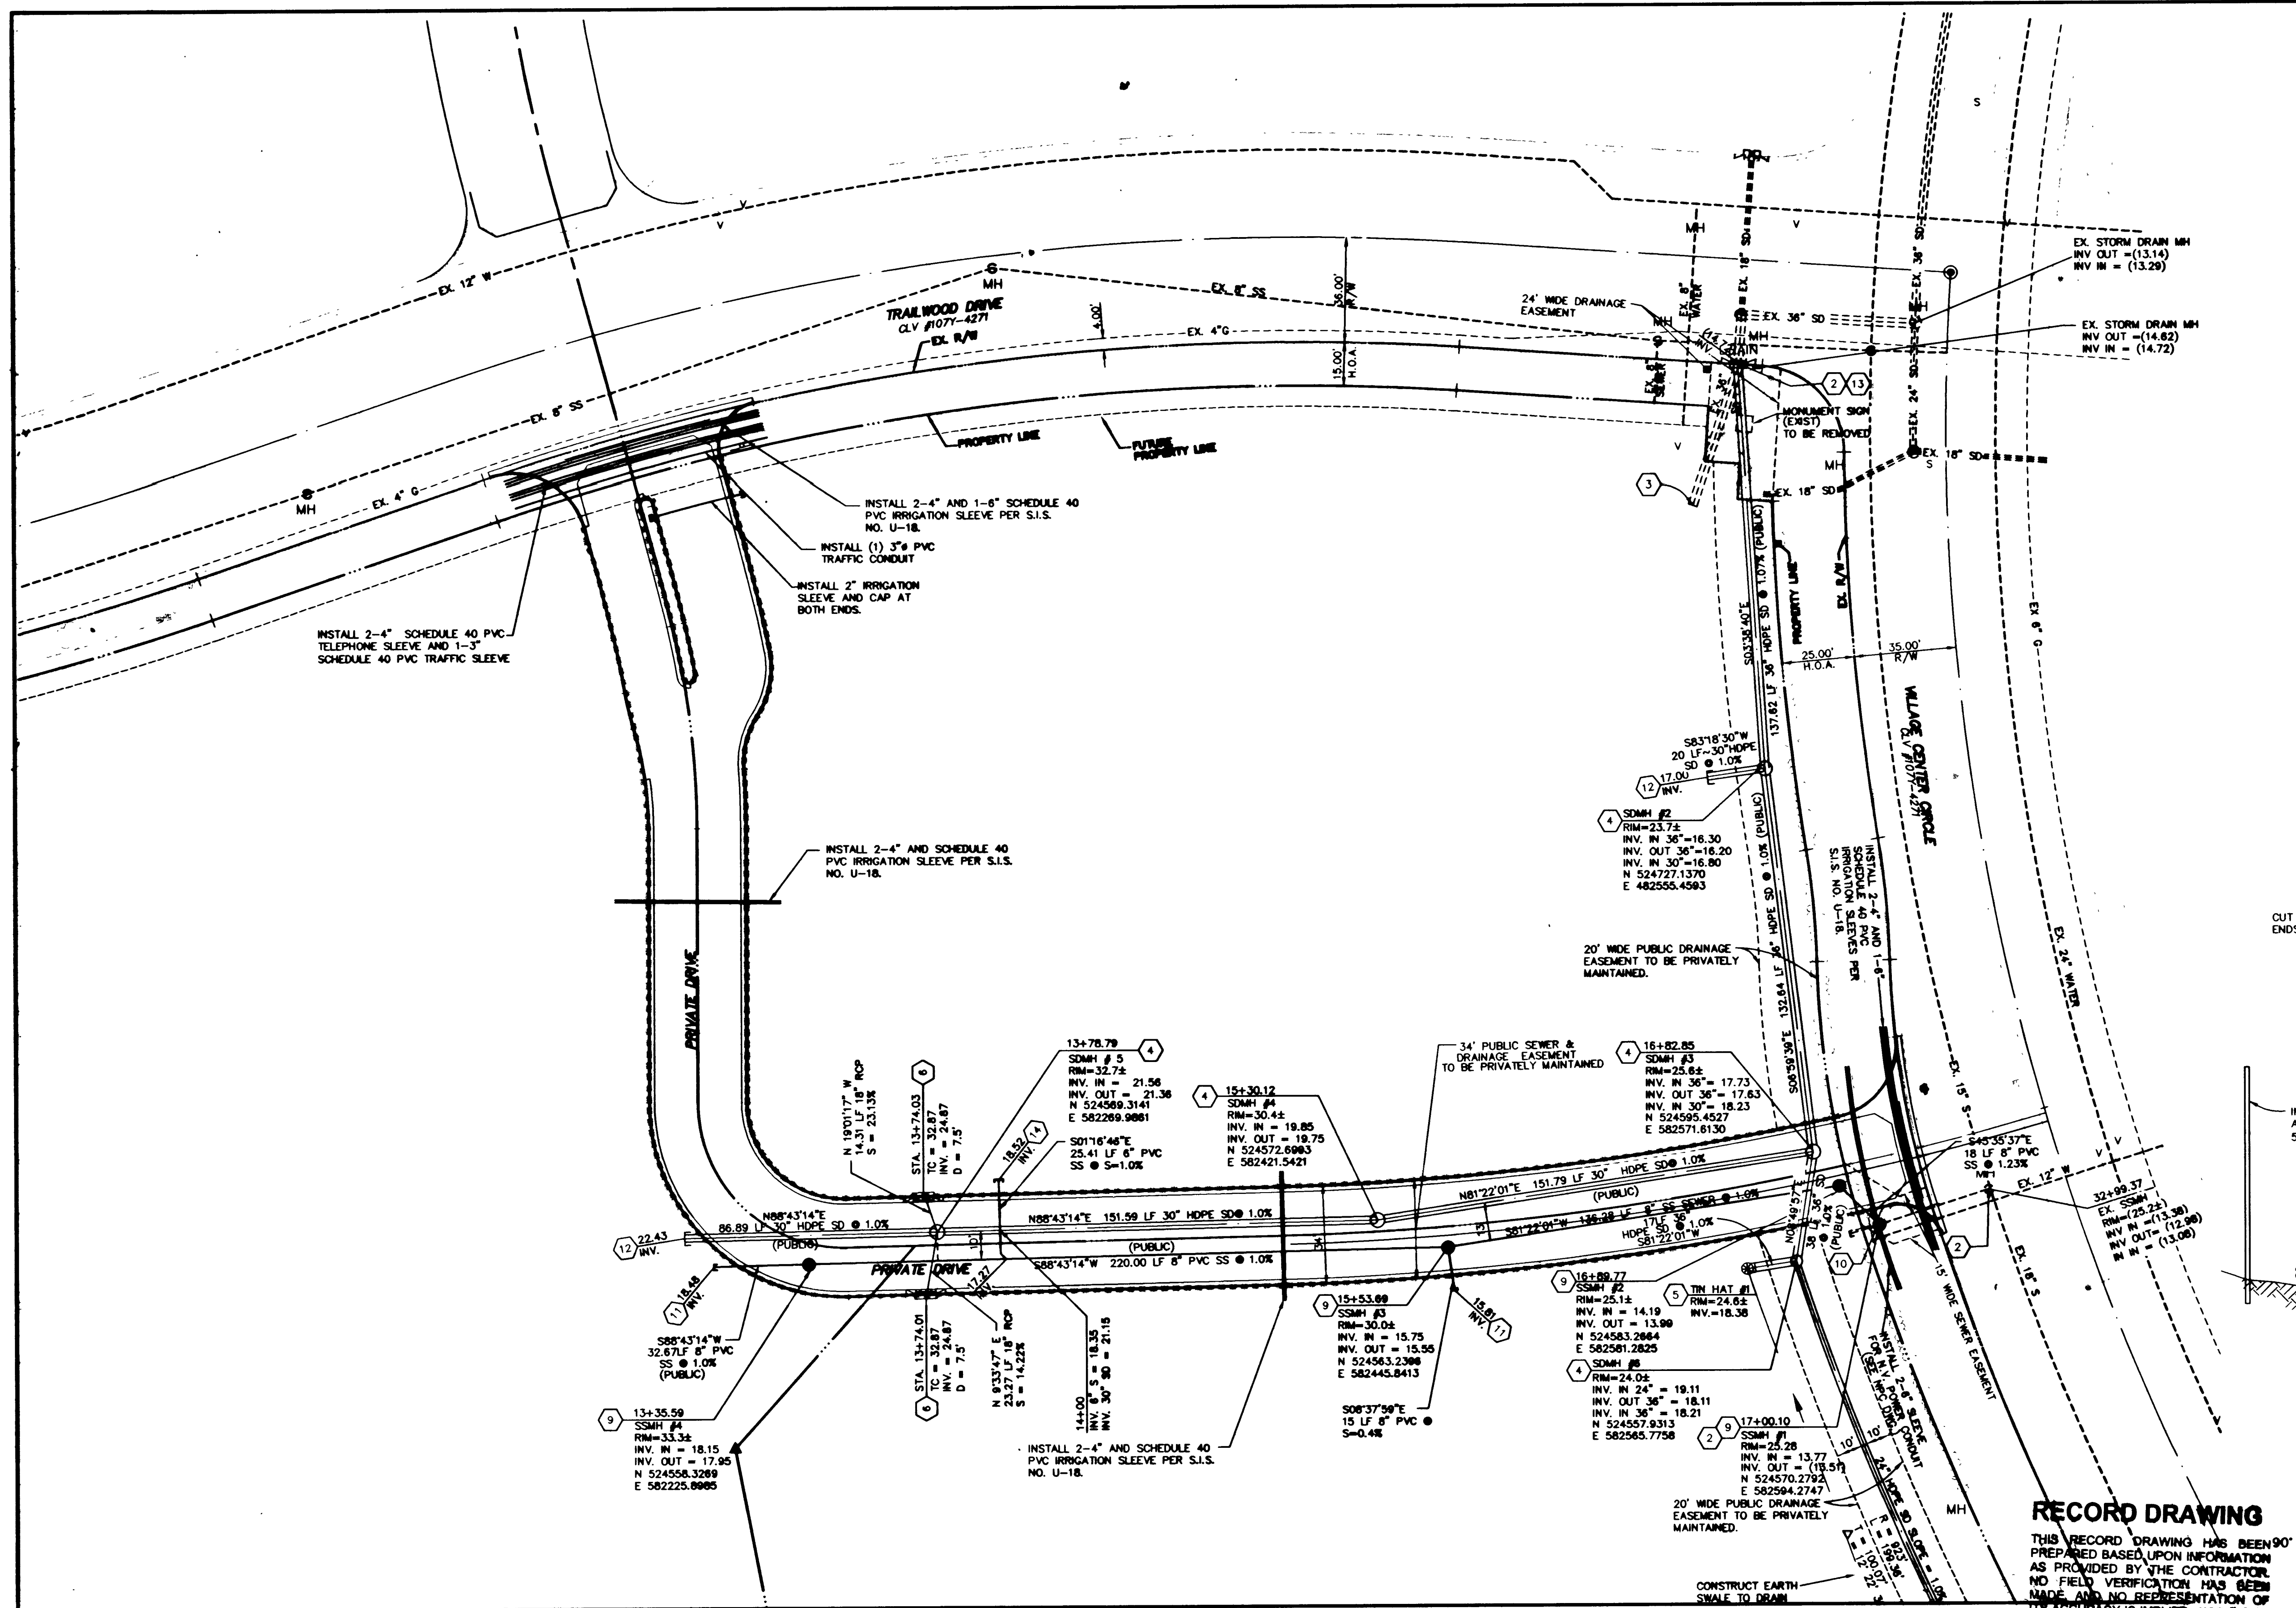

G. C. WALLACE, INC.
Engineers/Planners/Surveyors
15150 S. 200th St., Suite 100
Burien, WA 98148
PHONE (206) 834-2200 FAX (206) 834-2299
H: 1003 PARCEL - E. WALLACE, INC. BUILT 1980

THE HOWARD HUGHES CORPORATION
Parcel C-5
AS-BUILT UTILITY PLAN
SHEET C-1
1 OF 2 SHEETS



AS-BUILT CLV # 7019 107-V-3354