

UTILITY NOTES

1. REMOVE EXIST STORM DRAIN PIPE AND INSTALL NEW STORM DRAIN PER PLAN.
2. CONTRACTOR TO VERIFY EXISTING STORM DRAIN AND/OR SEWER INVERTS & PIPE SLOPES PRIOR TO CONSTRUCTION. ANY WORK DONE PRIOR TO THIS VERIFICATION SHALL BE THE CONTRACTORS RESPONSIBILITY & COST.
3. EXISTING STORM DRAIN PIPE TO BE REMOVED.
4. INSTALL TYPE II MANHOLE, PER USDOCA DWG. NO. 405.
5. INSTALL TIN-HAT. SEE DETAIL 1 THIS SHEET.
6. INSTALL TYPE B DROP INLET PER USDOCA DWG. NO. 412. SEE PLAN FOR "D" DIMENSION.
7. INSTALL 60" DIAMETER TYPE I MANHOLE, PER USDOCA DWG. NO. 403.
8. CONNECT TO EXISTING STORM DRAIN PIPE.
9. CONSTRUCT 48" DIA. TYPE I SEWER MANHOLE PER CCSD STANDARDS.
10. EXISTING SEWER TO BE ABANDONED IN PLACE.
11. INSTALL 8" SEWER PLUG.
12. INSTALL 30" STORM DRAIN PLUG.
13. SAWCUT EXISTING STORM DRAIN PIPE AND MATCH.
14. INSTALL 6" SEWER PLUG.

GENERAL NOTE: ALL UTILITY LINES SHALL BE BACKFILLED AND COMPACTED PER SUMMERLIN IMPROVEMENT STANDARD DRAWINGS U-19 & U-20



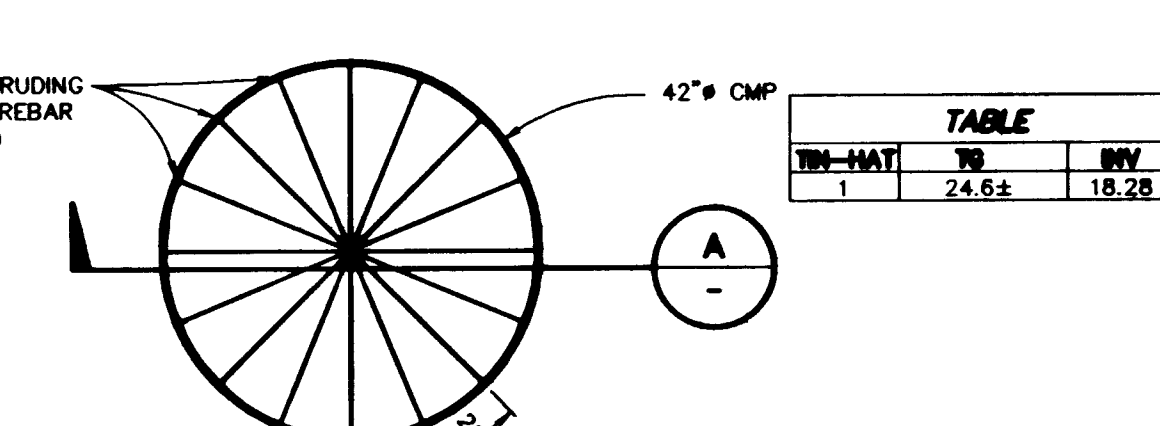


TABLE		
IN-HAT	TO	INV
1	24.6±	18.28

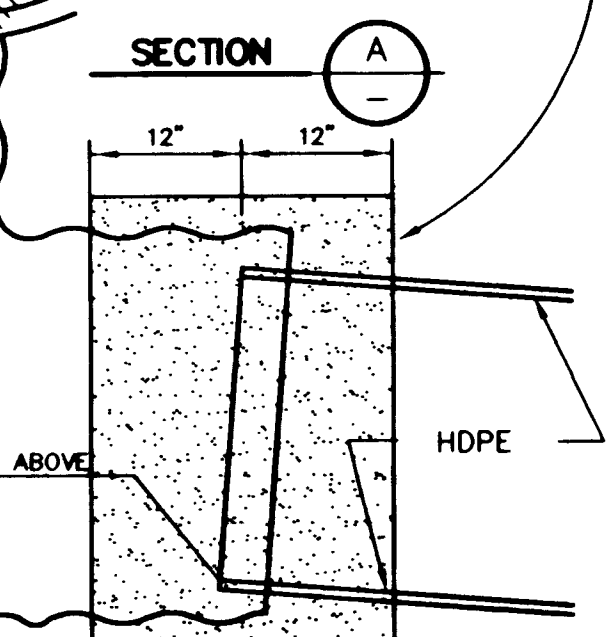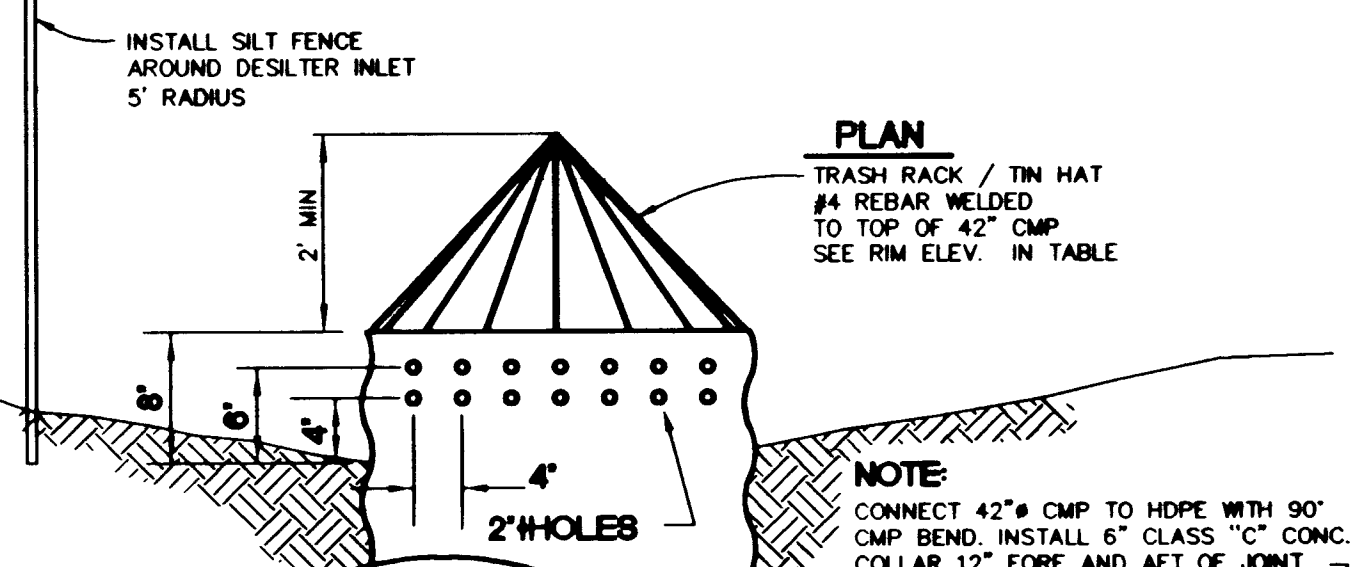

RECORD DRAWING


THIS RECORD DRAWING HAS BEEN PREPARED BASED UPON INFORMATION AS PROVIDED BY THE CONTRACTOR. NO FIELD VERIFICATION HAS BEEN MADE, AND NO REPRESENTATION OF ITS ACCURACY IS IMPLIED. WHILE THIS INFORMATION IS BELIEVED TO BE RELIABLE, G. C. WALLACE, INC., CANNOT ASSURE ITS ACCURACY, AND THIS IS NOT RESPONSIBLE FOR THE ACCURACY OF THIS RECORD DRAWING OR FOR ANY ERRORS OR OMISSIONS WHICH MAY HAVE BEEN INCORPORATED INTO ITR AS A RESULT. THOSE RELYING ON THIS RECORD DOCUMENT ARE ADVISED TO OBTAIN INDEPENDENT VERIFICATION OF ITS ACCURACY BEFORE APPLYING IT FOR ANY PURPOSE.

1 TEMPORARY INLET STRUCTURE

SCALE: N.T.S.

MATCH LINE SEE SHEET C-5

- #### LEGEND
- EX. FIRE HYDRANT W/6" GATE VALVE
 - PROPOSED FIRE HYDRANT W/6" GATE VALVE
 - EX. WATER LINE
 - EX. SEWER LINE
 - EX. GAS LINE
 - EX. STORM DRAIN GATE VALVE
 - SEWER MANHOLE
 - SEWER CLEAN OUT
 - WATER LINE
 - SEWER LINE
 - GAS LINE
 - FIRE LANE

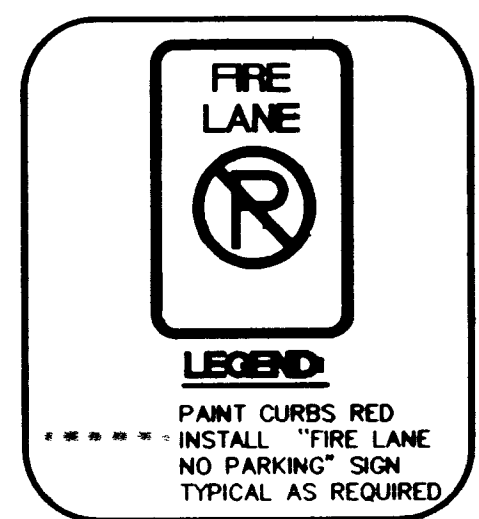

SEWER QUANTITIES (PUBLIC)

1. 48" DIAMETER MANHOLE.....	4 EA.
2. SEWER WYE.....	2 EA.
4. 8" PVC SEWER MAIN.....	412 LF.
5. 6" PVC SEWER LINE.....	44 LF.

STORM DRAIN QUANTITIES (PUBLIC)

1. 60" DIAMETER MANHOLE.....	2 EA.
2. TYPE II MANHOLE.....	5 EA.
3. 36" H.D.P.E. PIPE.....	528 LF.
4. 30" H.D.P.E. PIPE.....	421 LF.
5. 24" H.D.P.E. PIPE.....	785 LF.
6. 18" H.D.P.E. PIPE.....	36 LF.
7. 30" H.D.P.E. PLUG.....	2 EA.
8. 36" TIN HAT.....	1 EA.
10. TYPE "B" DROP INLET.....	2 EA.

CONTRACTOR NOTE

G.C. WALLACE, INC. ASSUME NO RESPONSIBILITY FOR EXISTING UTILITIES SHOWN OR NOT SHOWN. THE UTILITIES SHOWN ON THIS DRAWING HAVE BEEN PLOTTED FROM RECORD INFORMATION AND ARE FOR THE CONVENIENCE OF THE CONTRACTOR ONLY. IT IS THE CONTRACTOR'S RESPONSIBILITY TO FIELD VERIFY THE LOCATION AND DEPTH OF ALL RELEVANT UTILITIES PRIOR TO COMMENCEMENT OF CONSTRUCTION. IF A CONFLICT OR DISCREPANCY IS DISCOVERED, THE CONTRACTOR SHALL NOTIFY THE ENGINEER IN WRITING IMMEDIATELY.

Call before you Dig
1-800-227-2600

Call before you Dig
1-702-593-6111

DATE: 10/19/19

DESIGN: GCM

DRAWN: BOC

CHECK: BOC

ISSUE DATE: 10/19/19

ISSUE EDITOR: BOC

PLOT DATE: 10/19/19

PLOT TIME: 10:48:19

G. C. WALLACE, INC.
Engineers/Planners/Surveyors
15150 S. 26TH AVENUE, SUITE 100, DENVER, CO 80231
TELEPHONE (702) 904-2000 • FAX: (702) 904-2299
H: 10433 PARCEL - E. WALLACE, INC. - BUILT 10/19/19

THE HOWARD HUGHES CORPORATION

Trail Village Center South - PARCELS

AS-BUILT UTILITY PLAN

SHEET C-1

1 OF 2 SHEETS