


SHEET INDEX

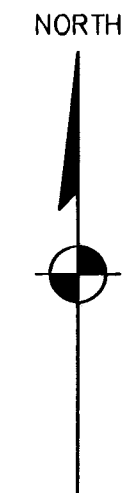

GENERAL SHEETS

SHEET	DRAWING TITLE
G-1	1 OF 37 COVER SHEET
G-2	2 OF 37 LOCATION MAP AND SHEET INDEX
G-3	3 OF 37 ABBREVIATIONS, LEGEND, AND SYMBOLS
G-4	4 OF 37 NOTES
G-5	5 OF 37 NOTES

SURVEY SHEETS

SHEET	DRAWING TITLE
HC-1	6 OF 37 SURVEY CONTROL

CIVIL SHEETS

SHEET	DRAWING TITLE
C-1	7 OF 37 SITE PLAN
C-2	8 OF 37 GRADING PLAN
C-3	9 OF 37 ROADWAY AND STORM DRAIN PLAN AND PROFILE TROPICAL PKWY STA: 100+00 TO STA: 105+97
C-4	10 OF 37 UTILITY PLAN
C-5	11 OF 37 PAVEMENT STRIPING, SIGNAGE, AND STREETLIGHT PLAN
D-1	12 OF 37 SECTIONS AND DETAILS
D-2	13 OF 37 SECTIONS AND DETAILS
D-3	14 OF 37 SECTIONS AND DETAILS

ELECTRICAL SHEETS


SHEET	DRAWING TITLE
EG1	15 OF 37 ELECTRICAL LEGEND SHEET
ES1	16 OF 37 ELECTRICAL SITE PLAN, PHOTOMETRIC STATISTICS, AND FIXTURE SCHEDULE
E1	17 OF 37 ELECTRICAL DETAILS

LANDSCAPE SHEETS

SHEET	DRAWING TITLE
L1.00	18 OF 37 CONSTRUCTION LEGEND
L1.01	19 OF 37 CONSTRUCTION PLAN
L1.02	20 OF 37 CONSTRUCTION PLAN
L1.03	21 OF 37 CONSTRUCTION PLAN
L1.04	22 OF 37 CONSTRUCTION DETAILS
L1.05	23 OF 37 CONSTRUCTION DETAILS
L2.00	24 OF 37 IRRIGATION LEGEND
L2.01	25 OF 37 IRRIGATION PLAN
L2.02	26 OF 37 IRRIGATION PLAN
L2.03	27 OF 37 IRRIGATION PLAN
L2.04	28 OF 37 IRRIGATION DETAILS
L2.05	29 OF 37 IRRIGATION DETAILS
L3.00	30 OF 37 PLANTING LEGEND
L3.01	31 OF 37 PLANTING PLAN
L3.02	32 OF 37 PLANTING PLAN
L3.03	33 OF 37 PLANTING PLAN
L3.04	34 OF 37 PLANTING DETAILS




ARCHITECTURAL SHEETS

SHEET	DRAWING TITLE
A-1	35 OF 37 COVER/LAYOUT
A-2	36 OF 37 DETAILS
S-1	37 OF 37 STRUCTURAL

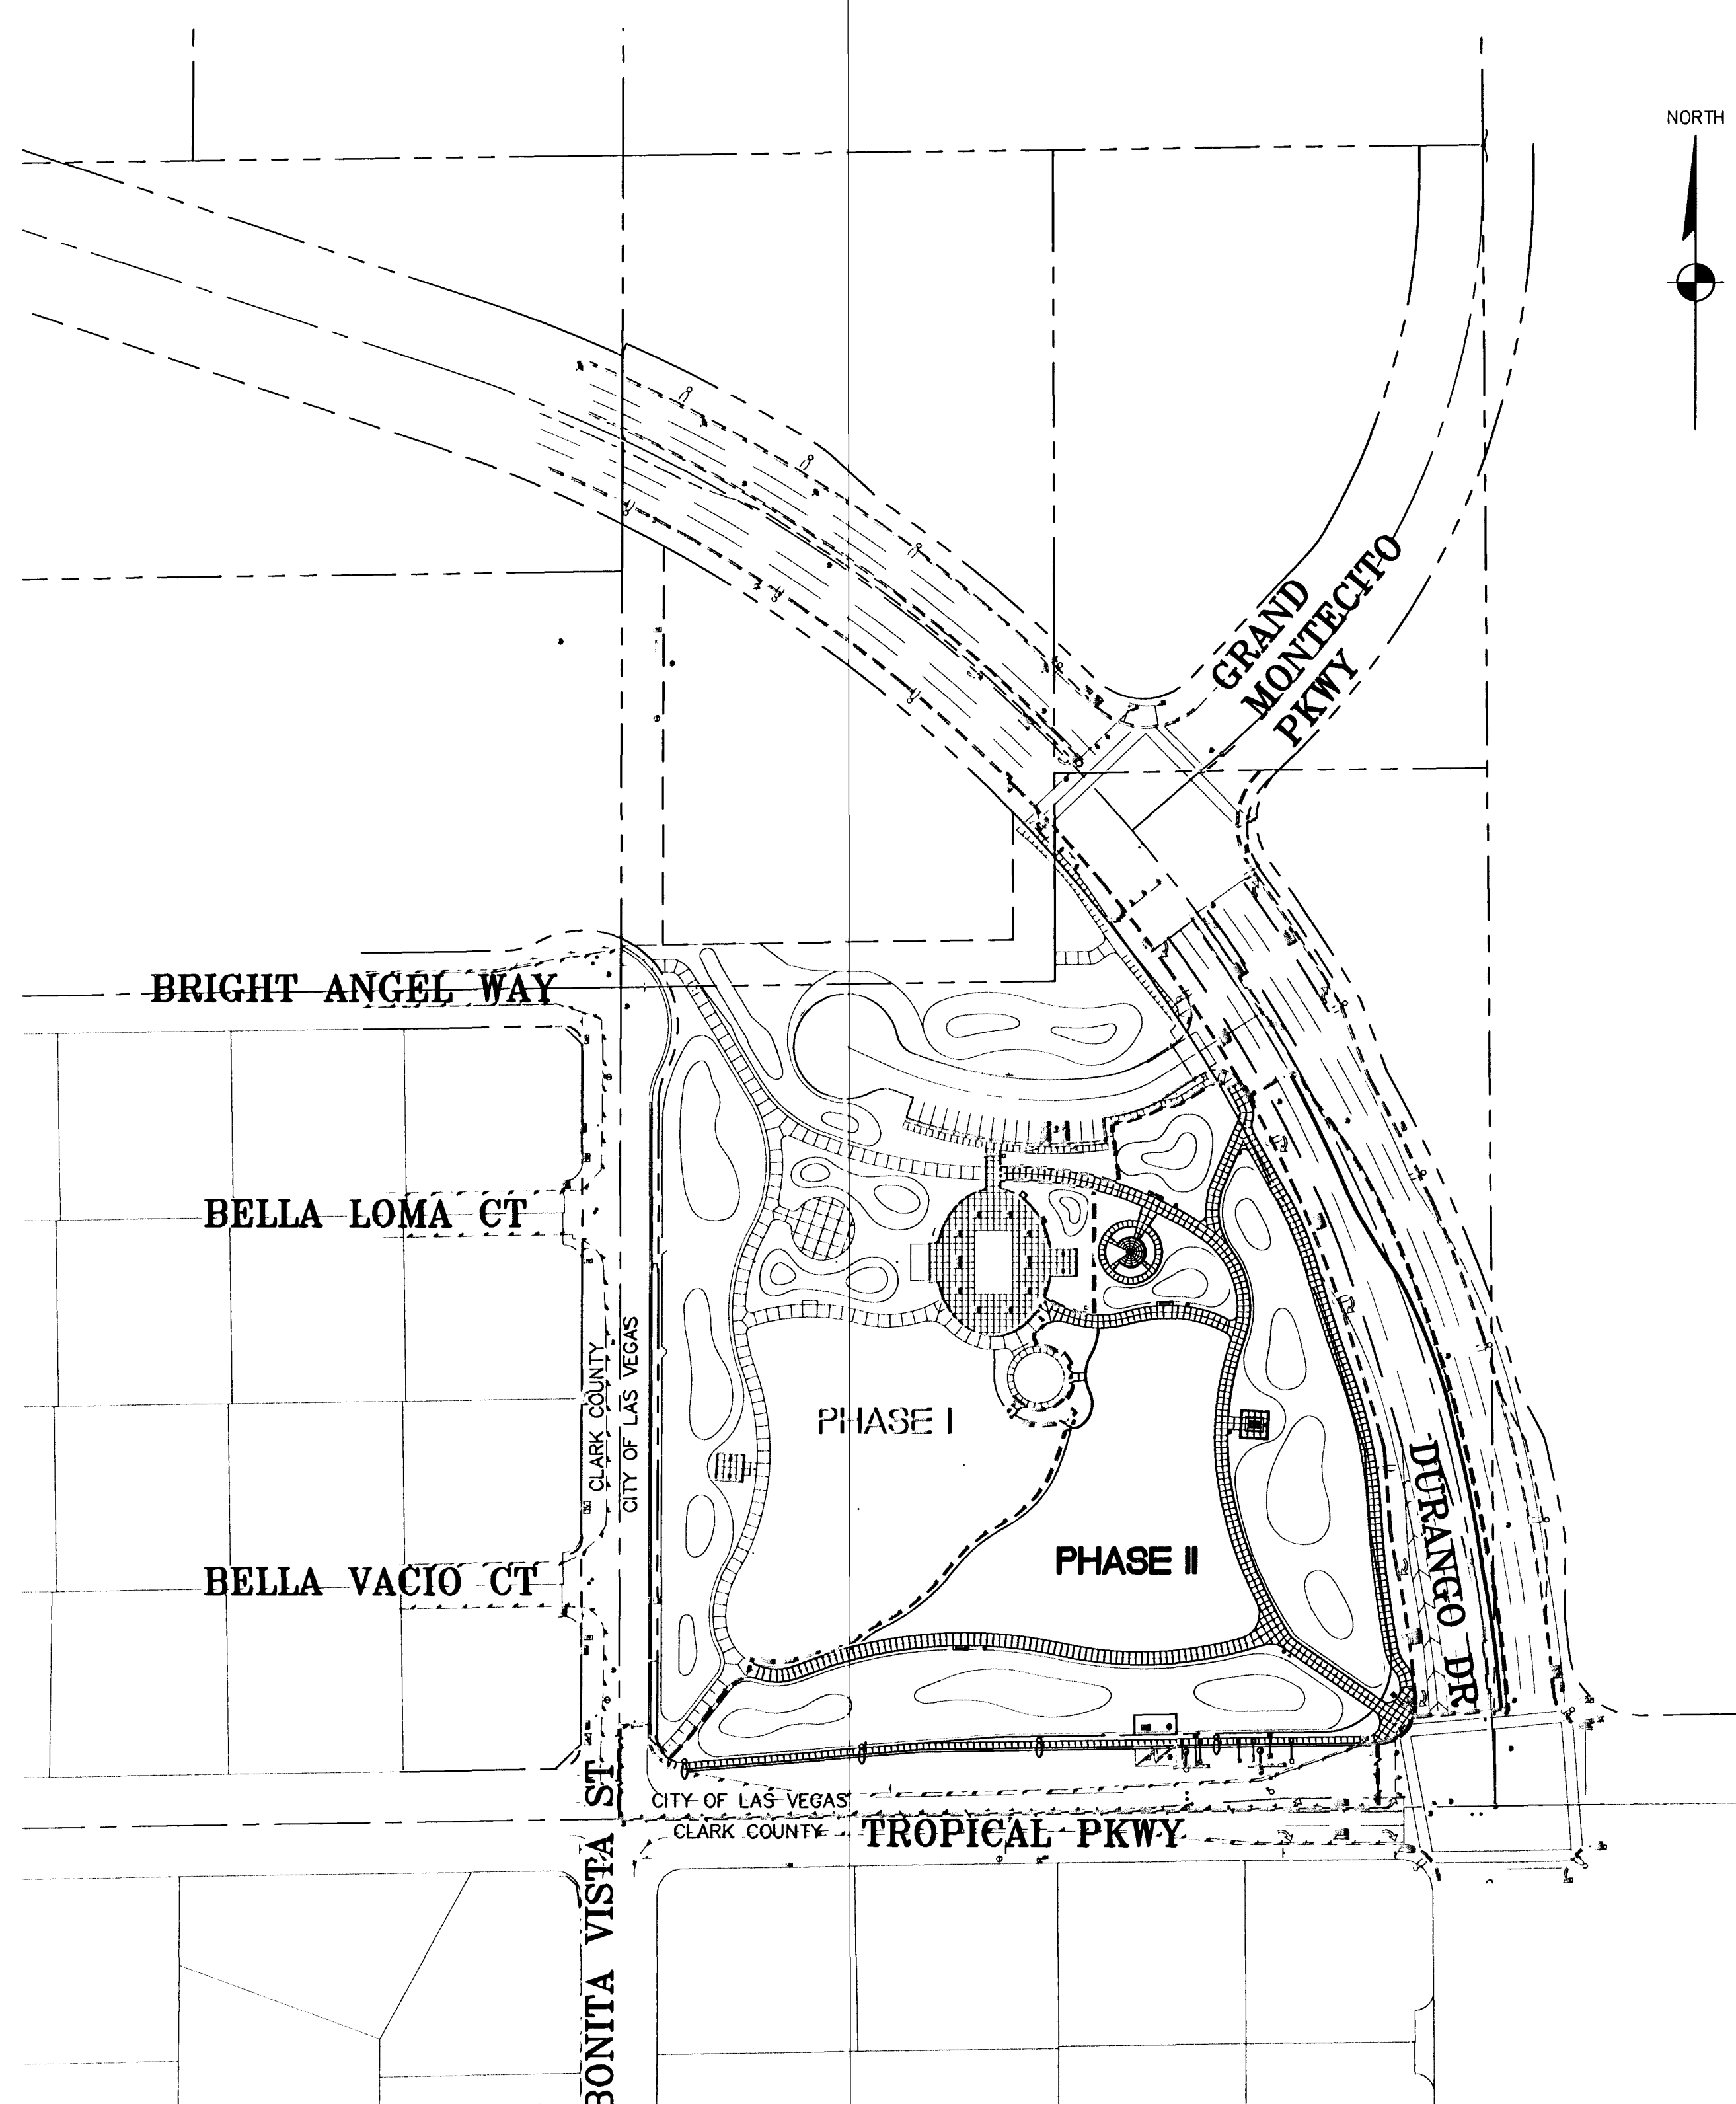


LOCATION MAP
SCALE: 1" = 100'

Douglas M. Morgan for
 LAS VEGAS VALLEY WATER DISTRICT ENGINEERING SERVICES MANAGER
 Project No. 116822
 DATE 12/1/11

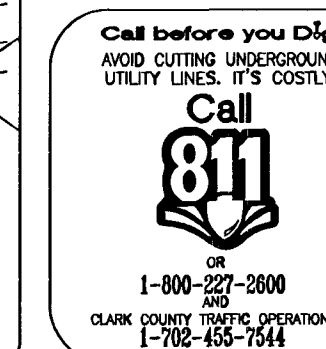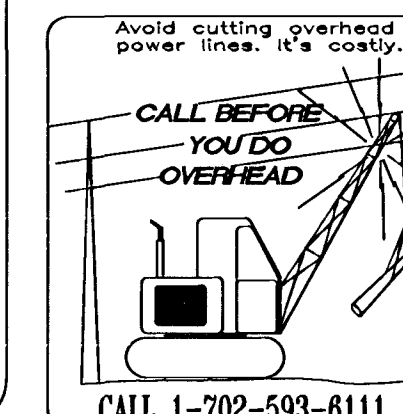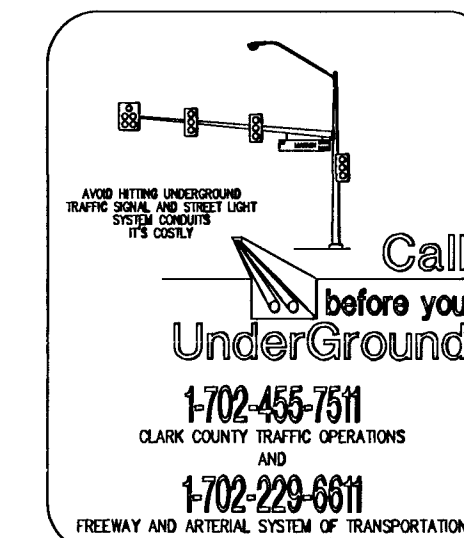

STANLEY CONSULTANTS INC.
 3820 SOUTH EASTERN AVENUE, SUITE 200
 LAS VEGAS, NEVADA 89119
 (702) 369-9396
 FAX: (702) 369-9793

CITY OF LAS VEGAS
DEPARTMENT OF PUBLIC WORKS
TROPICAL DURANGO PARK PHASE II
6075 N. DURANGO DRIVE
LOCATION MAP AND SHEET INDEX

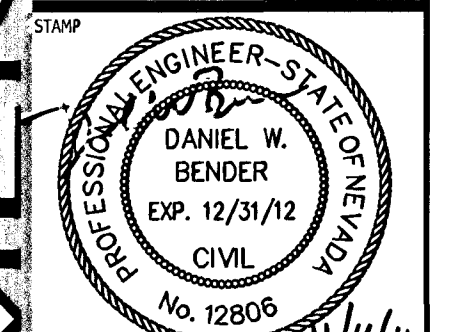

OWNER: CITY OF LAS VEGAS
 DEPARTMENT OF PUBLIC WORKS

333 NORTH RANCHO DRIVE
 LAS VEGAS, NEVADA 89106
 PHONE: (702) 229-6335
 FAX: (702) 384-4846
 TDD: (702) 386-9108

DRAWN	ME
FILE	
DATE	1/29/11
SCALE	N/A
BID NO	101534106
CLY DWG NO	650103-2
HANSEN NO	38938
SHT NO	G-2
	2 OF 37