

CEILING FINISHES

- 2x4 LAY-IN ACOUSTICAL CEILING
- GYPSUM BOARD CEILING
- EXISTING CEILING TO REMAIN
- 2' X 4' FLUORESCENT LIGHT FIXTURE
- 1' X 4' FLUORESCENT LIGHT FIXTURE


- SUPPLY AIR REGISTER
- RETURN AIR GRILLE
- EXHAUST
- EXIT SIGN
- SPRINKLER HEAD
- SPEAKER
- SMOKE DETECTOR

CEILING NOTES:

KEY	DESCRIPTION
D1	REUSE MARBLE BASE
E4	STRUCTURE ABOVE
E5	3 5/8" X 20 GA. METAL STUDS 16" O.C.
E6	METAL STUD BRACE
F9	MATCH EXISTING CROWN MOULDING
J1	ACOUSTICAL CEILING
J2	5/8" TYPE 'X' GYPSUM BOARD
J3	CONTINUOUS CORNER BEAD
J4	EXISTING CEILING TO REMAIN
J5	PATCH AND REPAIR DRYWALL AT CEILING/WALL CONNECTION.
R1	PROVIDE NEW PARA-LITE 1 #PL1-24-SP-S LENS IN EACH RECESSED LIGHT WELL
R2	EXISTING WORK LIGHT TO REMAIN
R3	EXISTING LOBBY LIGHTS TO REMAIN

GENERAL SPRINKLER NOTE:
THE LEASE SPACE IS FULLY SPRINKLED.
CONTRACTOR TO PROVIDE MODIFICATION TO
EXISTING SPRINKLER SYSTEM AS REQUIRED. THE
DESIGN, REVISION, FEES ASSOCIATED WITH THIS
SCOPE OF WORK TO BE BY CONTRACTOR AND
IN ACCORDANCE WITH LOCAL CODE.

521-279-2

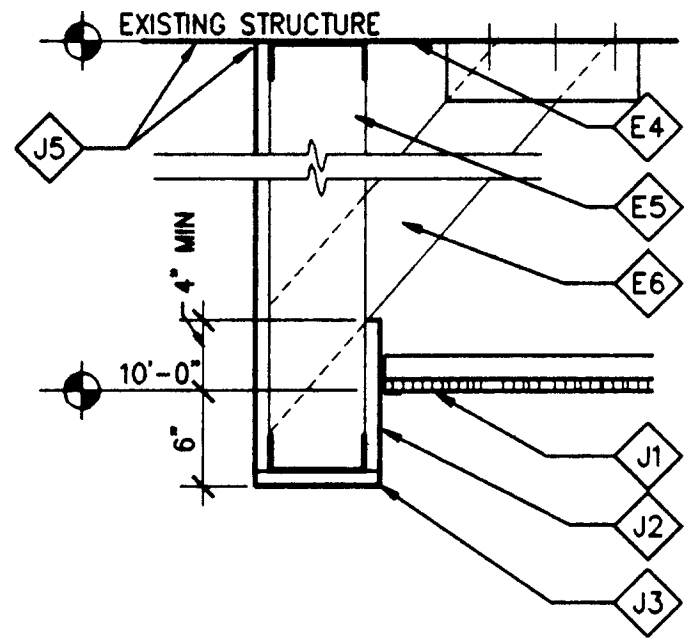


DETAIL

SCALE: 1 1/2" = 1'-0"

SOFFIT

1
A-3

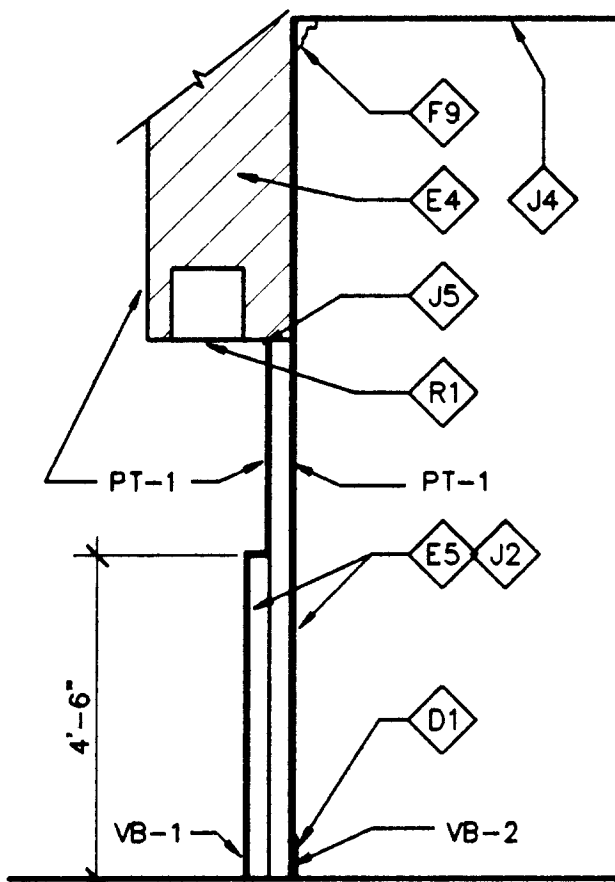


DETAIL

SCALE: 3/8" = 1'-0"

WALL-C


2
A-3

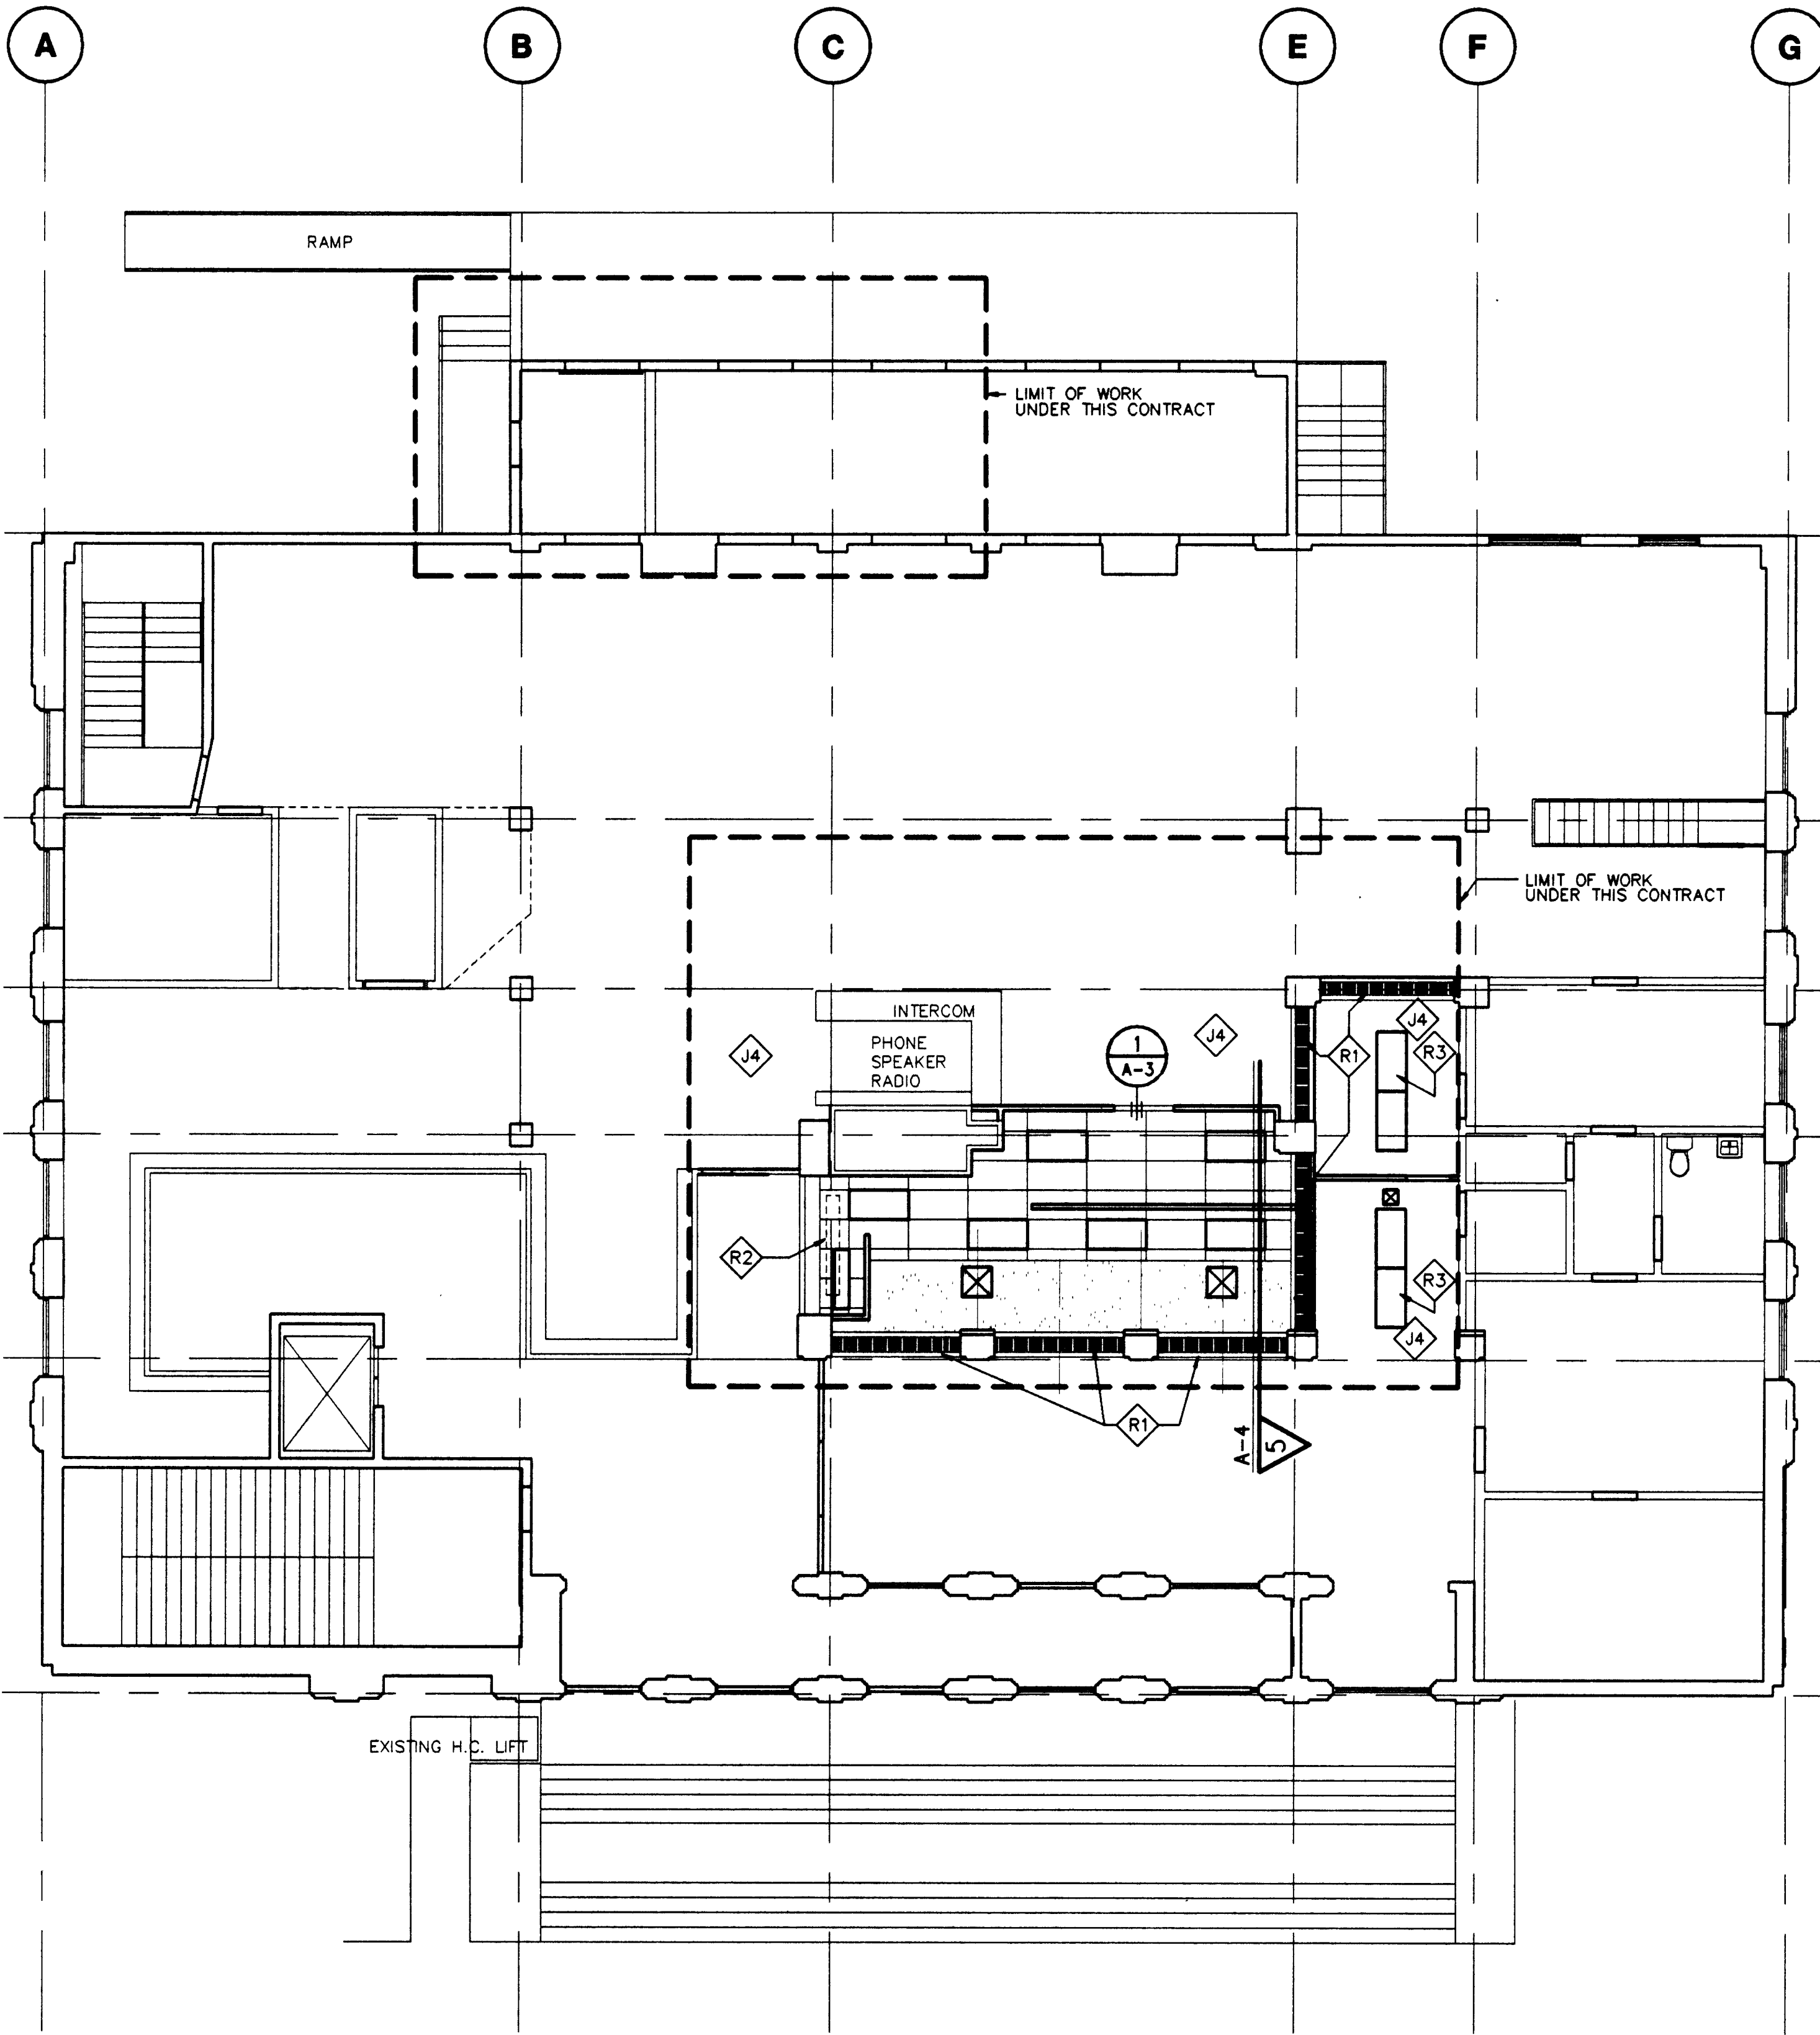

REFELCTED CEILING PLAN

SCALE: 1/8" = 1'-0"

USPSDNTN

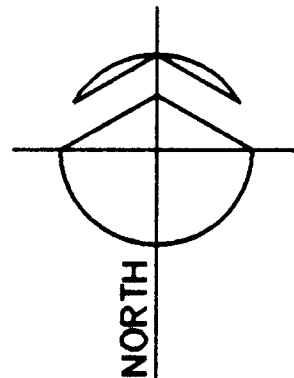

KGA
KITTRELL CARLOCK and ASSOCIATES
ARCHITECTS
400 SOUTH MOUNTAIN AVENUE, SUITE 800
LAS VEGAS, NV 89102-1700

United States Postal Service
Facilities Department

Facilities Service Office
850 CHERRY AVENUE, 4TH FLOOR
SAN BRUNO, CA 94069

USPS DOWNTOWN STATION
301 EAST STEWART
LAS VEGAS, NEVADA

REFLECTED CEILING PLAN

Revisions

Number 88-438
Date 9-17-88

USPS File Number

UNITED STATES POST OFFICE

63864