


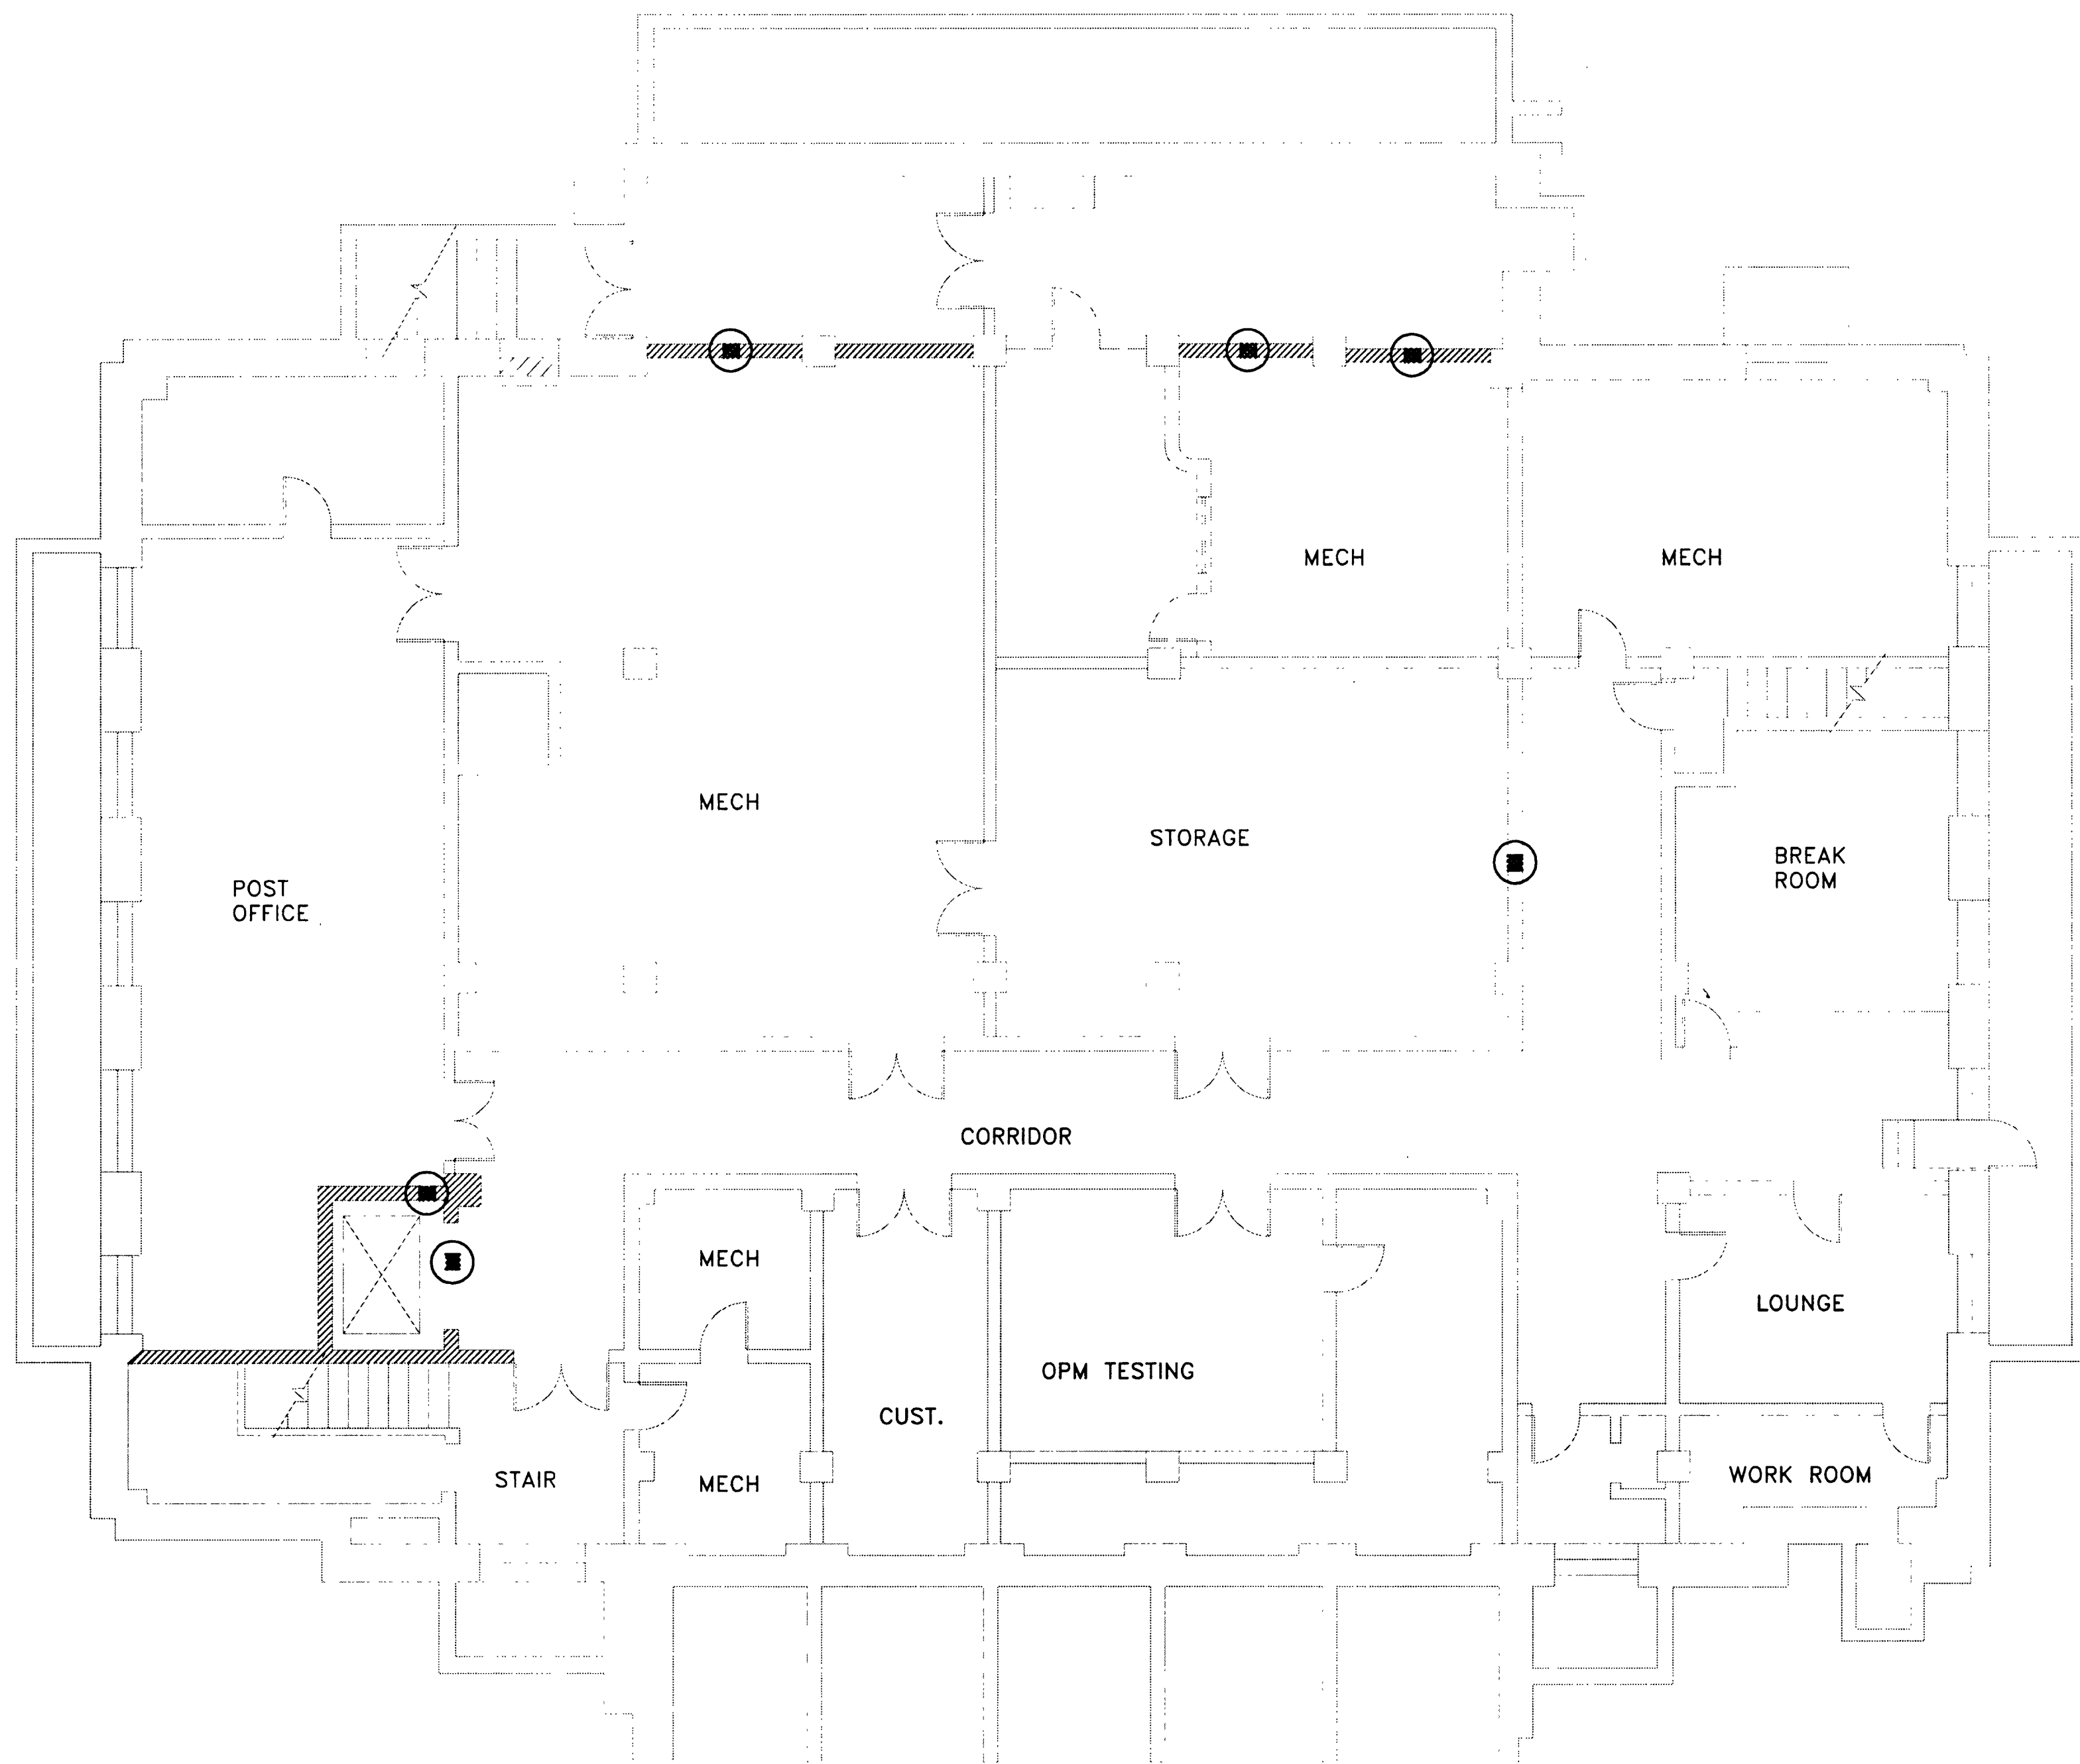

1 BASEMENT FLOOR PLAN
1:100mm

1mm=100mm
0 100 200 400 800



KEYNOTES - THIS SHEET

SYMBOLS

- PIPE PASSAGE THRU EXISTING WALL.
WILL REQUIRE ANY NEEDED PATCHING
FROM PIPE PASSAGE DEMOLITION.
- EXISTING 2-HOUR WALL

GENERAL NOTES

1. ALL FIRE SPRINKLER PIPING EXPOSED ON THIS FLOOR
2. ALL WALL PENETRATIONS THRU EXISTING WALLS TO BE 1-HOUR PENETRATIONS EXCEPT WHERE SHOWN AS PENETRATING A 2-HOUR WALL, FIRE STOPPED TO THESE RATINGS.
3. ALL FLOOR PENETRATIONS (THRU CONCRETE SLABS) INCLUDING CONCRETE PENETRATIONS THRU ATTIC AREA FLOORS TO HAVE 2-HOUR RATED AND FIRE STOPES FOR 2-HOUR PENETRATION.

Design & Construction Division
450 Golden Gate Ave.
San Francisco, California 94102

General
Services
Administration

IF SHEET IS LESS THAN 610MM x 915MM IT IS A
REDUCED PRINT. REDUCE SCALE ACCORDINGLY.

the architect's company
205 with standard
room, space, 1576
Phone (510) 427-406 Fax (510) 424-497

INSTALL FIRE SPRINKLER SYSTEM
LAS VEGAS FEDERAL BUILDING
POST OFFICE
LAS VEGAS, NEVADA

A/E CONTRACT NO. -
Proj. no. - Bldg. no.

Revisions		
No.	Approved By	Date

Architectural	Structural	Mechanical	Electrical
Approved			
Drawing	By	Date	Checked
2	RJB	5/14/96	D.B.
Drawing Title			
BASEMENT FLOOR PLAN			
Drawing Number			
A1			