




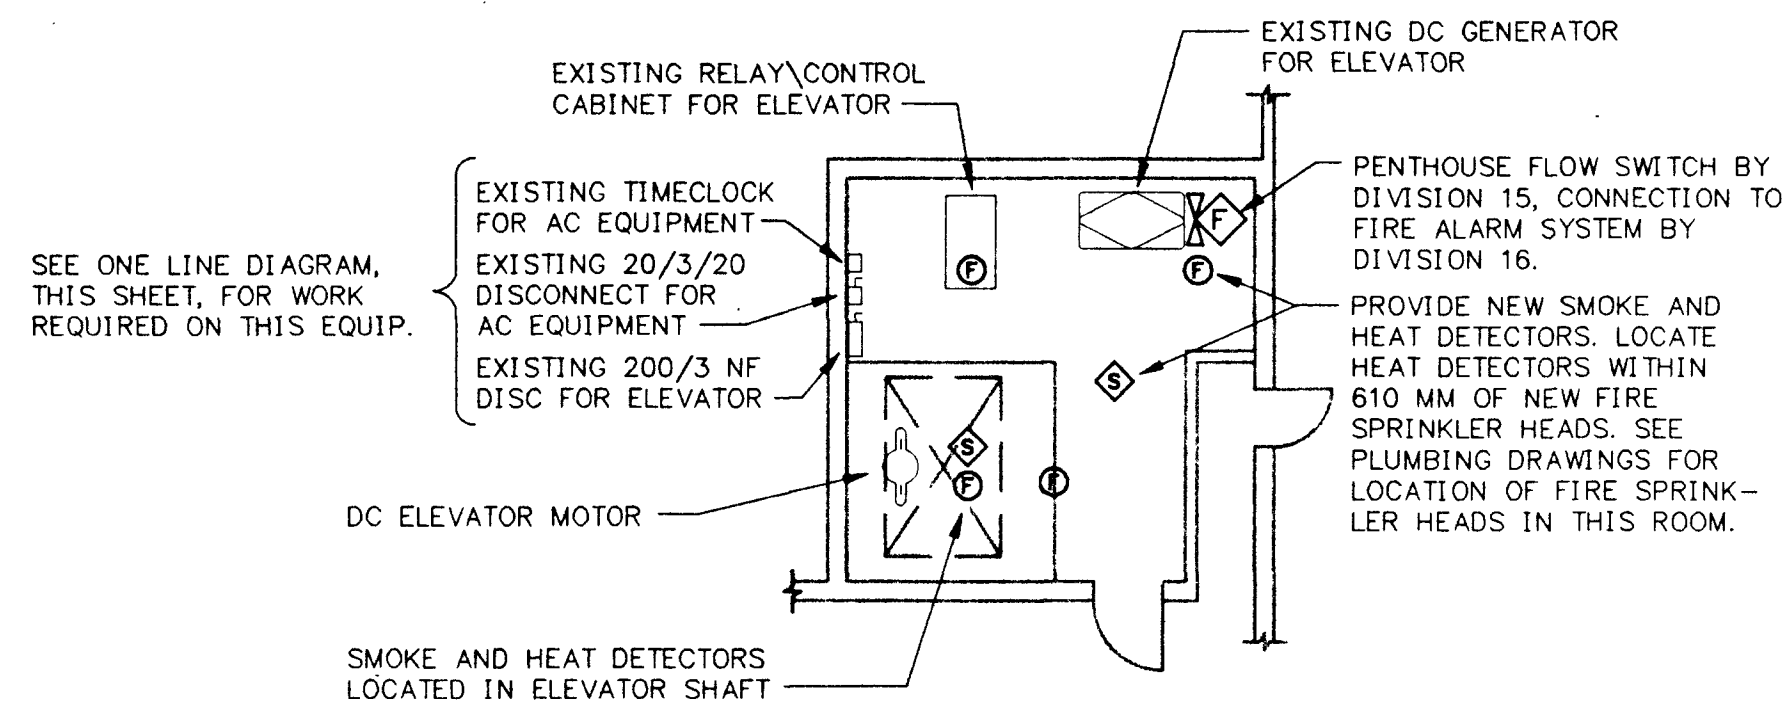


ELEVATOR ROOM/PENTHOUSE FIRE ALARM SYSTEM PLAN
SCALE: 1:100

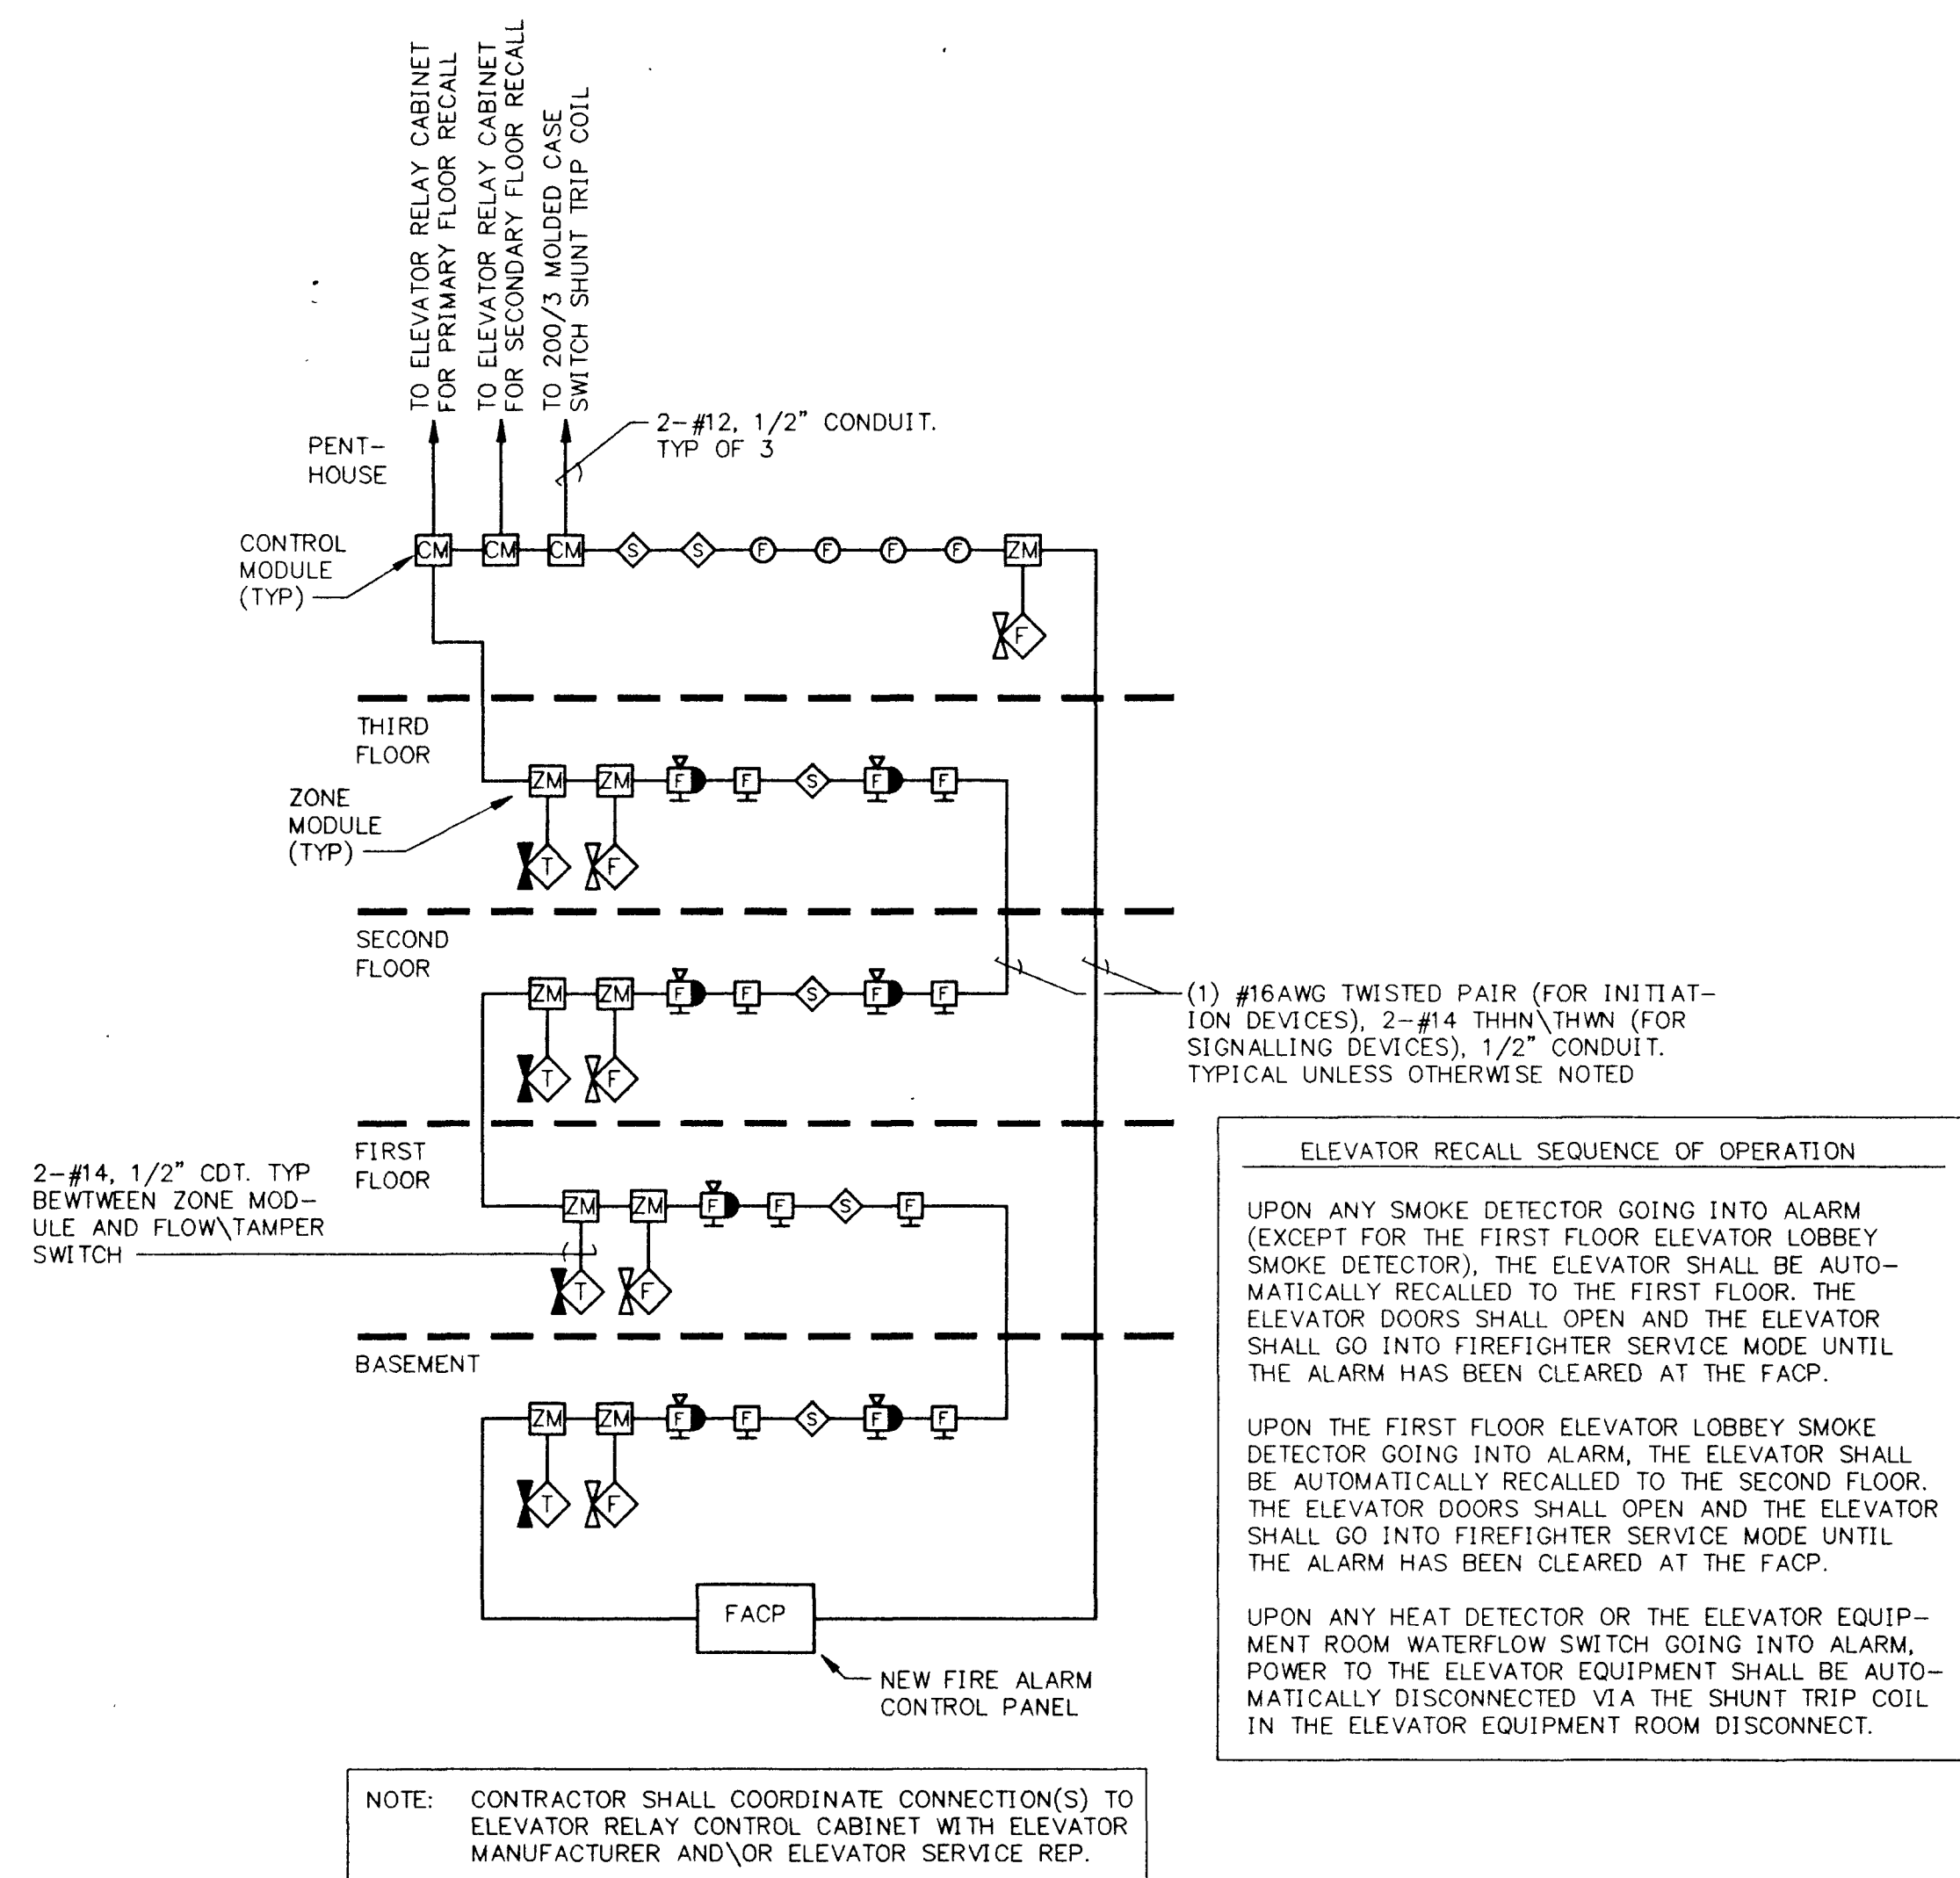

ELEVATOR EXISTING ONE LINE DIAGRAM
SCALE: N.T.S.

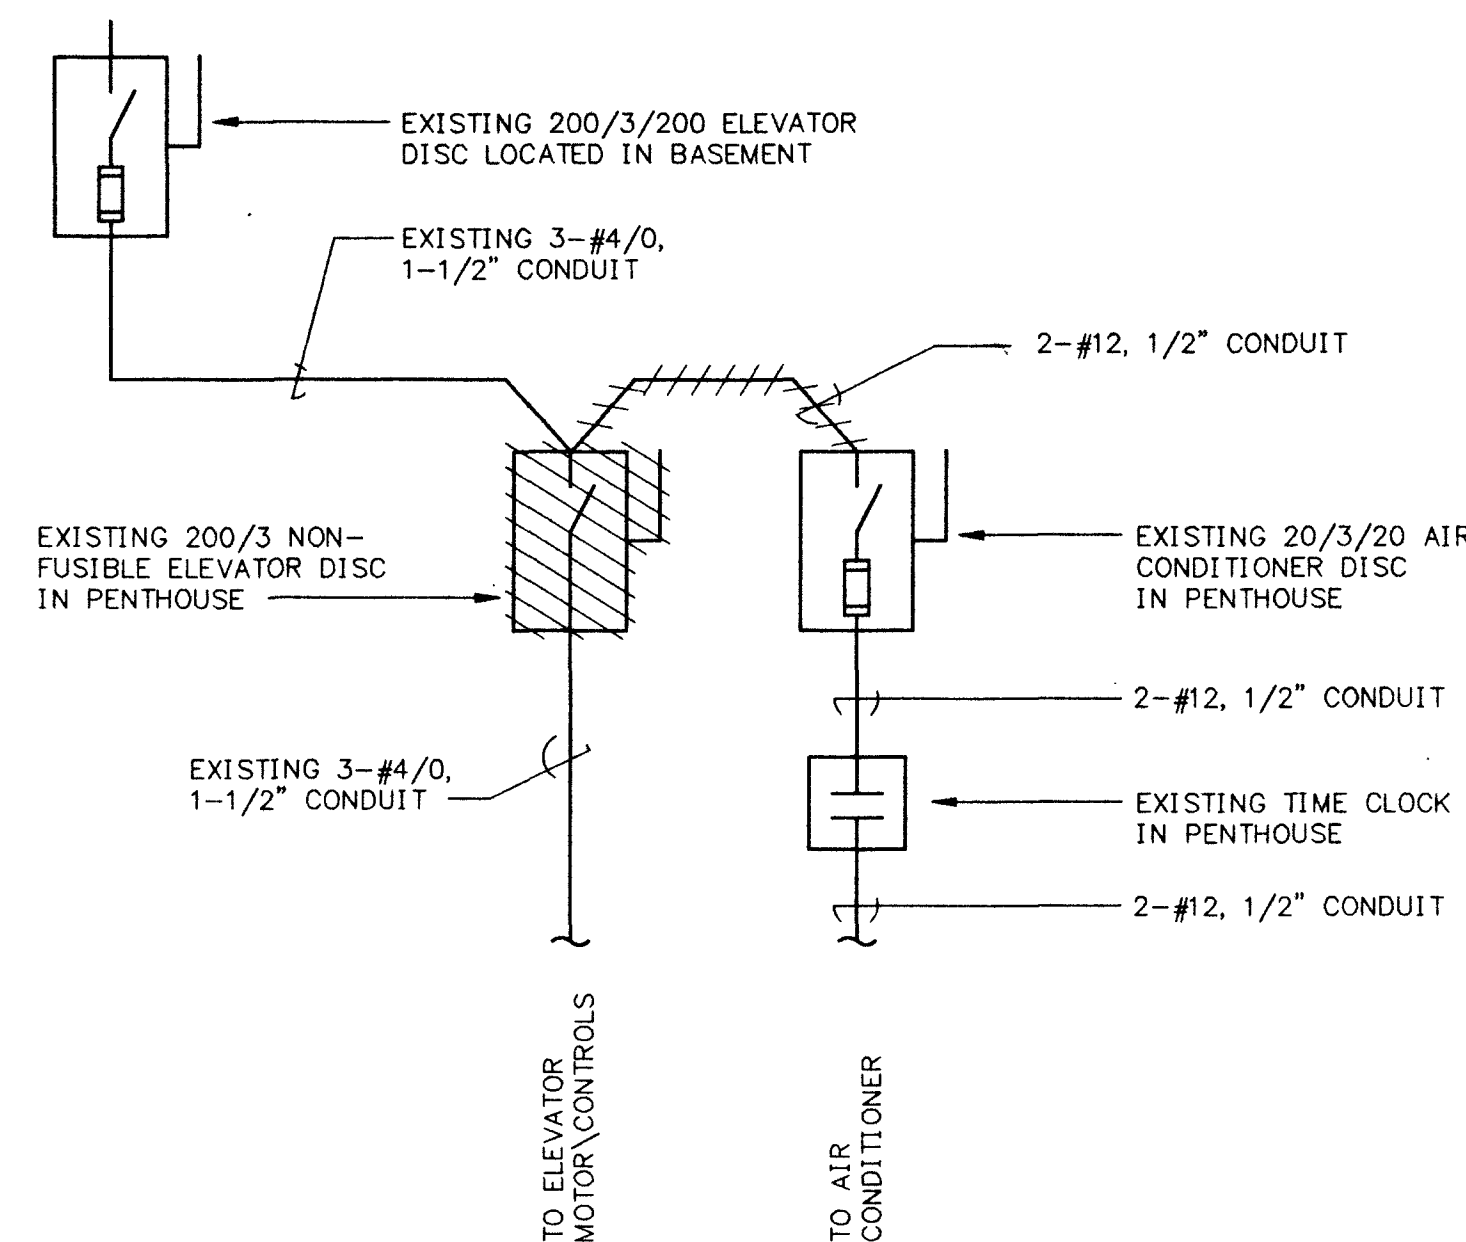

ELEVATOR EXISTING ONE LINE DIAGRAM
SCALE: N.T.S.

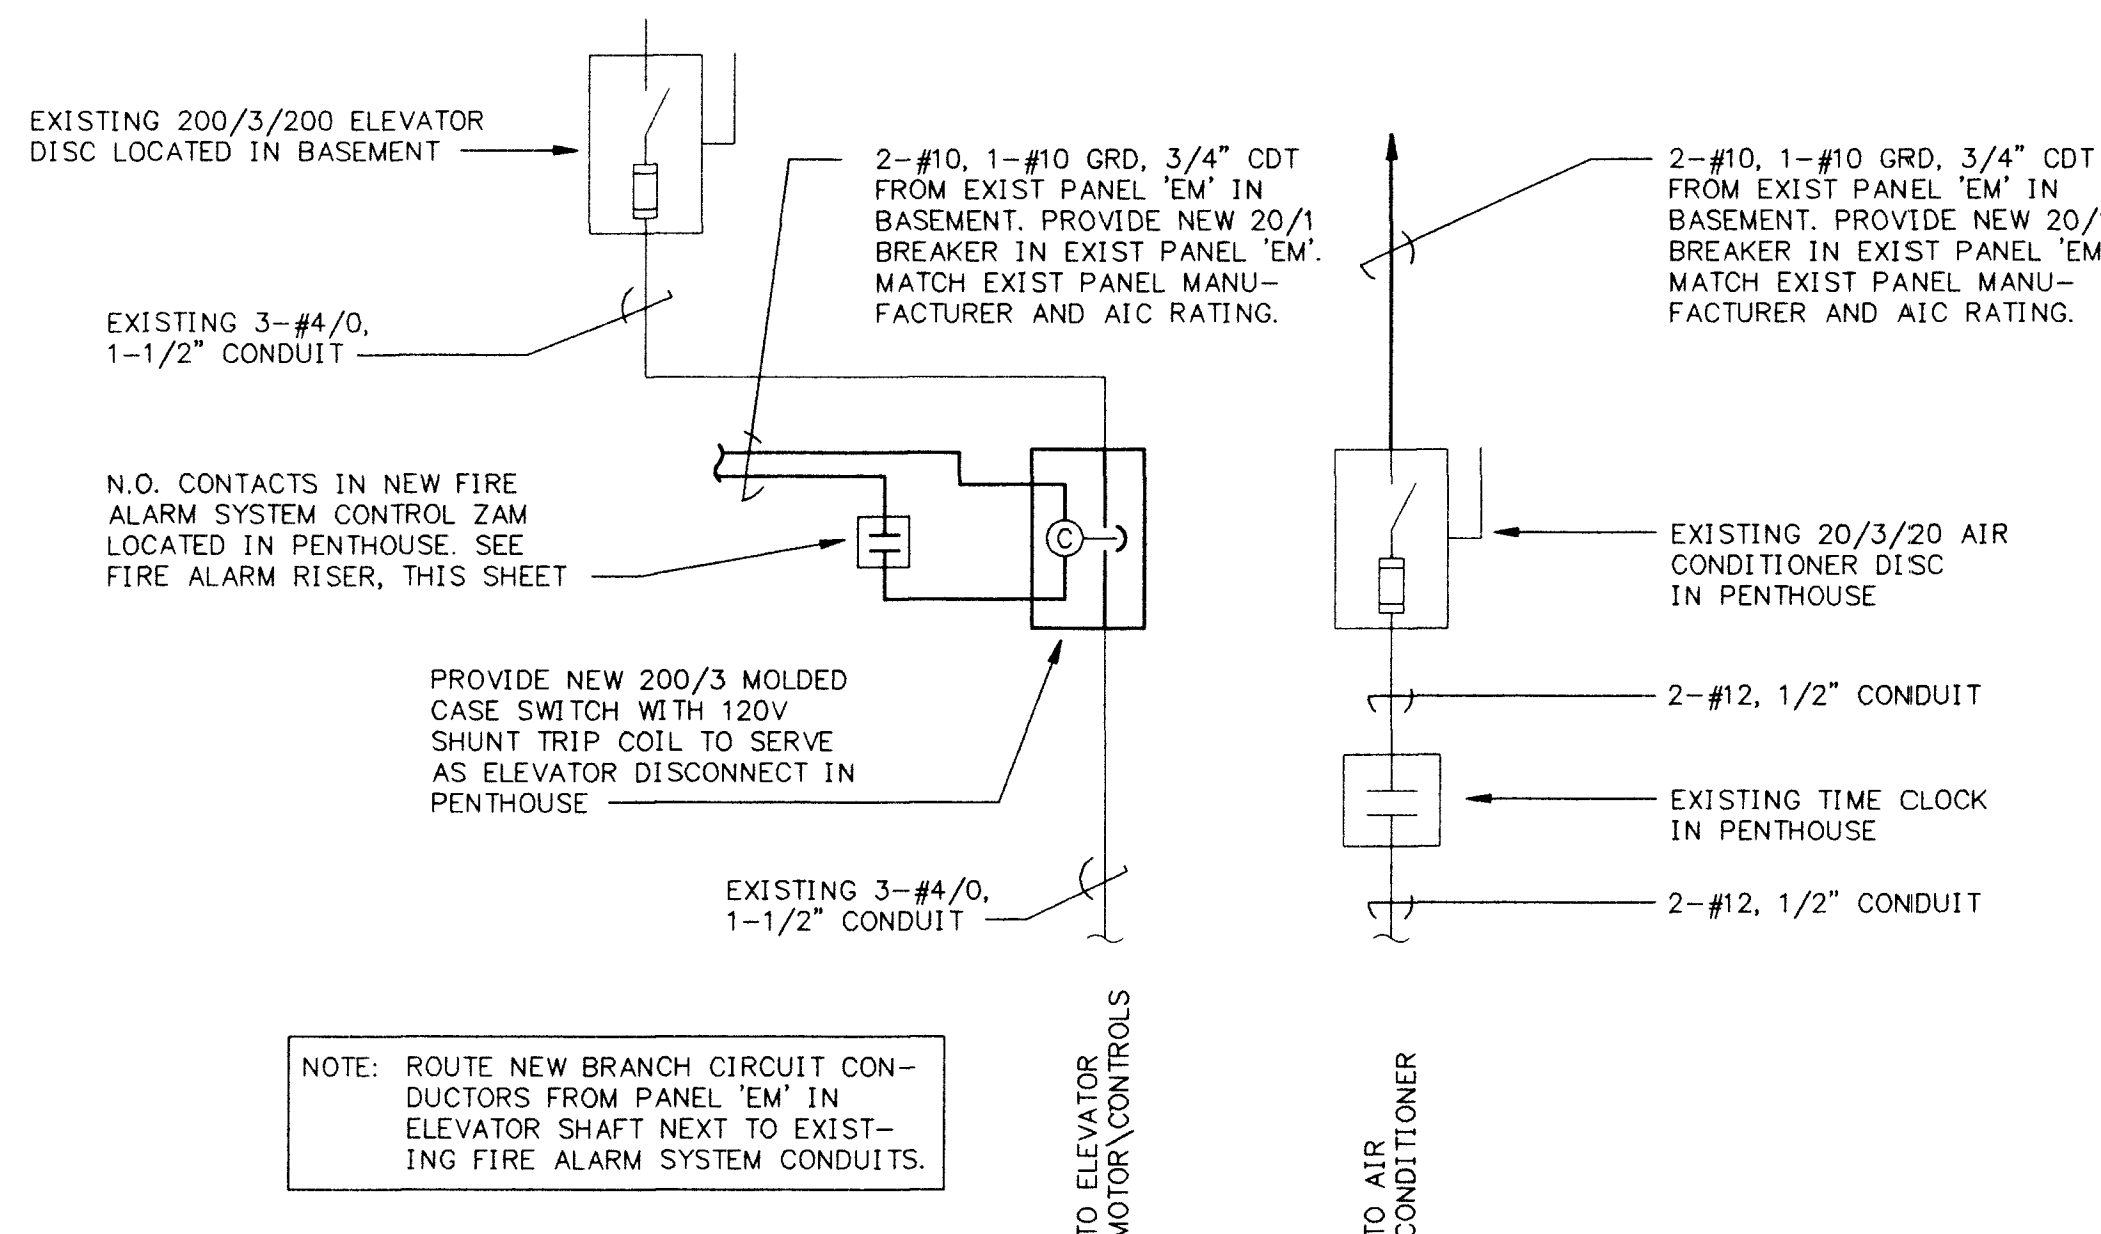

ELEVATOR EXISTING ONE LINE DIAGRAM
SCALE: N.T.S.

SYMBOLS

	FLOW SWITCH
	TAMPER SWITCH
	FIRE ALARM HEAT DETECTOR
	FIRE ALARM MANUAL STATION
	FIRE ALARM HORN/SPEAKER
	FIRE ALARM HORN WITH LIGHT
	FIRE ALARM SYSTEM CONTROL PANEL/TRANSPONDER
	SMOKE DETECTOR
	DISCONNECT SWITCH, 200A, 3 POLE, 150A FUSES
	JUNCTION BOX - WALL/CLG MOUNTED
	KEYED NOTE - SEE NOTE SCHEDULE ON SAME DRAWING

ABBREVIATIONS

AMP	AMP
AC	ALTERNATING CURRENT
AFF	ABOVE FINISHED FLOOR
AV	AUDIO/VISUAL
CDT	CONDUIT
DC	DIRECT CURRENT
DISC	DISCONNECT
DIST	DISTRIBUTION
EQUIP	EQUIPMENT
EXIST	EXISTING
FA	FIRE ALARM
GRD	GROUND
JB	JUNCTION BOX
MTD	MOUNTED
PNL	PANEL
TYP	TYPICAL
V	VOLT

1:100 SCALE 0 2 4 6 8 METERS

CBA CELLA BARR ASSOCIATES
4911 E. BROADWAY
TUCSON, ARIZONA 85711
(520) 760-7474
JOB No. 1-0651914

Design & Construction Division
525 Market Street
San Francisco, California
General Services Administration

IF SHEET IS LESS THAN 610MM x 915MM IT IS A REDUCED PRINT. REDUCE SCALE ACCORDINGLY.

the architecture co.
2825 n. silverbell rd.
tucson, az. 85745
(520) 622-4506

A/E CONTRACT NO. Bldg. no. Proj. no.

Revisions		
No.	Approved By	Date

Approved	By	Date	Checked

ONE LINE DIAGRAM, RISER
DIAGRAM, SYMBOLS

Draw Type	Sequence OF	Drawing Number

E5

521-279-5

63 893