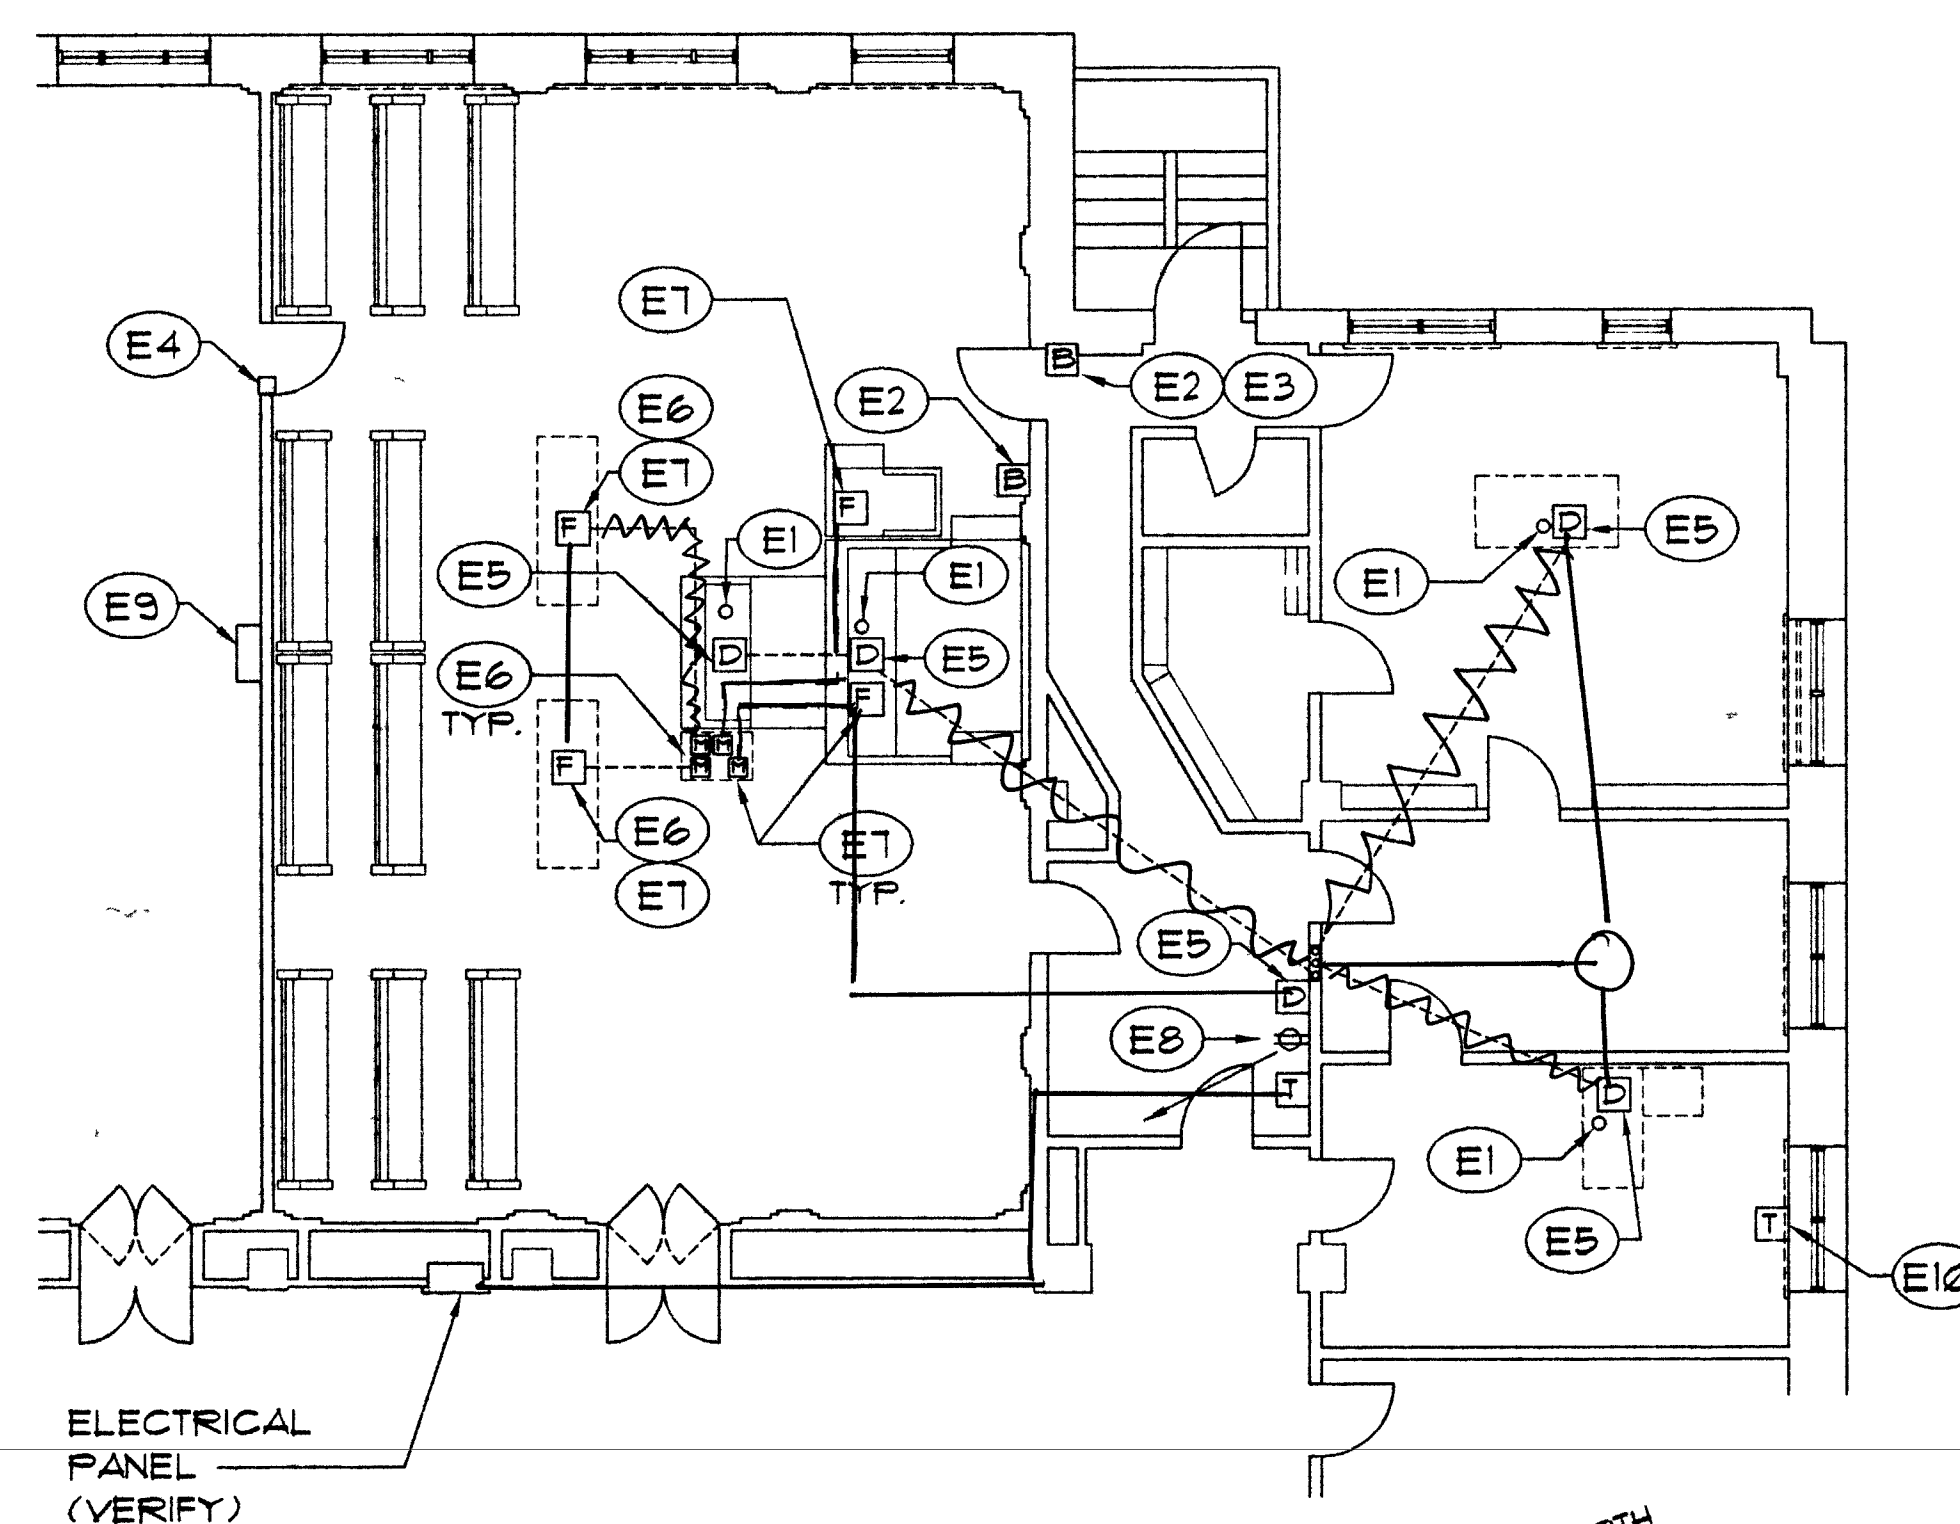


64803

14. WHERE ELECTRICAL WORK IS SPECIFIED IN CONJUNCTION WITH THE CABINETRY, THE CABINET CONTRACTOR SHALL COORDINATE HIS WORK (CUTOUPS FOR THE SWITCHES, OUTLETS, ETC.) WITH THE ELECTRICAL CONTRACTOR.
15. OMIT
16. OMIT
17. ALL ELECTRICAL LINES SHALL BE CONCEALED UNLESS OTHERWISE NOTED.
18. OMIT
19. NO MATERIALS SHALL BE STORED ON THE PUBLIC PROPERTY.
~~AN ENCROACHMENT PERMIT IS FIRST OBTAINED FROM THE PUBLIC~~
~~SEE SITE MAP FOR CONTRACTOR STAGING AREA.~~
20. ALL PAINT AND STAIN MATERIALS MUST COMPLY WITH LOCAL, STATE, AND FEDERAL AIR POLLUTION CONTROL MANDATES.
21. ALL GLASS USED ON THIS JOB TO REPAIR DAMAGED WINDOWS SHALL BE TEMPERED GLASS AND FULLY TEMPERED


$$1/8" = 1'-0"$$
$$1/8" = 1'-0"$$

NORTH

PROJECT NORTH

1/8" x 1'-0"

----- CONDUIT (BELOW FLOOR)

----- REPORTER'S MICROPHONE LEAD WIRE SYSTEM
CONDUIT (ABOVE FLOOR / UNDER RAISED PLATFORM)

· [M] *3M MICROPHONE CABLE CONNECTORS

[F] *3F MICROPHONE CABLE CONNECTORS ..

[D] DURESS ALARM SYSTEM COMPONENT
(FOR INFORMATION ONLY - SEE NOTE E5)

[B] BUZZER SYSTEM COMPONENT

[T] TELEPHONE SYSTEM EQUIPMENT
(FOR INFORMATION ONLY - SEE NOTE E10)

OFFICE FURNITURE (SHOWN FOR REFERENCE ONLY -
VERIFY EXACT LOCATIONS OF ELECTRICAL WORK
WITH GSA CONTRACTING OFFICER'S REPRESENTATIVE)

PERMANENTLY ATTACHED FURNITURE (SHOWN FOR
REFERENCE ONLY - VERIFY EXACT LOCATIONS OF
ELECTRICAL WORK WITH GSA CONTRACTING
OFFICER'S REPRESENTATIVE).

- E1. CORE DRILL 1" DIAMETER HOLE THRU CONCRETE FLOOR FOR N.I.C. TELEPHONE WIRE. VERIFY LOCATION OF HOLE WITH GSA CONTRACTING OFFICER'S REPRESENTATIVE. CONTRACTOR MUST TAKE PRECAUTIONS NOT TO DISTURB OCCUPANTS OR DAMAGE CONTENTS OF ROOM BELOW. FIRE SEAL HOLE AFTER INSTALLATION OF WIRE BY OTHERS. FOUR (4) HOLES TOTAL.
- E2. BUZZER SYSTEM: INSTALL A TRANSFORMER MOUNTED ON EXISTING HIGH OUTLET WITH LOW VOLTAGE WIRING TO EXISTING PUSHBUTTON ON DOOR. THIS SHALL ACTIVATE A BUZZER LOCATED IN THE COURTROOM ON WALL AT 42". ALL WIRING SHALL BE CONCEALED IN WALL. CUT AND PATCH AS REQUIRED. FINISH WALL TO MATCH ADJACENT SURFACES. LOCATION OF BUZZER TO BE VERIFIED WITH GSA CONTRACTING OFFICER'S REPRESENTATIVE.
- E3. CONCEAL EXISTING ACTIVE EXPOSED WIRING IN THE WALL. CUT, PATCH, AND REFINISH AS REQUIRED (SEE FLOOR PLAN SHEET A12).
- E4. DOOR ALARM: INSTALL A DOOR ALARM CONTACT THAT SHALL BE WIRED TO AND REPORT TO THE SAME ALARM PANEL (LOCATED IN BASEMENT) AS EXISTING DOOR CONTACT IN HALL 104 TO CORRIDOR. FURNISH ALL CONDUIT AND WIRING AS REQUIRED. CONDUIT SHALL BE ALUMINUM BUT FINISH AREAS. CUT AND PATCH AS REQUIRED, FINISH TO MATCH EXISTING ADJACENT SURFACES.
- E5. DURESS ALARM SYSTEM: PROVIDE RECESSED JUNCTION BOX AND 3/4" CONDUITS UNDER FLOOR FROM LOCATION INDICATED IN HALL 104 TO FLOOR MOUNTED JUNCTION BOXES UNDER JUDGE'S BENCH & CLERK'S BENCH IN THE COURTROOM, AND UNDER JUDGE'S DESK & CLERK'S DESK IN THE OFFICES. VERIFY ALL LOCATIONS WITH GSA CONTRACTING OFFICER'S REPRESENTATIVE. PROVIDE FULL STRING IN EACH CONDUIT.


NOTE: DURESS ALARM SYSTEM EQUIPMENT AND WIRING WILL BE REMOVED FROM ITS EXISTING LOCATION, RELOCATED, AND REINSTALLED BY OTHERS - NOT A PART OF THIS CONTRACT.
- E6. CORE DRILL HOLES THRU CONCRETE FLOOR FOR MICROPHONE WIRE SYSTEM CONDUITS (SEE NOTE E7). FIRE SEAL HOLES AFTER CONDUIT PLACEMENT.
- E7. REPORTER'S MICROPHONE WIRE SYSTEM FOR RECORDING: INSTALL 3/4" RIGID CONDUIT UNDER THE FLOOR OR UNDER RAISED PLATFORMS TO HOUSE MICROPHONE LEAD WIRES FOR REPORTER'S RECORDING EQUIPMENT. RUN CONDUIT FROM THE MAIN FLOOR BOX UNDER THE REPORTER'S TABLE TO FLUSH MOUNTED FLOOR RECEPTACLES UNDER THE JUDGE'S BENCH, WITNESS STAND, AND THE TWO (2) COUNSEL TABLES (SEE ELECTRICAL PLAN).

INSTALL CONDUCTOR SHIELDED #8 STRANDED MIKE CABLE FROM THE FLOOR RECEPTACLES AT THE JUDGE'S BENCH, WITNESS STAND, AND TWO (2) COUNSEL TABLES. EACH CABLE END SHALL TERMINATE ON THE TOP OF THE REPORTER'S TABLE.

#8 MICROPHONE CABLE CONNECTORS TO BE CONNECTED TO #8 CABLE ENDS MOUNTED ON THE FLUSH FLOOR RECEPTACLES AT THE JUDGE'S BENCH, WITNESS STAND, THE TWO (2) COUNSEL TABLES.

#8 MICROPHONE CABLE CONNECTORS TO BE CONNECTED TO THE FOUR (4) CABLE ENDS THAT TERMINATE ON TOP OF THE REPORTER'S TABLE.
- E8. PROVIDE A NEW DUPLEX ELECTRICAL RECEPTACLE ON WALL IN HALL 104 FOR THE DURESS ALARM SYSTEM EQUIPMENT. CONNECT TO AVAILABLE CIRCUIT IN ELECTRICAL PANEL. VERIFY ALL LOCATIONS WITH GSA CONTRACTING OFFICER'S REPRESENTATIVE.
- E9. PROVIDE A NEW MOTION SENSOR ACTIVATED LIGHTING CONTROL SYSTEM FOR THE COURTROOM LIGHTING. INSTALL POWER PACK AND OTHER RELATED SYSTEM EQUIPMENT AT THIS LOCATION. SEE WEST INTERIOR ELEVATION SHEET A13 FOR MOUNTING LOCATIONS OF MOTION SENSORS. SEE SPECIFICATIONS FOR SYSTEM REQUIREMENTS.
- E10. EXISTING TELEPHONE SYSTEM TO BE RELOCATED BY OTHERS - NOT IN CONTRACT.

THE ABOVE DRAWINGS AND SPECIFICATIONS AND IDEAS, DESIGNS, AND ARRANGEMENTS REPRESENTED THEREBY ARE AND SHALL REMAIN THE PROPERTY OF THE ARCHITECT, AND NO PART THEREOF SHALL BE COPIED, DISCLOSED TO OTHERS OR USED IN ANY MANNER WITHOUT THE WRITTEN CONSENT OF THE ARCHITECT. NO PART OF THIS PROJECT FOR WHICH THEY HAVE BEEN PREPARED AND DEVELOPED WITHOUT THE WRITTEN CONSENT OF THE ARCHITECT. VISUAL CONTACT WITH THESE DRAWINGS OR SPECIFICATIONS SHALL CONSTITUTE CONCLUSIVE EVIDENCE OF ACCEPTANCE OF THE SAME. ANY WRITTEN DIMENSIONS ON THESE DRAWINGS SHALL HAVE PRECEDENCE OVER ANY ORAL DIMENSIONS. CONTRACTORS SHALL VERIFY, AND BE RESPONSIBLE FOR, ALL DIMENSIONS AND CONDITIONS OF THE JOB AND THIS OFFICE SHALL NOT BE RESPONSIBLE FOR ANY ERRORS OR OMISSIONS. ANY DIMENSIONS SHOWN ON THESE DRAWINGS SHALL BE DEEMED TO BE SUBMITTED TO THIS OFFICE FOR REVIEW AND APPROVAL.

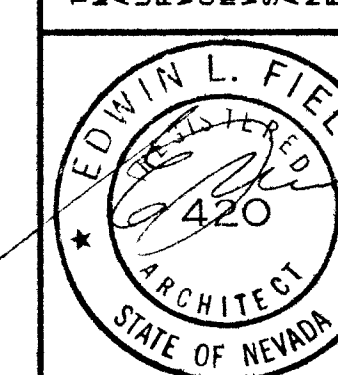

RENOVATION OF TAX COURT, SECOND FLOOR

TAX COURT, S
EAST STEWART STREET

GEN. NOTES, NOTES, ABBREVIATIONS, ELECT. PLAN

THE HEPY GROUP
Detroit, Michigan
Denver, Colorado
Orlando, Florida
Seattle, Washington

**FIELDS & DEVEREAUX
ARCHITECTS, AIA**

116 NORTH ROBERTSON BOULEVARD LOS ANGELES, CALIFORNIA 90048 213/853-0160

scale AS NOTED	sheet A1
drwn GGN	

checked	job no
approved	date

GSA PROJECT NUMBER: RNV53330
GSA BUILDING NUMBER: NV0005ZZ
52-279-6