

IMPROVEMENT PLANS FOR UPS NORTH FACILITY EXPANSION



CITY OF LAS VEGAS
STATE OF NEVADA
APN: 139-28-703-001, 009

DEVELOPER:
UNITED PARCEL SERVICE
740 MARTIN LUTHER KING BOULEVARD
LAS VEGAS, NEVADA 89106

PROJECT NAME: UPS North Facility
P.C.F.
This project water plan complies with the Las Vegas Valley Water District's technical requirements. However, this water plan is
NOT APPROVED FOR CONSTRUCTION
at this time and this signature does not provide or imply a water commitment.
Ray Lang 05/26/09
LWVWD #52 DATE

SHEET INDEX

SHEET #	DESCRIPTION
C1	COVER SHEET
C2	GENERAL NOTES
C3	PAVEMENT RESTORATION PLAN
C4	GRADING PLAN (NORTH)
C5	GRADING PLAN (SOUTH)
C6	UTILITY AND STREET LIGHTING PLAN
C7	STRIPING, SIGNAGE, AND FIRE LANE PLAN
C8	DETAIL SHEET
C9	DETAIL SHEET

APPROVALS


Charles Kalkowski, Jr. 7-9-2001
CHARLES KALKOWSKI, JR. PE 4477
CITY ENGINEER DATE

APPROVAL OF THESE PLANS BY THE CITY ENGINEER IS LIMITED TO THOSE IMPROVEMENTS CONSTRUCTED IN THE DEDICATED RIGHT-OF-WAY AND/OR DEDICATED EASEMENTS. THIS APPROVAL DOES NOT AUTHORIZE THE CONSTRUCTION OF ANY IMPROVEMENTS THAT DEVIATE FROM THE ADOPTED STANDARDS AND/OR SPECIFICATION EXCEPT THOSE SPECIFICALLY LISTED UNDER DEVIATIONS FROM THE STANDARDS. THE ENGINEER SHALL RESOLVE ANY DEVIATIONS OTHER THAN THOSE LISTED IN THE DEVIATIONS FROM STANDARDS IN FAVOR OF THE UNIFORM STANDARD DRAWINGS AND SPECIFICATIONS, CLARK COUNTY AREA, NEVADA.

John Koswan 7/5/2001
JOHN KOSWAN, CURRENT PLANNING MANAGER DATE
THIS PLAN MEETS THE APPLICABLE STANDARDS OF THE PLANNING AND DEVELOPMENT DEPARTMENT

Robert Bell 6/6/01
ROBERT BELL, CITY FIRE MARSHAL DATE

[Signature] 8/1/01
LAS VEGAS VALLEY WATER DISTRICT SHEETS 1, 2, 3 & 6 DATE

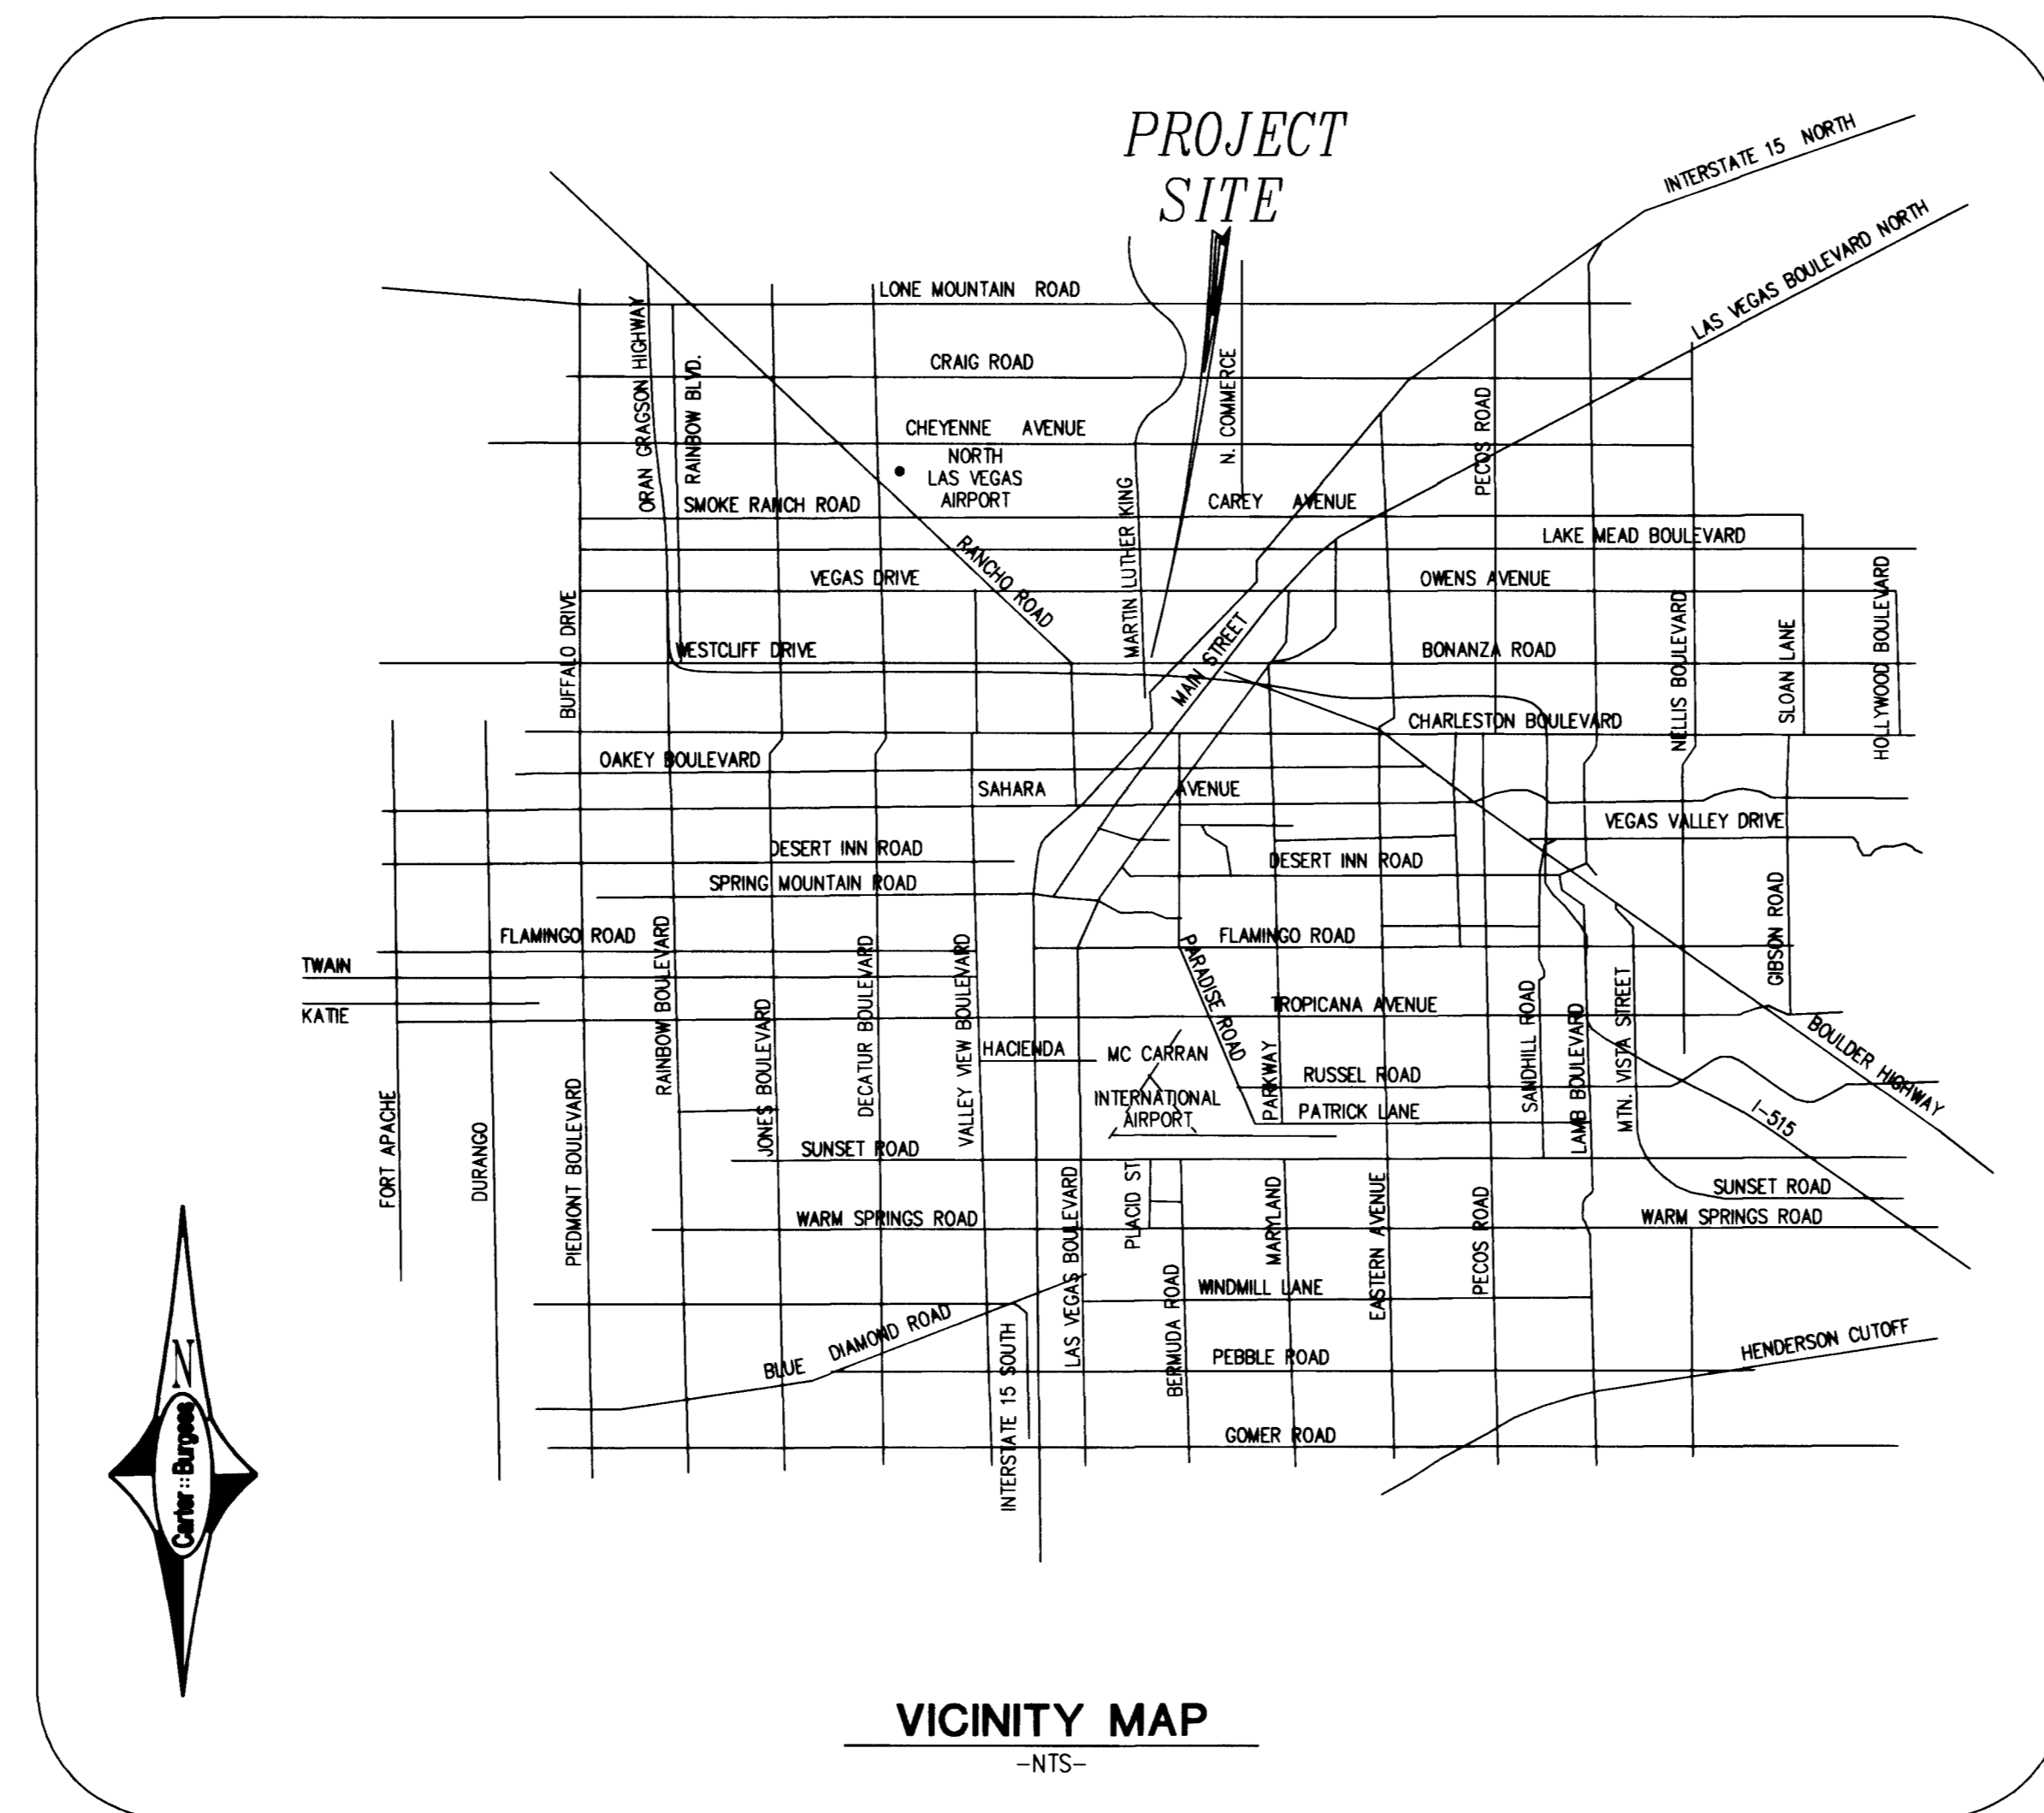

105 EAST RENO AVENUE 6 LAS VEGAS, NEVADA 89119 TEL 702 891 5201 FAX 702 891 5212	6655 Bermuda Road Las Vegas, NV 89119 (702) 888-5600 Fax: (702) 888-5454
WPH ARCHITECTURE inc	Carter Burgess Consultants in Planning, Engineering, Construction Management, and Related Services
COVER SHEET	UNITED PARCEL SERVICE NORTH FACILITY EXPANSION
DRAWN BY: JDO 06/06/01	DESIGNED BY: JDO 06/06/01
CHECKED BY: JMS 06/06/01	PROJECT NO: 240253
SCALE: N/A	HORIZ: N/A
VERT: N/A	REVISION
SHEET C1	
1 OF 9 SHEETS	
DRAWING NO. 07-V 3461	