

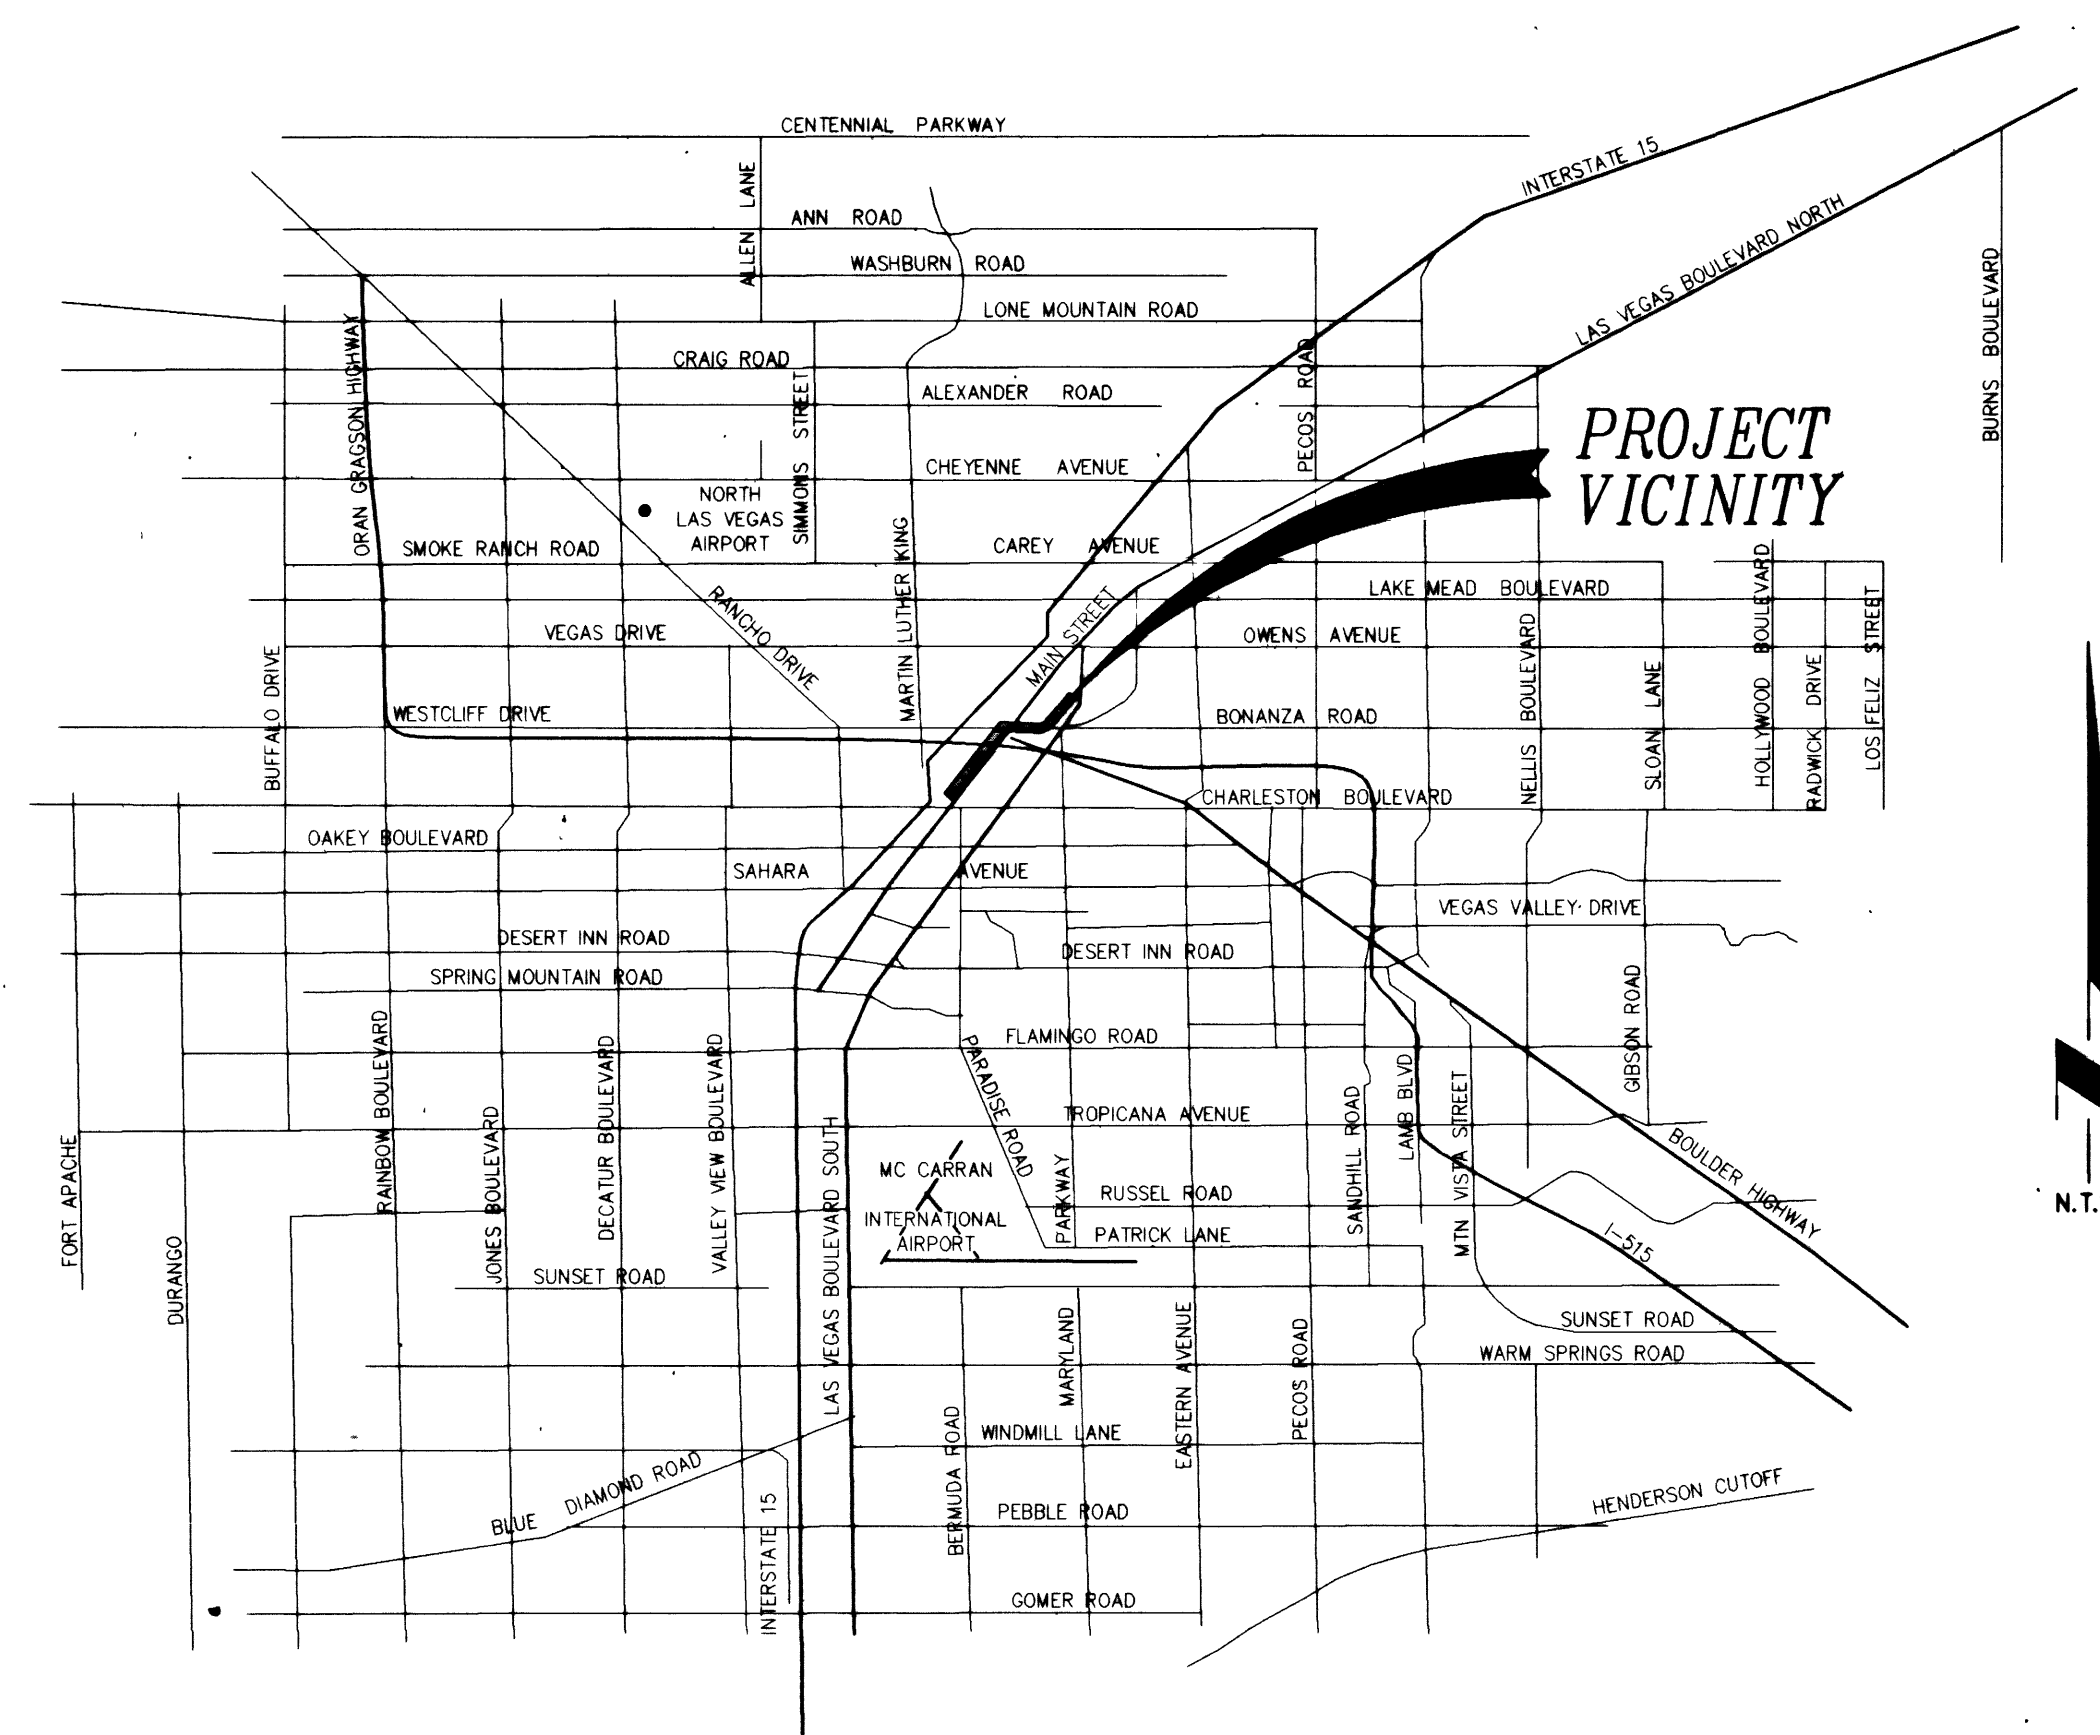
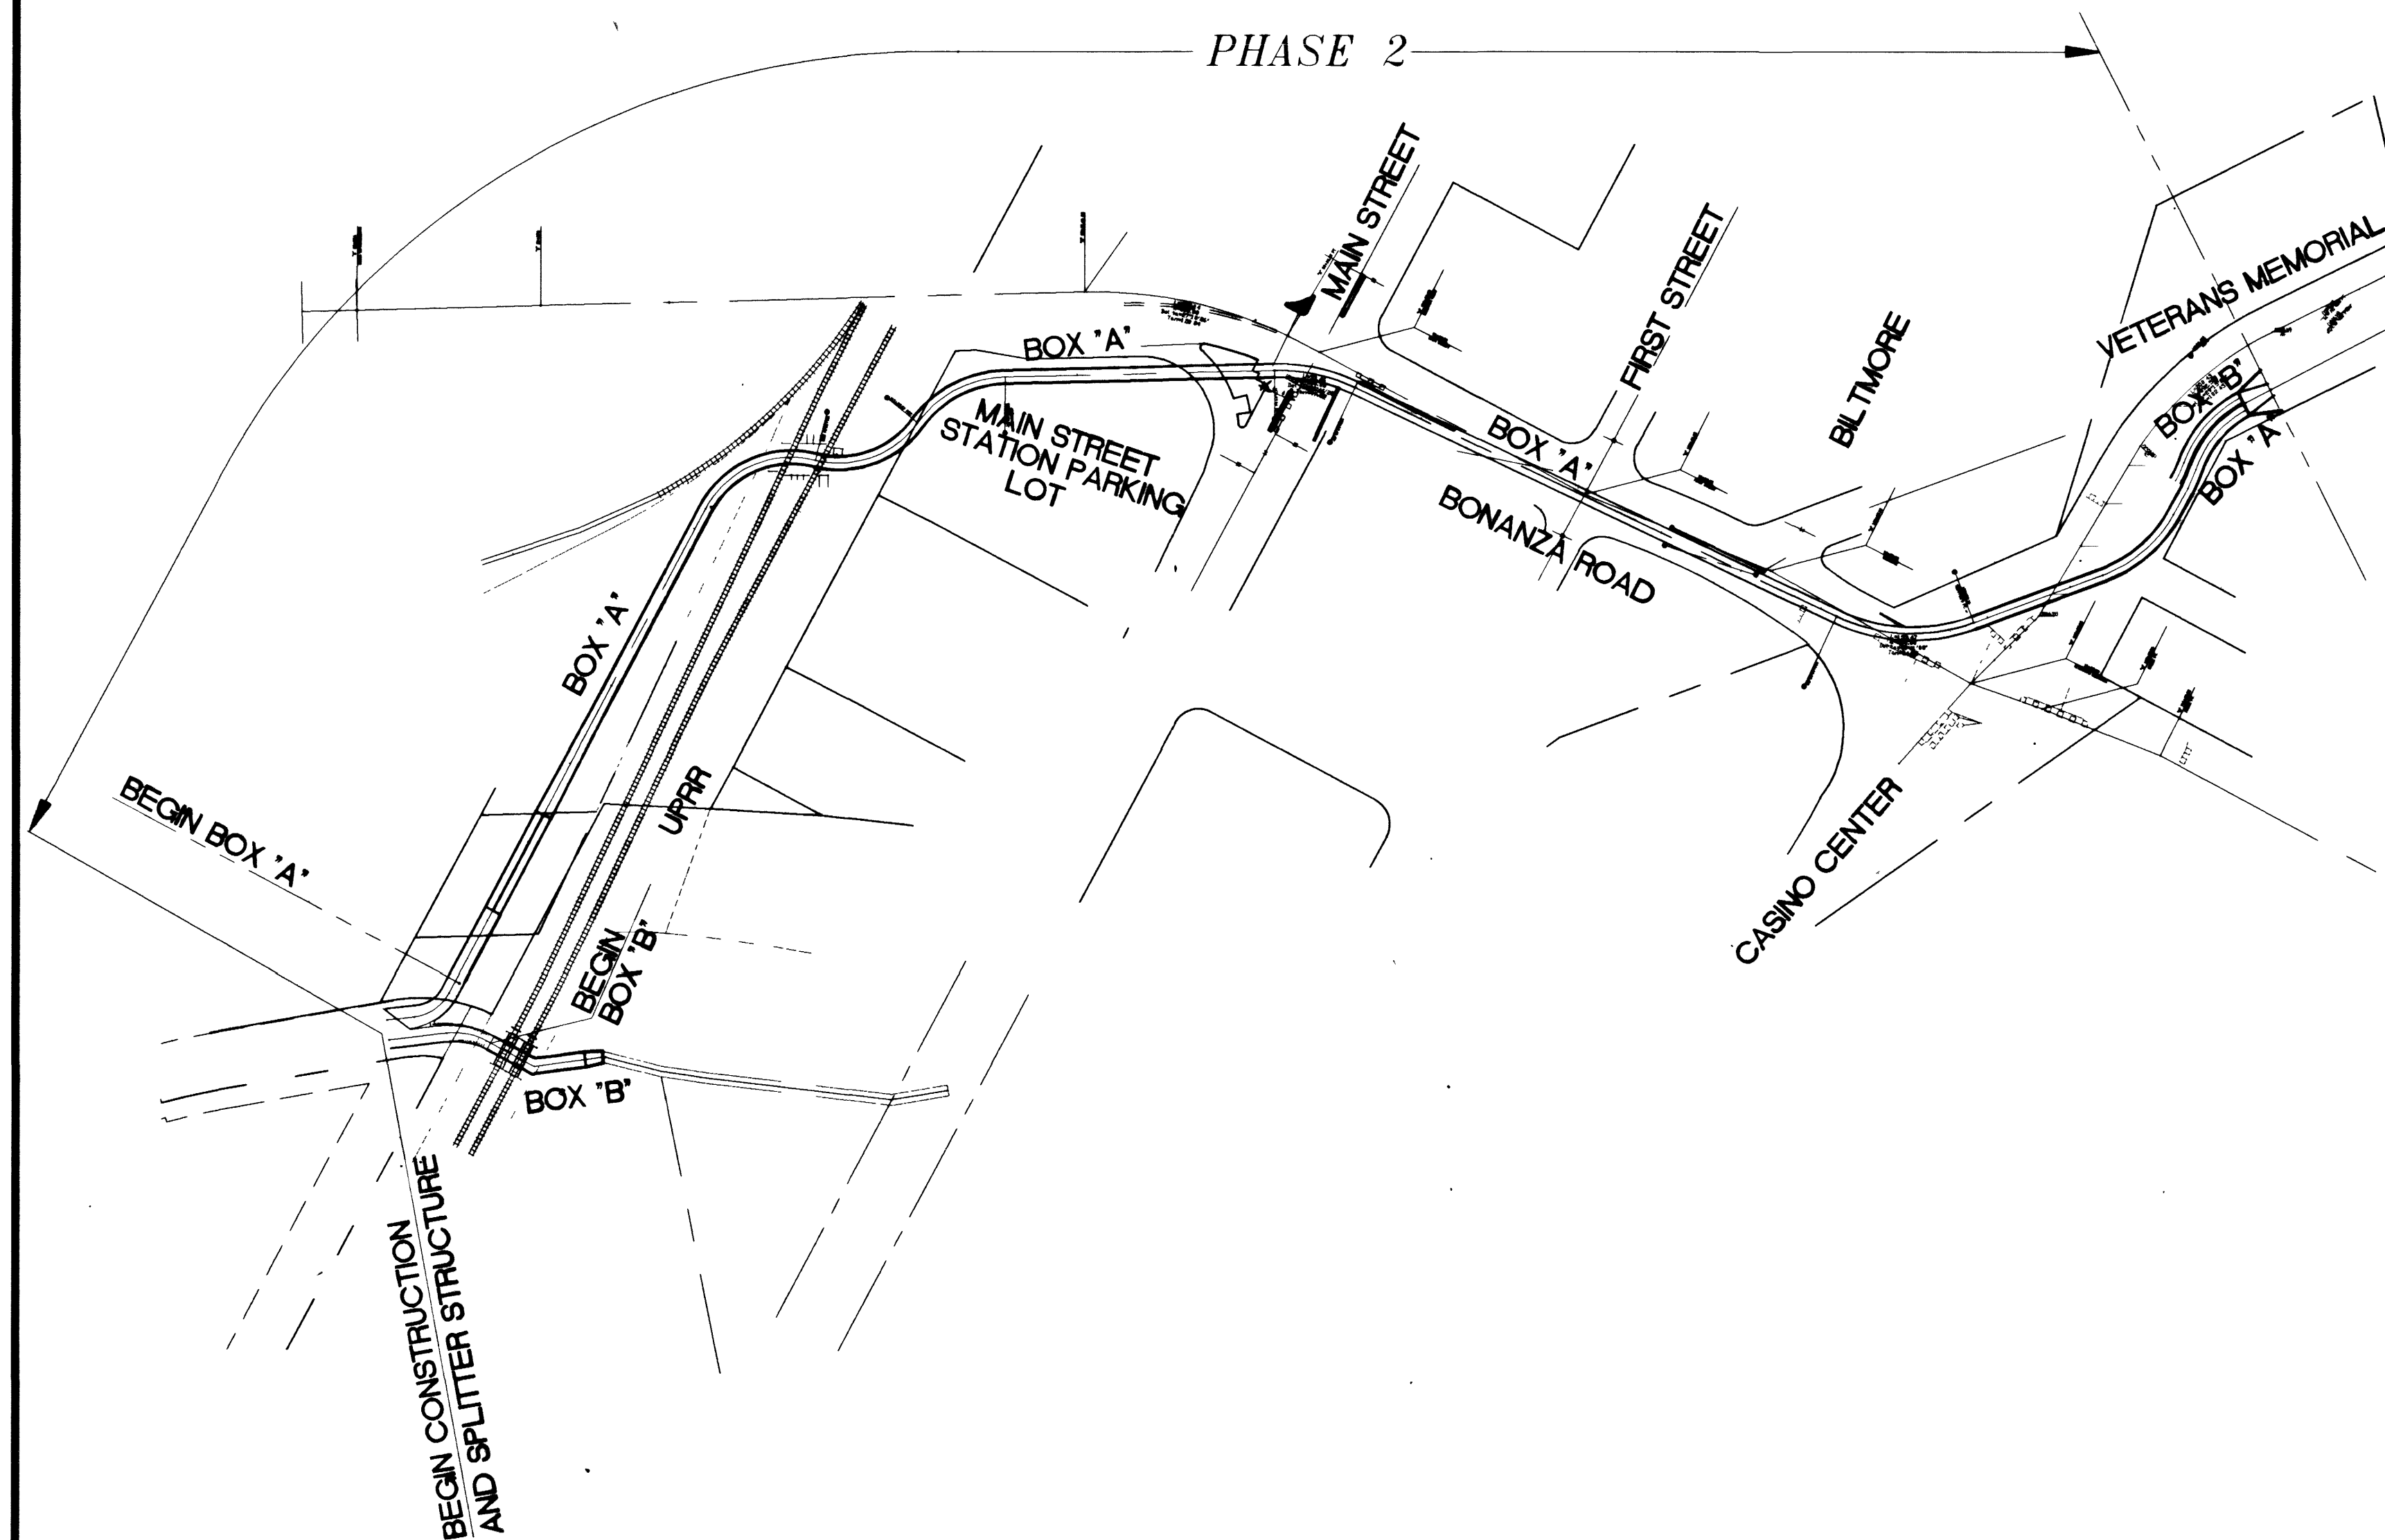


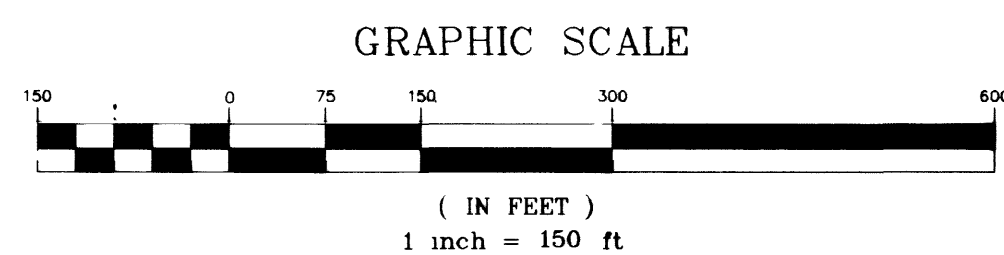

VICINITY MAP

INDEX OF DRAWINGS

<u>TOTAL</u>	<u>SHEET</u>	<u>No.</u>	<u>DESCRIPTION</u>
1	C1		COVER SHEET
2	C2		VICINITY MAP AND INDEX OF DRAWINGS
3	C3		GENERAL NOTES
4	C4		ESTIMATE OF QUANTITIES AND MANHOLE SCHEDULE
5	PG1		PROJECT GEOMETRICS AND CONTROL POINTS
6	SD1		PLAN & PROFILE STA 103+00 to 110+25.75 BOX "A"
7	SD2		PLAN & PROFILE STA 110+25.75 TO 116+00 BOX "A"
8	SD3		PLAN & PROFILE STA 116+00 TO 126+00 BOX "A"
9	SD4		PLAN & PROFILE STA 126+00 TO 129+94.44 BOX "A"
10	SD5		PLAN & PROFILE MATCH EX. RCB TO STA 129+94.44 BOX "B"
11	SD6		PLAN & PROFILE 36 - INCH STORM DRAIN & CONNECTION DETAIL
12	SD7		PLAN & PROFILE STA 103+27.51 TO 105+78.98 BOX "B"
13	SD8		PLAN & PROFILE BONANZA ROAD STORM DRAIN
14	SD9		DROP INLET PROFILES AND RETAINING WALL REPLACEMENT
15	SD10		RCB, ROB MANHOLE AND CONNECTION DETAILS.
16	SD11		CAST-IN-PLACE CHANNEL SPLITTER SECTION
17	SD12		SPLITTER PLAN AND PROFILE
18	SD13		OUTLET STRUCTURE & CROSSING RCB PLAN @ BONANZA ROAD
19	SD14		OUTLET STRUCTURE WING WALL DETAILS
20	SD15		DROP INLET DETAILS
21	SD16		C.I.P DOUBLE 9' x 8' AND TRANSITION DETAILS
22	SD17		TEMPORARY U.P.R.R. STRUCTURE SUPPORT BOX "B"
23	SD18		TEMPORARY U.P.R.R. STRUCTURE SUPPORT BOX "A"
24	SS1		6" SEWER RELOCATION STATION 0+00 TO 1+15±
25	ST		BONANZA ROAD STA 97+00.00 TO 106+00.00
26	S2		BONANZA ROAD/VETERAN'S MEMORIAL PLAN AND PROFILE
27	S3		135L STREET SECTION
28	TS1		BONANZA ROAD SIGNAGE, STRIPING, AND STREET LIGHTING PLAN
29	TS2		VETERAN'S MEMORIAL DRIVE SIGNAGE, STRIPING, AND STREET LIGHTING PLAN
30	TS3		MAIN ST. STATION SIGNAGE, STRIPING, AND STREET LIGHTING PLAN
31	T1		SIGNALIZATION PLAN (PART 1)
32	T2		SIGNALIZATION PLAN (PART 2)

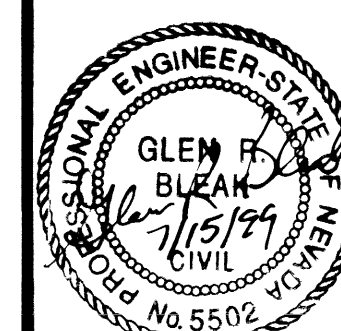

SHEET C2
2 OF 32

DRAWING NO.

731-54F

DRAWN BY: **SHEET:**

**CITY OF LAS VEGAS
UPPER WASHINGTON AVENUE CONVEYANCE SYSTEM**

PHASE 2
VICINITY MAP AND INDEX OF DRAWINGS

DRAWN BY: **SHEET:**

SCC	7/14/99	UPP
DESIGNED BY:	7/14/99	
SCC		

CHECKED BY:	7/14/99	TITLE:
GRB		

PROJECT NO:	SCALE:
--------------------	---------------


Carter Burgess

Consultants in Planning, Engineering, Architecture,
Construction Management, and Related Services
655 Bermuda Road
Las Vegas, NV 89119
702) 938-5400 Fax (702) 938-5454

No.	Date	BY	REVISION
-----	------	----	----------