
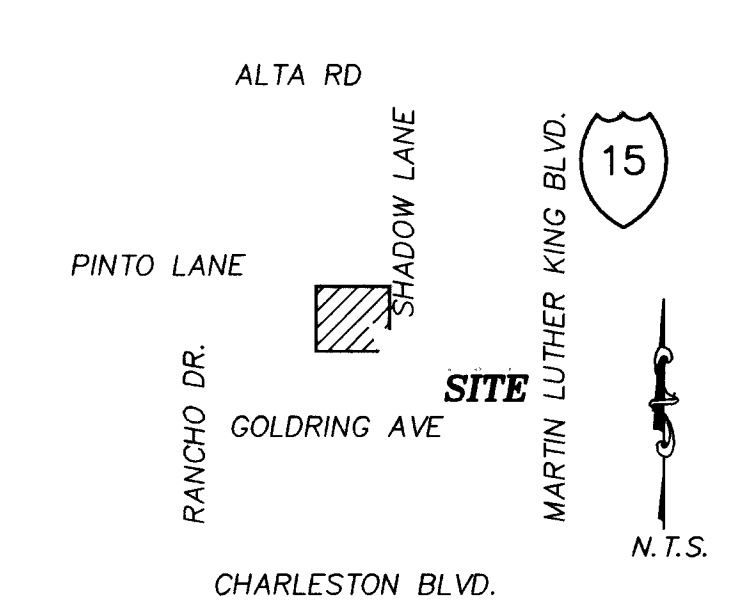
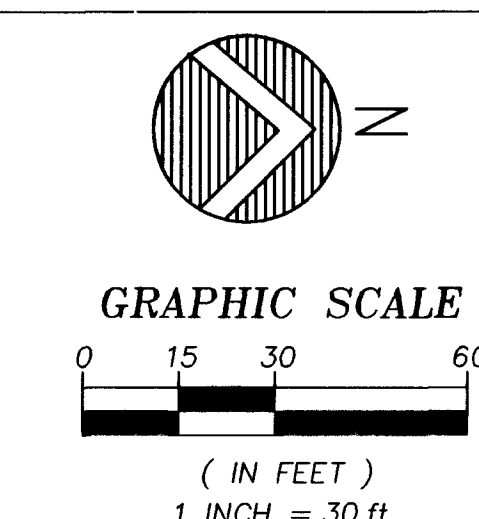


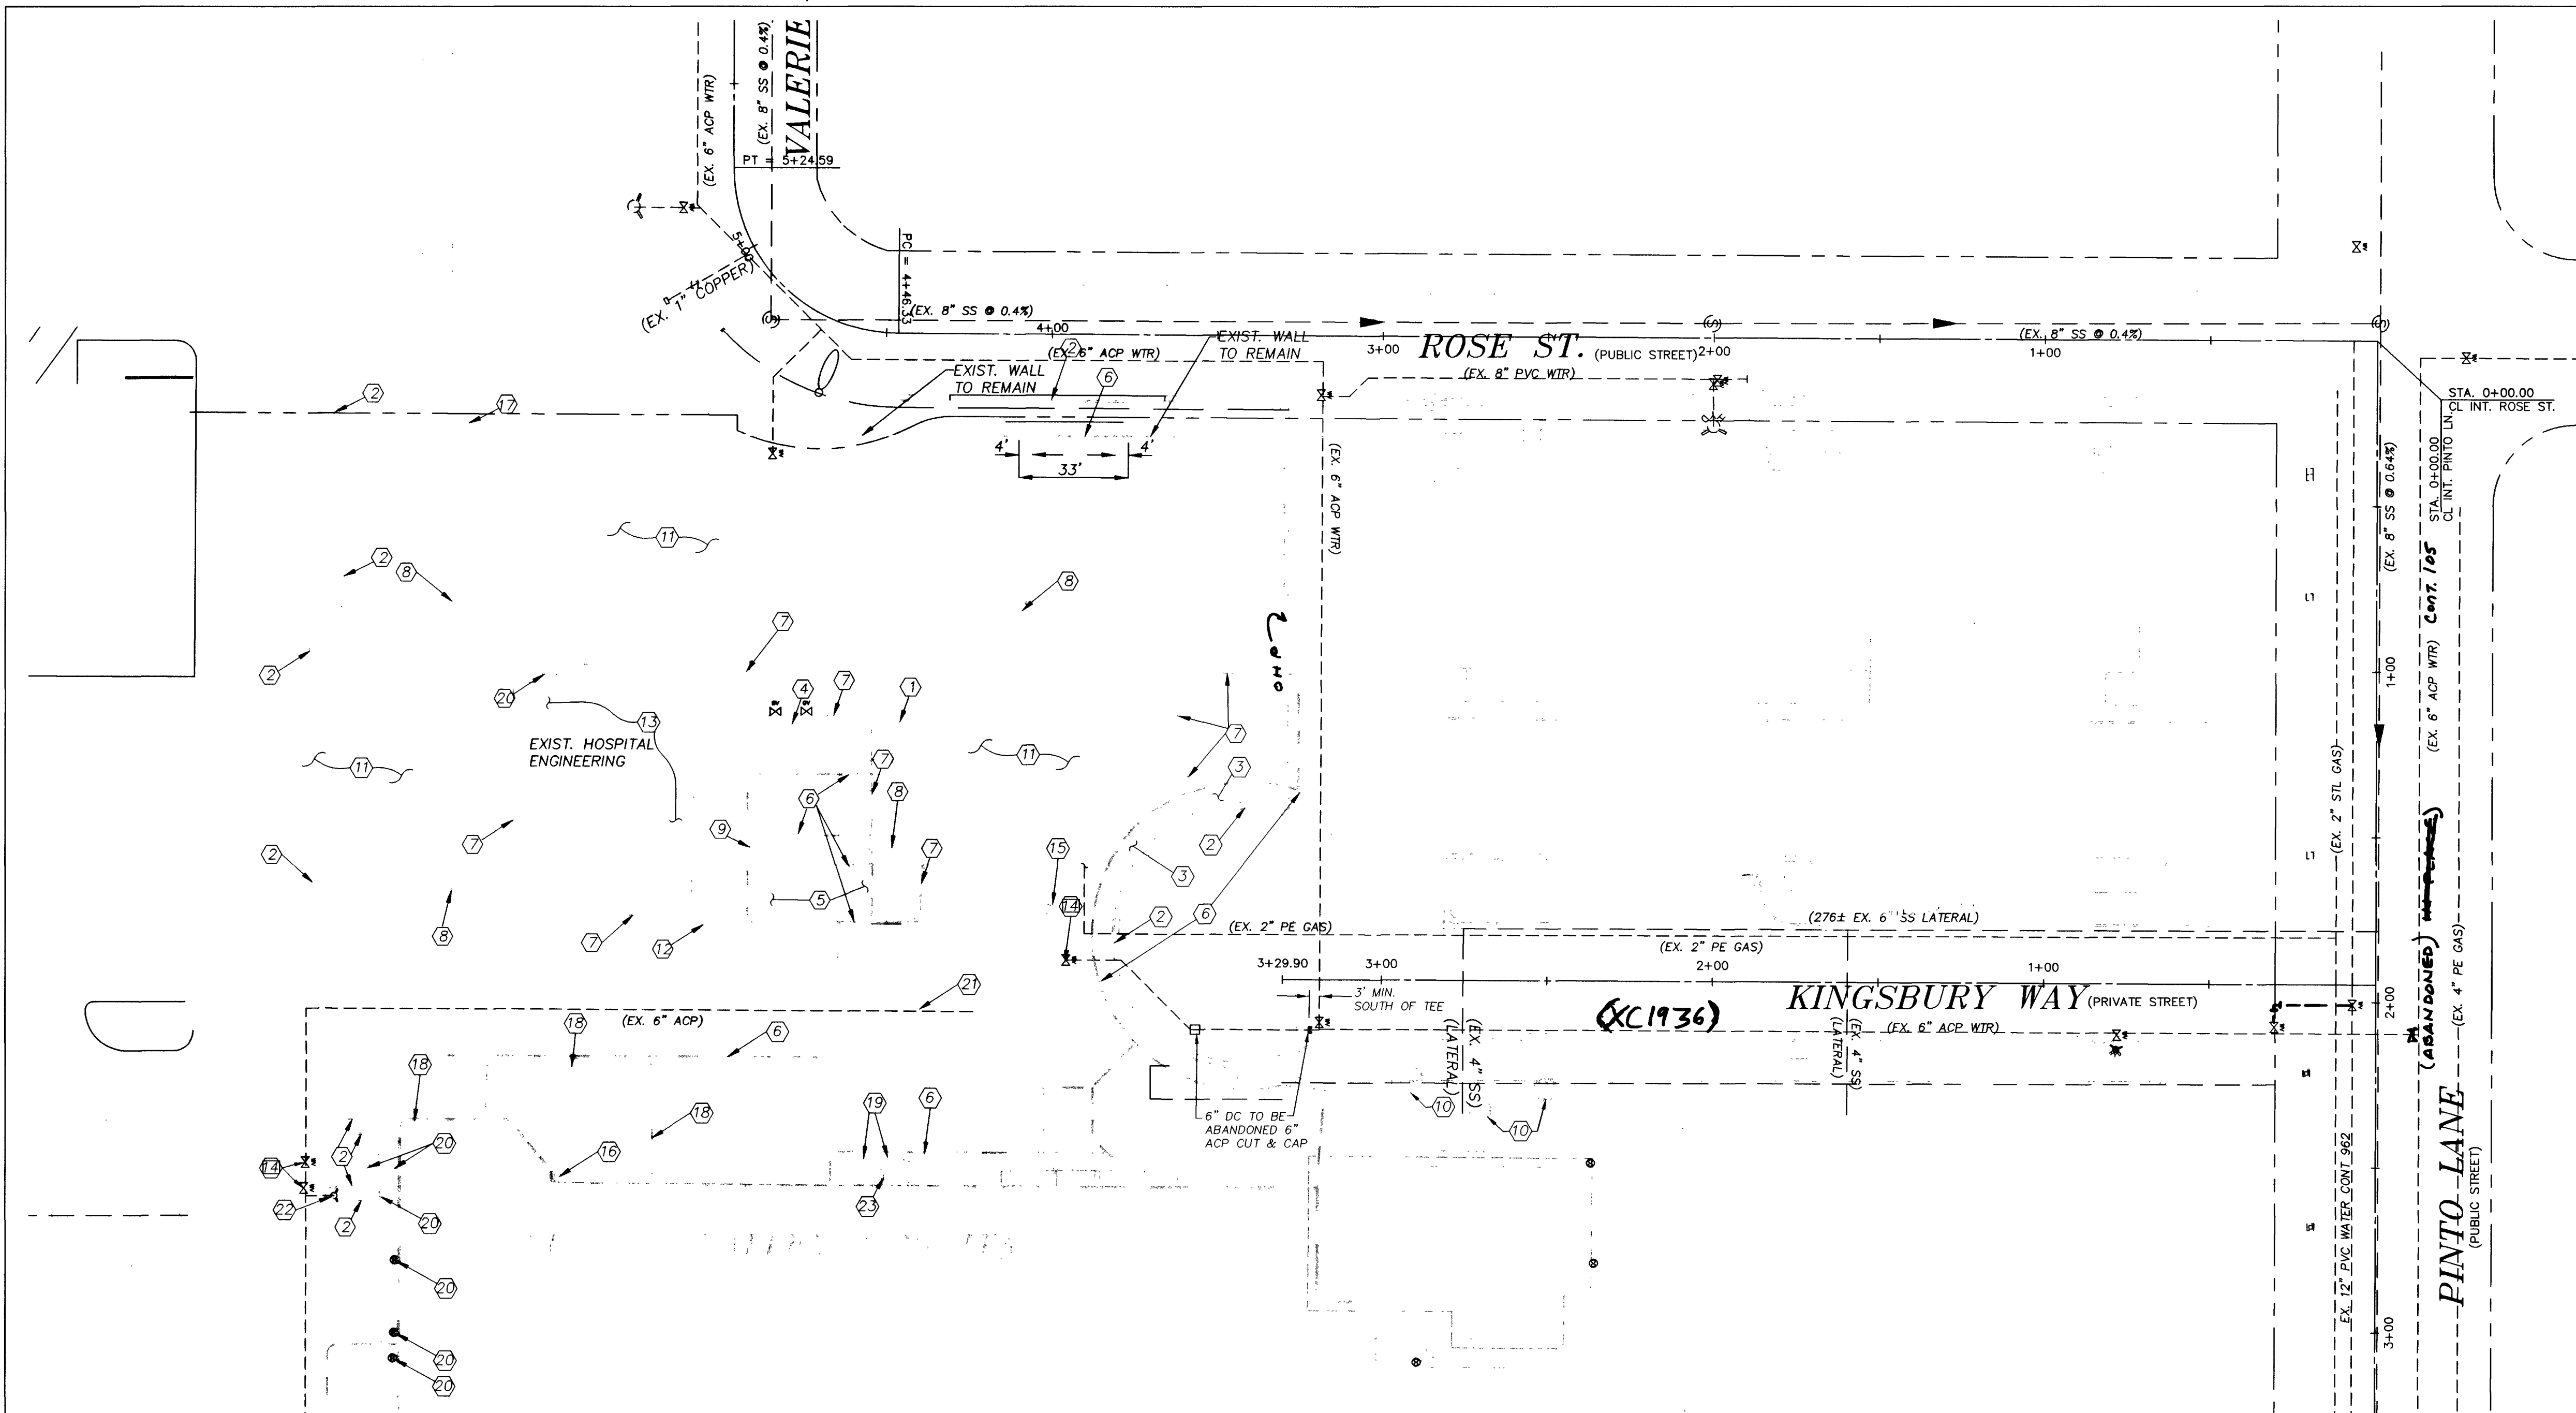

LOCATION MAP

BASIS OF BEARING

SOUTH 89°51'00" EAST, BEING THE CENTER LINE OF PINTO LANE AS SHOWN PER PARCEL MAP FILE 5, PAGE 7. CLARK COUNTY OFFICIAL RECORDS.

BENCHMARK

RIVET AND PLATE IN TOP OF CURB @ THE SOUTHEAST CORNER OF ALTA DRIVE AND SHADOW LANE.
BENCHMARK#: 0LV01.33W6
625.7337 METERS OR 2052.93 FEET.
CONVERSION TO SITE BENCHMARK IS: BENCHMARK + .20'

DEMOLITION NOTESS

- ① EXIST. GREASE TRAP TO BE REMOVED. SEE UTILITY NOTES ON THIS SHEET.
- ② EXIST. CURB TO BE REMOVED
- ③ EXIST. SIDEWALK TO BE REMOVED
- ④ EXIST. TANK TO BE REMOVED. SEE UTILITY NOTES ON THIS SHEET.
- ⑤ EXIST. CONCRETE SLAB TO BE REMOVED
- ⑥ EXIST. WALLS TO BE REMOVED
- ⑦ EXIST. FENCE TO BE REMOVED
- ⑧ EXIST. EXTERIOR LIGHTS TO BE REMOVED. SEE ELECTRICAL PLANS. SEE UTILITY NOTES ON THIS SHEET.
- ⑨ EXIST. TREES TO BE REMOVED
- ⑩ EXIST. TREE TO REMAIN, PROTECT IN PLACE.
- ⑪ EXIST. ASPHALT TO BE REMOVED AND REPLACED
- ⑫ EXIST. WATER VALVE TO BE REMOVED. SEE UTILITY NOTES ON THIS SHEET.
- ⑬ EXIST. BUILDING AND FOUNDATION TO BE REMOVED
- ⑭ EXIST. VALVE TO REMAIN, PROTECT IN PLACE. SEE UTILITY NOTES ON THIS SHEET.
- ⑮ REMOVE EXIST. FIRE HYDRANT PER UTILITY PLAN. SEE UTILITY NOTES ON THIS SHEET.
- ⑯ EXIST. PUMP DRIVEN DRAIN INLET TO BE REMOVED
- ⑰ EXIST. ELECTRICAL VAULTS TO REMAIN, PROTECT IN PLACE
- ⑱ EXIST. BUILDING OVERHANG AND SUPPORTS TO BE REMOVED.
- ⑲ EXIST. CONCRETE STEPS AND RAMP TO BE REMOVED.
- ⑳ EXIST. SEWER CLEANOUTS TO REMAIN, PROTECT IN PLACE. SEE UTILITY NOTES ON THIS SHEET.
- ㉑ EXIST. 6" WATER LINE TO BE RELOCATED BY CONTRACTOR. SEE UTILITY NOTES ON THIS SHEET.
- ㉒ EXIST. FIRE HYDRANT TO REMAIN, PROTECT IN PLACE. SEE UTILITY NOTES ON THIS SHEET.
- ㉓ EXIST. 8" PIPE TO BE IDENTIFIED AND REMOVED/RELOCATED BY CONTRACTOR. SEE UTILITY NOTES ON THIS SHEET.

UTILITY NOTE

CONTRACTOR TO PROVIDE UTILITY LOCATIONS AND UTILITY AS-BUILT PLAN. THE PLAN SHALL BE REVIEWED WITH OWNER AND OWNER'S REPRESENTATIVE PRIOR TO ANY COMMENCEMENT OF ANY CONSTRUCTION ACTIVITIES.

NOTE

DEMOLITION CONTRACTOR TO REMOVE EXISTING INCINERATOR, OXYGEN PAD, ENGINEERING BUILDING, COLD WATER LINES, HOSE BIBS, AREA DRAINS AND GREASE INTERCEPTOR BACK TO UTILITY CONNECTIONS AND CAP ALL UTILITY LINES AS REQUIRED. REFER TO CLV PROJECT # L-4170-02 FOR RELOCATION AND ABANDONMENT OF EXISTING OXYGEN YARD.

ABANDONMENT OF VAULT STRUCTURES

THE CONTRACTOR WILL REMOVE THE TOP OF THE EXISTING VAULT AND REMOVE THE EXISTING WATER FACILITIES. THE OLD VAULT MAY BE ABANDONED IN PLACE BY CUTTING AND CAPPING WATER LATERALS AS SHOWN ON DRAWING AND BACKFILLING ACCORDING TO THE AGENCY HAVING JURISDICTION.
Return 6" DC to LVVWD

APPROVED FOR CONSTRUCTION

LAS VEGAS VALLEY WATER DISTRICT DATE

NOTE: CONTRACTOR TO VERIFY UTILITY STUB LOCATIONS AND SIZE WITH PLUMBING PLANS PRIOR TO INSTALLATION OF NEW UTILITIES.

NOTICE: POINT OF CONNECTION
CONTRACTOR SHALL NOTIFY ENGINEER PRIOR TO CONSTRUCTION ACTIVITIES AND CONSTRUCTION OF SANITARY SEWER AND SEWER LATERALS OF ALL INVERT ELEVATIONS. ONCE INVERT INFORMATION IS RECEIVED, THE SLOPE AND INVERTS WILL BE REVISED ACCORDINGLY. IF THE CONTRACTOR DOES NOT PROVIDE THE INFORMATION, THE ENGINEER WILL NOT BE RESPONSIBLE FOR THE SANITARY SEWER DESIGN.

NOTE
CIVILWORKS, INC. ASSUMES NO RESPONSIBILITY FOR EXISTING UTILITY LOCATIONS AND/OR ELEVATIONS. THE UTILITIES SHOWN ON THIS DRAWING HAVE BEEN PLOTTED FROM AVAILABLE INFORMATION. IT IS, HOWEVER, THE CONTRACTOR'S RESPONSIBILITY TO FIELD VERIFY THE LOCATION OF ALL UTILITIES AND SITE ELEVATIONS PRIOR TO THE COMMENCEMENT OF ANY CONSTRUCTION. CONTRACTOR TO FIELD VERIFY ALL EXISTING SITE CONDITIONS PRIOR TO CONSTRUCTION. IF A CONFLICT EXISTS BETWEEN WHAT IS SHOWN ON THESE DRAWINGS AND WHAT EXISTS IN THE FIELD, THE CONTRACTOR IS TO NOTIFY THE ENGINEER, THE ARCHITECT, AND/OR THE OWNER IMMEDIATELY AND PRIOR TO THE COMMENCEMENT OF ANY WORK.

NOTICE TO CONTRACTOR !
EXISTING UTILITY LOCATIONS SHOWN HEREON ARE APPROXIMATE ONLY. IT SHALL BE THE CONTRACTOR'S RESPONSIBILITY TO DETERMINE THE EXACT VERTICAL AND HORIZONTAL LOCATION OF ALL EXISTING UNDERGROUND UTILITIES PRIOR TO COMMENCING CONSTRUCTION. NO REPRESENTATION IS MADE THAT ALL EXISTING UTILITIES ARE SHOWN HEREON. THE ENGINEER ASSUMES NO RESPONSIBILITY FOR UTILITIES NOT SHOWN OR UTILITIES NOT SHOWN IN THEIR PROPER LOCATION.
AVOID CUTTING UNDERGROUND UTILITIES. IT'S COSTLY.
CALL before you dig
1-800-227-2600 UNDERGROUND SERVICE (USA)
AVOID OVERHEAD POWER LINE CONTACT.
CALL before you OVERHEAD
1-702-593-6111 NEVADA POWER ENVIRONMENT AND SAFETY SERVICES DEPT.

Civilworks
Engineering with "sensible" solutions tailored to your "specific" needs.
7625 S. Industrial Rd., Suite #101 • Las Vegas, NV • 89139
Office #: (702) 876-3474 • Facsimile #: (702) 876-1323
ARCH: HKS, INC.

VALLEY HOSPITAL
EMERGENCY ROOM EXPANSION
UNIVERSAL HEALTH SERVICES
367 South Gulph Road
King of Prussia, PA 19406 PH: (800) 347-7750
CITY OF LAS VEGAS, NEVADA

DEMOLITION PLAN

PROJ. NO. 0127005-00
DATE 01/27/05
DESIGNER B.A. POTTS
CHECKER B.A. POTTS
REVISIONS:
DATE 01/27/05
BY B.A. POTTS
NO. 13121
STATE OF NEVADA
BRANDON A. POTTS
CIVIL
Exp: 12/31/05
PRINTS/REQUIRE ENGINEER'S SEAL & SIGN FOR PROOF OF VALIDITY
SHEET NO. **C-4** of 8