



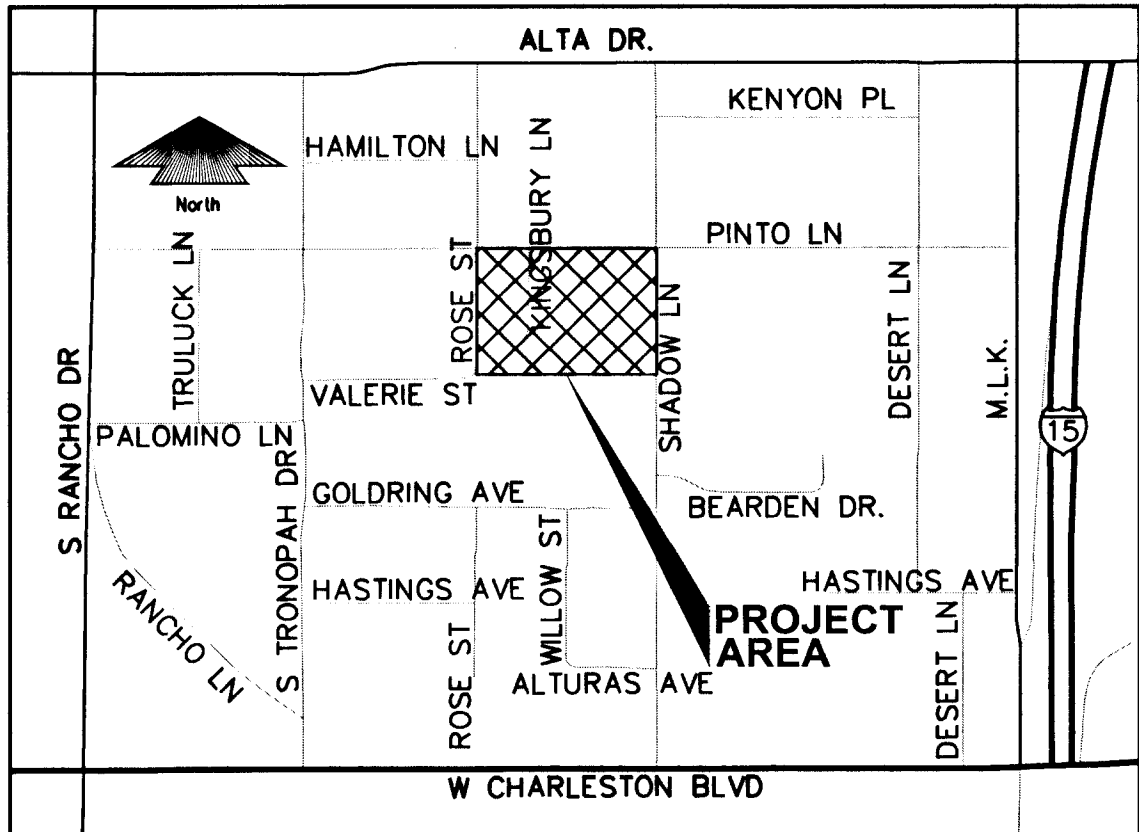

VICINITY MAP
N.T.S.

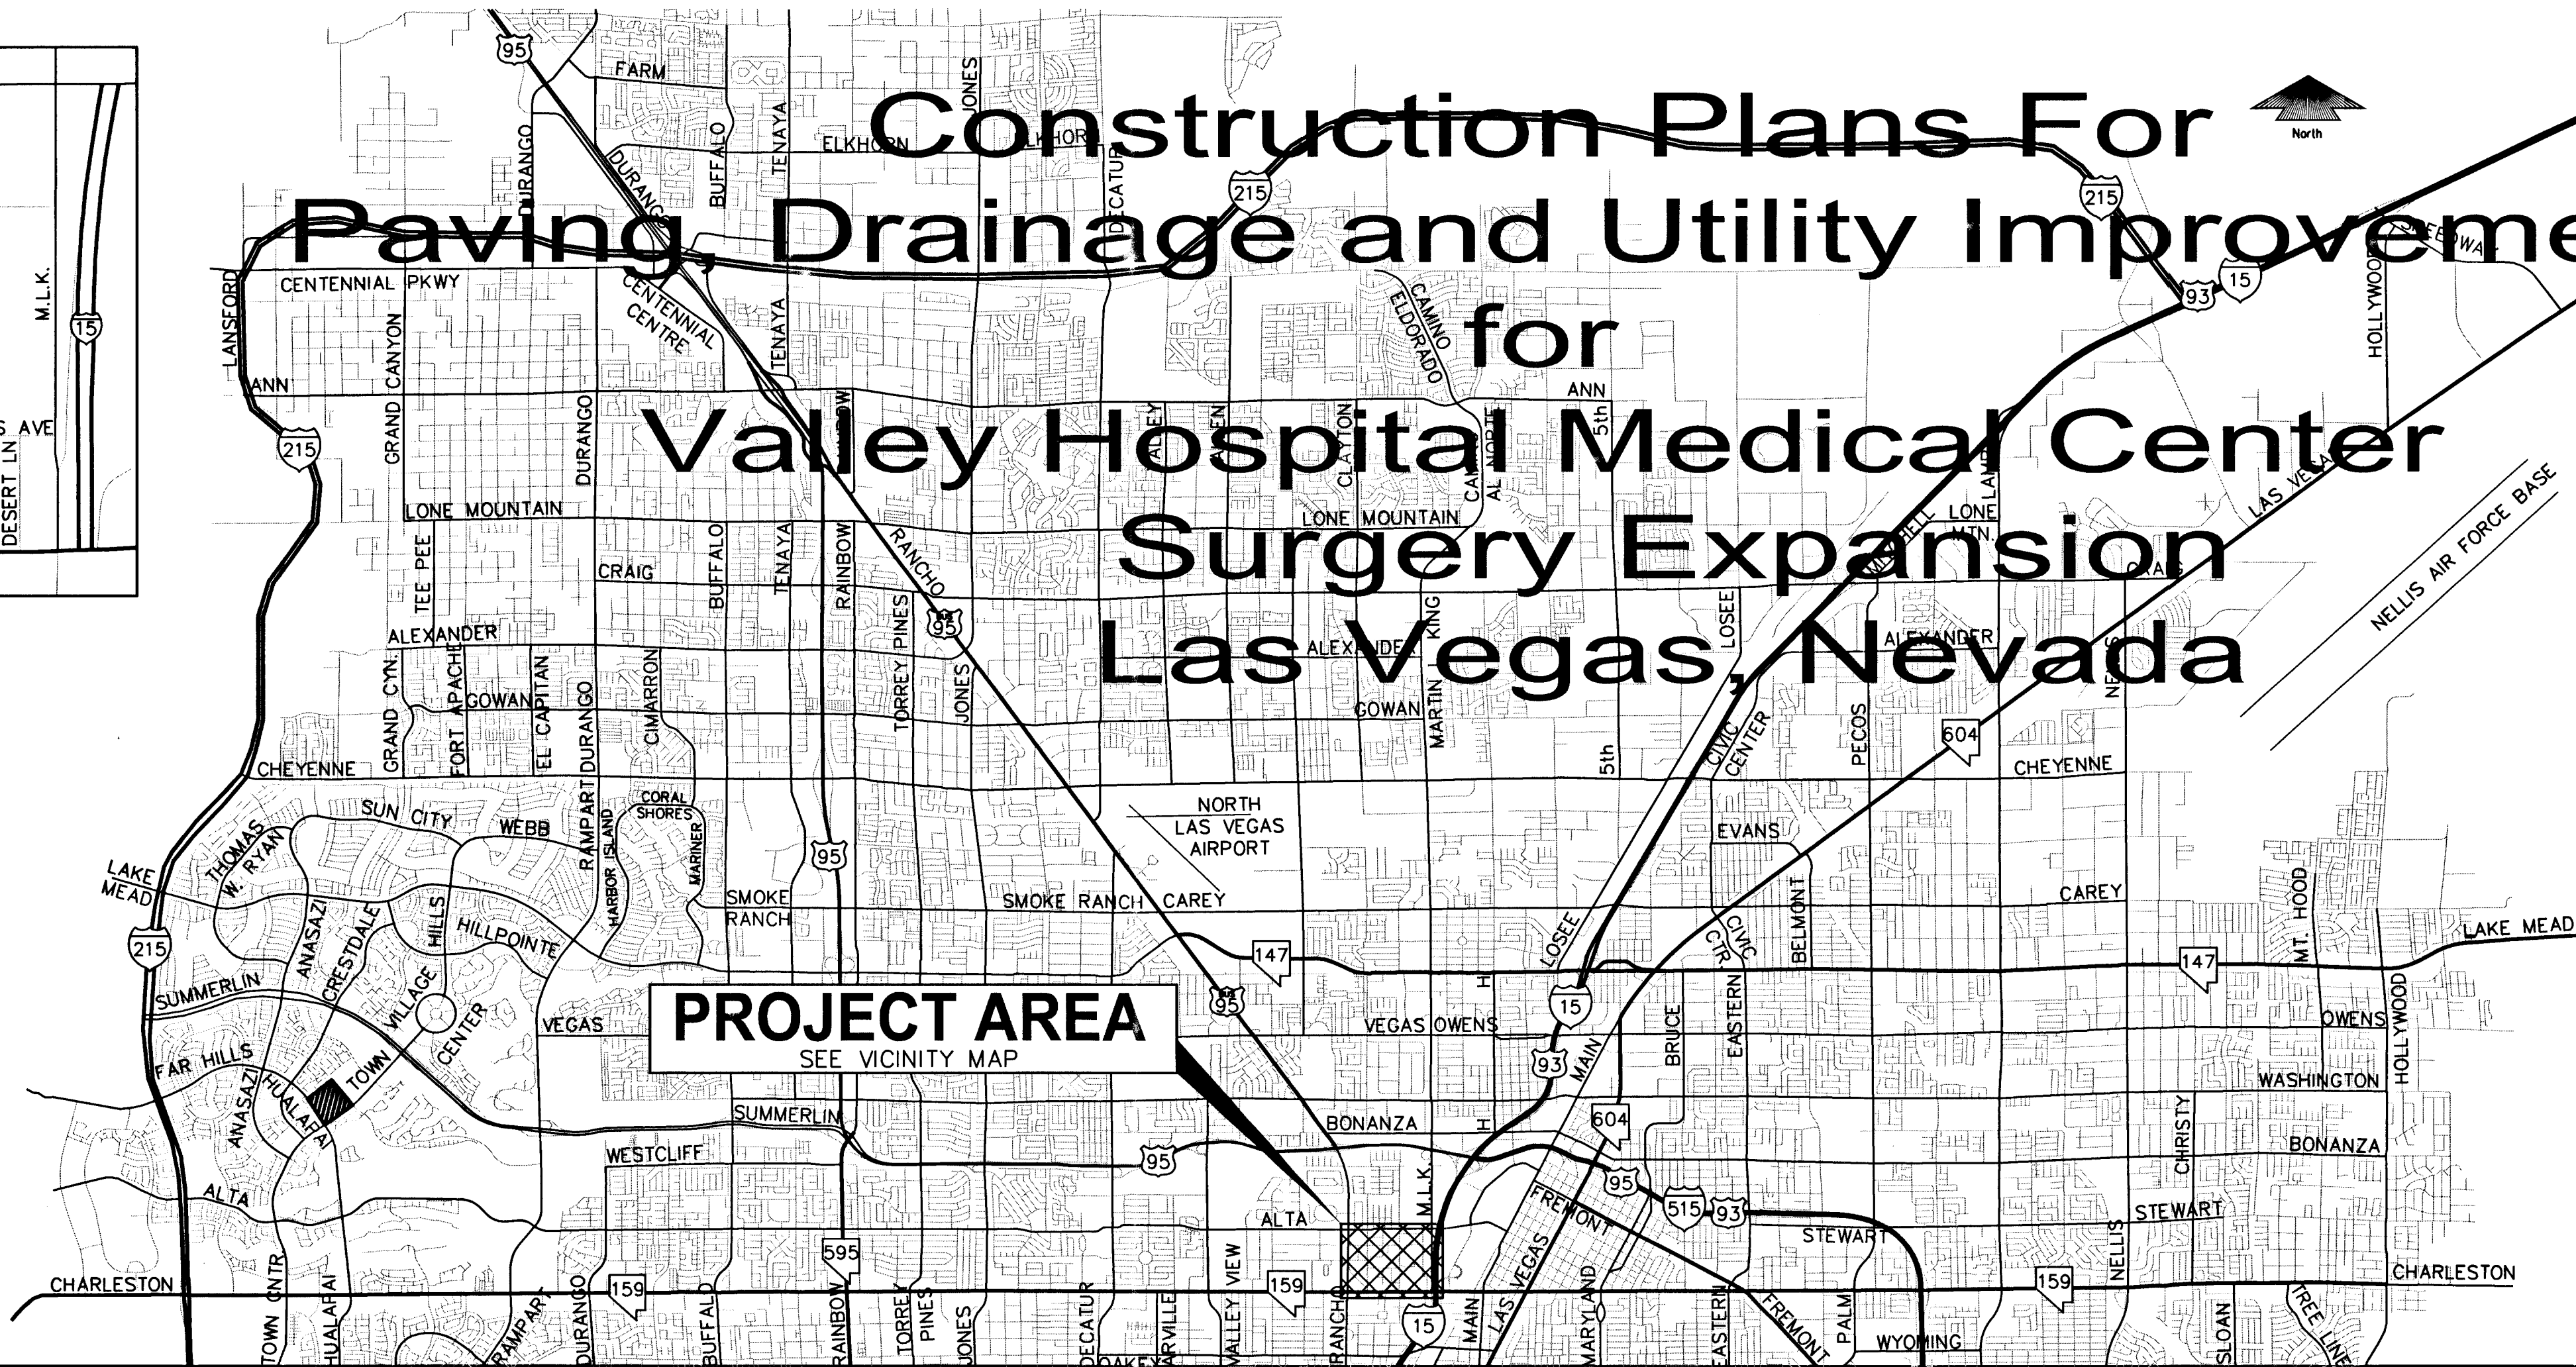

PROJECT AREA
SEE VICINITY MAP

Approvals:

Jorge Cervantes
Jorge Cervantes, PE No. 13977, P.O.E.
City Engineer
Date: 1-18-08

Approval of these plans is limited to those improvements constructed in the dedicated right-of-way and/or dedicated easements. This approval does not authorize the construction of any improvements that deviate from adopted standards and/or specifications, except those specifically listed under deviations from standard. The engineer shall resolve any deviation other than those listed in deviations from standards in favor of the Uniform Standards Drawings and Specifications, Clark County Area, Nevada.

Doug Rofkin
Doug Rofkin, AICP, Planning Manager
Date: 10-31-07

Note:
This plan meets the applicable standards of the Planning and Development Department.

City Engineer
City Engineer
Date: 10-31-07

N/A
N/A
Date: 10-31-07

Nevada Power Company
Nevada Power Company
Date: 10-31-07

Nevada power company acknowledges that we have received your plans and will provide service to all electrical needs associated with this project. Nevada power company reserves the right to address any existing or future conflicts once the final design is completed, the new service and the resolution of any conflicts will be accomplished pursuant to the Nevada public utility commission's rules and regulations.

David L. Whitman
Embargo Approval
Date: 10-31-07

The affixed embargo approval does not assume or guarantee liability for known or unknown conflicts with existing or proposed improvements. Resolution of any conflict will be accomplished pursuant to local ordinances, Nevada revised statutes and/or public utility commission rules and regulations.

Markelle Thompson
Cox Communications Of Las Vegas, Inc.
Date: 10/31/07


Kristen
Southwest Gas Corporation
Date: 11/5/07

Owner/Developer
UHS OF DELAWARE, INC
367 South Gulph Road
King Of Prussia, Pa 19406

HKS
Contact Person
Noel Barrick, AIA
HKS, Inc.
1919 McKinney Ave.
Dallas, Tx 75201

Civil Engineer
LOPEZGARCIA GROUP
1950 N. Stemmons Freeway, Suite 6000
Dallas, Tx 75207

ASSESSOR'S PARCEL NUMBER
139-33-303-024

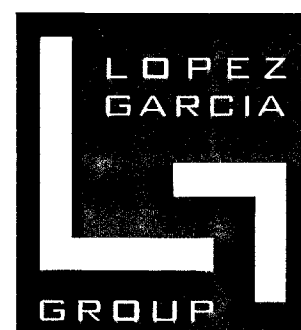

LEGEND	CL OR SURVEY LINE	EASEMENT LINE	HEAVY AC P.W.M.	MANHOLES & DESCRIPTIONS	CAP	DESCRIPTION	BO VALVE	CLEAN OUT	FDC FIRE HYDRANT	GATE VALVE	REDUCER	100% HPS STREETLIGHT	150% HPS STREETLIGHT	200% HPS STREETLIGHT	250% HPS STREETLIGHT	400% HPS STREETLIGHT	5' CONTOUR LINE	1' CONTOUR LINE	EDGE OF P.W.M.	SPOT ELEVATIONS	SIGNS
	PROPERTY LINE	SAWCUT LINE	LIGHT AC P.W.M.	● SANITARY SEWER		EXISTING:	●	●	●	●	●	●	●	●	●	●	---	---	---	(12.34)	---
	ROW LINE	SCARP LINE	CONC. P.W.M.	● STORM DRAIN		PROPOSED:	●	●	●	●	●	●	●	●	●	●	---	---	---	12.34 BC	---
				● ELECTRICAL																	
				● TELEPHONE																	

ABBREVIATIONS:

AND	HPS	HIGH PRESSURE SODIUM
AT	ID	INSIDE DIAMETER
DIAMETER OR ROUND NUMBER	INV	INVERT
AC	IRR	IRRIGATION
ADJ	LAT	LATERAL
ADJUST	LF	LINEAL FEET
AGG	LP	LOW POINT
AGGREGATE	LS	LANDSCAPE
ALT	LT	LEFT
ALTERNATE	LVWD	LAS VEGAS VALLEY WATER DISTRICT
AVE		
BACK OF CURB		
BOR		
BOUNDARY		
BEG		
BENCHMARK		
BLOWOFF		
BSW		
BETWEEN		
BEGINNING OF VERTICAL CURVE		
CATV		
CABLE TV		
CURB AND GUTTER		
CAST IRON PIPE		
CENTERLINE		
CORRUGATED METAL PIPE		
CONCRETE MASONRY UNIT		
CLEAN OUT		
CONC		
CONCRETE		
CONSTRUCT		
CITY OF BOULDER CITY		
CITY OF LAS VEGAS		
CITY OF NORTH LAS VEGAS		
CITY OF HENDERSON		
CITY OF MESQUITE		
CLARK COUNTY		
CLARK COUNTY AREA UNIFORM		
CLARK COUNTY SANITATION		
CLARK COUNTY REGIONAL FLOOD CONTROL DISTRICT		
DC		
DEPRESSED CURB		
STANDARDS FOR CONSTRUCTION		
STANDARDS FOR WASTEWATER COLLECTION SYSTEM		
DI		
DIAMETER		
DIP		
DUCTILE IRON PIPE		
DMH		
DOMESTIC		
D/W		
DRIVEWAY		
E		
ELECTRIC		
EAC		
EDGE OF AC		
EC		
END OF CURVE		
ECR		
END OF CURB RETURN		
ECD		
END DRIVEWAY		
EL		
ELEVATION		
EW		
ELECTRIC METER		
EOP		
EDGE OF PAVEMENT		
ESMT		
EASEMENT		
EW		
EACH WAY		
EX		
EXISTING		
FFC		
FIRE DEPARTMENT CONNECTION		
FG		
FINISH FLOOR		
FG		
FINISH GRADE		
FL		
FIRE HYDRANT		
FL		
FLOW LINE		
FDC		
FACE OF CURB		
FSR		
FINISHED SURFACE		
FIRE SPRINKLER RISER		
G		
GALV		
GALVANIZED		
GB		
GRADE BREAK		
GRM		
GALLONS PER MINUTE		
GR		
GRATE		
H		
HIGH OR HEIGHT		
HDPE		
HIGH DENSITY POLYETHYLENE		
HERCP		
HORIZONTAL ELLIPTICAL		
HP		
HORIZONTAL		
HIGH POINT		
UG		
UNDERGROUND		
VC		
VERTICAL CURVE		
VCP		
VERTIFIED CLAY PIPE		
VERT		
VERTICAL		
VG		
VALLEY GUTTER		
VVWD		
VALLEY VALLEY WATER DISTRICT		
WL		
WATER LINE		
WM		
WATER METER		
W		
WITH		
W/O		
WITHOUT		

BASIS OF BEARINGS:

NORTH 89°54'49" WEST, BEING THE BEARING OF THE CENTERLINE OF PINTO LANE, AS SHOWN ON THAT CERTAIN MAP ON FILE IN THE CLARK COUNTY RECORDER'S OFFICE IN BOOK 123, PAGE 37 OF PLATS, SITUATE IN THE SOUTHWEST QUARTER (SW 1/4) OF SECTION 33, TOWNSHIP 20 SOUTH, RANGE 61 EAST, M.D.M., CITY OF LAS VEGAS, CLARK COUNTY, NEVADA.

BENCHMARK:

CITY OF LAS VEGAS BENCHMARK 1LV01 33SW6
RIVET AND PLATE IN TOP OF CURB AT THE SOUTHEAST CORNER OR SHADOW LANE AND PALMWOOD

ELEVATION = 626.313 METERS, 2054.83 FEET (NAVD 88)



CLIENT
UHS OF DELAWARE, INC
367 SOUTH GULPH ROAD
KING OF PRUSSIA, PA 19406

ARCHITECT
HKS ARCHITECTS, INC.
1919 MCKINNEY AVENUE
DALLAS, TX 75201

STRUCTURAL ENGINEER
HKS ARCHITECTS, INC.
1919 MCKINNEY AVENUE
DALLAS, TX 75201-1753

MEP ENGINEER
CORD PARTNERS
3625 N. HALL ST., SUITE 1300 LB 13
DALLAS, TX 75219

DESIGN CONSULTANT
DESIGN STUDIO, INC.
161 LEVERINGTON AVENUE
PHILADELPHIA, PA 19127


CIVIL ENGINEER
LOPEZGARCIA GROUP
1825 MARKET CENTER, SUITE 500
DALLAS, TX 75207

LANDSCAPE ARCHITECT
JW ZUNINO AND ASSOCIATES
3191 S JONES BLVD
LAS VEGAS, NV 89146




VALLEY HOSPITAL
MEDICAL CENTER
LAS VEGAS, NEVADA

**SURGERY
EXPANSION**

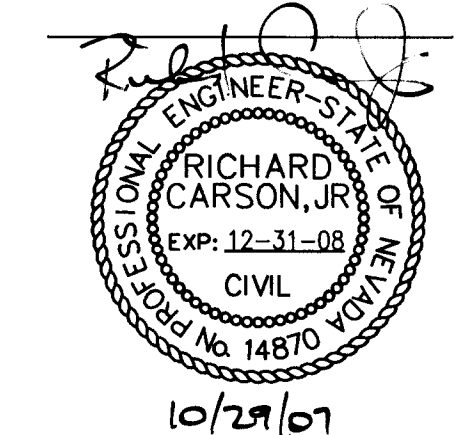

KEY PLAN

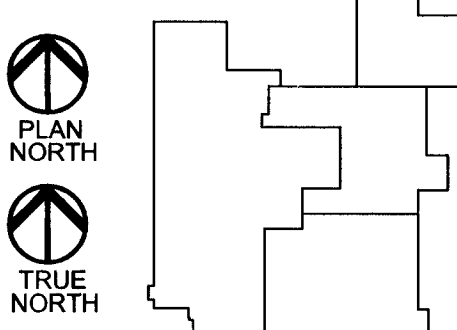

REVISION

HKS PROJECT NUMBER

07141.005

DATE

9 OCTOBER 2007

ISSUE

CONSTRUCTION

DOCUMENTS

SHEET TITLE

COVER SHEET

C0.0
SHEET NO. 1 OF 21

107V1092-EX

© 2007 HKS ARCHITECTS INC.