


Avoid cutting underground utility lines. It's costly.
Call before you Dig.
 1-800-227-2600
 UNDERGROUND SERVICE ALERT (USA)

SAFETY ALERT
Call before you Overhead
 593-6111
 OVERHEAD SERVICE ALERT

BASIS OF BEARING
 S 00° 05' 17" W BEING THE CENTERLINE OF VALLEY VIEW BLVD. AS SHOWN ON SPANISH OAKS 8 IN BOOK 22 PAGE 25 OF PLATS IN THE CLARK COUNTY RECORDERS OFFICE.

BENCH MARK
 B.M. 7C11555W6 RIVET AND PLATE IN TOP OF CURB NORTHEAST RETURN SAHARA AND SPANISH OAKS ELEV. 2131.809 NAVD 88

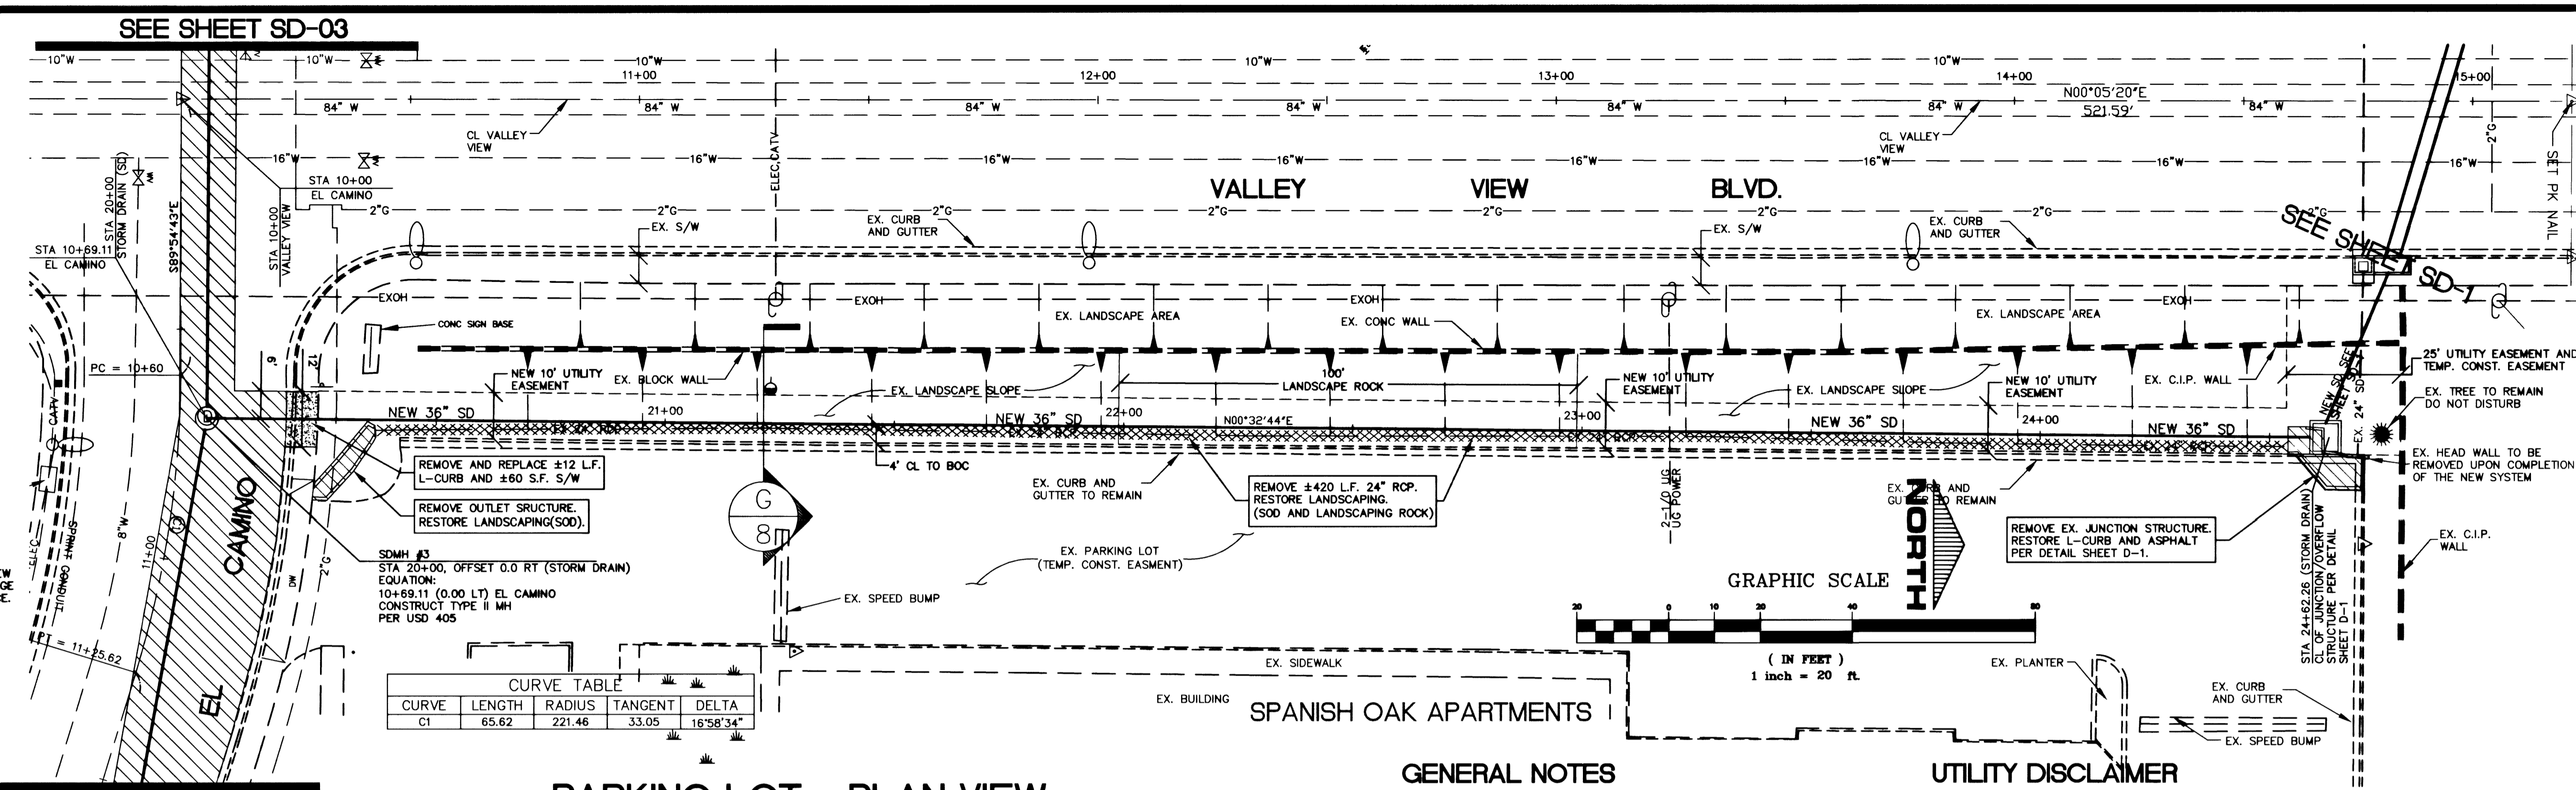

PARKING LOT - PLAN VIEW

HORIZ. SCALE: 1"=20'
 VERT. SCALE: -

APPROVED BY


 LAS VEGAS VALLEY WATER DISTRICT
 DATE: 1-21-00

GENERAL NOTES

- PIPE LENGTHS AND SLOPES ARE CALCULATED FROM CENTER OF MH TO CENTER OF MH OR TO INSIDE FRONT FACE OF DI.
- DEPTH D FOR DROP INLETS (DI) IS AS DEFINED IN APPROPRIATE U.S.D. No.

UTILITY DISCLAIMER

UTILITY LOCATIONS SHOWN HEREON ARE APPROXIMATE ONLY. IT SHALL BE THE CONTRACTOR'S RESPONSIBILITY TO DETERMINE THE EXACT VERTICAL AND HORIZONTAL LOCATION OF ALL EXISTING UNDERGROUND UTILITIES PRIOR TO COMMENCING CONSTRUCTION. NO REPRESENTATION IS MADE THAT ALL EXISTING UTILITIES ARE SHOWN HEREON. THE ENGINEER AND THE CITY OF LAS VEGAS ASSUMES NO RESPONSIBILITY FOR UTILITIES NOT SHOWN OR UTILITIES NOT SHOWN IN THEIR PROPER LOCATION.

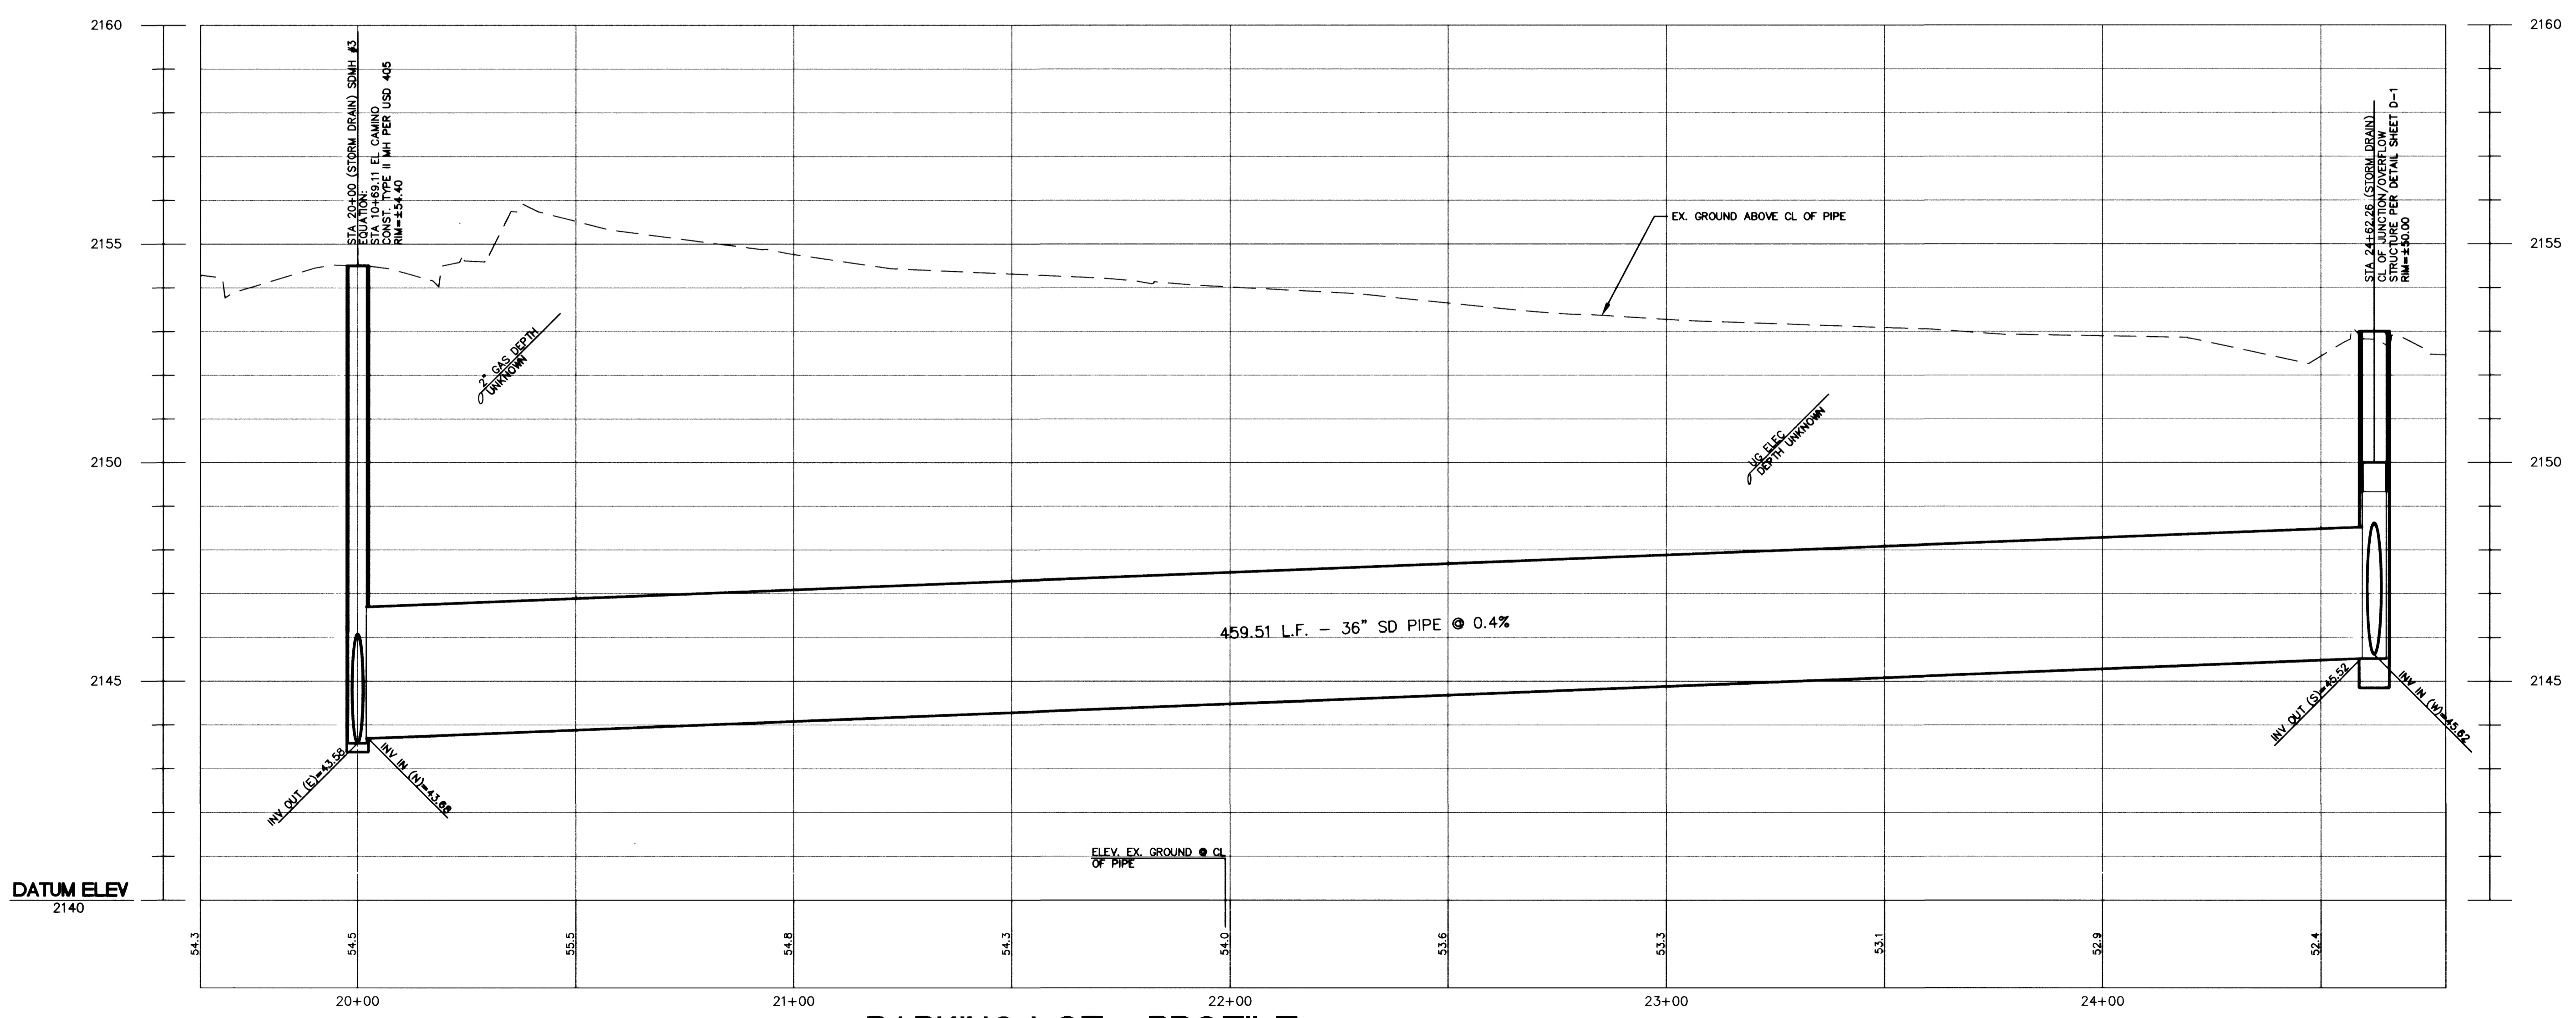

PARKING LOT - PROFILE

HORIZ. SCALE: 1"=20'
 VERT. SCALE: 1"=2'

DEPARTMENT OF PUBLIC WORKS
 ENGINEERING DESIGN SECTION

CITY ENGINEER: JERRY WALKER, P.E. (ACTING)
 PROJECT MANAGER: ED NETTENSTROM, P.E.
 DESIGNED BY: MAS
 DRAWN BY: MAS/ESM
 CHECKED BY: [Signature]
 DATE: 1/1/00

TITLE: VALLEY VIEW STORM DRAIN
 PHASE 1 - UPPER SYSTEM
 PLAN AND PROFILE
 STATION 10+00 TO 15+00

Sheet SD-2
 4 of 9
 DRAWING NO. 327-V259
 BID# 00.1730.21

25742