
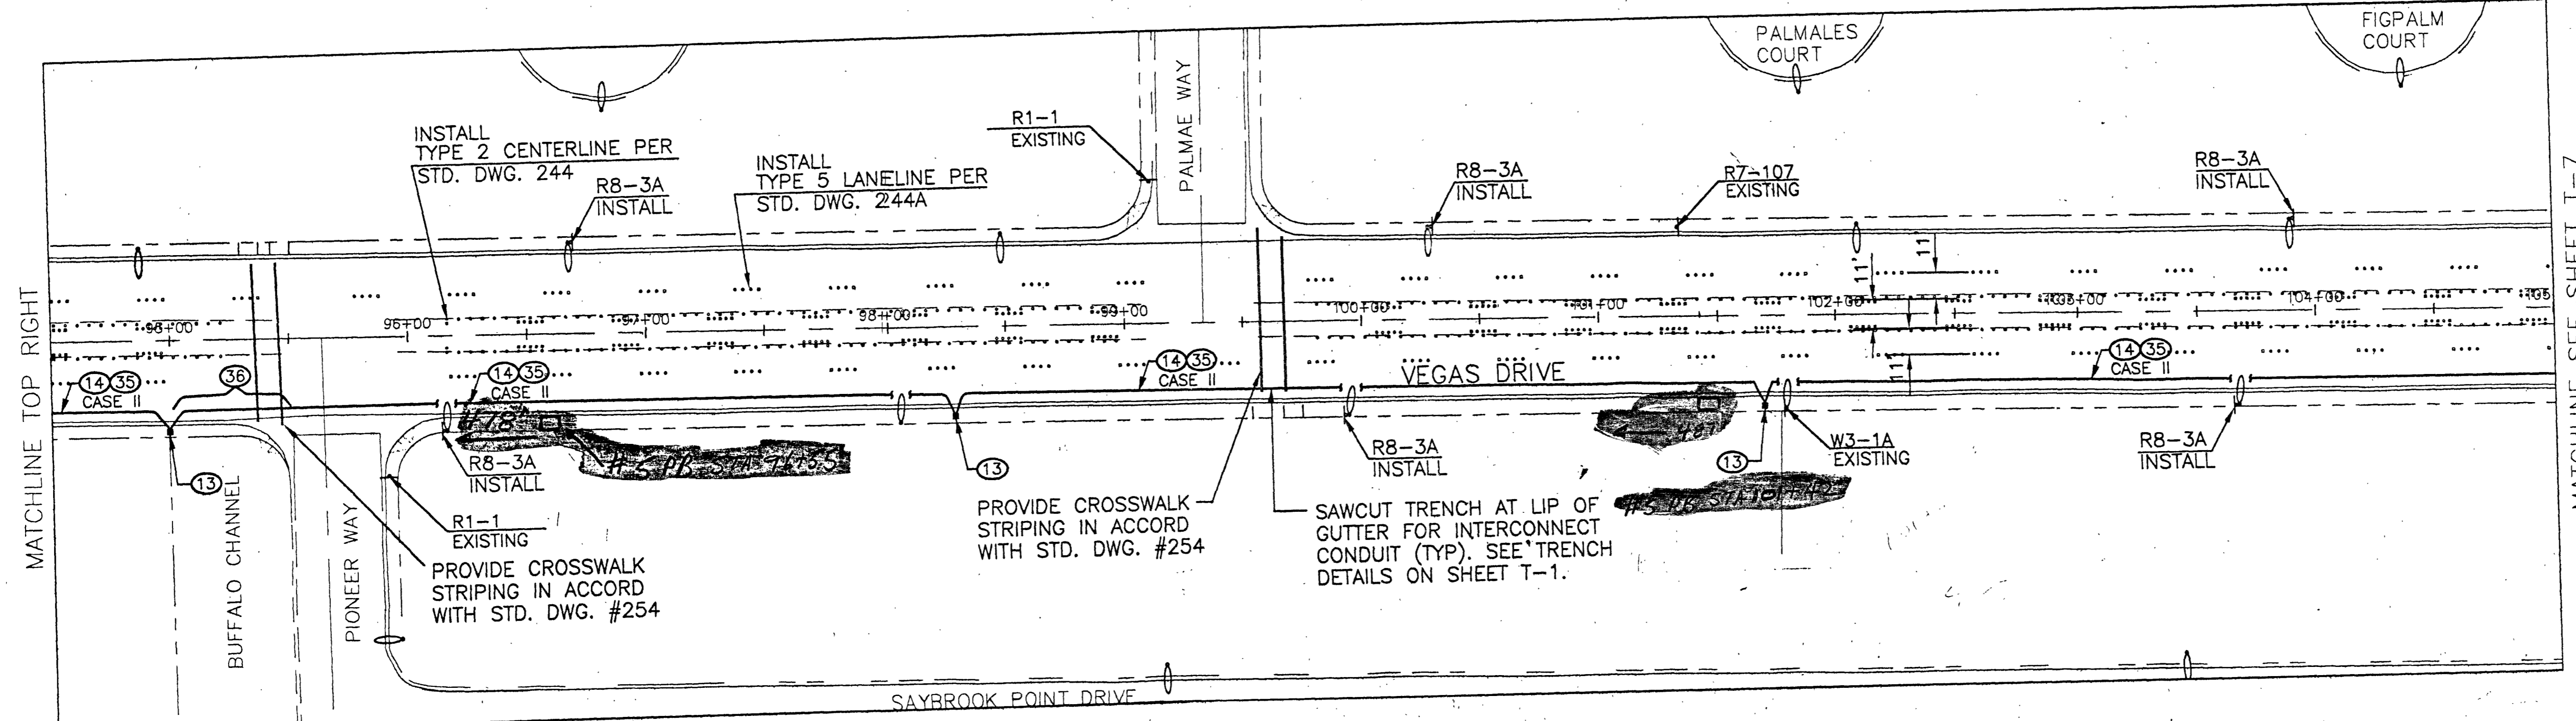


NOTES: 1. REFER TO STD. DWG. NO. 247 FOR MARKER AND REFLECTOR TYPES.
 2. SEE SHEET T-1 FOR STREETLIGHTING CONSTRUCTION NOTES.

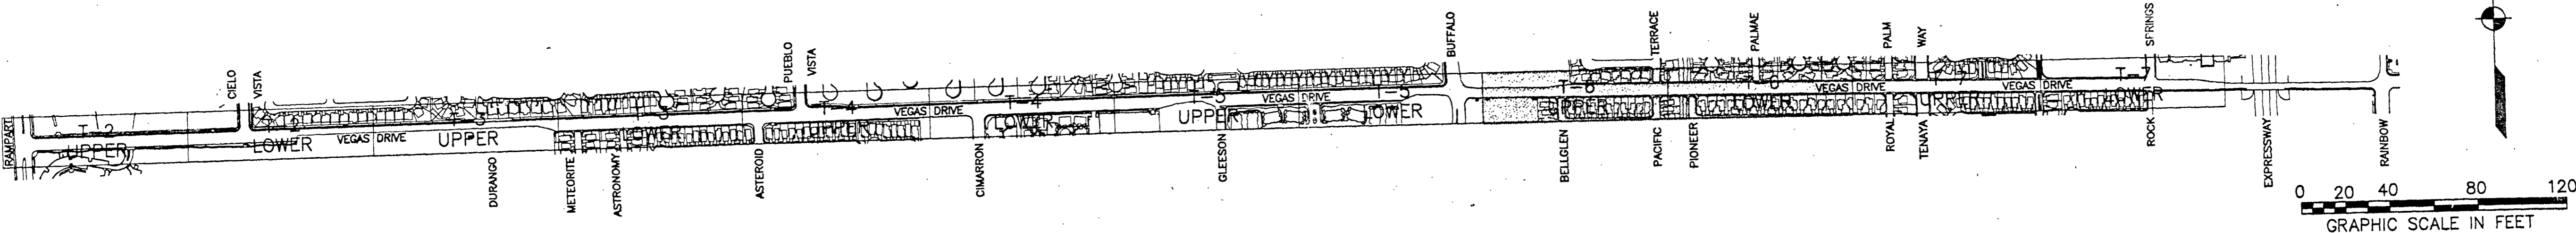

NOTES: 1. REFER TO STD. DWG. NO. 247 FOR MARKER AND REFLECTOR TYPES.
 2. SEE SHEET T-1 FOR STREETLIGHTING CONSTRUCTION NOTES.

Avoid cutting underground utility lines. It's costly.
Call before you Dig.
 1-800-227-2600
 UNDERGROUND SERVICE ALERT (USA)

REGISTERED PROFESSIONAL ENGINEER STATE OF NEVADA
 WILLIAM J. COLEMAN
 CIVIL
 No. 4923 NOVEMBER 30, 1997

REGISTERED PROFESSIONAL ENGINEER STATE OF NEVADA
 THOMAS J. KROB
 ELECTRICAL
 No. 6361 NOVEMBER 30, 1997

9/14/97

STREET LIGHTING

USE OF DOCUMENTS		DATE	BY
THIS DOCUMENT, INCLUDING THE INCORPORATED DESIGNS, IS AN INSTRUMENT OF SERVICE FOR THIS PROJECT AND SHALL NOT BE USED FOR ANY OTHER PROJECT WITHOUT THE WRITTEN AUTHORIZATION OF KENNEDY/JENKS CONSULTANTS.			
DESIGNED	HW/DSN		
DRAWN	JDM/BJL		
CHECKED	TOM		
NO.	KROB		
Kennedy/Jenks Consultants 1455 E. Tropicana Avenue, Suite 300 Las Vegas, NV 89119 TJKROB CONSULTING ENGINEERS, INC. 1918 S. JONES BLVD., SUITE B LAS VEGAS, NV 89102 (702) 871-3271 ELECTRICAL ENGINEERING			
CITY OF LAS VEGAS NEVADA			
CITY OF LAS VEGAS - STREET IMPROVEMENTS VEGAS DRIVE - RAMPART TO ROCK SPRINGS STRIPING/LIGHTING PLAN FROM STA. 84+00 TO STA. 105+00			
6105/SIT-16	DWG. NO. 107-V2684	DATE 9-16-97	SHEET 43 OF 50
			T-6

47654