

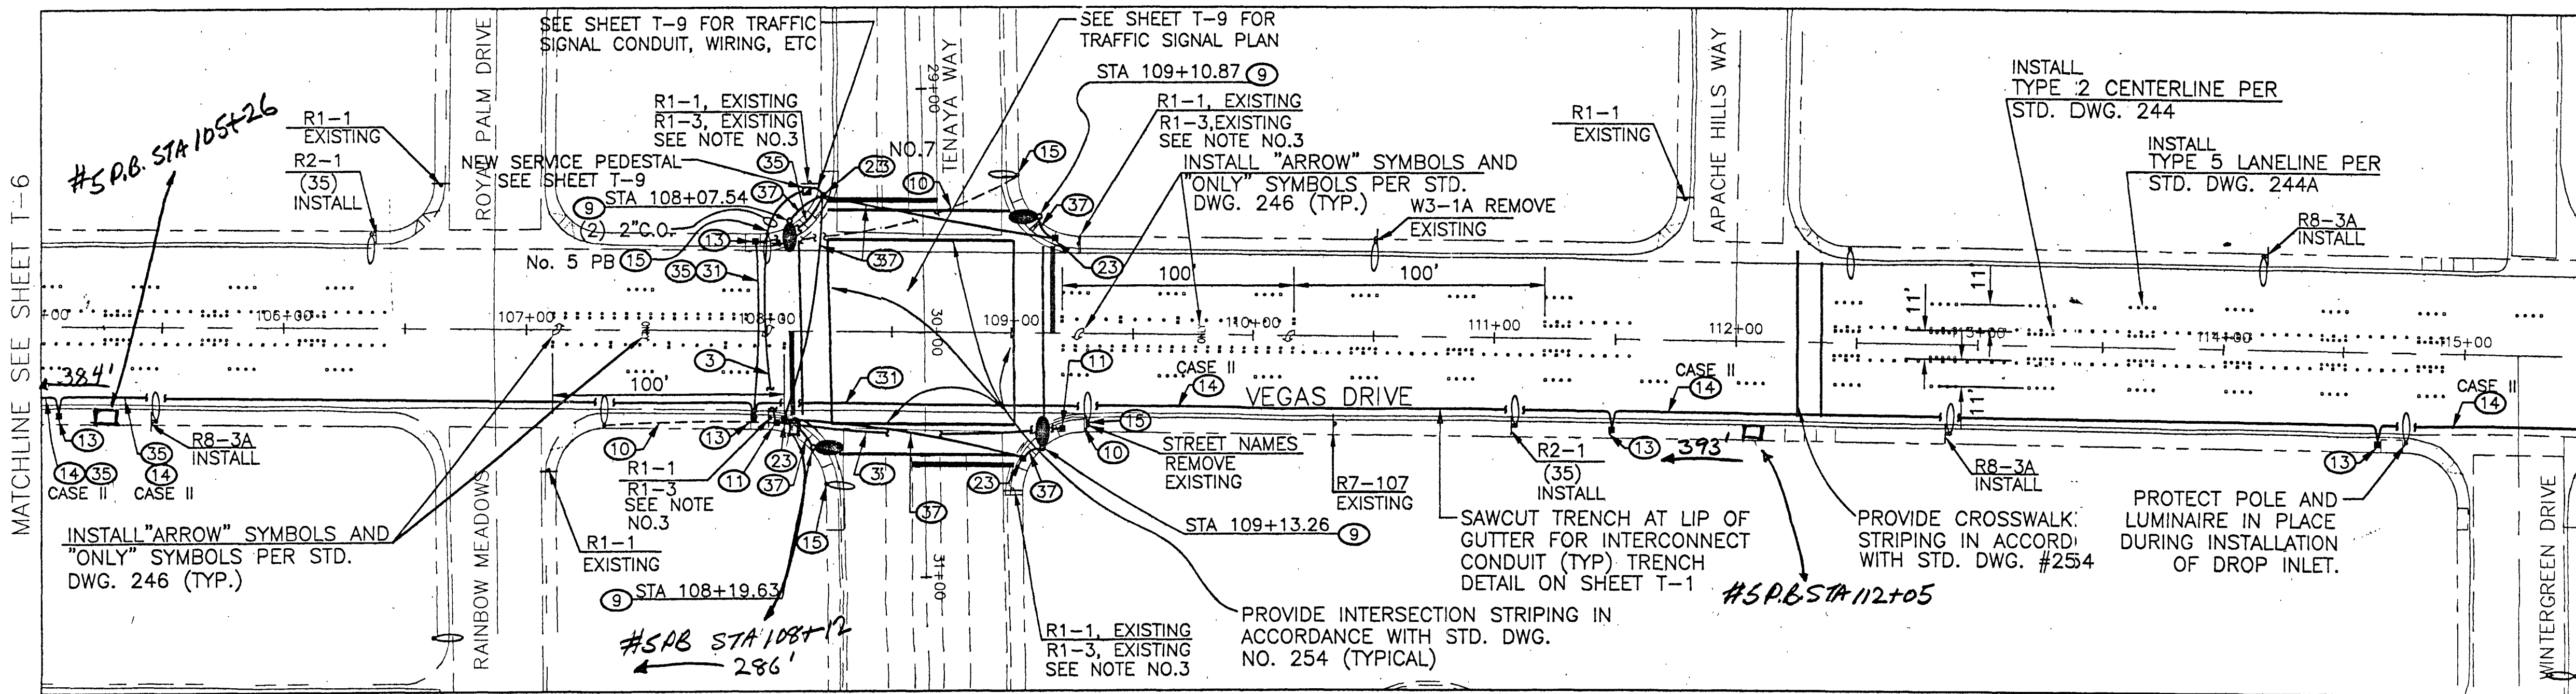


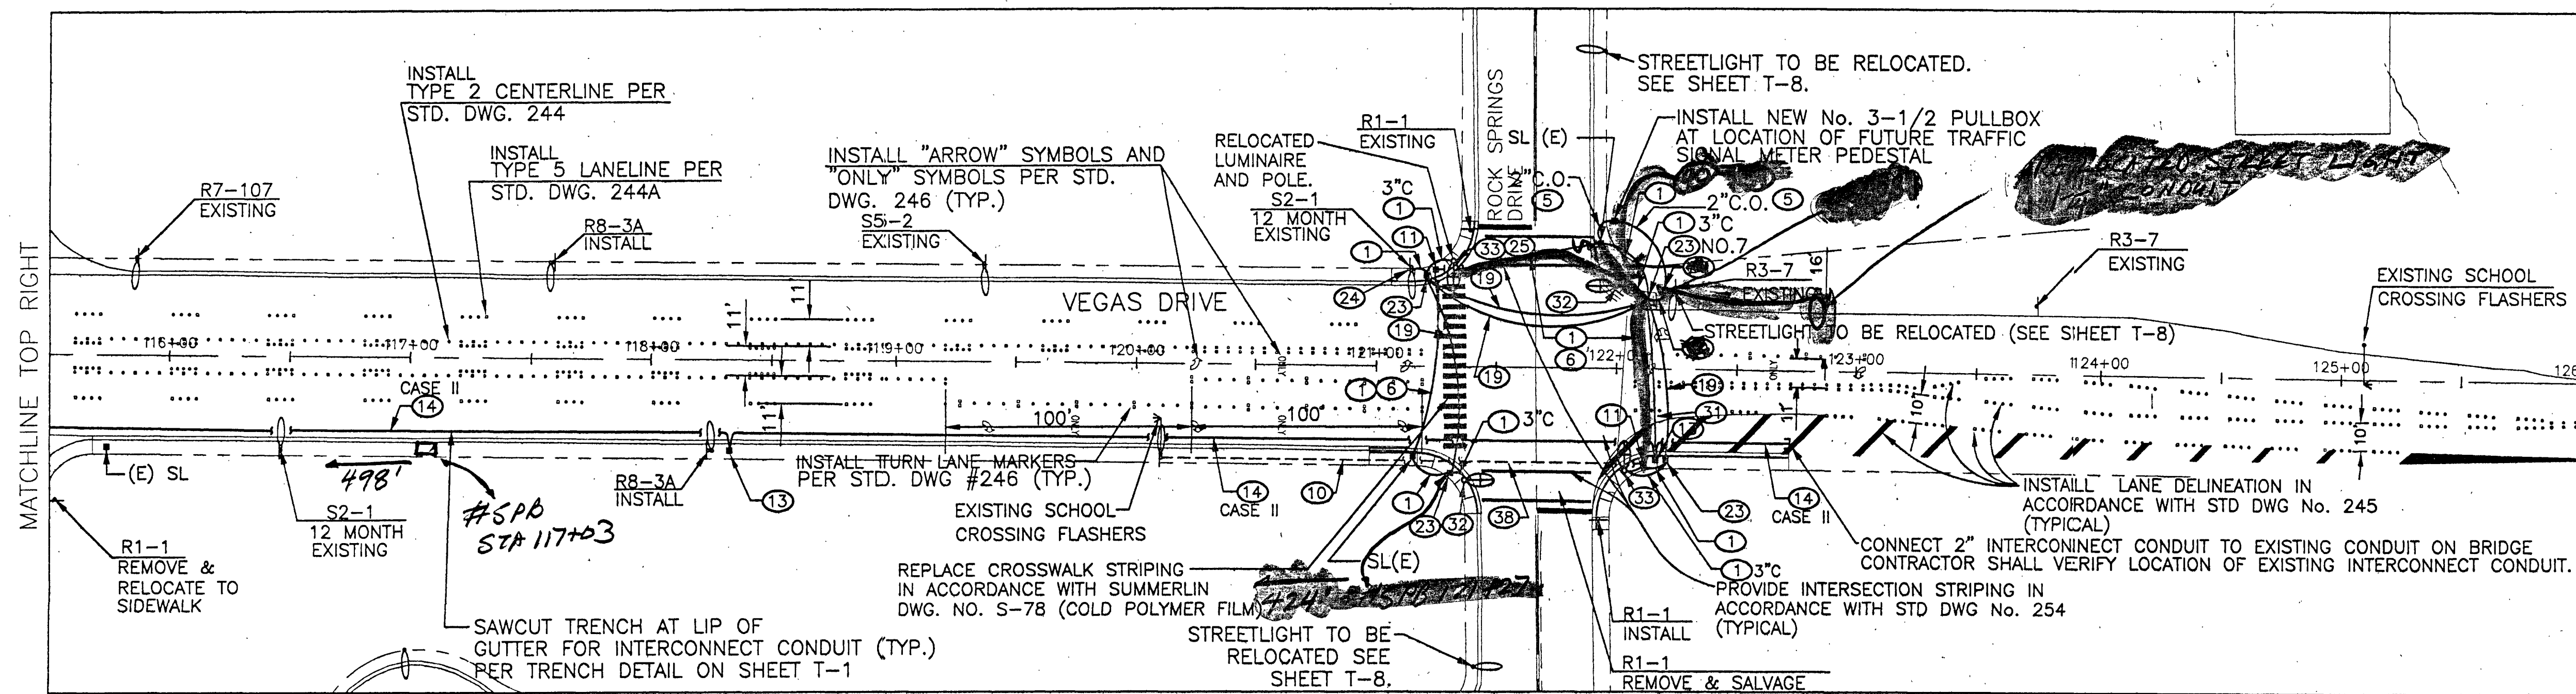

- NOTES:
1. REFER TO STD. DWG. NO. 247 FOR MARKER AND REFLECTOR TYPES.
  2. SEE SHEET T-1 FOR STREETLIGHTING CONSTRUCTION NOTES.
  3. REMOVE ALL R1-1 & R1-3 SIGNS WITH CONSTRUCTION OF TRAFFIC SIGNALS, RETURN TO CITY OF LAS VEGAS YARD.
  4. RELOCATE (3) OF EXISTING STREETLIGHTS TO BE REMOVED FROM TENAYA INTERSECTION TO BE RE-INSTALLED AT ROCK SPRINGS. SEE NOTE 4 BELOW.

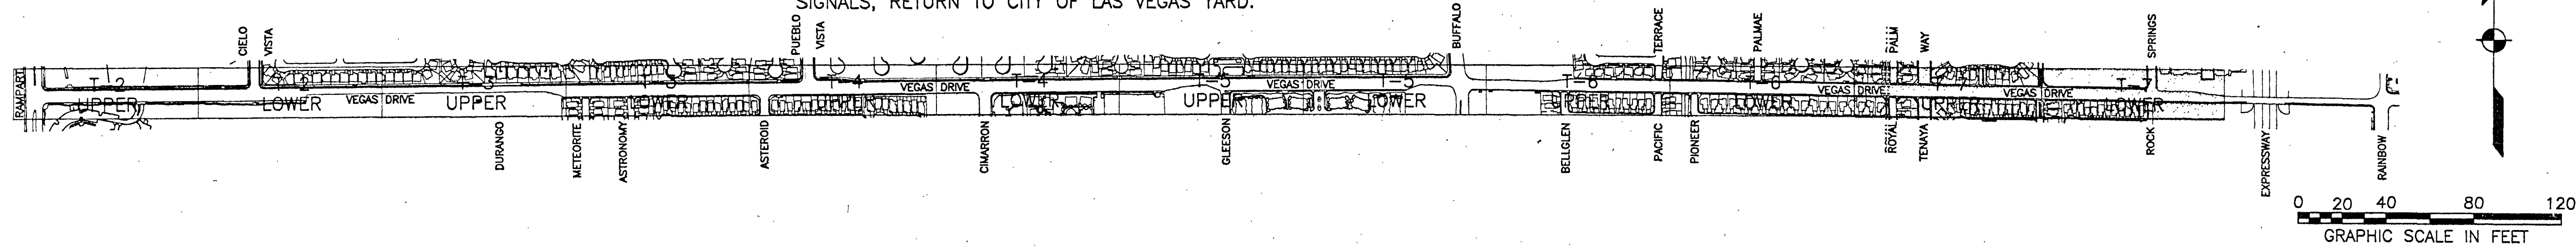


- NOTES:
1. REFER TO STD. DWG. NO. 247 FOR MARKER AND REFLECTOR TYPES.
  2. SEE SHEET T-1 FOR STREETLIGHTING CONSTRUCTION NOTES.
  3. SEE SHEET T-8 FOR STREETLIGHTING RELOCATIONS ON ROCK SPRINGS.
  4. STREETLIGHTS ON NE, SE, AND SW CORNERS ARE RELOCATED FROM TENAYA INTERSECTION.
  5. TRAFFIC SIGNAL POLES SHALL BE INSTALLED CLEAR OF HANDICAP RAMPS IN ACCORDANCE WITH A.D.A. REQUIREMENTS.


Avoid cutting underground utility lines. It's costly.

Call  
before you  
Dig.

1-800-227-2600  
UNDERGROUND SERVICE ALERT (USA)

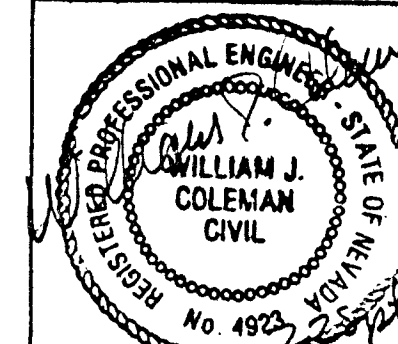

STRIPING & SIGNAGE

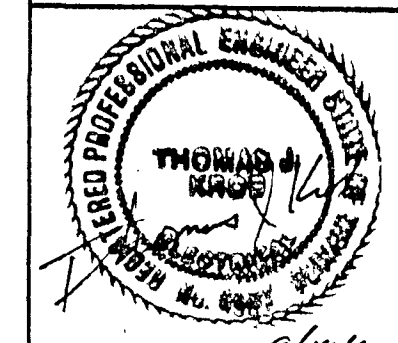

STREET LIGHTING

USE OF DOCUMENTS  
THIS DOCUMENT, INCLUDING THE INSTRUMENT OF SERVICE, IS AN INSTRUMENT OF SERVICE FOR THE PROJECT AND SHALL NOT BE USED FOR ANY OTHER PROJECT WITHOUT THE WRITTEN AUTHORIZATION OF KENNEDY/JENKS CONSULTANTS.

| NO. | REVISION | DATE | BY |
|-----|----------|------|----|
|     |          |      |    |
|     |          |      |    |
|     |          |      |    |
|     |          |      |    |

DESIGNED HW/DSN  
DRAWN JDM/BUL  
CHECKED TOM  
KROB  
Kennedy/Jenks Consultants  
1455 E. Tropicana Avenue, Suite 300  
Las Vegas, NV 89119  
CONSULTING ENGINEERS, INC.  
1015 S. RANCHO BLVD., SUITE 9  
LAS VEGAS, NEVADA 89102  
ELECTRICAL ENGINEERING



CITY OF LAS VEGAS - STREET IMPROVEMENTS  
VEGAS DRIVE - RAMPART TO ROCK SPRINGS  
STRIPING/LIGHTING PLAN  
FROM STA. 105+00  
TO STA. 126+00

DWG. NO. 107-V2884  
SHEET 44 OF 50  
DATE 9-16-97  
T-7