



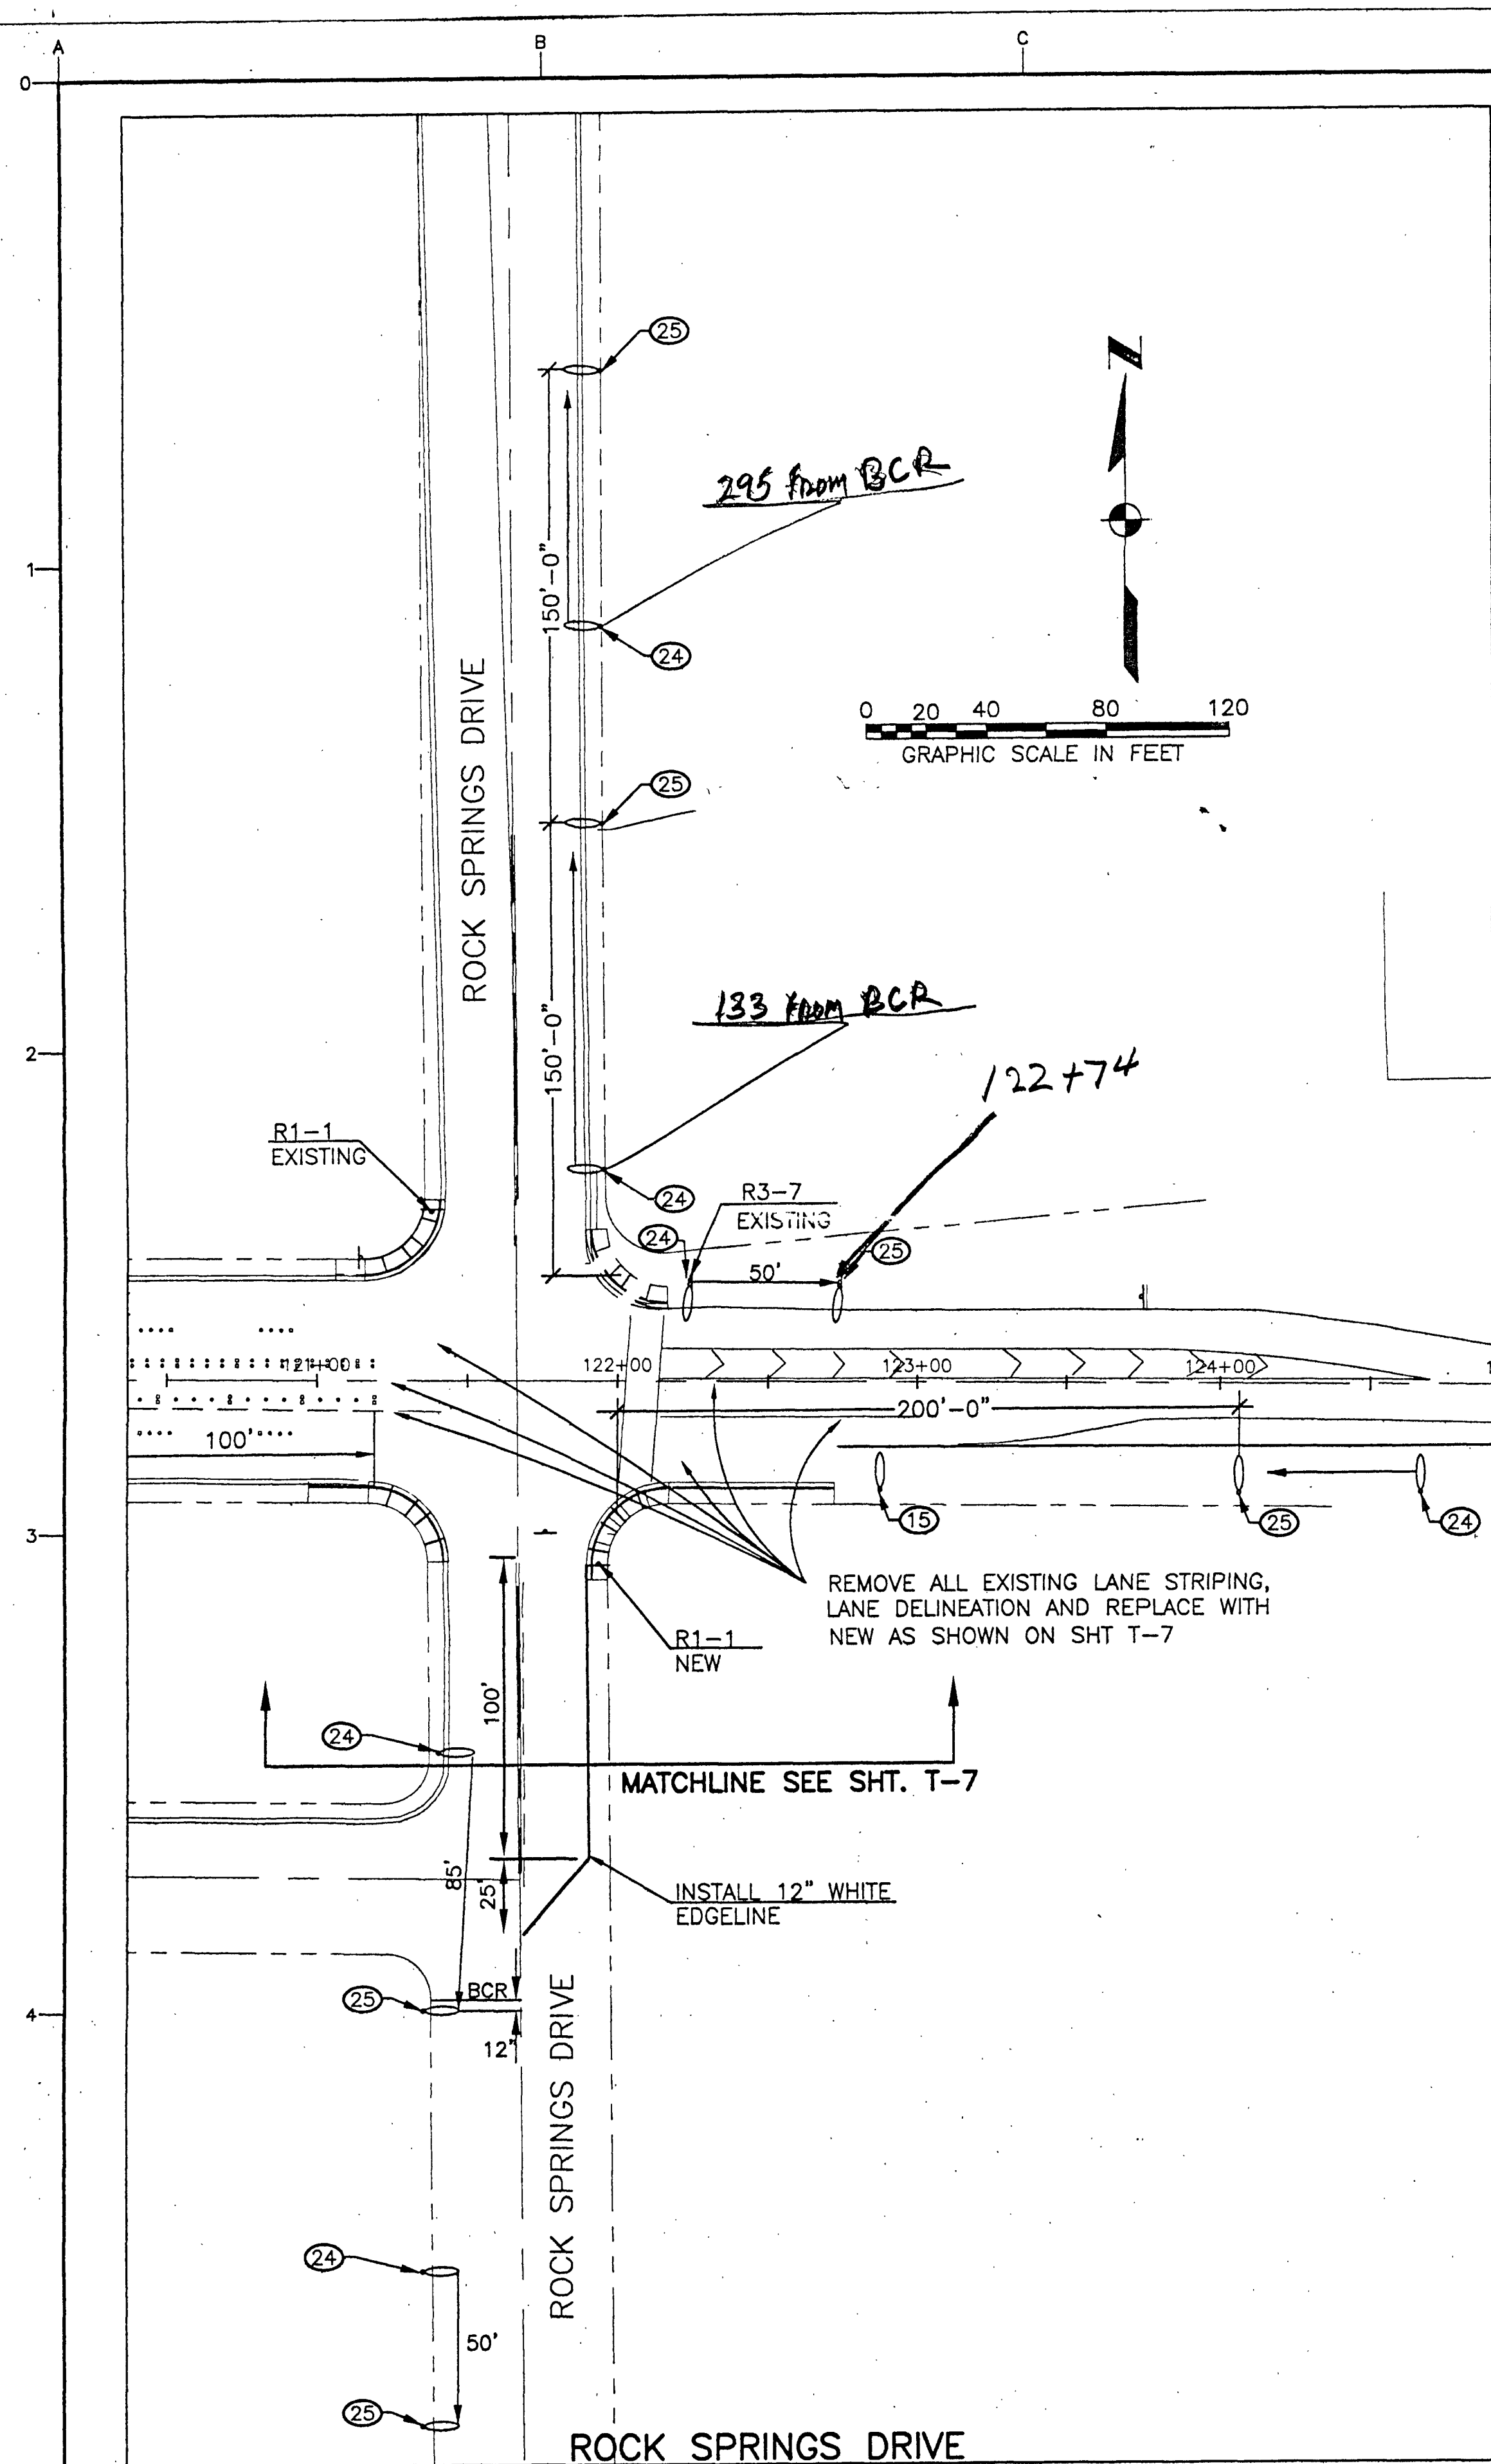



- NOTES:
1. REFER TO STD. DWG. NO. 247 FOR MARKER AND REFLECTOR TYPES.
 2. SEE SHEET T-1 FOR STREETLIGHTING CONSTRUCTION NOTES.
 3. SEE SHEET T-7 FOR INTERSECTION TRAFFIC SIGNAL UNDERGROUND REQUIREMENTS.

MATCHLINE SEE SHT. T-3

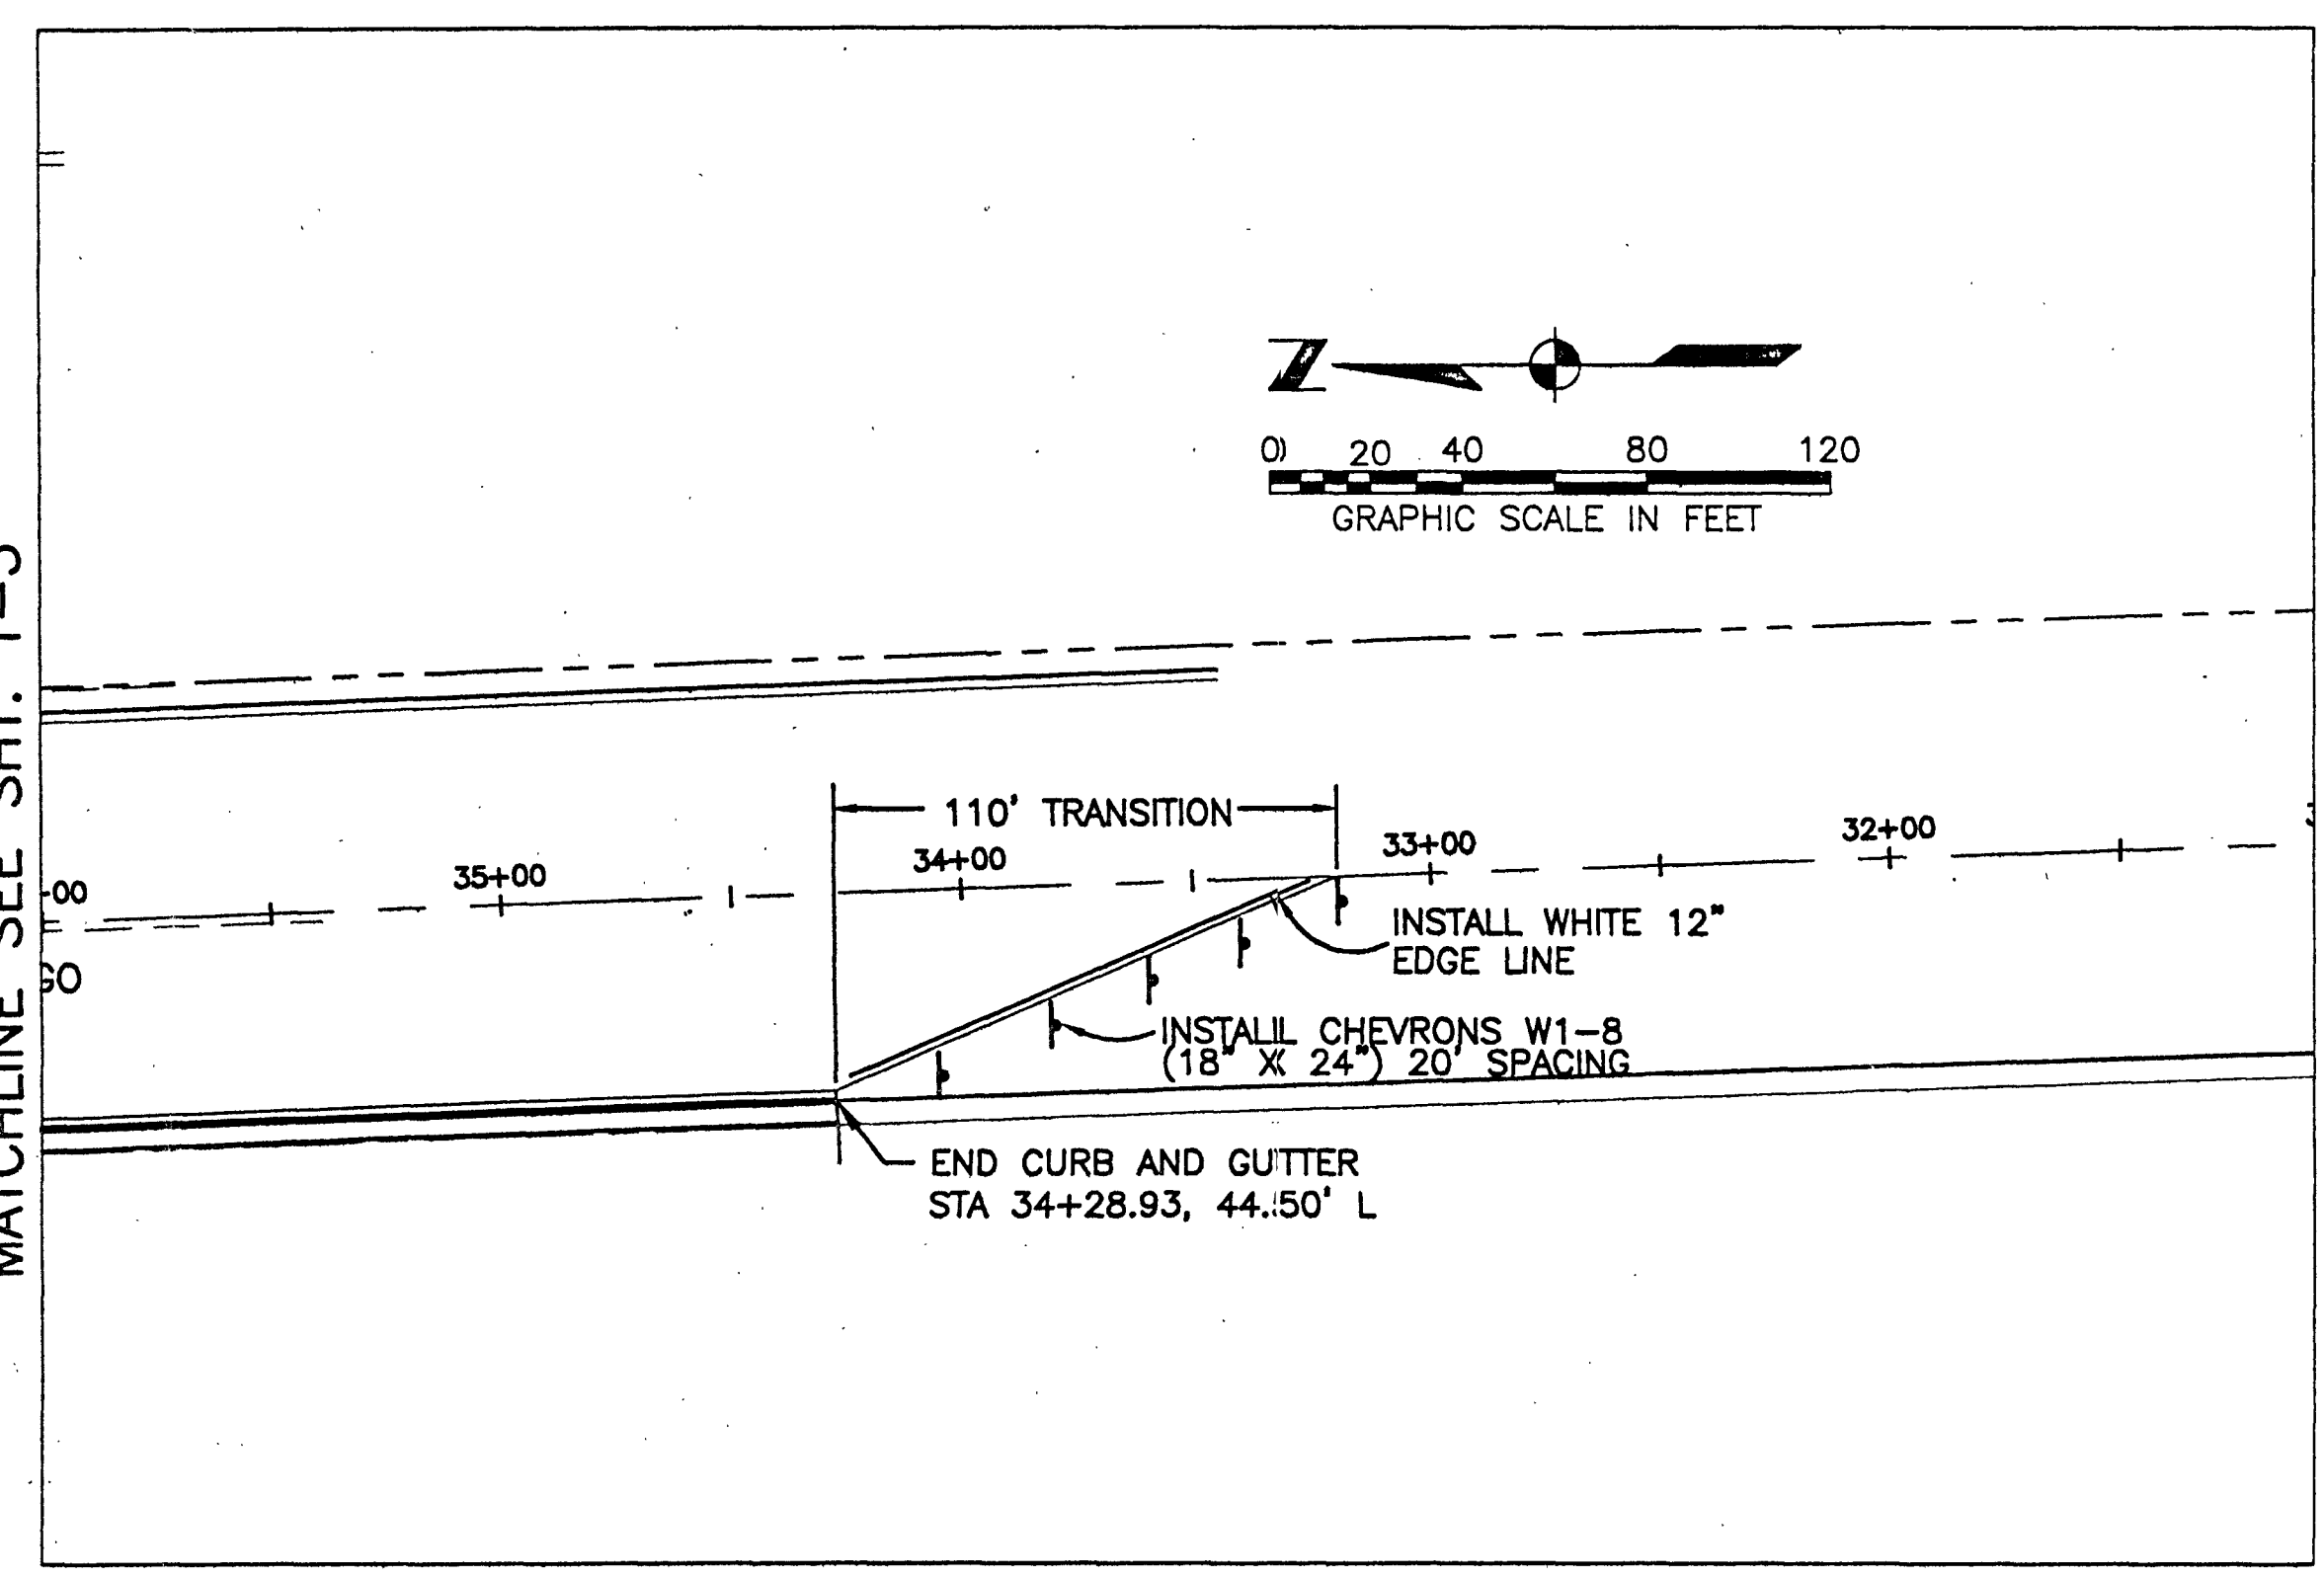

DURANGO DRIVE

Avoid cutting underground utility lines. It's costly.
Call before you Dig.
 1-800-227-2600
 UNDERGROUND SERVICE ALERT (USA)

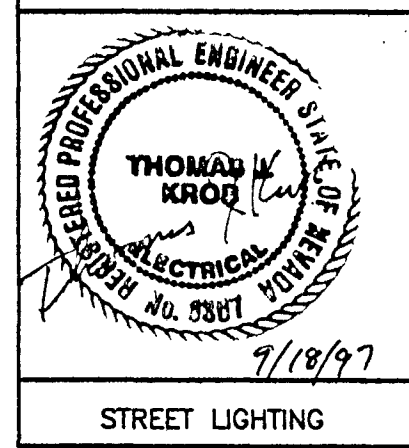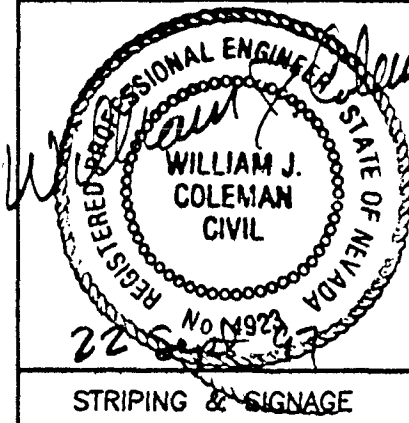

USE OF DOCUMENTS				DATE		REVISION		NO.	
THIS DOCUMENT, INCLUDING THE INSTRUMENT OF SERVICE FOR THIS PROJECT AND SHALL NOT BE USED FOR ANY OTHER PROJECT WITHOUT THE WRITTEN AUTHORIZATION OF KENNEDY/JENKS CONSULTANTS.				BY					
DESIGNED	HW/DSN	DRAWN	JDM/BUL	CHECKED	TOM	NO.			
Kennedy/Jenks Consultants 1455 E. Tropicana Avenue, Suite 300 Las Vegas, NV 89119				TOM KROB		ELECTRICAL ENGINEERING			
CITY OF LAS VEGAS - STREET IMPROVEMENTS VEGAS DRIVE - RAMPART TO ROCK SPRINGS				STRIPING/LIGHTING PLAN VEGAS DRIVE/ ROCK SPRINGS DRIVE		T-8			
DWG. NO.	107-V2684	JOB NO.	967018.04	DATE	9-16-97	SHEET	45 OF 50		

47056