
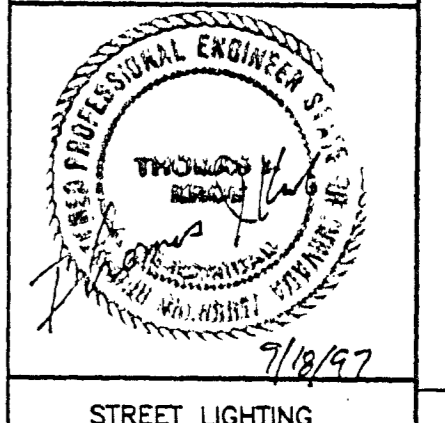


Avoid cutting underground utility lines. It's costly.  
**Call before you Dig.**  
 1-800-227-2600  
UNDERGROUND SERVICE ALERT (USA)

**USE OF DOCUMENTS**  
 THIS DOCUMENT, INCLUDING THE INCORPORATED DESIGNS, IS AN INSTRUMENT OF SERVICE FOR THIS PROJECT AND SHALL NOT BE USED FOR ANY OTHER PROJECT WITHOUT THE WRITTEN AUTHORIZATION OF KENNEDY/JENKS CONSULTANTS.

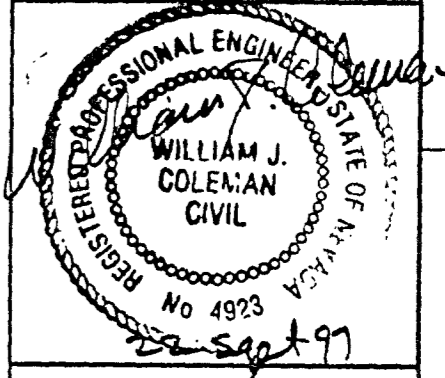

STREET LIGHTING


| NO. | REVISION | DATE | BY |
|-----|----------|------|----|
|     |          |      |    |
|     |          |      |    |
|     |          |      |    |

DESIGNED: HW/DSN  
 DRAWN: JDM/BJL  
 CHECKED: TOM KROB  
 Kennedy/Jenks Consultants  
 1455 E. Tropicana Avenue, Suite 300  
 Las Vegas, NV 89119  
**TJKROB** CONSULTING ENGINEERS, INC.  
 1455 E. TROPICANA AVENUE, SUITE 300  
 LAS VEGAS, NEVADA 89119  
 (702) 871-3621  
 ELECTRICAL ENGINEERING





CITY OF LAS VEGAS - STREET IMPROVEMENTS  
 VEGAS DRIVE - RAMPART TO ROCK SPRINGS  
 STRIPING/LIGHTING PLAN  
 FROM STA. 0+98.92 TO STA. 21+00

6105/SHT-12  
 DWG NO: 107-V2684  
 JOB NO: 967018.04  
 DATE: 9-16-87  
 SHEET: 39 OF 50  
**T-2**

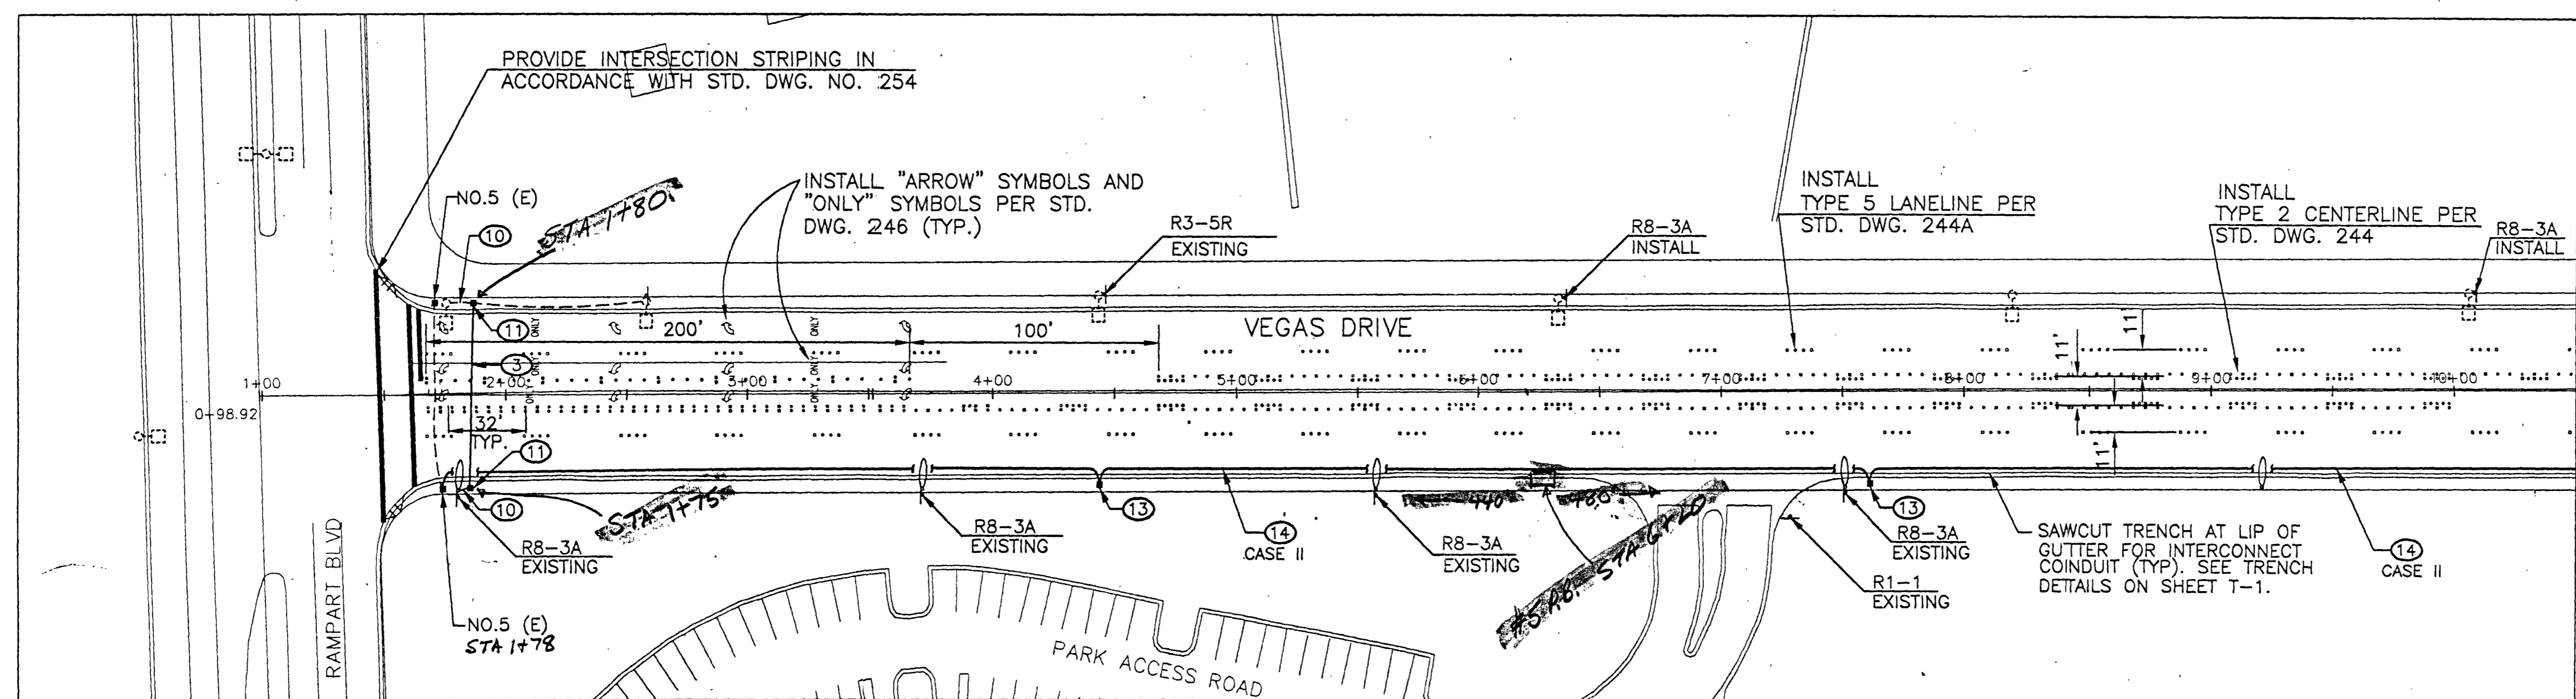

NOTES: 1. REFER TO STD. DWG. NO. 247 FOR MARKER AND REFLECTOR TYPES.  
 2. SEE SHEET T-1 FOR STREETLIGHTING CONSTRUCTION NOTES.

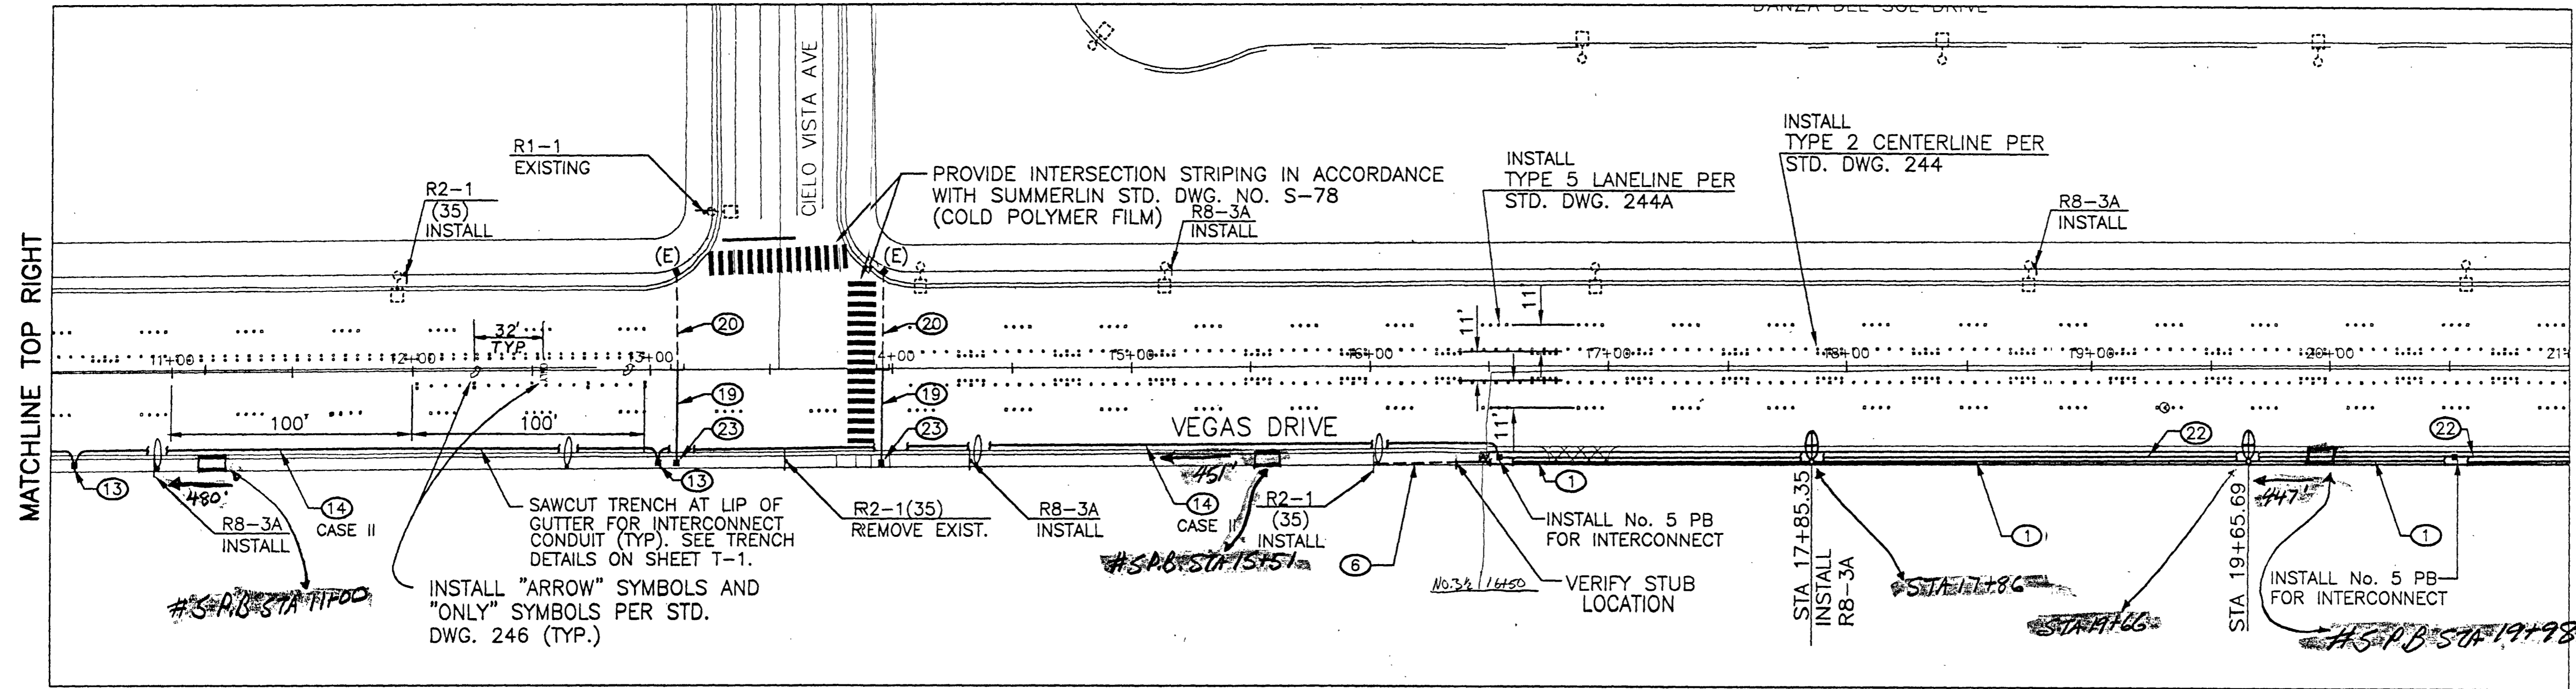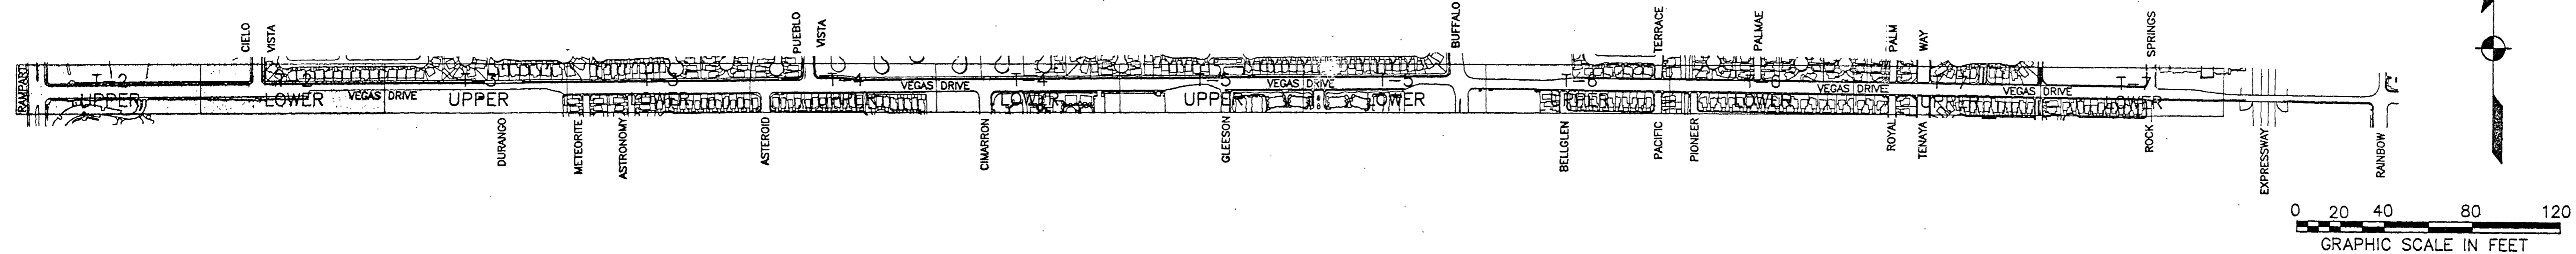

NOTES: 1. REFER TO STD. DWG. NO. 247 FOR MARKER AND REFLECTOR TYPES.  
 2. SEE SHEET T-1 FOR STREETLIGHTING CONSTRUCTION NOTES.

47056