


KEY MAP
NTS

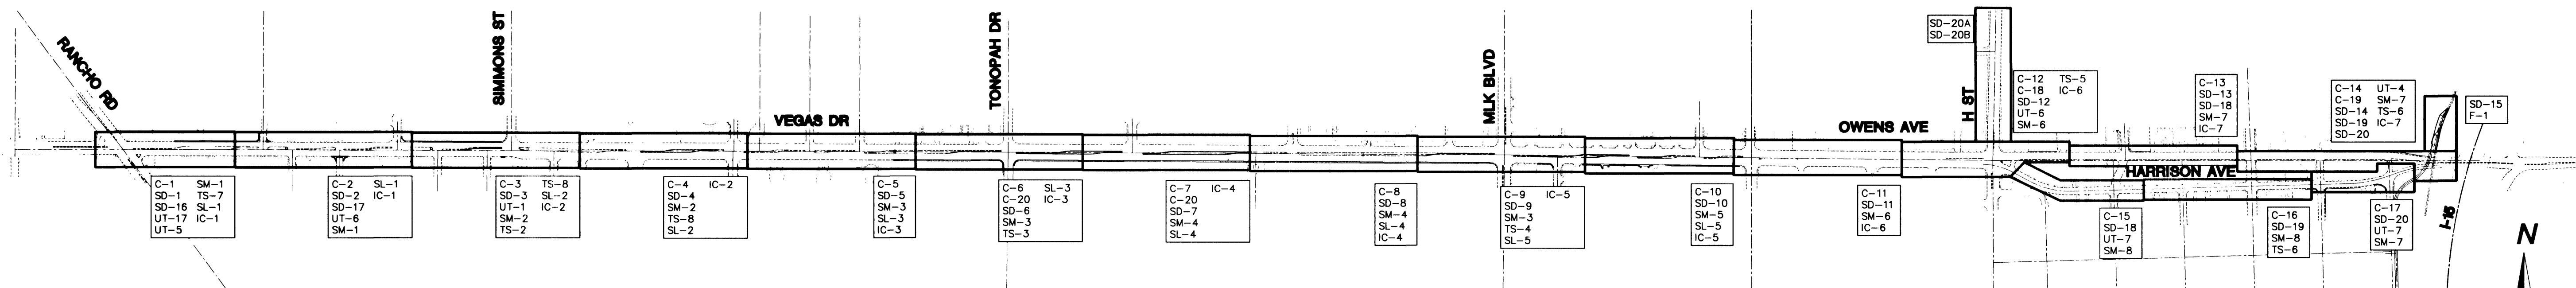

INDEX OF DRAWINGS

GENERAL DRAWINGS

DWG DESCRIPTION

1	COVER
2	KEY MAP AND INDEX OF DRAWINGS
3	GENERAL NOTES
H-1	MONUMENTATION AND HORIZONTAL CONTROL SHEET 1
H-2	MONUMENTATION AND HORIZONTAL CONTROL SHEET 2
H-3	MONUMENTATION AND HORIZONTAL CONTROL SHEET 3

TYPICAL SECTIONS

DWG DESCRIPTION

TY-1	TYPICAL SECTIONS
------	------------------

CIVIL DRAWINGS

DWG DESCRIPTION

C-1	CONSTRUCTION PLAN AND PROFILE 7+00 to 16+00
C-2	CONSTRUCTION PLAN AND PROFILE 16+00 to 25+50
C-3	CONSTRUCTION PLAN AND PROFILE 25+50 to 34+50
C-4	CONSTRUCTION PLAN AND PROFILE 34+50 to 43+50
C-5	CONSTRUCTION PLAN AND PROFILE 43+50 to 52+50
C-6	CONSTRUCTION PLAN AND PROFILE 52+50 to 61+50
C-7	CONSTRUCTION PLAN AND PROFILE 61+50 to 70+50
C-8	CONSTRUCTION PLAN AND PROFILE 70+50 to 79+50
C-9	CONSTRUCTION PLAN AND PROFILE 79+50 to 88+50
C-10	CONSTRUCTION PLAN AND PROFILE 88+50 to 96+50
C-11	CONSTRUCTION PLAN AND PROFILE 96+50 to 105+50
C-12	CONSTRUCTION PLAN AND PROFILE 105+50 to 114+50
C-13	CONSTRUCTION PLAN AND PROFILE 114+50 to 123+50

CIVIL DRAWINGS

DWG DESCRIPTION

C-14	CONSTRUCTION PLAN AND PROFILE 123+50 to 135+75
C-15	CONSTRUCTION PLAN AND PROFILE 11+25 to 20+50
C-16	CONSTRUCTION PLAN AND PROFILE 20+50 to 28+00
C-17	CONSTRUCTION PLAN AND PROFILE 28+00 to 34+50
C-18	INTERSECTION GRADING PLAN OWENS AVE/HARRISON AVE & H STREET
C-19	INTERSECTION GRADING PLAN OWENS AVE/HARRISON AVE @ I-15 OVERPASS
C-20	MEDIAN GEOMETRY
C-21	NOT USED

STORM DRAIN DRAWINGS

DWG DESCRIPTION

SD-1	STORM DRAIN PLAN AND PROFILE 6+91.43 to 16+00
SD-2	STORM DRAIN PLAN AND PROFILE 16+00 to 25+50
SD-3	STORM DRAIN PLAN AND PROFILE 25+50 to 34+50
SD-4	STORM DRAIN PLAN AND PROFILE 34+50 to 43+50
SD-5	STORM DRAIN PLAN AND PROFILE 43+50 to 52+50
SD-6	STORM DRAIN PLAN AND PROFILE 52+50 to 61+50
SD-7	STORM DRAIN PLAN AND PROFILE 61+50 to 70+50
SD-8	STORM DRAIN PLAN AND PROFILE 70+50 to 79+50
SD-9	STORM DRAIN PLAN AND PROFILE 79+50 to 88+50
SD-10	STORM DRAIN PLAN AND PROFILE 88+50 to 96+50
SD-11	STORM DRAIN PLAN AND PROFILE 96+50 to 105+50
SD-12	STORM DRAIN PLAN AND PROFILE 105+50 to 114+50
SD-13	STORM DRAIN PLAN AND PROFILE 114+50 to 123+50

STORM DRAIN DRAWINGS

SHT DESCRIPTION

SD-14	STORM DRAIN PLAN AND PROFILE 123+50 to 135+75
SD-15	I-15 DRAINAGE CHANNEL CONFLUENCE PLAN
SD-16	RANCHO DRIVE STORM DRAIN LATERAL PLAN & PROFILE
SD-17	VEGAS DRIVE/FERRELL STREET STORM DRAIN LATERAL PLAN & PROFILE
SD-18	"F" STREET STORM DRAIN LATERAL PLAN & PROFILE
SD-19	"D" STREET STORM DRAIN LATERAL PLAN & PROFILE
SD-20	"C" STREET STORM DRAIN LATERAL PLAN & PROFILE
SD-20A	STORM DRAIN PLAN & PROFILE "H" STREET LATERAL
SD-20B	STORM DRAIN PLAN & PROFILE "H" STREET LATERAL
SD-21	STORM DRAIN LATERAL PROFILE
SD-22	STORM DRAIN LATERAL PROFILE
SD-23	STORM DRAIN LATERAL PROFILE
SD-24	STORM DRAIN LATERAL PROFILE
SD-25	STORM DRAIN LATERAL PROFILE
SD-26	STORM DRAIN LATERAL PROFILE
SD-27	STORM DRAIN LATERAL PROFILE

DETAIL DRAWINGS

DWG DESCRIPTION

DT-1	STORM DRAIN DETAIL SHEET 1
DT-2	STORM DRAIN DETAIL SHEET 2
DT-3	STORM DRAIN DETAIL SHEET 3
DT-4	STORM DRAIN TRANSITION STRUCTURE DETAIL SHEET 1
DT-5	STORM DRAIN TRANSITION STRUCTURE DETAIL SHEET 2
DT-6	CONFLUENCE DETAIL SHEET
DT-7	SANITARY SEWER DETAIL SHEET 1
DT-8	SANITARY SEWER DETAIL SHEET 2

FENCE DRAWING

DWG DESCRIPTION

F-1	I-15 DRAINAGE CHANNEL FENCING PLAN
-----	------------------------------------

UTILITY DRAWINGS

DWG DESCRIPTION

UT-1	TWIN LAKES LATERAL 36" WATER LINE RELOCATION DETAIL SHEET 1
UT-2	WATERLINE RELOCATION DETAIL SHEET 1
UT-3	WATERLINE RELOCATION DETAIL SHEET 2
UT-4	WATERLINE RELOCATION DETAIL SHEET 3
UT-5	WATERLINE RELOCATION DETAIL SHEET 4
UT-6	WATERLINE RELOCATION DETAIL SHEET 5
UT-7	10" SANITARY SEWER PLAN & PROFILE 123+50 to 135+75
UT-8	SANITARY SEWER PLAN & PROFILE 21" DIVERSIONARY LINE
UT-9	SANITARY SEWER PLAN & PROFILE VEGAS/FERRELL & OWENS/"H"
UT-10	SANITARY SEWER PLAN & PROFILE "H"/"G" & HARRISON/"B"

TRAFFIC SIGNALING AND MARKING DRAWINGS

DWG DESCRIPTION

SM-1	SIGNING AND MARKING PLAN 7+00 to 25+50
SM-2	SIGNING AND MARKING PLAN 25+50 to 43+50
SM-3	SIGNING AND MARKING PLAN 43+50 to 61+50
SM-4	SIGNING AND MARKING PLAN 61+50 to 79+50
SM-5	SIGNING AND MARKING PLAN 79+50 to 96+50
SM-6	SIGNING AND MARKING PLAN 96+50 to 114+50
SM-7	SIGNING AND MARKING PLAN 114+50 to 135+75
SM-8	SIGNING AND MARKING PLAN 12+00 to 30+00

TRAFFIC SIGNAL DRAWINGS

DWG DESCRIPTION

TS-1	TRAFFIC SIGNAL GENERAL NOTES & DETAILS
TS-2	TRAFFIC SIGNAL VEGAS DR & SIMMONS ST
TS-3	TRAFFIC SIGNAL VEGAS DR & TONOPAH DR
TS-4	TRAFFIC SIGNAL VEGAS DR & MLK BLVD
TS-5	TRAFFIC SIGNAL OWENS AVE & "H" ST
TS-6	TRAFFIC SIGNAL OWENS AVE/HARRISON AVE & "D" ST
TS-7	TRAFFIC SIGNAL VEGAS DR & RANCHO DR
TS-8	FLASHING SCHOOL BEACON ADVANCED TECHNOLOGIES ACADEMY

STREET LIGHTING DRAWINGS


DWG DESCRIPTION

SL-1	STREET LIGHTING PLAN 7+00 to 25+50
SL-2	STREET LIGHTING PLAN 25+50 to 43+50
SL-3	STREET LIGHTING PLAN 43+50 to 61+50
SL-4	STREET LIGHTING PLAN 61+50 to 79+50
SL-5	STREET LIGHTING PLAN 79+50 to 98+00

INTERCONNECT DRAWINGS

DWG DESCRIPTION

IC-1	FIBER OPTIC INTERCONNECT PLAN 7+00 to 25+50
IC-2	FIBER OPTIC INTERCONNECT PLAN 25+50 to 43+50
IC-3	FIBER OPTIC INTERCONNECT PLAN 43+50 to 61+50
IC-4	FIBER OPTIC INTERCONNECT PLAN 61+50 to 79+50
IC-5	FIBER OPTIC INTERCONNECT PLAN 79+50 to 96+50
IC-6	FIBER OPTIC INTERCONNECT PLAN 96+50 to 114+50
IC-7	FIBER OPTIC INTERCONNECT PLAN 114+50 to 135+50
IC-8	FIBER OPTIC INTERCONNECT DETAIL SHEET 1
IC-9	FIBER OPTIC INTERCONNECT DETAIL SHEET 2
IC-10	FIBER OPTIC INTERCONNECT DETAIL SHEET 3
IC-11	FIBER OPTIC INTERCONNECT DETAIL SHEET 4
IC-12	FIBER CONNECTION DETAIL COMMUNICATION CIRCUIT 5
IC-13	FIBER CONNECTION DETAIL COMMUNICATION CIRCUIT 6

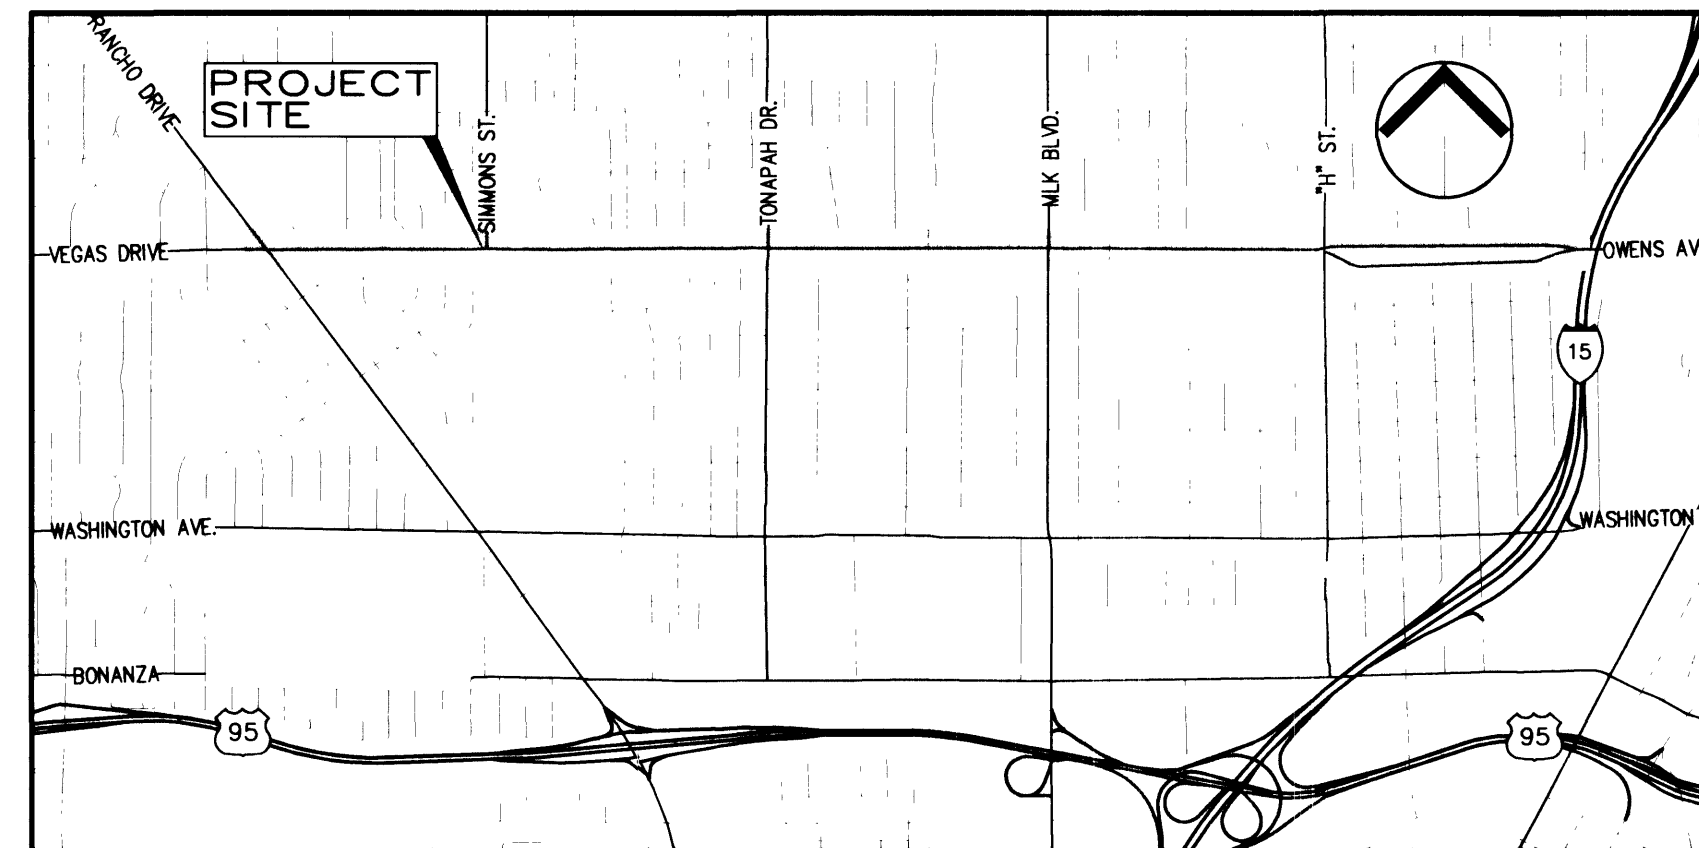

LOCATION MAP
N.T.S.

SAFETY ALERT
Call Before You Overhead
1-702-593-6111

Call before you Dig
1-800-227-2600

DEPARTMENT OF PUBLIC WORKS
KEY MAP AND INDEX OF SHEETS
PROJECT: VEGAS DR/OWENS AVE RANCHO DR. TO INTERSTATE 15
SHEET: 2
DRAWING NO. 2
DATE: 1/4/02
DESIGN BY: Kimley-Horn and Associates, Inc.
Engineering, Planning, and Environmental Consultants
© 2002