

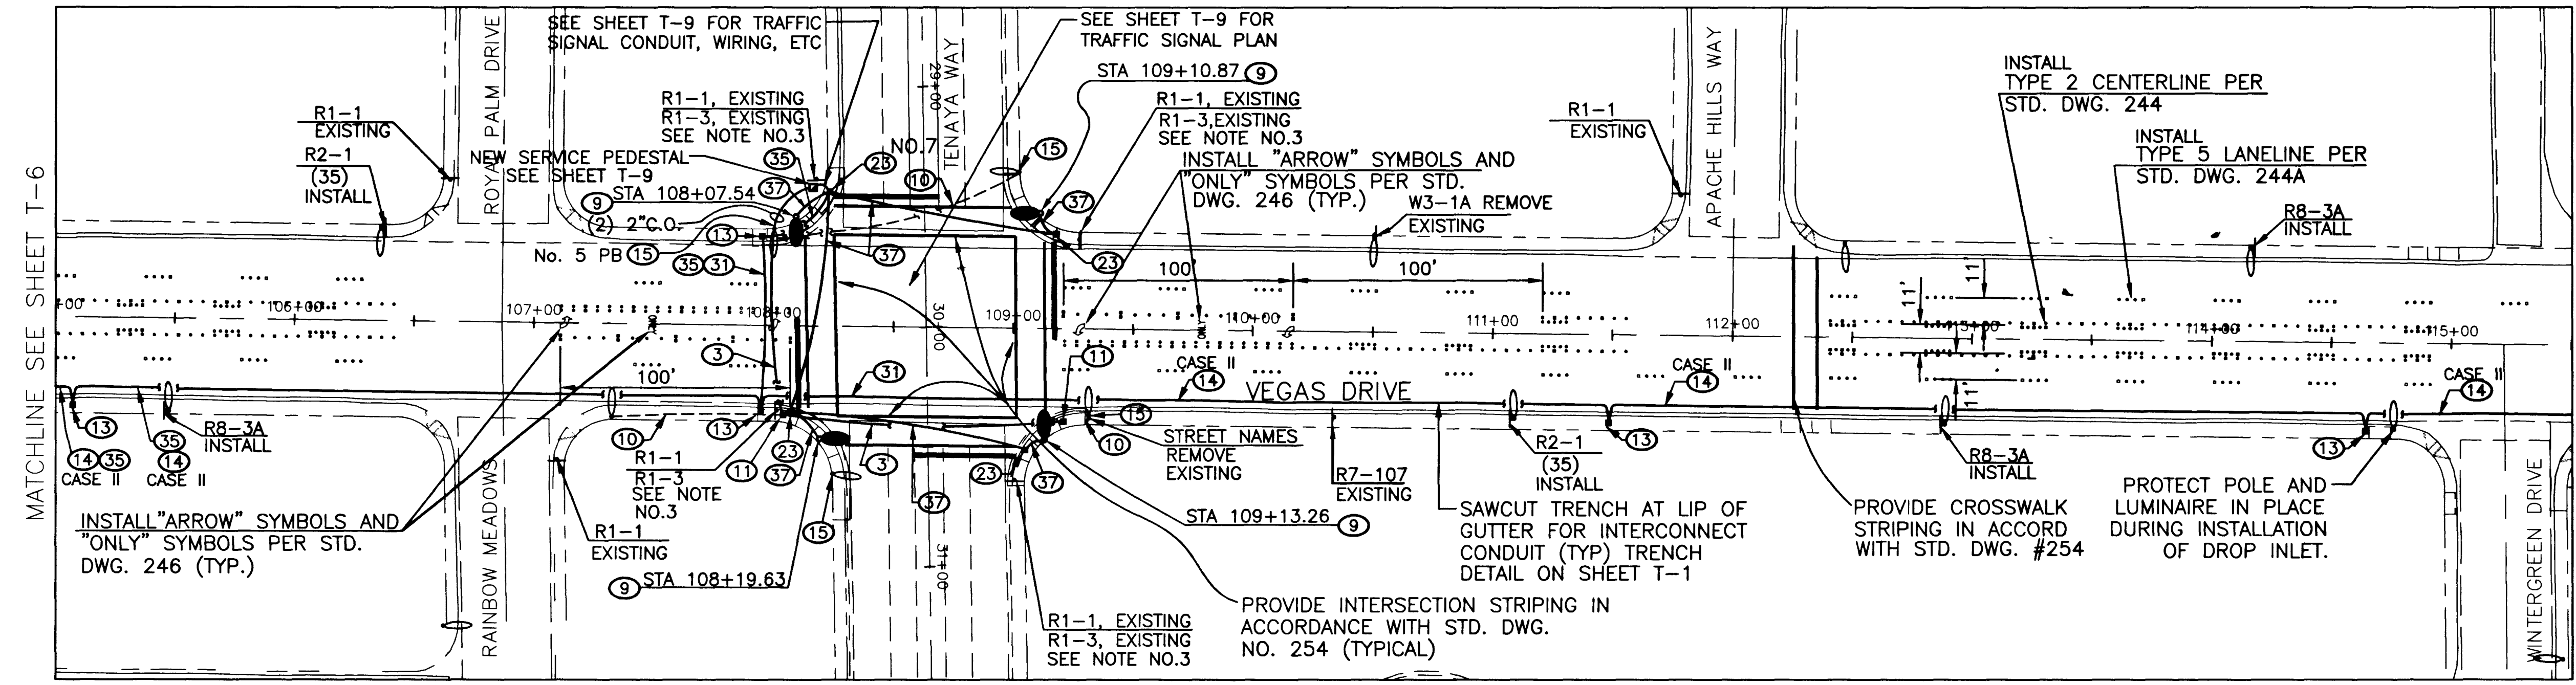


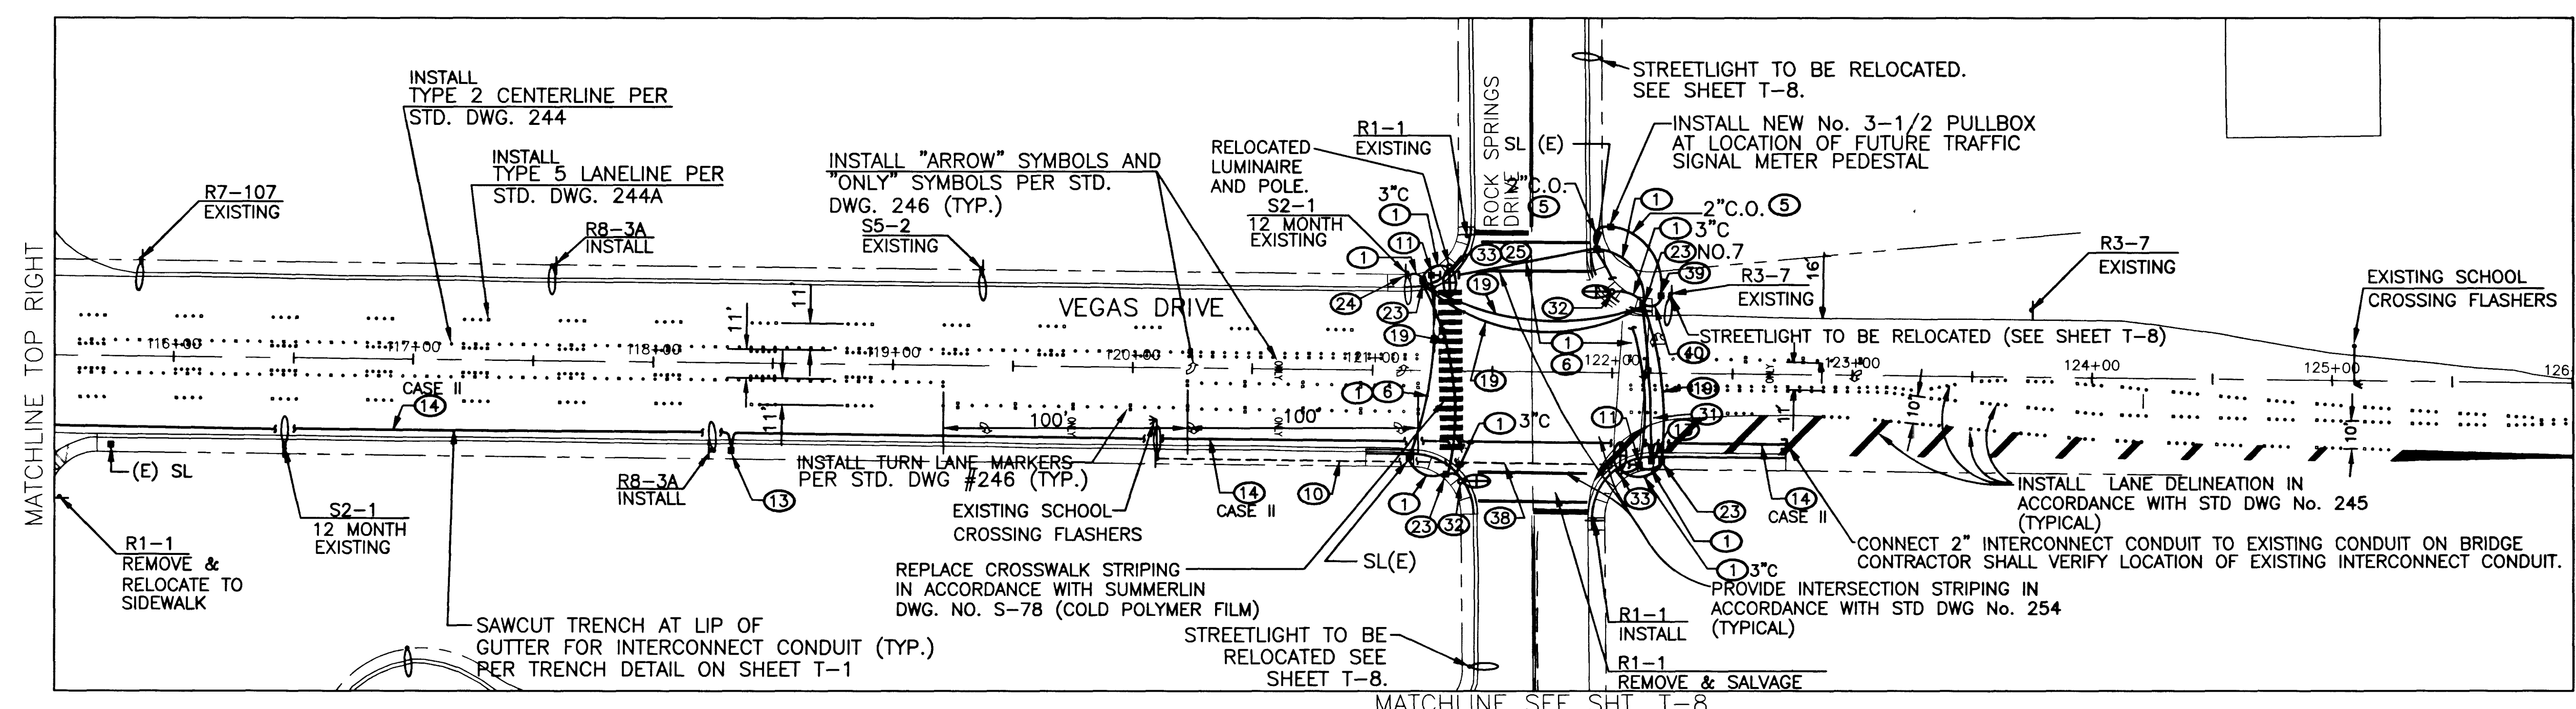

- NOTES:
1. REFER TO STD. DWG. NO. 247 FOR MARKER AND REFLECTOR TYPES.
 2. SEE SHEET T-1 FOR STREETLIGHTING CONSTRUCTION NOTES.
 3. REMOVE ALL R1-1 & R1-3 SIGNS WITH CONSTRUCTION OF TRAFFIC SIGNALS, RETURN TO CITY OF LAS VEGAS YARD.
 4. RELOCATE (3) OF EXISTING STREETLIGHTS TO BE REMOVED FROM TENAYA INTERSECTION TO BE RE-INSTALLED AT ROCK SPRINGS. SEE NOTE 4 BELOW.

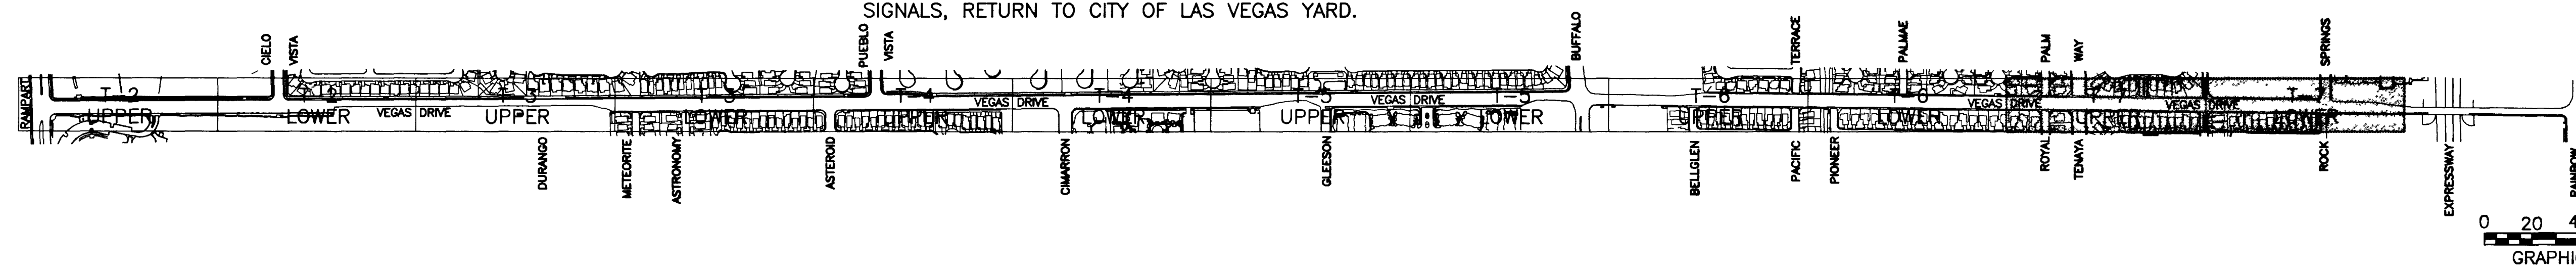

- NOTES:
1. REFER TO STD. DWG. NO. 247 FOR MARKER AND REFLECTOR TYPES.
 2. SEE SHEET T-1 FOR STREETLIGHTING CONSTRUCTION NOTES.
 3. SEE SHEET T-8 FOR STREETLIGHTING RELOCATIONS ON ROCK SPRINGS.
 4. STREETLIGHTS ON NE, SE, AND SW CORNERS ARE RELOCATED FROM TENAYA INTERSECTION.
 5. TRAFFIC SIGNAL POLES SHALL BE INSTALLED CLEAR OF HANDICAP RAMPS IN ACCORDANCE WITH A.D.A. REQUIREMENTS.

Call before you Dig.
1-800-227-2600
UNDERGROUND SERVICE ALERT (USA)

REGISTERED PROFESSIONAL ENGINEER
STATE OF NEVADA
WILLIAM J. COLEMAN
CIVIL
No. 4923, Y0000

STRIPING & SIGNAGE

REGISTERED PROFESSIONAL ENGINEER
STATE OF NEVADA
THOMAS A. KROB
ELECTRICAL
No. 4923, Y0000

7/18/97

STREET LIGHTING

USE OF DOCUMENTS				REVISION			
THIS DOCUMENT, INCLUDING THE INCORPORATED DESIGNS, IS AN INSTRUMENT OF SERVICE FOR THIS PROJECT AND SHALL NOT BE USED FOR ANY OTHER PROJECT WITHOUT THE WRITTEN AUTHORIZATION OF KENNEDY/JENKS CONSULTANTS.				NO.	DATE	BY	
DESIGNED							
DRAWN							
CHECKED							
DATE							
SHEET							
T-7							

6105/SHT-17	CITY OF LAS VEGAS - STREET IMPROVEMENTS	VEGAS DRIVE - RAMPART TO ROCK SPRINGS	STRIPING/LIGHTING PLAN
107-V2684	VEGAS DRIVE - RAMPART TO ROCK SPRINGS	FROM STA. 105+00	TO STA. 126+00
967018.04	DATE	9-16-97	SHEET 44 OF 50

Kennedy/Jenks Consultants
1455 E. Tropicana Avenue, Suite 300
Las Vegas, NV 89119

TJKROB
CONSULTING ENGINEERS, INC.
1945 S. JONES BLVD., SUITE B
LAS VEGAS, NV 89102
ELECTRICAL ENGINEERING

CITY OF LAS VEGAS
NEVADA

