

REGIONAL STREET AND HIGHWAY COMMISSION OF CLARK COUNTY

PROJECT NO. 4A

VEGAS DRIVE IMPROVEMENTS

JONES BOULEVARD TO DECATUR BOULEVARD

APPROVALS

COUNTY COMMISSION

JAMES G. RYAN, CHAIRMAN
JAMES A. BRENNAN
ROBERT N. BROADBENT
MYRON E. LEAVITT
TOM WIESNER


	APPROVED FOR CONSTRUCTION	DATE OF APPROVAL
REGIONAL STREET & HIGHWAY COMMISSION MANAGING ENGINEER		
CLARK COUNTY ENGINEER		
CLARK COUNTY FIRE DEPARTMENT		
CITY OF LAS VEGAS DIRECTOR OF PUBLIC WORKS		
CITY OF LAS VEGAS TRAFFIC ENGINEER		
CITY OF LAS VEGAS SUPT. OF SANITATION		
NEVADA POWER COMPANY		
CENTRAL TELEPHONE COMPANY		
SOUTHWEST GAS COMPANY		
LAS VEGAS VALLEY WATER DISTRICT		

CITY COMMISSION

MAYOR ORAN K. GRAGSON
DR. ALEXANDER COBLENTZ
GEORGE E. FRANKLIN, JR.
HAROLD F. MORELLI
HANK THORNLEY

SHEET INDEX

SHEET NUMBER	DESCRIPTION
1	TITLE SHEET, LOCATION MAP, INDEX AND AGENCY APPROVALS
2-6	PLAN AND PROFILE FOR VEGAS DRIVE AND NUISANCE WATER DRAIN
7-9	PLAN AND PROFILE FOR NUISANCE WATER DRAIN (ALTERNATE II B)
10	INTERSECTION OF VEGAS DRIVE WITH JONES BLVD. AND SAYLOR WAY
11	INTERSECTION OF VEGAS DRIVE WITH MICHAEL WAY AND DECATUR BLVD.
12	TYPICAL SECTIONS AND CONSTRUCTION DETAILS
13	NUISANCE WATER DRAIN DETAILS
14	LOG OF BORINGS, CONSTRUCTION DETAILS AND SUMMARY OF QUANTITIES

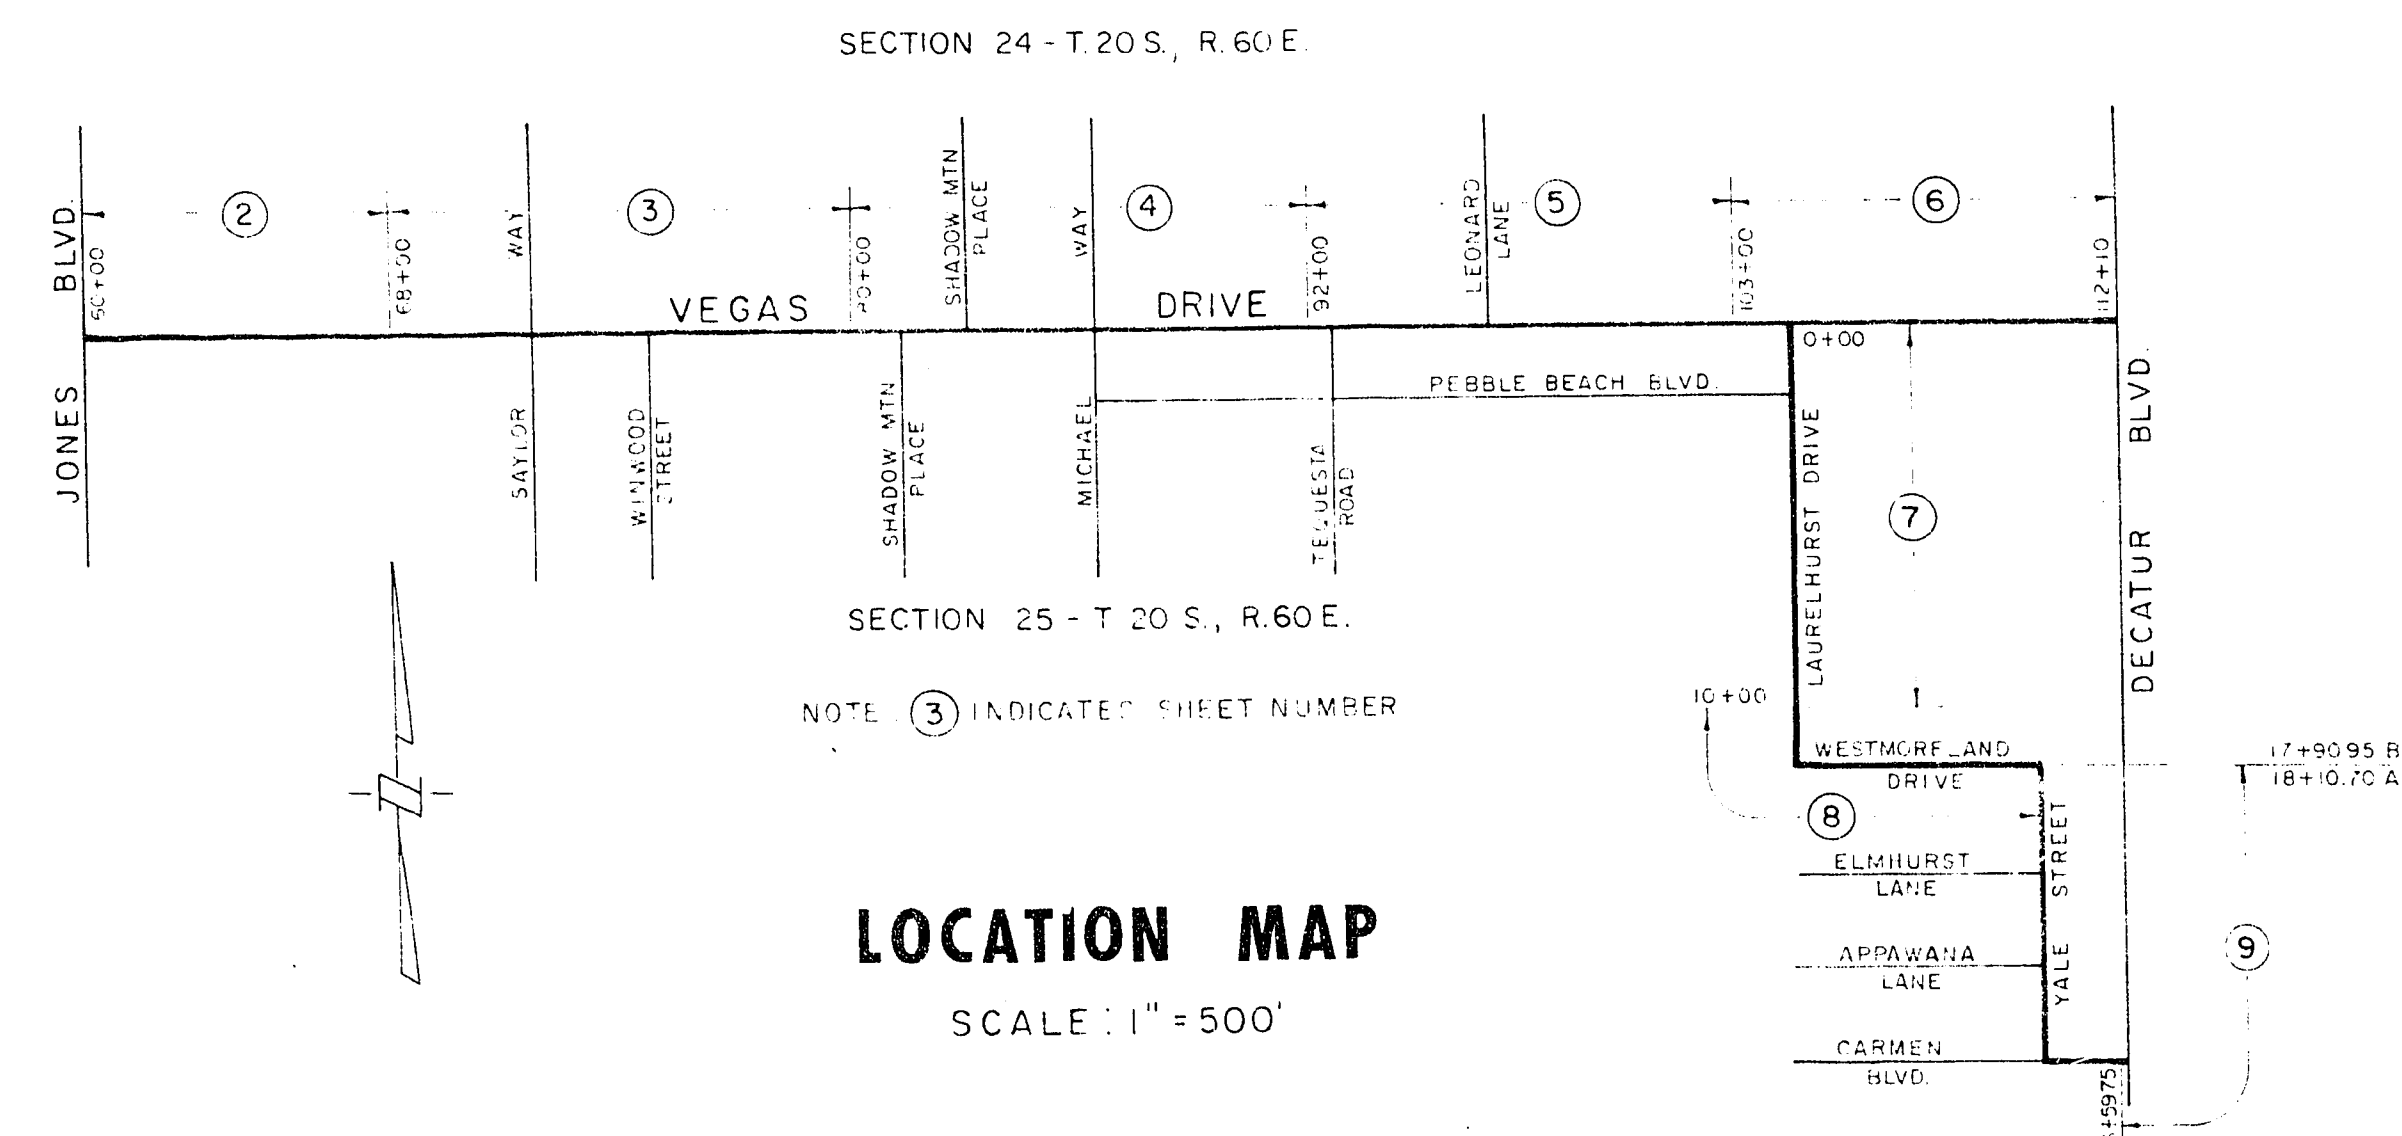

Boyle
ENGINEERING
Consulting Engineers
SANTA ANA VENTURA BAKERSFIELD
SAN DIEGO LAS VEGAS
S. C. DITSWORTH R.C.E. 2304

"AS CONSTRUCTED" 6-1-73

SHEET 1 OF 15

21.4.13
107-V912