


STA 22+50
MATCHLINE - SEE SHEET 3

MATCHLINE - SEE SHEET 5
STA 32+00

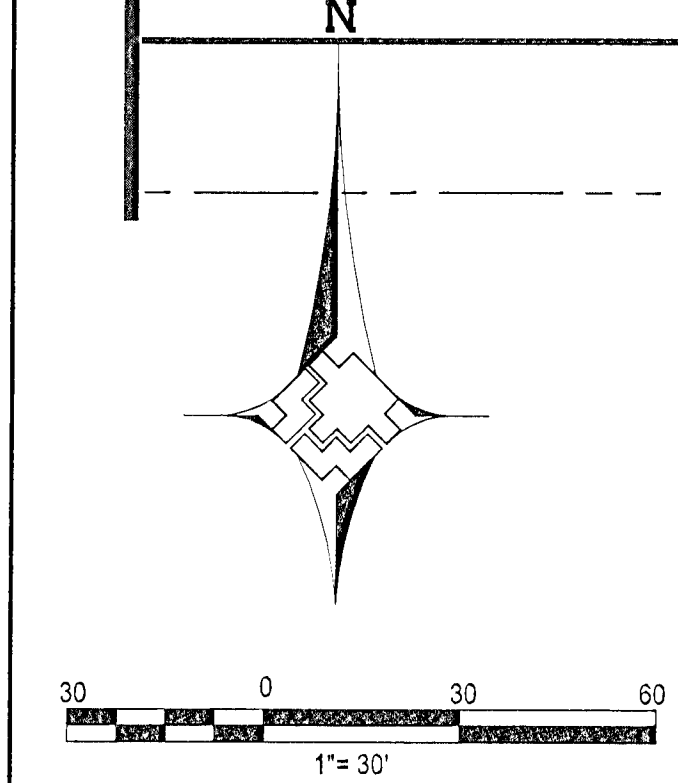


Call before you Dig
Avoid cutting underground utility lines. It's costly.

Call 811

OR
1-800-227-2600

AND
CLARK COUNTY TRUCK OPERATIONS
1-702-455-7544

CPM Utility Plan Approval
 CPM Project Name Vegas Drive Improvements
 CPM Hansen # 11554 Date 6/4/12
 CPM Project Manager Lorrie Linnert Dunford x6735
 Approved by: [Signature]

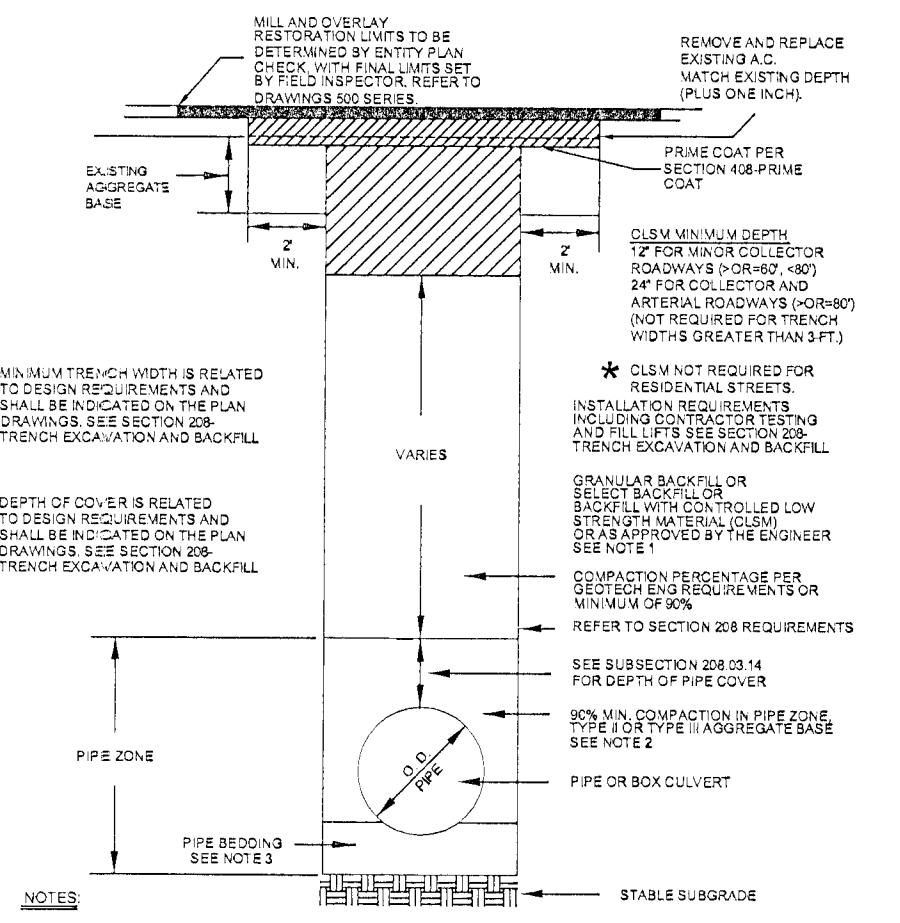

- NOTES:
- NO STONES OR LUMPS GREATER THAN 3" PERMITTED IN TRENCH 2' OR LESS IN WIDTH.
 - TRENCH WIDTH, BEDDING, SUBGRADE AND PIPE ZONE REQUIREMENTS FOR UTILITY INSTALLATIONS SHALL CONFORM TO THE RESPECTIVE ENTITY REQUIREMENTS.
 - CURBED ROCK MAY BE USED FOR PIPE BEDDING ONLY IF MATERIAL HAS BEEN PERMITS APPROVED BY THE GOVERNING AGENCY. SEE STANDARD DRAWING PD 305 FOR PIPE BEDDING METHODS.
 - LAS VEGAS VALLEY WATER DISTRICT REQUIRES PIPE BEDDING AND BACKFILL WITHIN THE PIPE ZONE TO BE OF THE SAME MATERIAL.

RTC STD DWG 503

Southwest Gas Corporation

NO.	DESCRIPTION	BY	DATE	APPRD.
1387	REVISIONS			

NO.	UNIT TYPE	INSTL.	RET.	INSTL.	RET.
		PROPOSED		COMPLETED	

AS-BUILT DRAWING-PRESSURE TEST DATA

PIPE DIA.	TEST MEDIUM	TEST METHOD
PIPE LENGTH	<input type="checkbox"/> AIR	<input type="checkbox"/> GAUGE
PIPE TYPE	<input type="checkbox"/> NITROGEN	<input type="checkbox"/> CHART
MIN. DURATION	<input type="checkbox"/> WATER	<input type="checkbox"/> GAUGE PRESS REC SW
	<input type="checkbox"/> SOAP	

VISUAL INSPECTION CERTIFICATION

I HAVE VISUALLY INSPECTED ALL HEATED FUSIONS, SOLVENT CEMENT, MECHANICAL JOINTS, AND WELDS THAT I HAVE PERFORMED

NAME _____ DATE _____

AS-BUILTS ACCEPTED BY _____ DATE _____

POSTED BY _____ DATE _____

POSTING QCD BY _____ DATE _____

CONSTRUCTION

INSPECTOR _____

FOREMAN _____

REVIEWED BY _____

PERMIT INFORMATION

CITY OF LAS VEGAS

TAX CODE 02-0207 / 02-0200

ISOLATION AREA	W. R. NO.
DIST_019	1414593
LOCATION	TILE NO.
T20S, R60E, S24 T20S, R60E, S25 T20S, R61E, S19 M.D.M.	x606y522 x609y522

ENGINEER/TECHNICIAN	RYAN MORGAN	PHONE	365-2172
ACCOUNT REP.		PHONE	
PROJECT CONTACT	RYAN MORGAN	PHONE	365-2172
SHEET NO.	4 OF 9	SCALE	1"=30'
DWN. BY	ZE	CHKD. BY	DATE
TITLE		F-CLV-VEGAS DRIVE STORM DRAIN 4" DIST. STEEL REPLACEMENT	