


LOCATION MAP

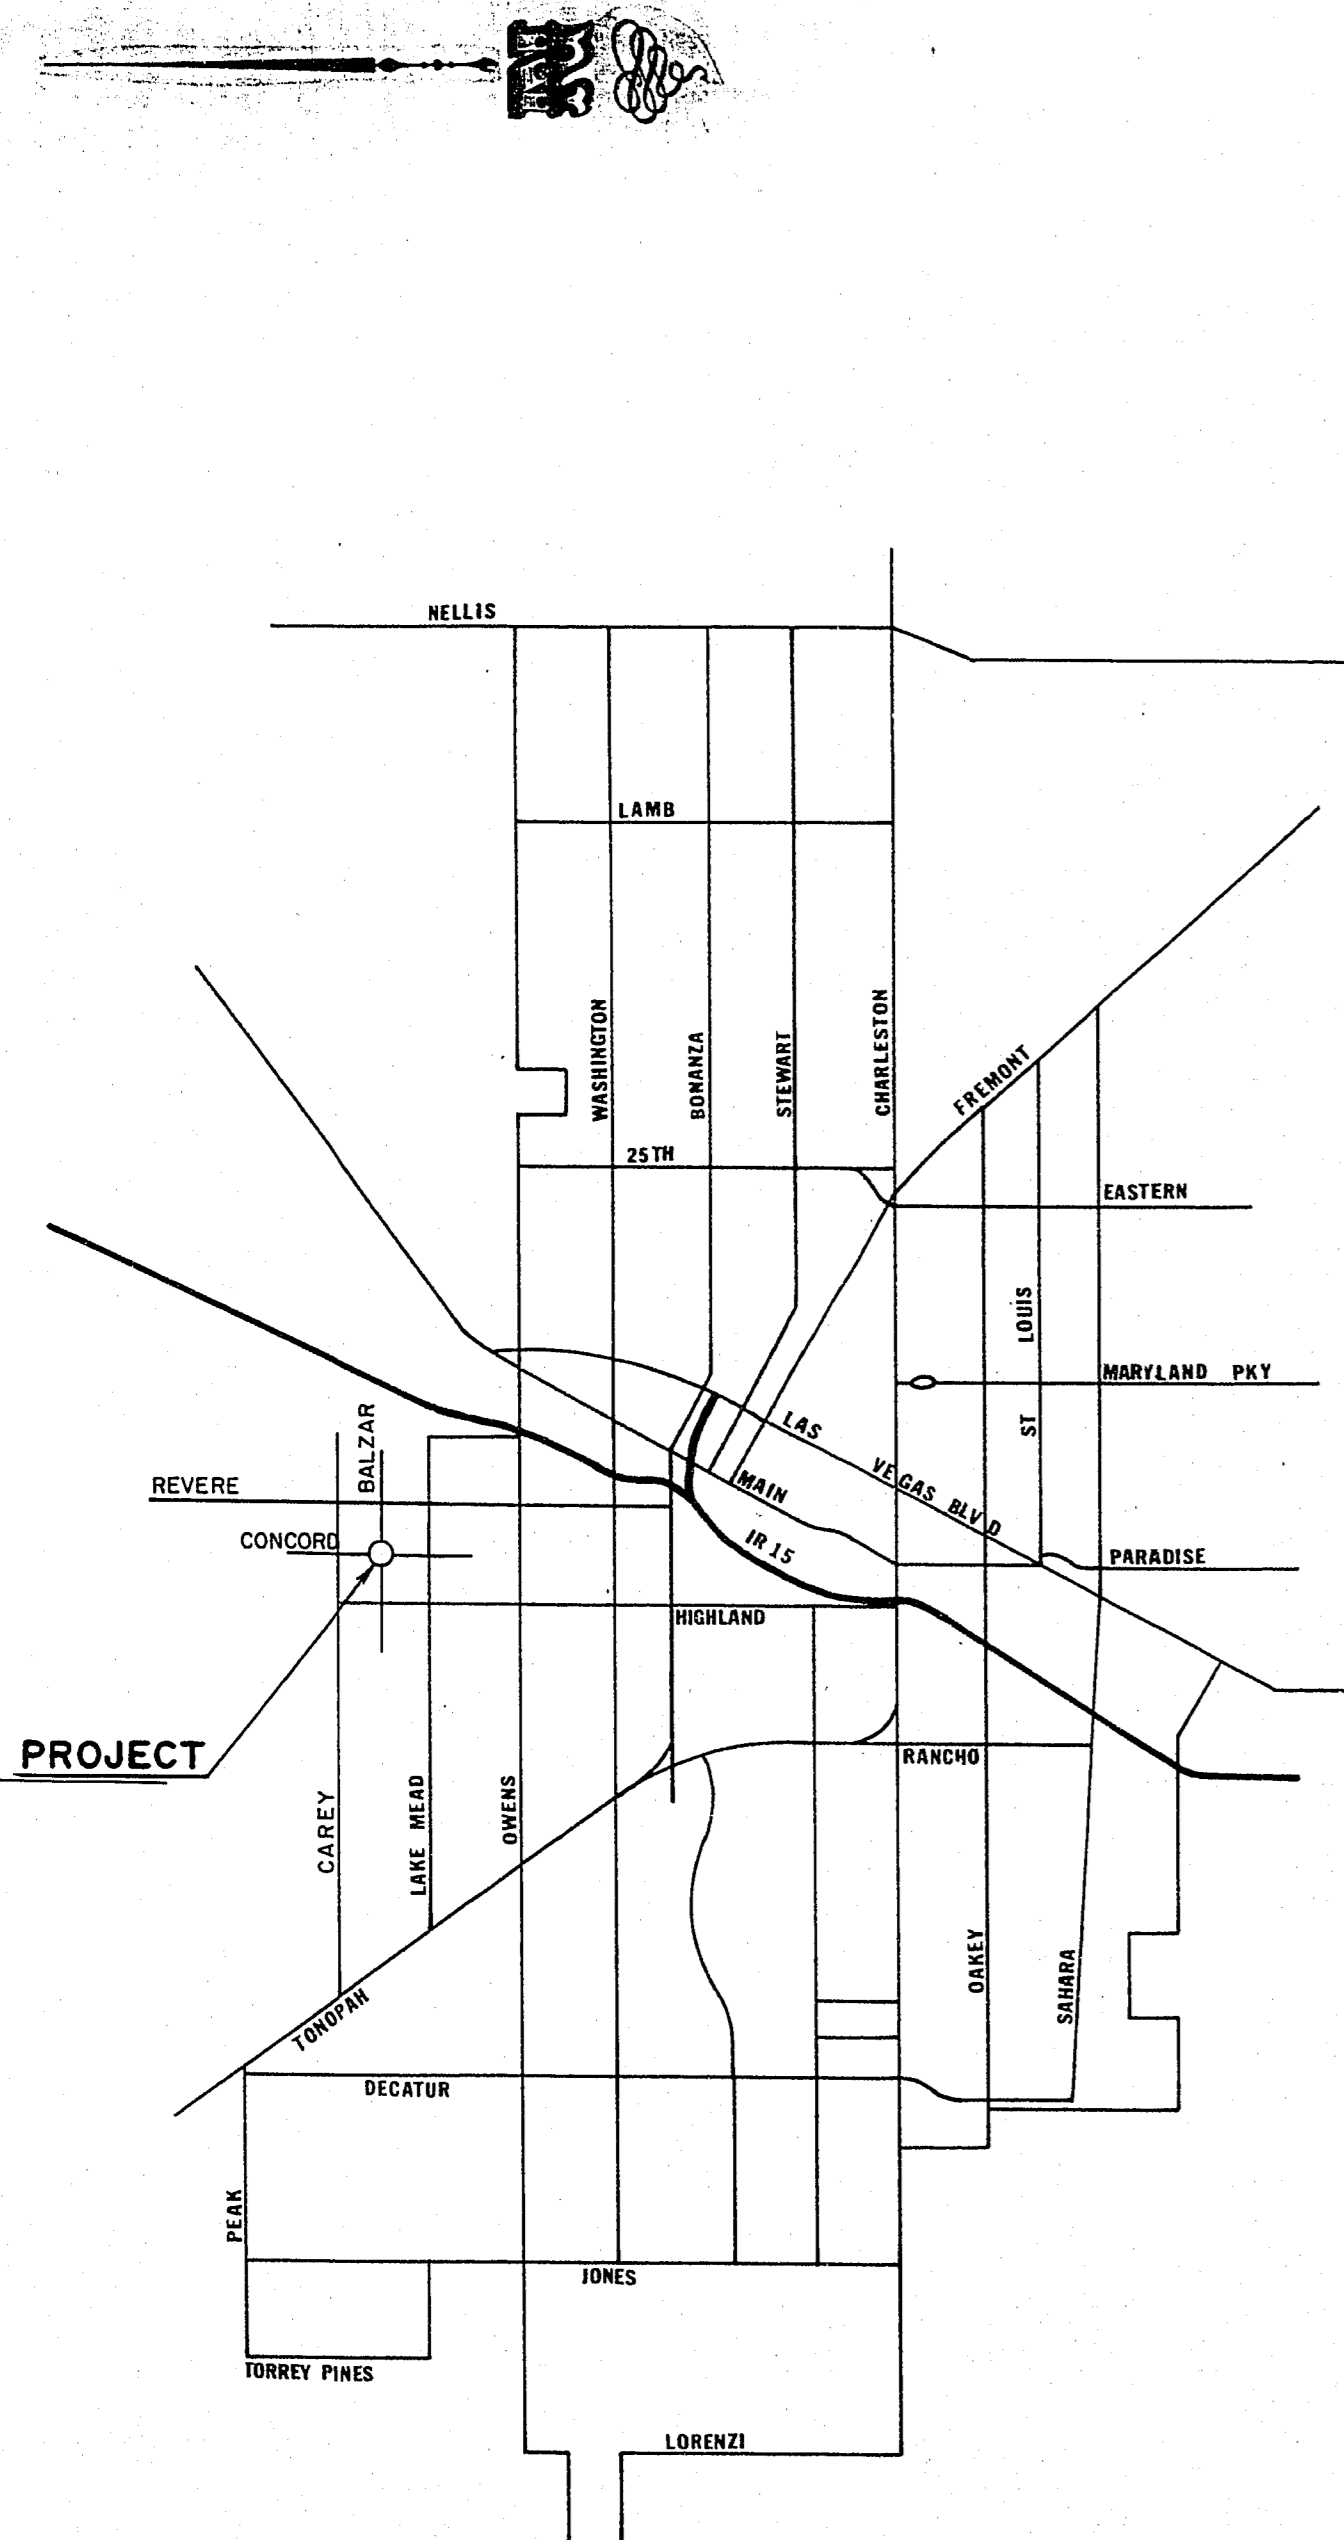

CITY OF LAS VEGAS  
CLARK COUNTY, NEVADA  
DEPARTMENT OF PUBLIC WORKS  
SERVICES DIVISION

**VEGAS HEIGHTS CIRCLE TOT LOT**

**HUD OSC 9**

BID No.-F-72.68

CONTRACT No.-CLV-F968



CONTRACT  
DRAWING  
AUG 18 1972

**MAYOR**  
ORAN K. GRAGSON

**COMMISSIONERS**  
HANK THORNLEY  
ALEXANDER COBLENTZ, M.D.  
GEORGE E. FRANKLIN JR.  
HAROLD F. MORELLI

**CITY MANAGER**  
A. R. TRELEASE

**DIRECTOR OF PUBLIC WORKS**  
RICHARD P. SAUER

INDEX OF SHEETS

15-13-39

No.	DESCRIPTION
1	TITLE SHEET, VICINITY MAP, AND INDEX
2	EXISTING SITE PLAN, TOTAL QUANTITIES OF PROJECT
3	BLOCK WALL AND FENCING PLAN
4	GRADING AND PAVING PLAN
5	IRRIGATION SYSTEM, PLANTING PLAN, AND DETAILS

AGENCY	NO SERVICE IN PROJECT	PLANS REVIEWED BY	DATE	DEPT. OF PUBLIC WORKS	APPROVED	DATE	REVISIONS				TITLE	APPROVED	DATE	
							No.	DESCRIPTION	BY	Date				APPROVAL
Central Telephone Co.	N/A			Design Sect. Chief	<i>[Signature]</i>	09/04/72								
L.V.V. Water District		<i>M. Wall</i>	8/10/72	Traffic Engr.	N/A									
Southwest Gas Co.		<i>R. H. Townsend</i>	8-9-72	Const. Div. Engr.	<i>[Signature]</i>	8-10-72								
Nevada Power Co.	N/A			Design Div. Engr.	<i>[Signature]</i>	8/9/72								
Supt. of Sanitation	N/A			Dep. Dir. of Publ. Works	<i>[Signature]</i>	8/10/72								
C.L.V. Electrician		<i>George Davis</i>	8-10-72	Dir. of Public Works	<i>[Signature]</i>	8/11/72								
C.L.V. Fire Chief	N/A			City Manager										

These plans were approved and adopted by the Board of City Commissioners of Las Vegas, Nevada, at its meeting held

Oran K. Gragson, Mayor

Edwina M. Cole, City Clerk

DATE - 8-11-72

DRAWING NUMBER

**650.23-1**

SHEET 1 OF 5