
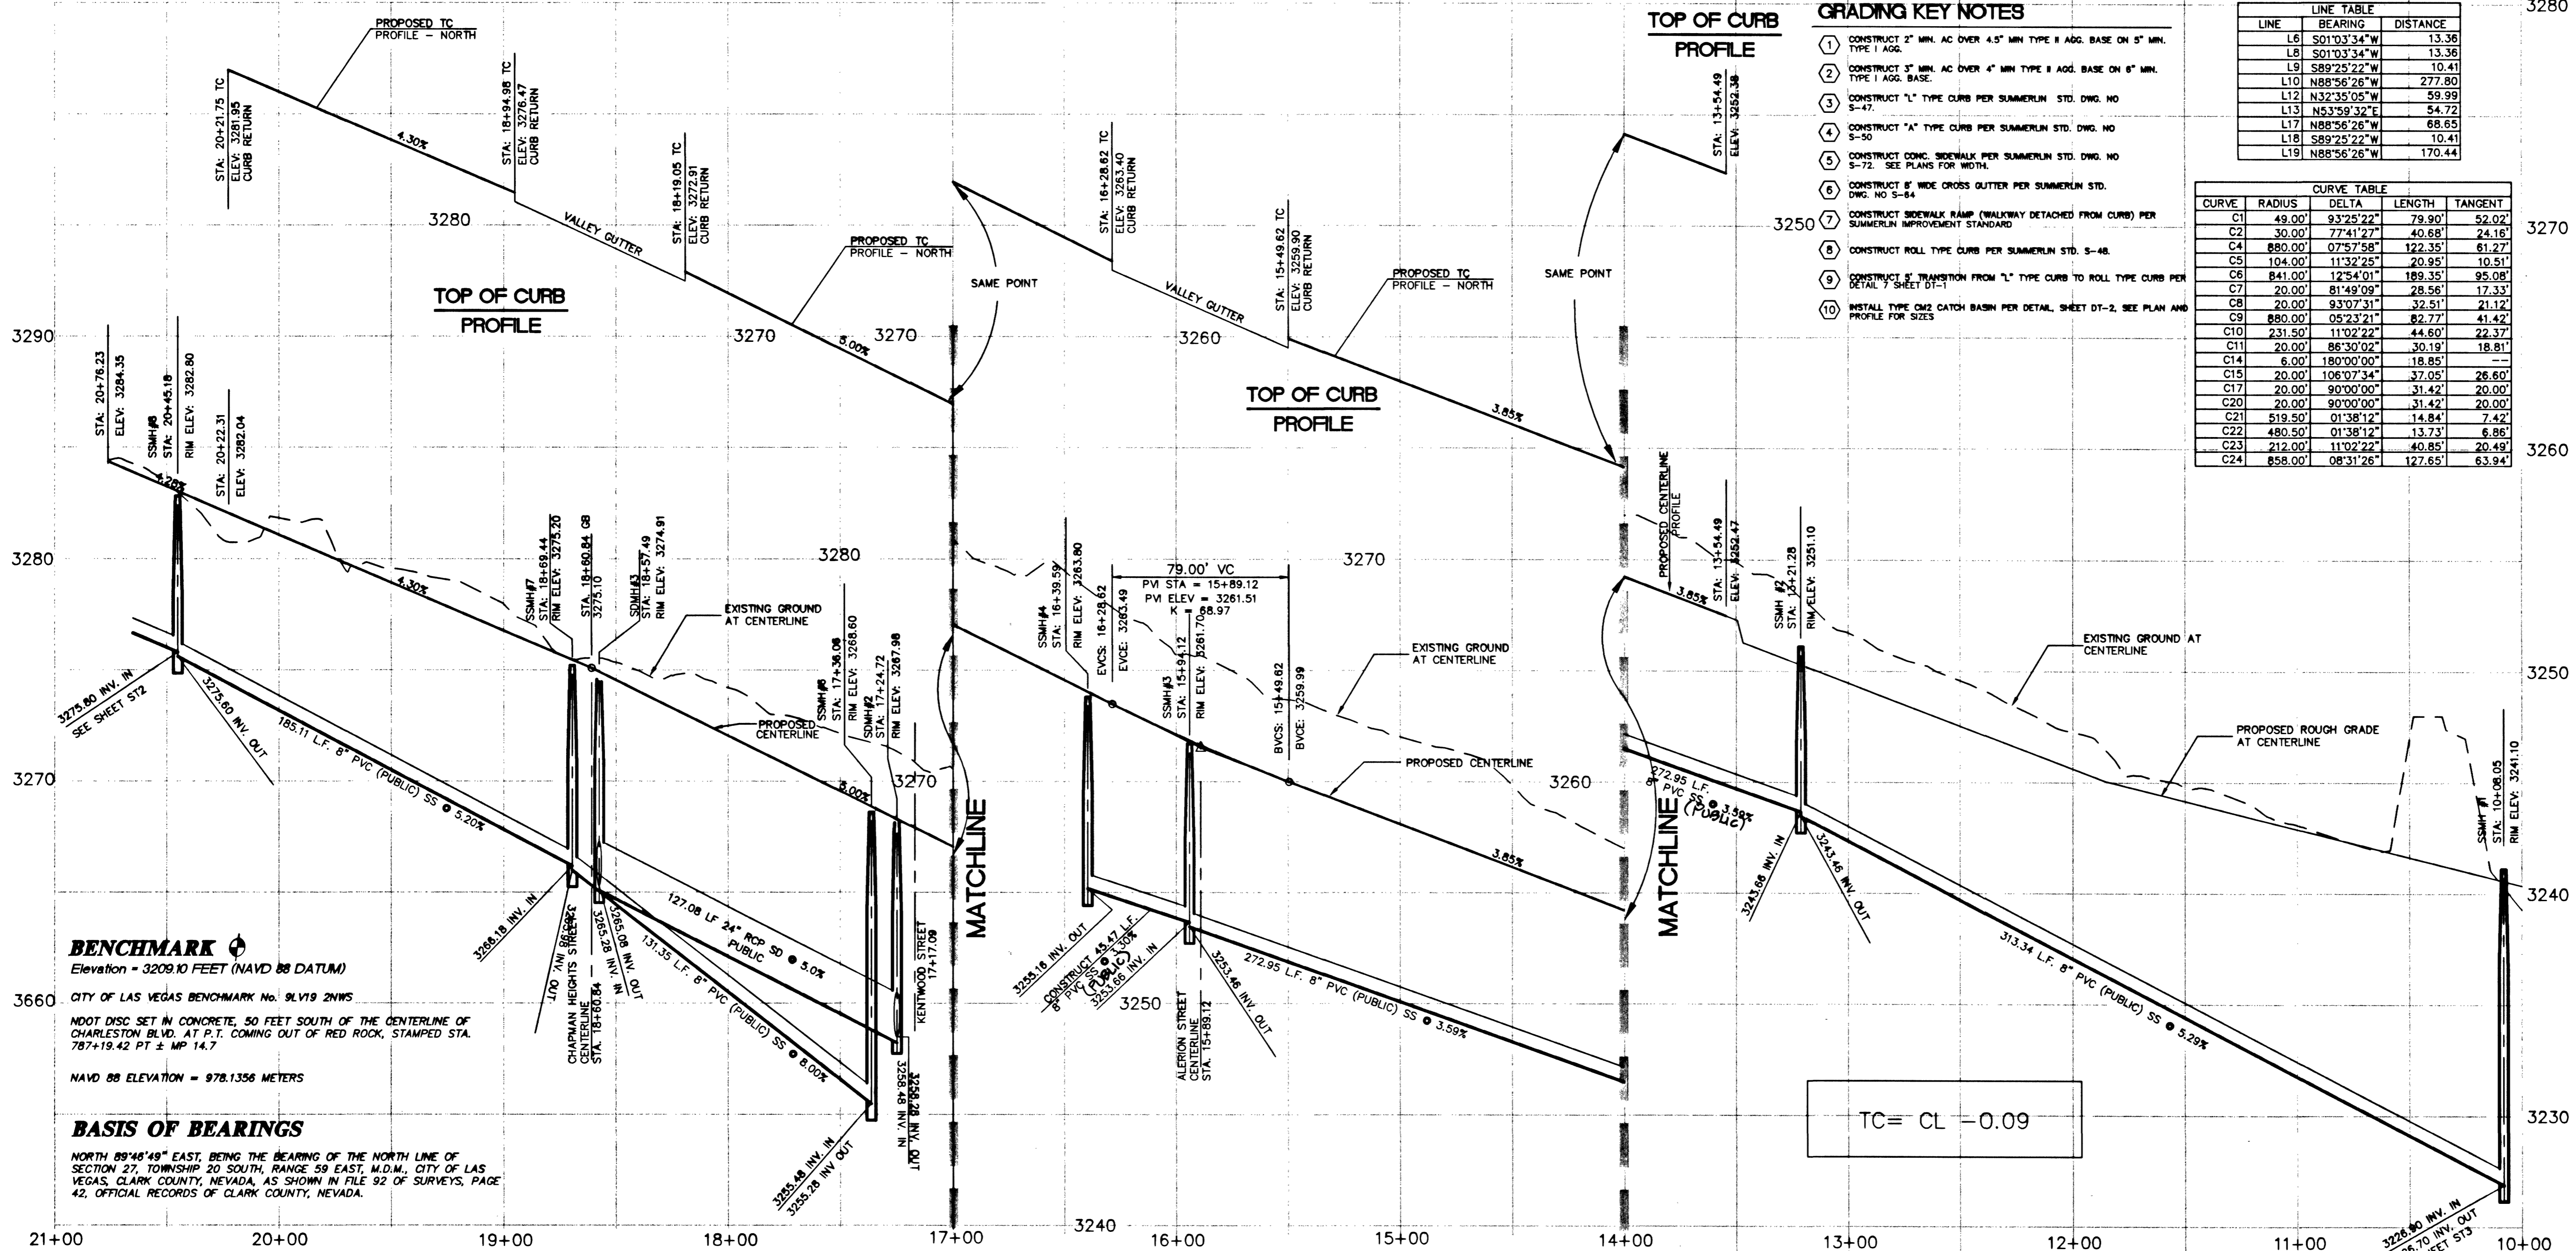


Call before you Dig  
1-800-227-2600  
Call before you Overhead  
1-702-593-6111

**CONTRACTORS NOTE**  
CONTRACTOR SHALL IMMEDIATELY NOTIFY ENGINEER OF ANY DISCREPANCY BETWEEN INFORMATION ON PLANS AND EXISTING SITE CONDITIONS.

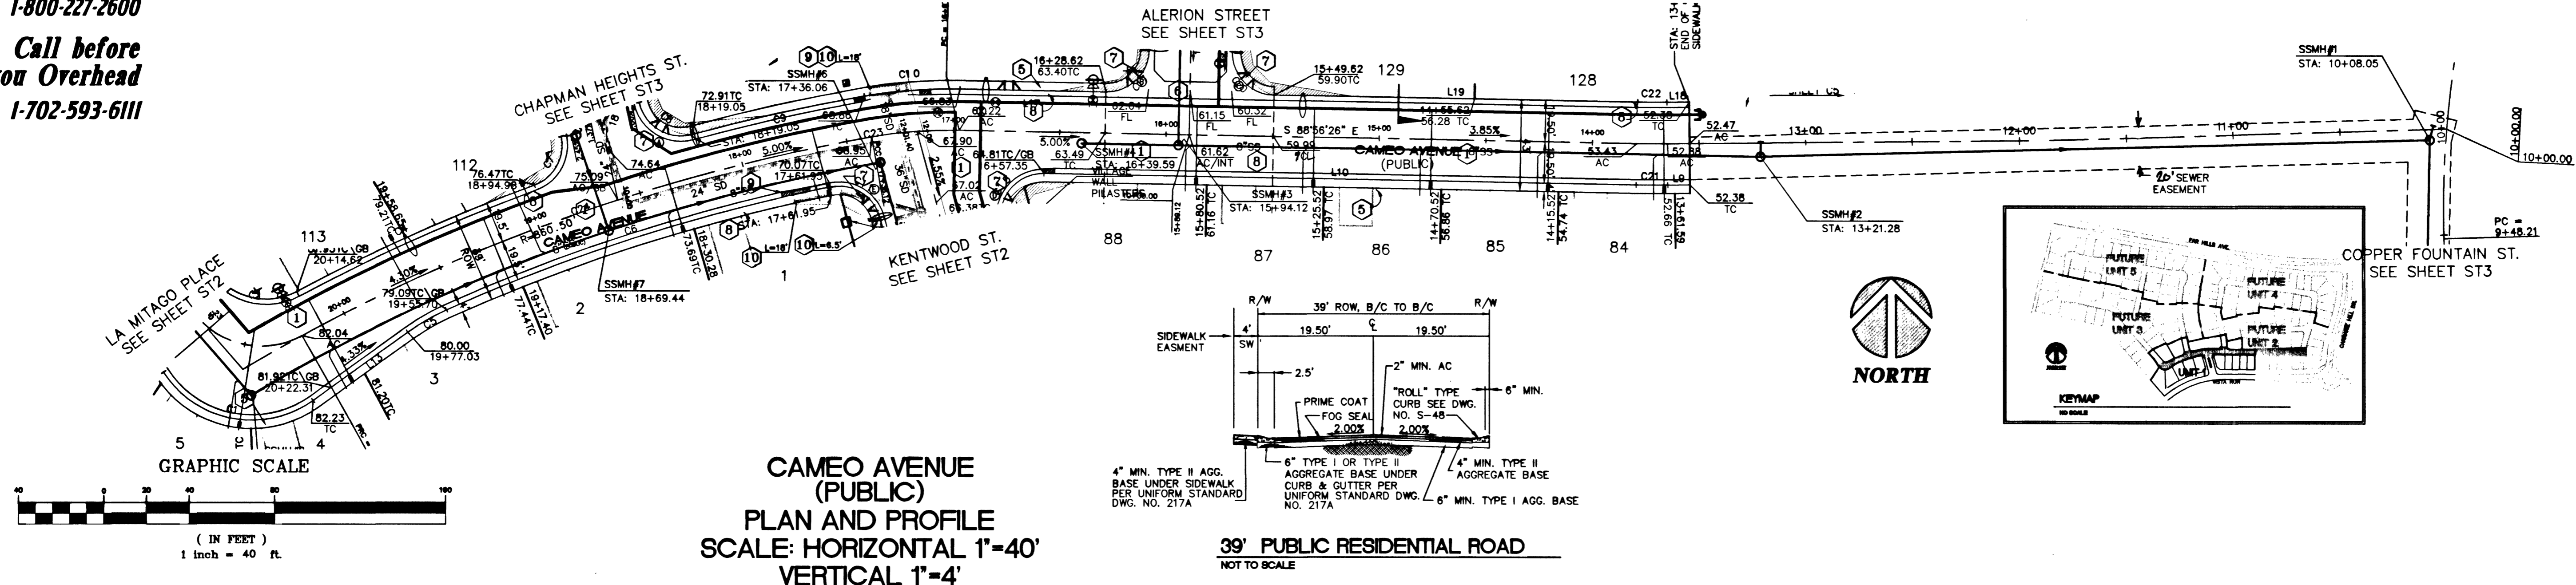

DESIGNED BY: [ ]  
DRAWN BY: [ ]  
CHECKED BY: [ ]  
PROJECT DATE: [ ]

DEVELOPER  
SUMNERLIN, VILLAGE 20  
CITY OF LAS VEGAS, NEVADA

**CAMEO AVENUE STREET AND SEWER PLAN AND PROFILE UNIT 1**

6280 S. Valley View Blvd Suite 200  
Las Vegas, NV 89118  
Tel: (702) 368-3008  
Fax: (702) 368-0047

**CONSULTANTS, INC.**  
ENGINEERING · PLANNING · LAND SURVEYING

SHEET  
ST1  
11 OF 16

AGENCY DWG. NO.  
3071-4705

019056

CVL Proj. No. 019056