


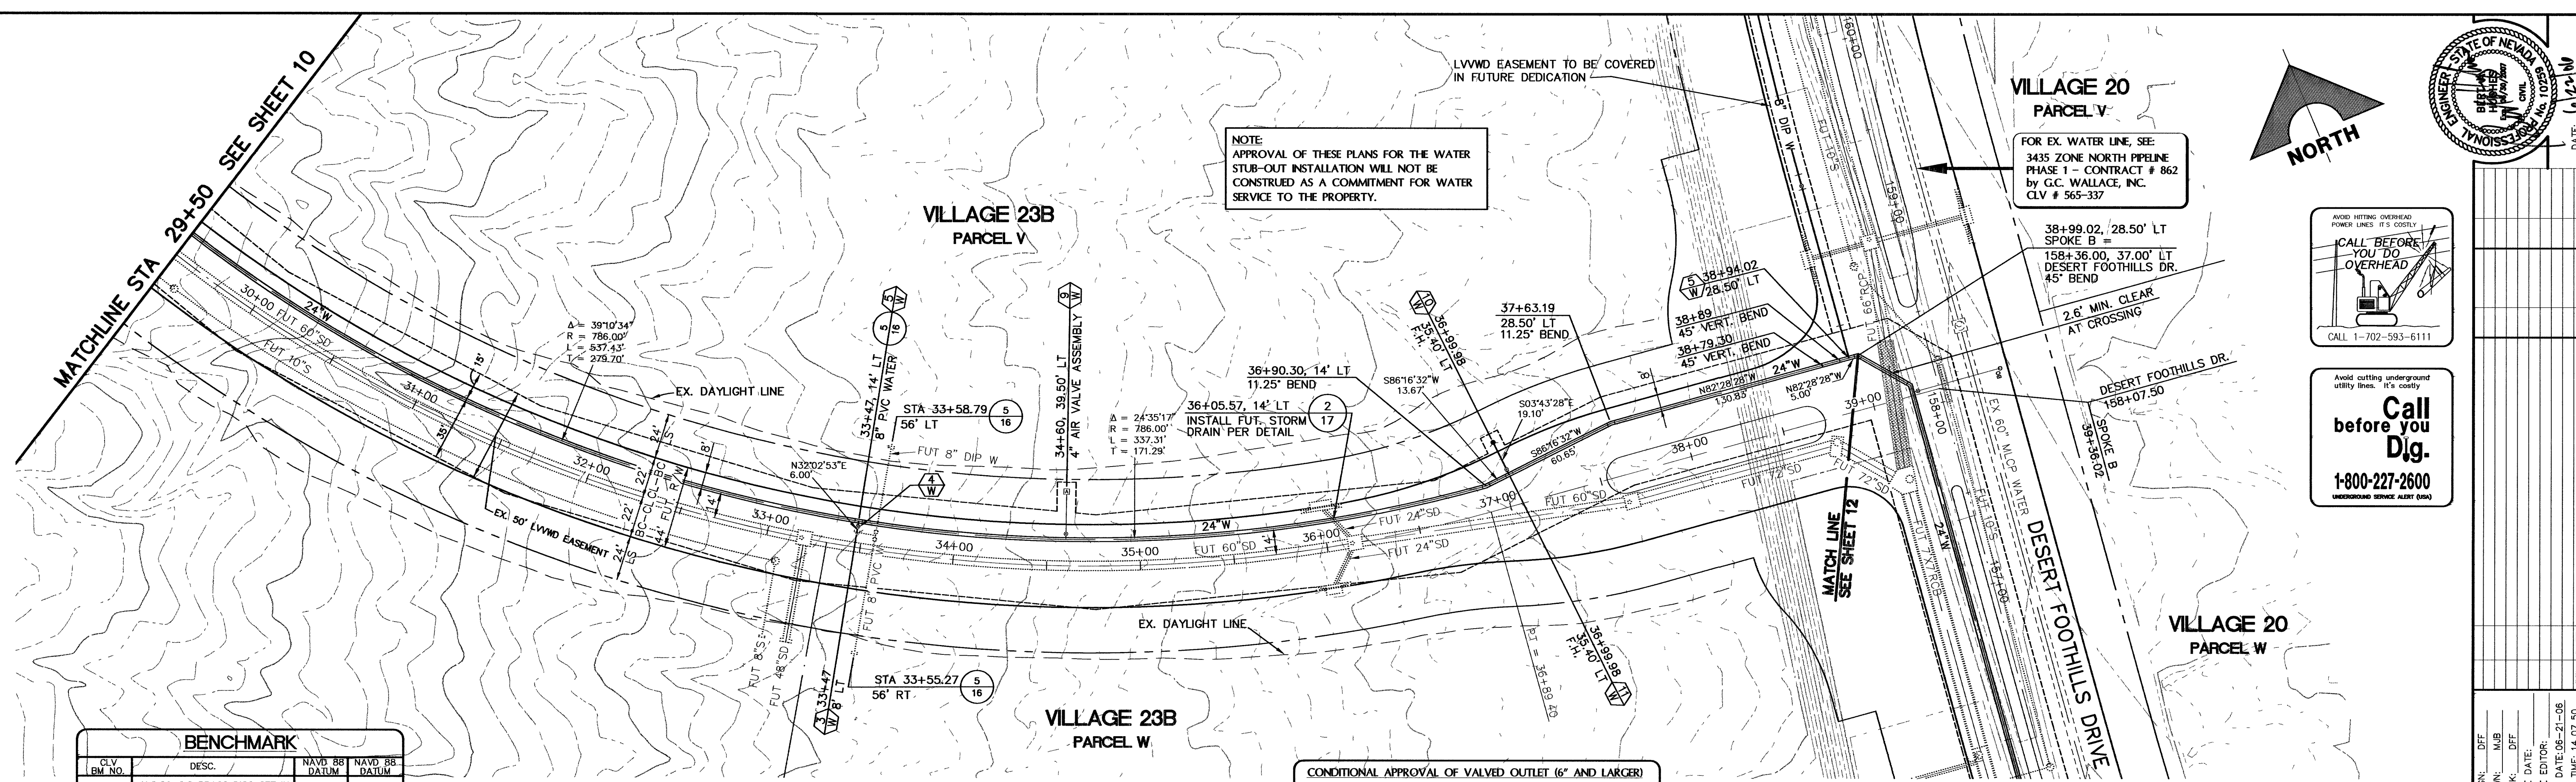


BENCHMARK			
CLV	DESC.	NAVD 88 DATUM	NAVD 88 DATUM
D368 3	U.S.C. & G.S. BRASS DISC SET IN ROCK ON THE EAST SIDE OF CHARLESTON BOULEVARD AND SOUTH OF THE RED ROCK DETENTION BASIN.	3246.71 (FEET)	989.599 (METERS)

BASIS OF BEARINGS
NORTH 89°45'05" EAST BEING THE SOUTH LINE OF THE SOUTHWEST QUARTER (SW 1/4) OF SECTION 35, TOWNSHIP 20 SOUTH, RANGE 59 EAST, M.D.M., AS SHOWN BY MAP ON FILE IN FILE 91, PAGE 28 OF PARCEL MAPS IN THE CLARK COUNTY RECORDER'S OFFICE, CLARK COUNTY, NEVADA

THIS PROPERTY MAY HAVE STATIC WATER PRESSURE IN EXCESS OF 80 PSL. THE UNIFORM PLUMBING CODE REQUIRES THAT INDIVIDUAL, ON-SITE (PRIVATE), PRESSURE-REDUCING VALVES BE INSTALLED WHENEVER THE PRESSURE EXCEEDS 80 PSL. PRVs ARE THE DEVELOPER'S RESPONSIBILITY, AND WILL NOT BE INSPECTED OR INCLUDED IN THE ACCEPTANCE OF LVVWD FACILITIES. ESN041


SPOKE B (PUBLIC)

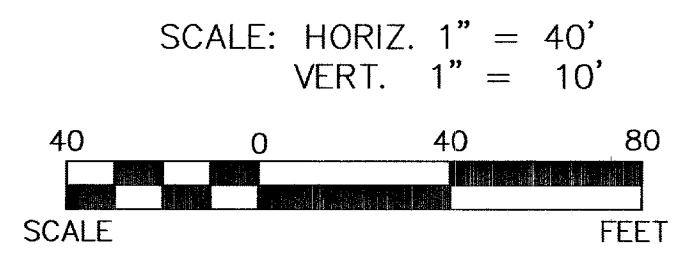

CONDITIONAL APPROVAL OF VALVED OUTLET (6" AND LARGER)
THE WATER PLANS SHOW ONE OR MORE VALVED OUTLETS EXTENDING OUT OF PAVED AREAS. INSTALLATION OF THESE OUTLETS IS ACCEPTABLE; HOWEVER, IF THE OUTLETS ARE INCORRECTLY LOCATED OR NOT USED FOR ANY REASON WHEN THE PROPERTY IS ACTUALLY DEVELOPED, THE DEVELOPER SHALL ABANDON THE OUTLETS AT THE CONNECTION TO THE ACTIVE MAIN IN ACCORDANCE WITH THE DISTRICT'S STANDARDS, AND AT THE DEVELOPER'S EXPENSE. APPROVAL OF THE VALVED OUTLET DOES NOT PROVIDE OR IMPLY A WATER COMMITMENT. ESN037

NOTE
THIS SET OF DRAWINGS IS BASED UPON NAVD 88 DATUM. PREVIOUS DRAWINGS MAY BE BASED ON OTHER DATUM. CARE SHOULD BE OBSERVED WHEN UTILIZING THIS SET OF DRAWINGS.

APPROVAL:
LAS VEGAS VALLEY WATER DISTRICT
DATE: 6/24/06
LVVWD NO. 112538

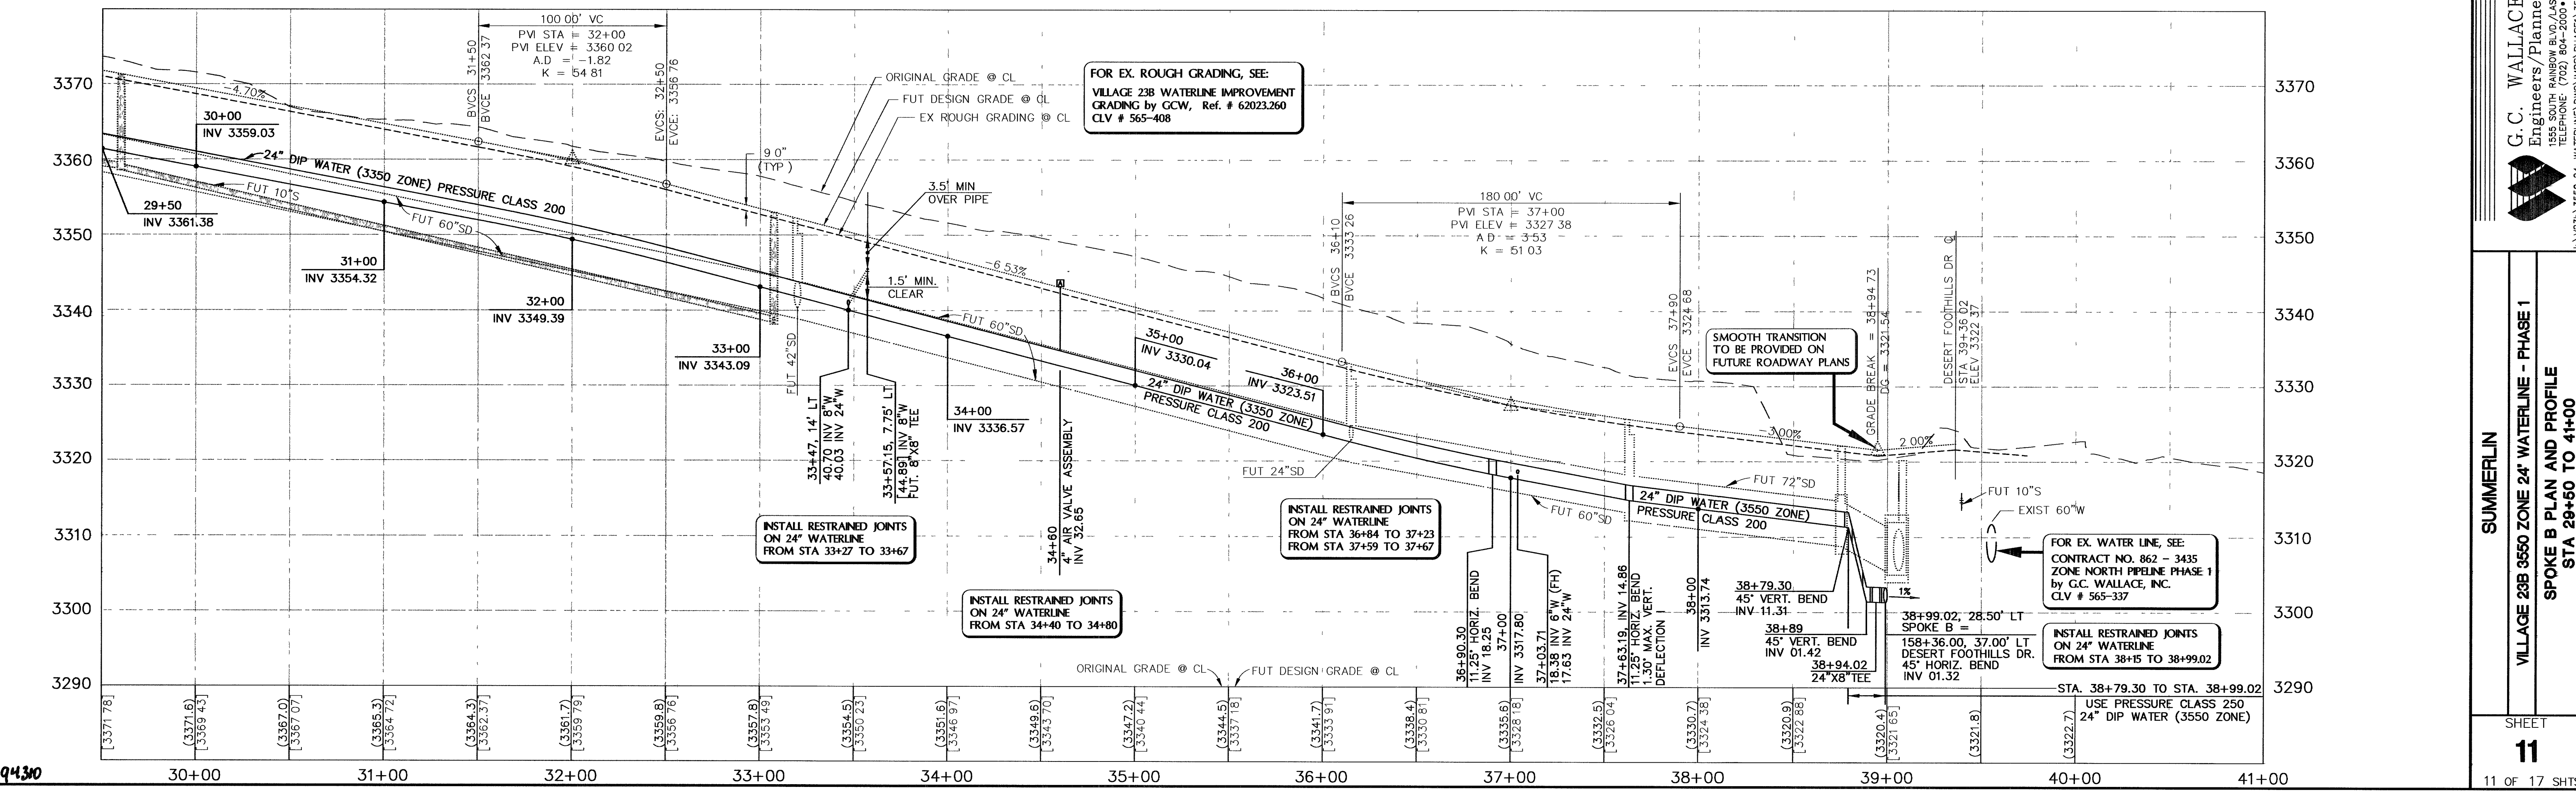

DATE: 6/22/06

CALL BEFORE YOU DIG OVERHEAD
CALL 1-702-593-6111

Call before you Dig.
1-800-227-2600
UNDERGROUND SERVICE ALERT (USA)

DESIGN:	DFP
DRAWN:	MJB
CHECK:	DFP
ISSUE DATE:	
ISSUE EDITOR:	
PLOT DATE:	06-21-06
PLOT TIME:	14:07:50
DESCRIPTION:	

G.C. WALLACE, INC.
Engineers/Planners/Surveyors
1555 SOUTH RAINBOW BLVD., LAS VEGAS, NEVADA 89146
TELEPHONE: (702) 804-2000 • FAX: (702) 804-2299
E-MAIL: WALLACE@GCI-WALLACE.COM

SUMMERLIN
VILLAGE 23B 3550 ZONE 24" WATERLINE - PHASE 1
SPOKE B PLAN AND PROFILE
STA 29+50 TO 41+00

SHEET
11
11 OF 17 SHTS

JOB NO. 62A.W04216