


SUMMERLIN

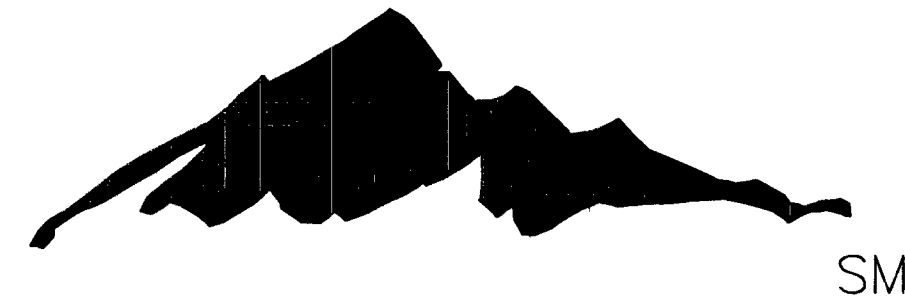


VILLAGE 23B PARCEL R-S

STORM DRAIN AND SANITARY SEWER OUTFALL IMPROVEMENTS

2013


A.P.N. 137-27-713-001
NON-SID PROJECT

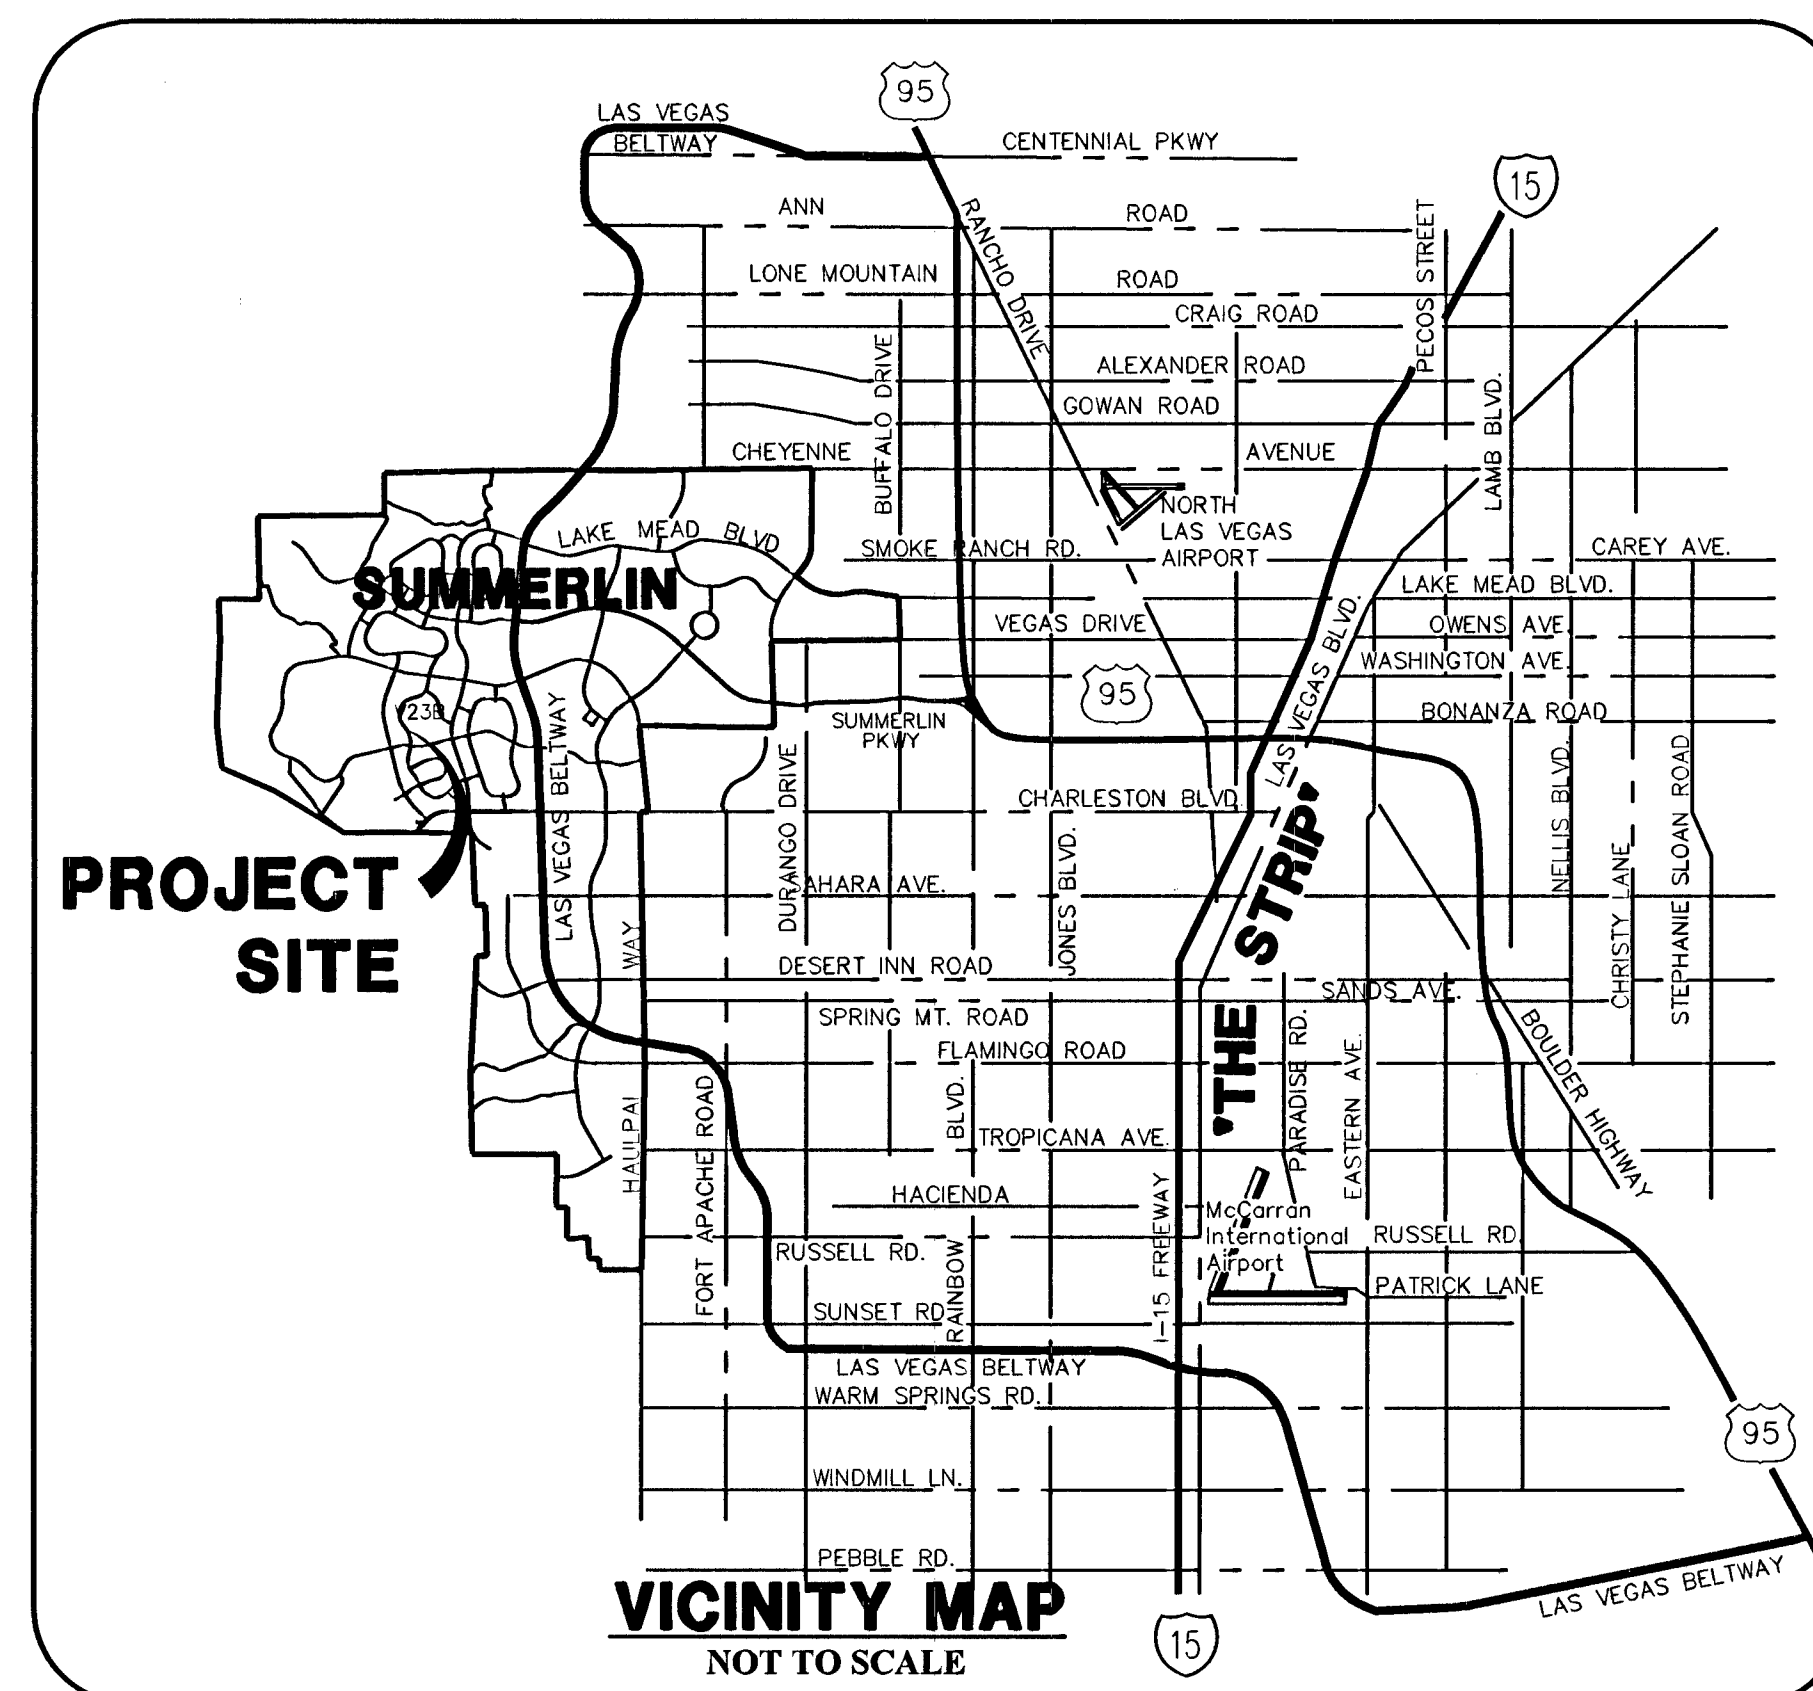

OWNER/DEVELOPER

THE HOWARD HUGHES COMPANY, LLC
10801 W. CHARLESTON BLVD., 3RD FLOOR
LAS VEGAS, NEVADA 89146
OFFICE PHONE NO. (702) 791-4300
OFFICE FAX NO. (702) 791-4450

ENGINEER

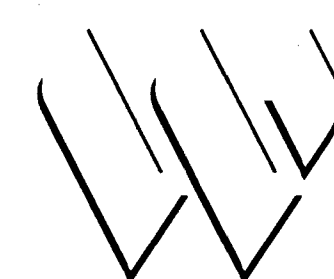

G.C. WALLACE COMPANIES
ENGINEERS | PLANNERS | SURVEYORS
1555 S. RAINBOW BLVD • LAS VEGAS, NV 89146
T: 702.804.2000 • F: 702.804.2299 • GCWALLACE.COM

DRAWING INDEX

NO.	DWG	DESCRIPTION
1	C1	COVER SHEET
2	C2	PROJECT DATA SHEET
3	C3	GENERAL NOTES
4	MU1	STORM DRAIN MASTER PLAN
5	MU2	SANITARY SEWER MASTER PLAN
6	P1	UTILITY PLAN AND PROFILE FROM STA 0+50 TO STA 7+50
7	P2	UTILITY PLAN AND PROFILE FROM STA 7+50 TO STA 11+50
8	P3	UTILITY PLAN AND PROFILE FROM STA 11+50 TO END

APPROVED FOR CONSTRUCTION

David Bowers
LAS VEGAS VALLEY WATER DISTRICT ENGINEERING SERVICES MANAGER
PROJECT NO. 122199 DATE: 10/11/13
SHEETS: C1-C3, MU1, MU2, & P2

THE HOWARD HUGHES COMPANY, LLC

Kevin Orrock
KEVIN ORROCK
TITLE: VICE PRESIDENT
DATE: 10/9/13

DRAINAGE CERTIFICATION

I CERTIFY THAT THE GRADING PLANS ARE IN CONFORMANCE WITH THE APPROVED DRAINAGE STUDY ON FILE AT THE CITY OF LAS VEGAS FOR THIS PROJECT.

Joshua Johnson
JOSHUA JOHNSON P.E. 15789
DATE: 10/11/13

David Bowers
DAVID BOWERS, PE, PTOE, PE# 16736
CITY ENGINEER
CITY OF LAS VEGAS, NEVADA
DATE: 10/24/13


APPROVAL OF THESE PLANS IS LIMITED TO THOSE IMPROVEMENTS CONSTRUCTED IN THE DEDICATED RIGHTS-OF-WAY AND/OR DEDICATED EASEMENTS. THIS APPROVAL DOES NOT AUTHORIZE THE CONSTRUCTION OF ANY IMPROVEMENTS THAT DEVIATE FROM ADOPTED STANDARDS AND/OR SPECIFICATIONS, EXCEPT THOSE SPECIFICALLY LISTED UNDER "DEVIATIONS FROM STANDARDS". THE ENGINEER SHALL RESOLVE ANY DEVIATION OTHER THAN THOSE LISTED IN "DEVIATIONS FROM STANDARDS" IN FAVOR OF THE UNIFORM STANDARD DRAWINGS AND SPECIFICATIONS CLARK COUNTY AREA NEVADA.

CLV PLANNING DEPARTMENT

THIS PLAN MEETS THE APPLICABLE STANDARDS OF THE CITY OF LAS VEGAS PLANNING DEPARTMENT

Chris Knight
CHRIS KNIGHT, DIRECTOR BUILDING AND SAFETY
DATE: 10/25/13


H# 51345 CLV DRAWING NO. 1071 6127

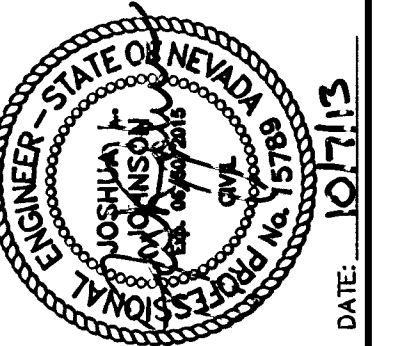

PROJECT NO.	DATE	REV	DATE	DESCRIPTION
62023B-215	10-04-13			
DESIGN: HN				
DRAWN: HN				
CHECK: DY				
PLOT DATE: 10-04-13				
PLOT TIME: 15:07:07				

PROJECT NO. 62023B-215
DESIGN: HN
DRAWN: HN
CHECK: DY
PLOT DATE: 10-04-13
PLOT TIME: 15:07:07

G.C. WALLACE COMPANIES
ENGINEERS | PLANNERS | SURVEYORS
1555 S. RAINBOW BLVD • LAS VEGAS, NV 89146
T: 702.804.2000 • F: 702.804.2299 • GCWALLACE.COM

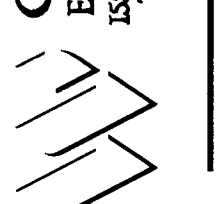

LAS VEGAS, NEVADA

F:\Projects\62023B-215\DWG\Production\215-01-C1.dwg

Humberto Franco-Rivas

SUMMERLIN

VILLAGE 23B PARCEL R-S
STORM DRAIN AND SANITARY SEWER OUTFALL IMPROVEMENTS

COVER SHEET

DRAWING

C1

1 OF 8 SHTS