

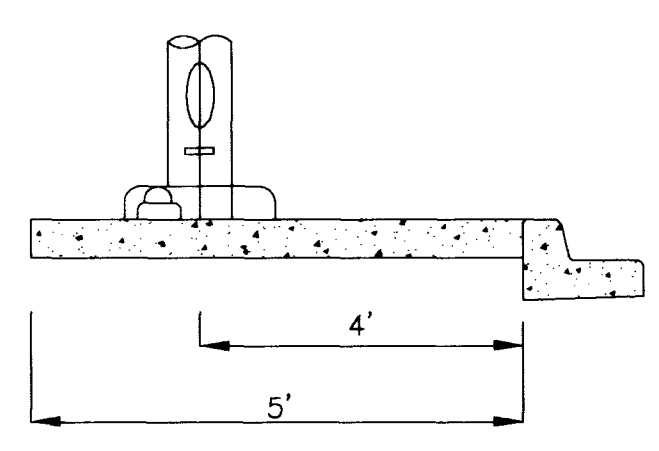
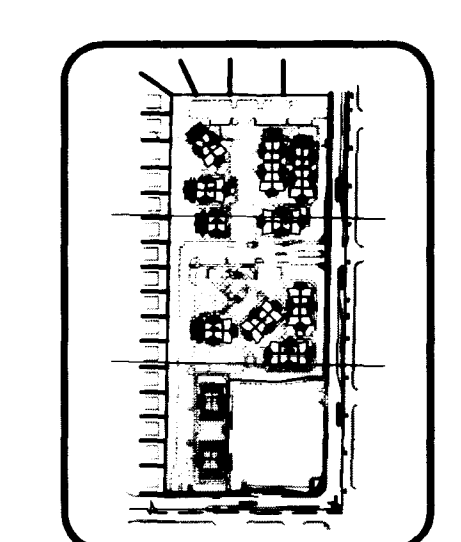


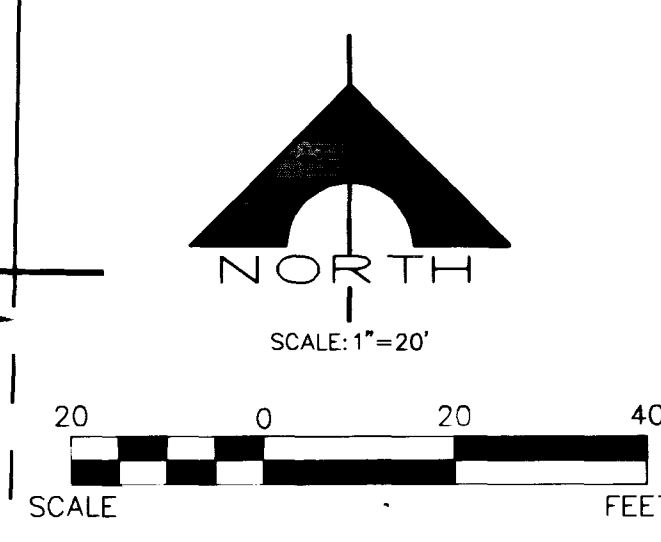

STREET LIGHT NOTE:
ALL HAND HOLE COVERS MUST BE INSTALLED, POLE CAPS POURED, & PULL BOX LIDS BOLTED DOWN PRIOR TO ENERGIZING CIRCUIT. ALL WIRE MUST HAVE THW INSULATION.

STREET LIGHT LOCATION
NOTE:
REPU LL STREET LIGHT WIRE FROM EXISTING STREET AT STA 14+51.57 TO RELOCATED STREET LIGHT AT STA 16+22.19 TO ENSURE CONTINUOUS CIRCUIT.
NOTE:
FOR INTERCONNECT NOTES SEE UTILITY SHEETS

Avoid cutting underground utility lines. It's costly.
Call before you dig.
1-800-227-2600
UNDERGROUND SERVICE (USA)

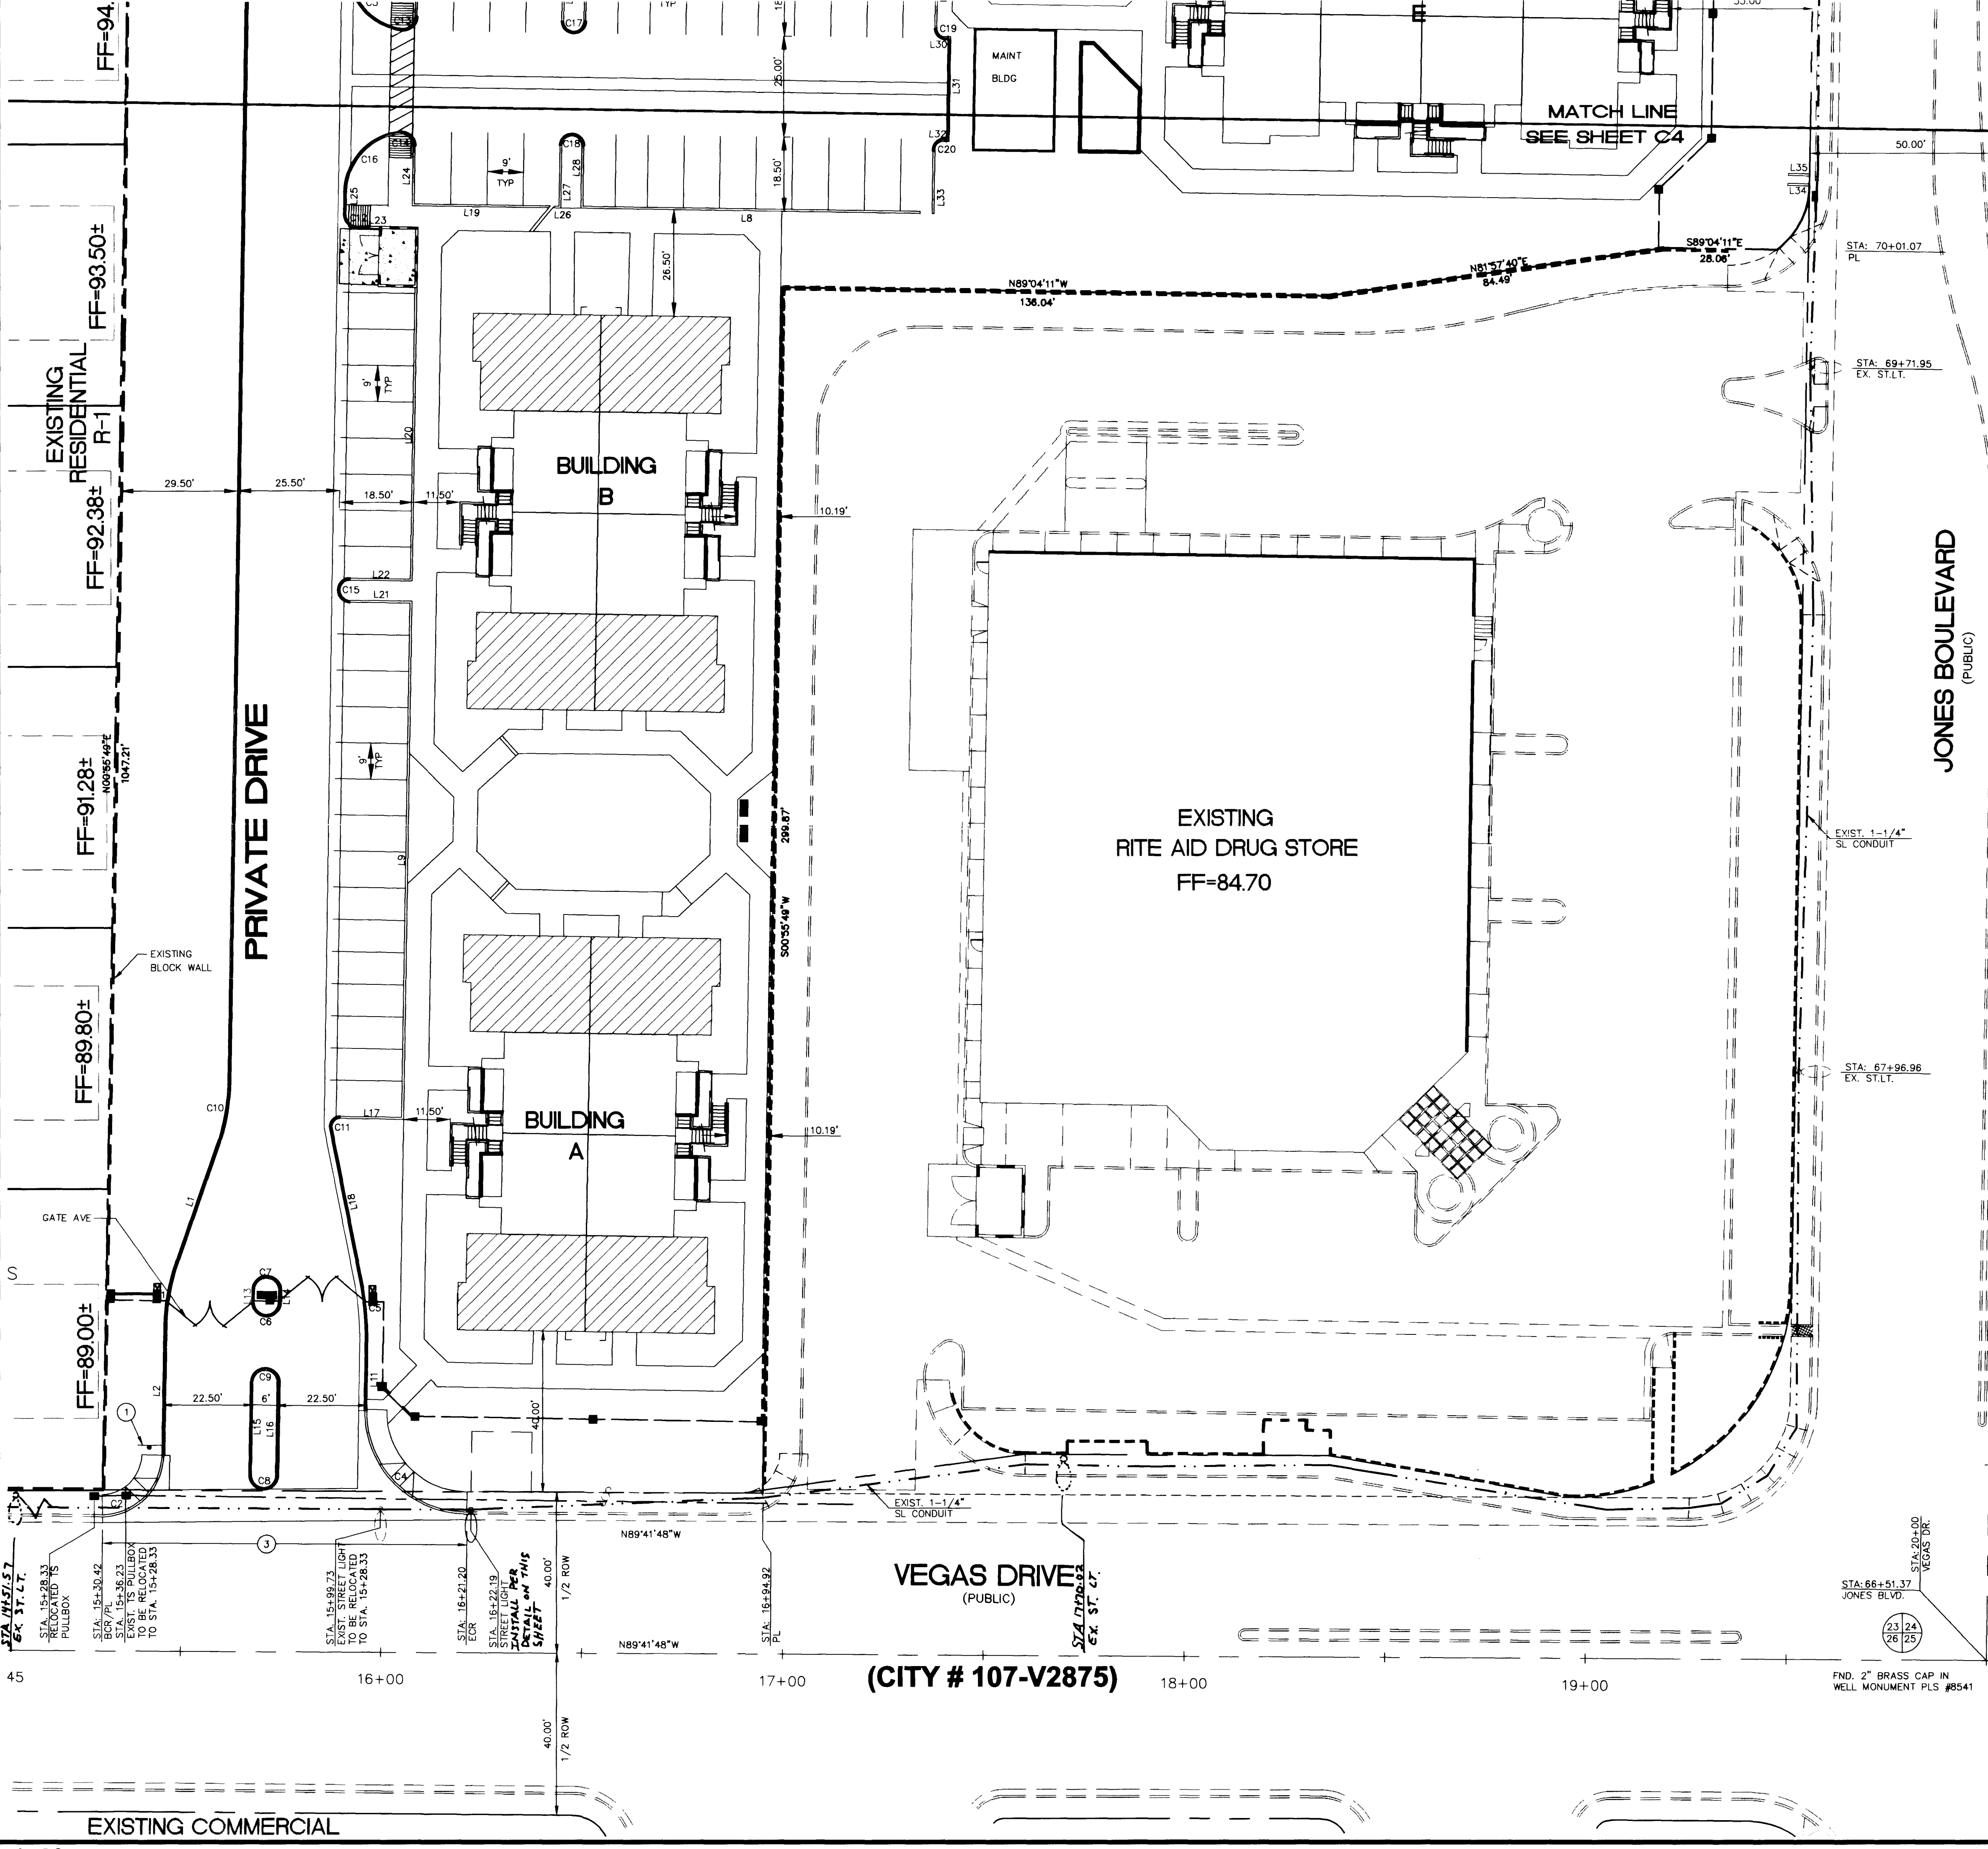

VINTAGE DESERT ROSE SENIORS APARTMENTS, LP
2440 PROFESSIONAL DRIVE, SUITE 100
ROSEVILLE, CA. 95661
PHONE: (916) 773-6060
FAX: (916) 773-5866

THE CW GROUP
CIVIL ENGINEERS
2680 Chandler Ave. Suite 5
Las Vegas, Nevada 89120
Ph: (702) 798-8645
FAX: (702) 798-8656

VINTAGE DESERT ROSE SENIOR APARTMENTS
STREET LIGHT PLAN
TRAFFIC / SITE PLAN 3

ENGINEER
WATKINS
22.04.00
CIVIL

SHEET C5
5 OF 15 SHEETS
DRAWING NO.
107-V 3195

SCALE: 1"=20'
DRAWN BY: THC
DESIGNED BY: WLW
CHECKED BY: WLW
SUBMITTAL DATE: 02-03-2000
REVISION APPROVAL BLOCK

REV. # BY DATE DESCRIPTION